
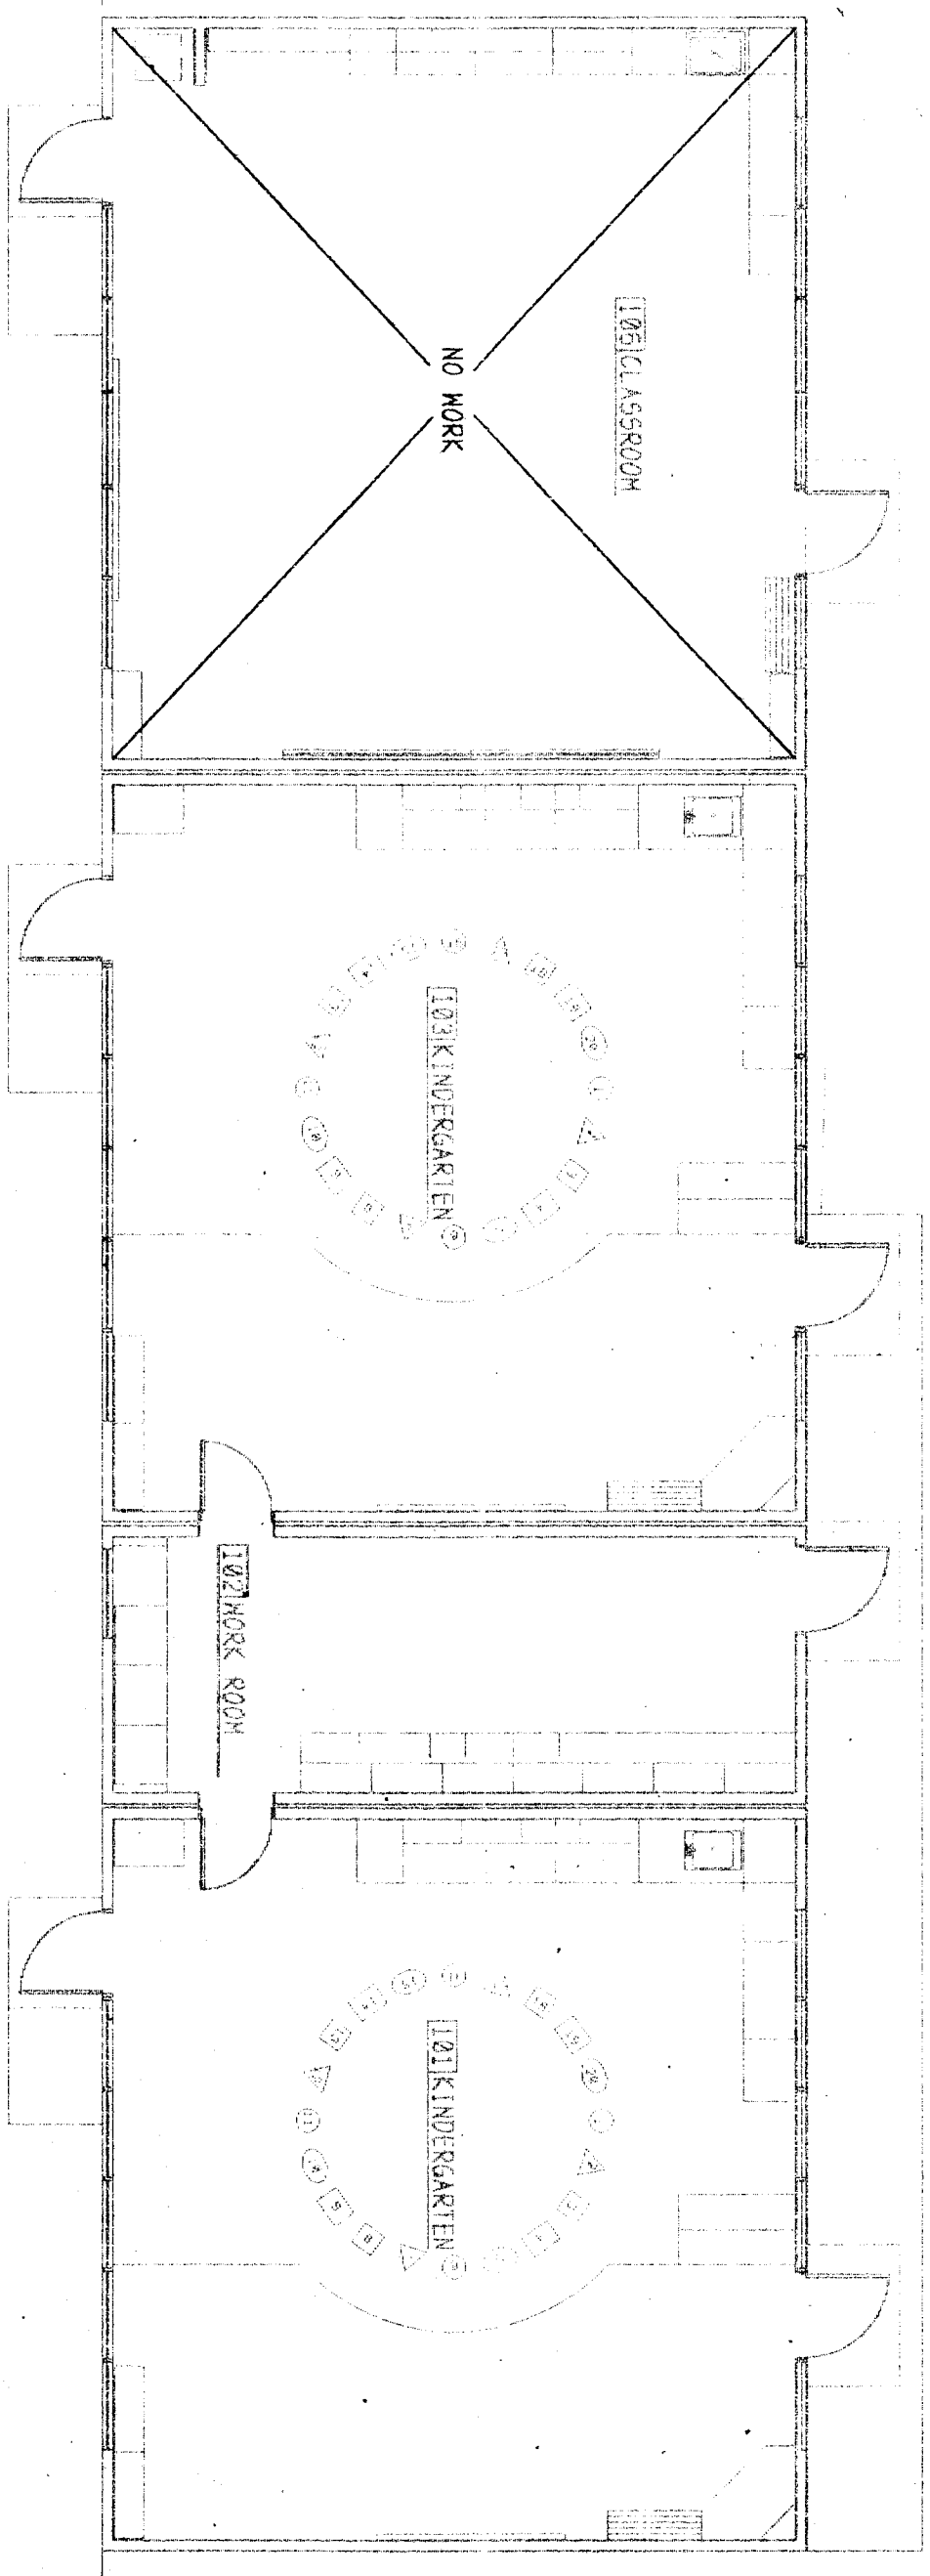



BUILDINGS 100 & 400 - FIRE ALARM PLANS

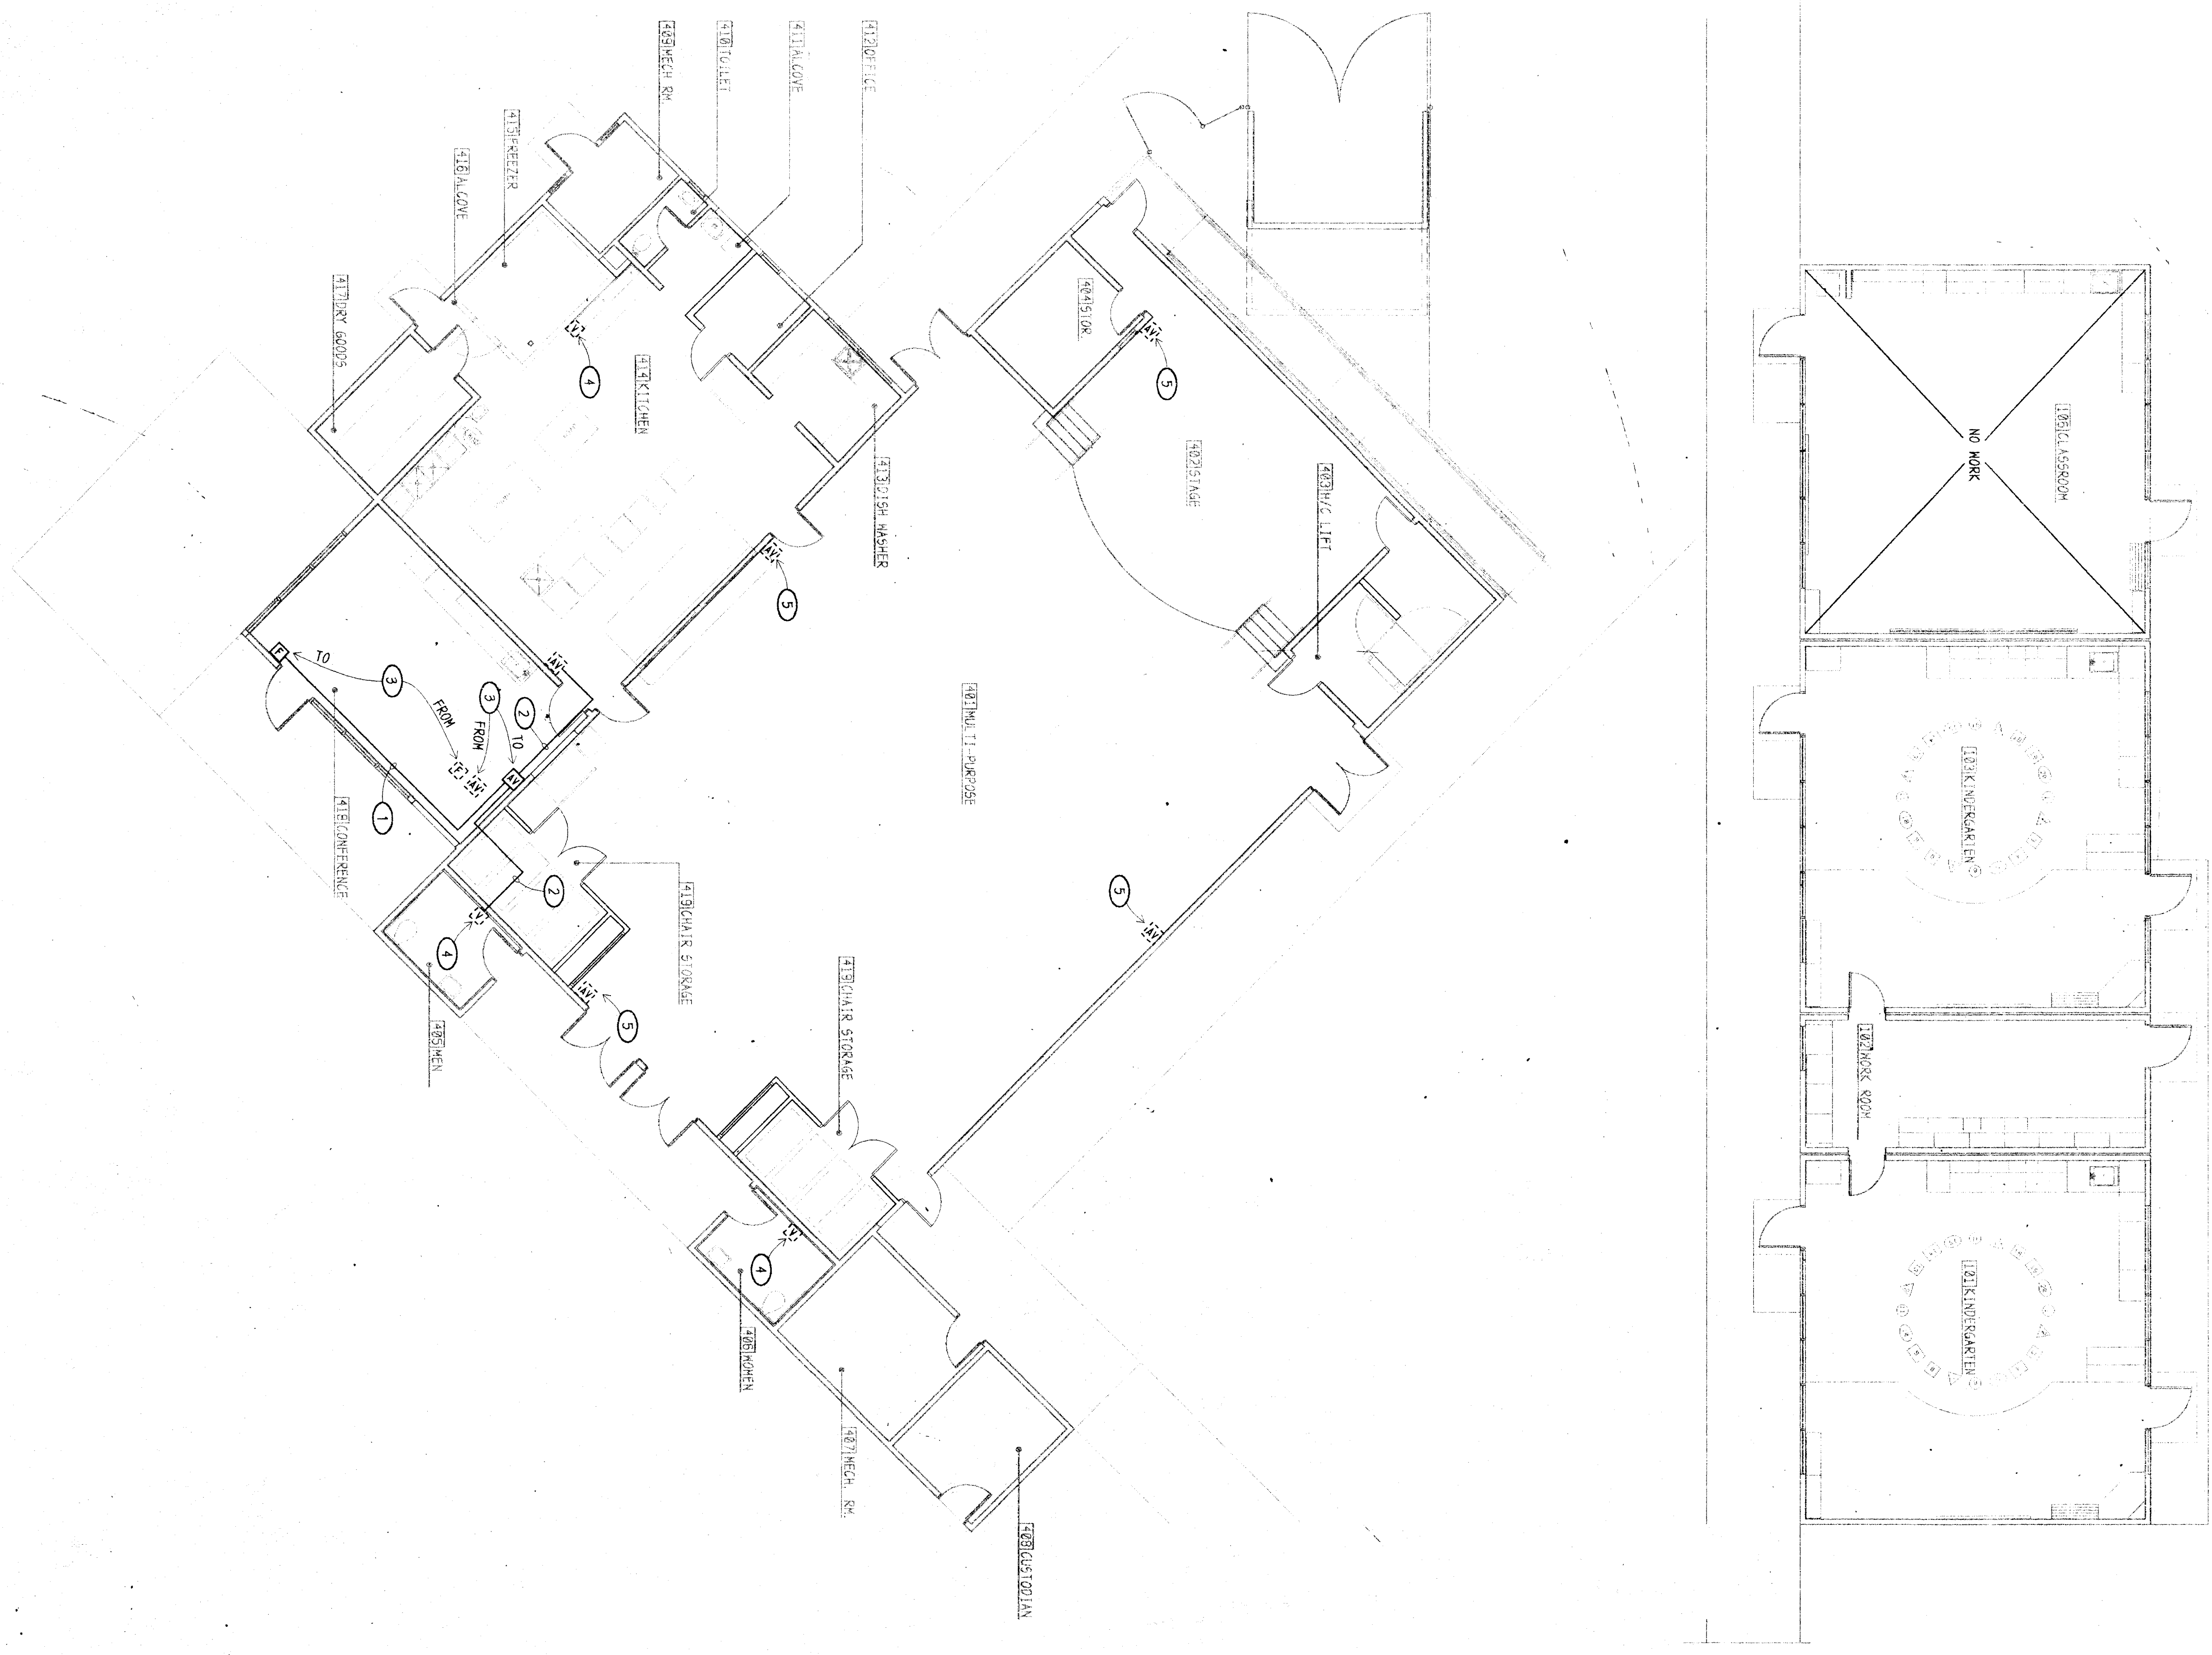

- NOTES (THIS SHEET ONLY):
- 1 ROUTE CONDUIT CONCEALED WHERE POSSIBLE. WHERE NOT RUN NEW AIRRAIL METAL RACEWAY (MINIMUM 7000 FEET OR EQUAL).
 - 2 RECONNECT EXISTING FA CIRCUIT PATH AS SHOWN AS DISCUSSED IN NOTE WITH 6 #12, 2 #14 IN SAME MANNER AS BEFORE DEMOLITION WORK.
 - 3 RELOCATE DEVICES FROM HALL BEING REMOVED AND RECONNECT AS NOTED.
 - 4 LOCATION OF EXISTING VISUAL DEVICE. NO WORK REQUIRED.
 - 5 LOCATION OF EXISTING AUDIO/VISUAL DEVICE. NO WORK REQUIRED.

NOTE
 THE FIRE ALARM SYSTEM SHOWN ON THESE PLANS HAS BEEN SUBMITTED AND APPROVED BY THE DIVISION OF STATE ARCHITECT FOR REVIEW AND APPROVAL. THE CONTRACTOR SHALL PAY ANY ADDITIONAL FEES THAT ARE INCURRED DUE TO THIS SUBSTITUTION.


COMPLETE FIRE ALARM PLAN SUBMITTAL
 THE FIRE ALARM SYSTEM SHOWN ON THESE PLANS HAS BEEN SUBMITTED AND APPROVED BY THE DIVISION OF STATE ARCHITECT FOR REVIEW AND APPROVAL. THE CONTRACTOR SHALL PAY ANY ADDITIONAL FEES THAT ARE INCURRED DUE TO THIS SUBSTITUTION.

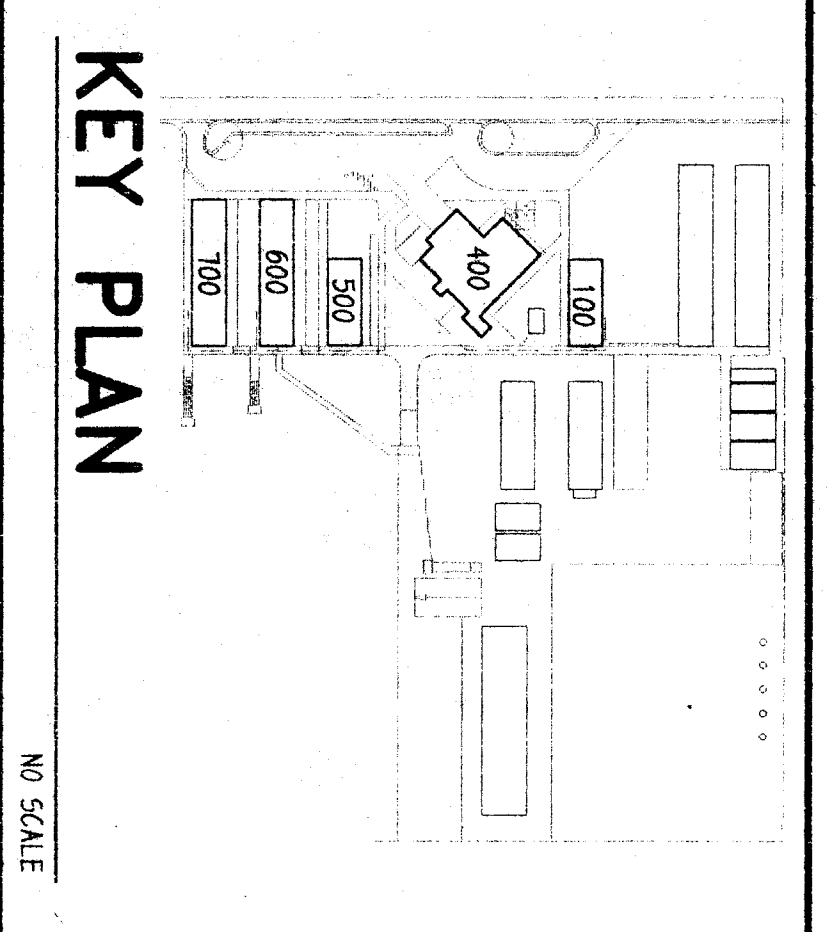

KEY PLAN
 NO SCALE


CONNELLS DESIGN GROUP, INC.
 REGISTERED ARCHITECTS
 No. 7198
 Exp. 6/30/00
 918 W. Main St., Ph. 725-3671
 Visalia, California 93271

1/8"

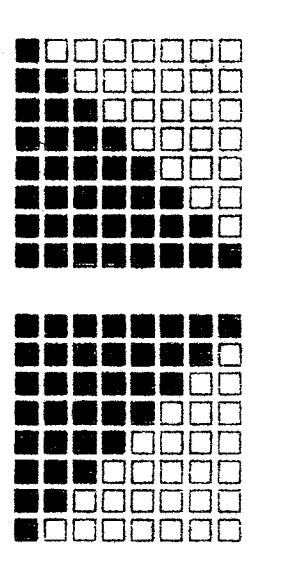

**ORDIZ
 MELBY
 ARCHITECTS**

3620 DISTRICT BLVD., #105
 BAKERSFIELD, CA 93313
 TEL. (805)-832-8288
 FAX. (805)-832-4291

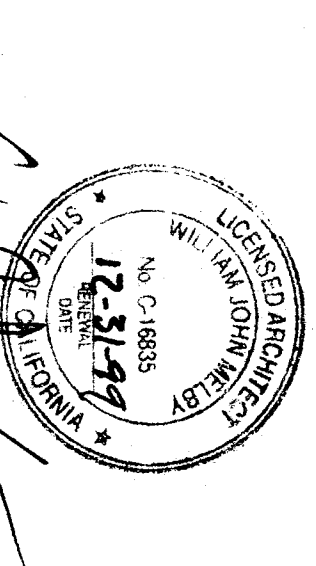

DANNY E. ORDIZ
 ARCHITECT C-14,728
 WILLIAM J. MELBY
 ARCHITECT C-16,835

IDENTIFICATION STAMP
 DIV. OF STATE ARCHITECT
 OFFICE OF REGULATIONS SERVICES

APPL. NO. 101484
 FILE NO.
 AC FKS HAS SA MC
 DATE 1-15-1999

AS BUILT DRAWINGS
 MODERNIZATION OF
 COLLEGE HEIGHTS
 ELEM. SCHOOL
 FOR:

**BAKERSFIELD
 CITY
 SCHOOL
 DISTRICT**

2551 SUNNY LN.
 BAKERSFIELD,
 CALIFORNIA
 93305

CHECK AND VERIFY ALL DIMENSIONS BEFORE PROCEEDING WITH THE WORK. REPORT DISCREPANCIES TO THE ARCHITECT.

MARK	DATE	REVISION

BUILDINGS 100 & 400 -
 FIRE ALARM PLANS

DESIGNER
 97.1.40
 DATE
 01-06-99
 DRAWN BY
 AC