


ORDIZ MELBY ARCHITECTS INC.  
 5620 DISTRICT BLVD. #105  
 BAKERSFIELD, CA 93313  
 TEL (805)-832-5258  
 FAX (805)-832-4291

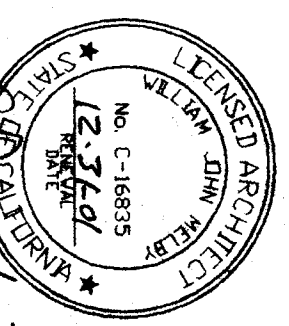

DANNY E. OSBIZ A.I.A.  
 ARCHITECT C-14,728  
 WILLIAM J. MELBY A.I.A.  
 ARCHITECT C-16,936

REGISTRATION STAMP  
 DIVISION OF THE STATE ARCHITECT  
 OFFICE OF REGULATION SERVICES  
 APRIL 10, 2004  
 FILE NO. 10-484  
 MECHANICAL  
 DATE: \_\_\_\_\_

AS BUILT DRAWINGS  
 MODERNIZATION OF  
 COLLEGE HEIGHTS  
 ELEM. SCHOOL  
 FOR:

BAKERSFIELD  
 CITY  
 SCHOOL  
 DISTRICT

2551 SUNNY LN.  
 BAKERSFIELD,  
 CALIFORNIA  
 93305


**ADDENDUM #1  
 DRAWING MP21**

CHECK AND VERIFY ALL DIMENSIONS  
 BEFORE PROCEEDING WITH THE  
 WORK. REPORT DISCREPANCIES TO  
 THE ARCHITECT.


MARK DATE REVISION  
 01/01/2001 ADDENDUM 1

MECH. / PLB'G.  
 FLOOR  
 PLANS  
 (BLDG. 400)

JOB NUMBER  
 97140  
 1/6/99  
 DRAWN BY  
 NO./R.B. 2.1  
 SHEET  
 OF 3

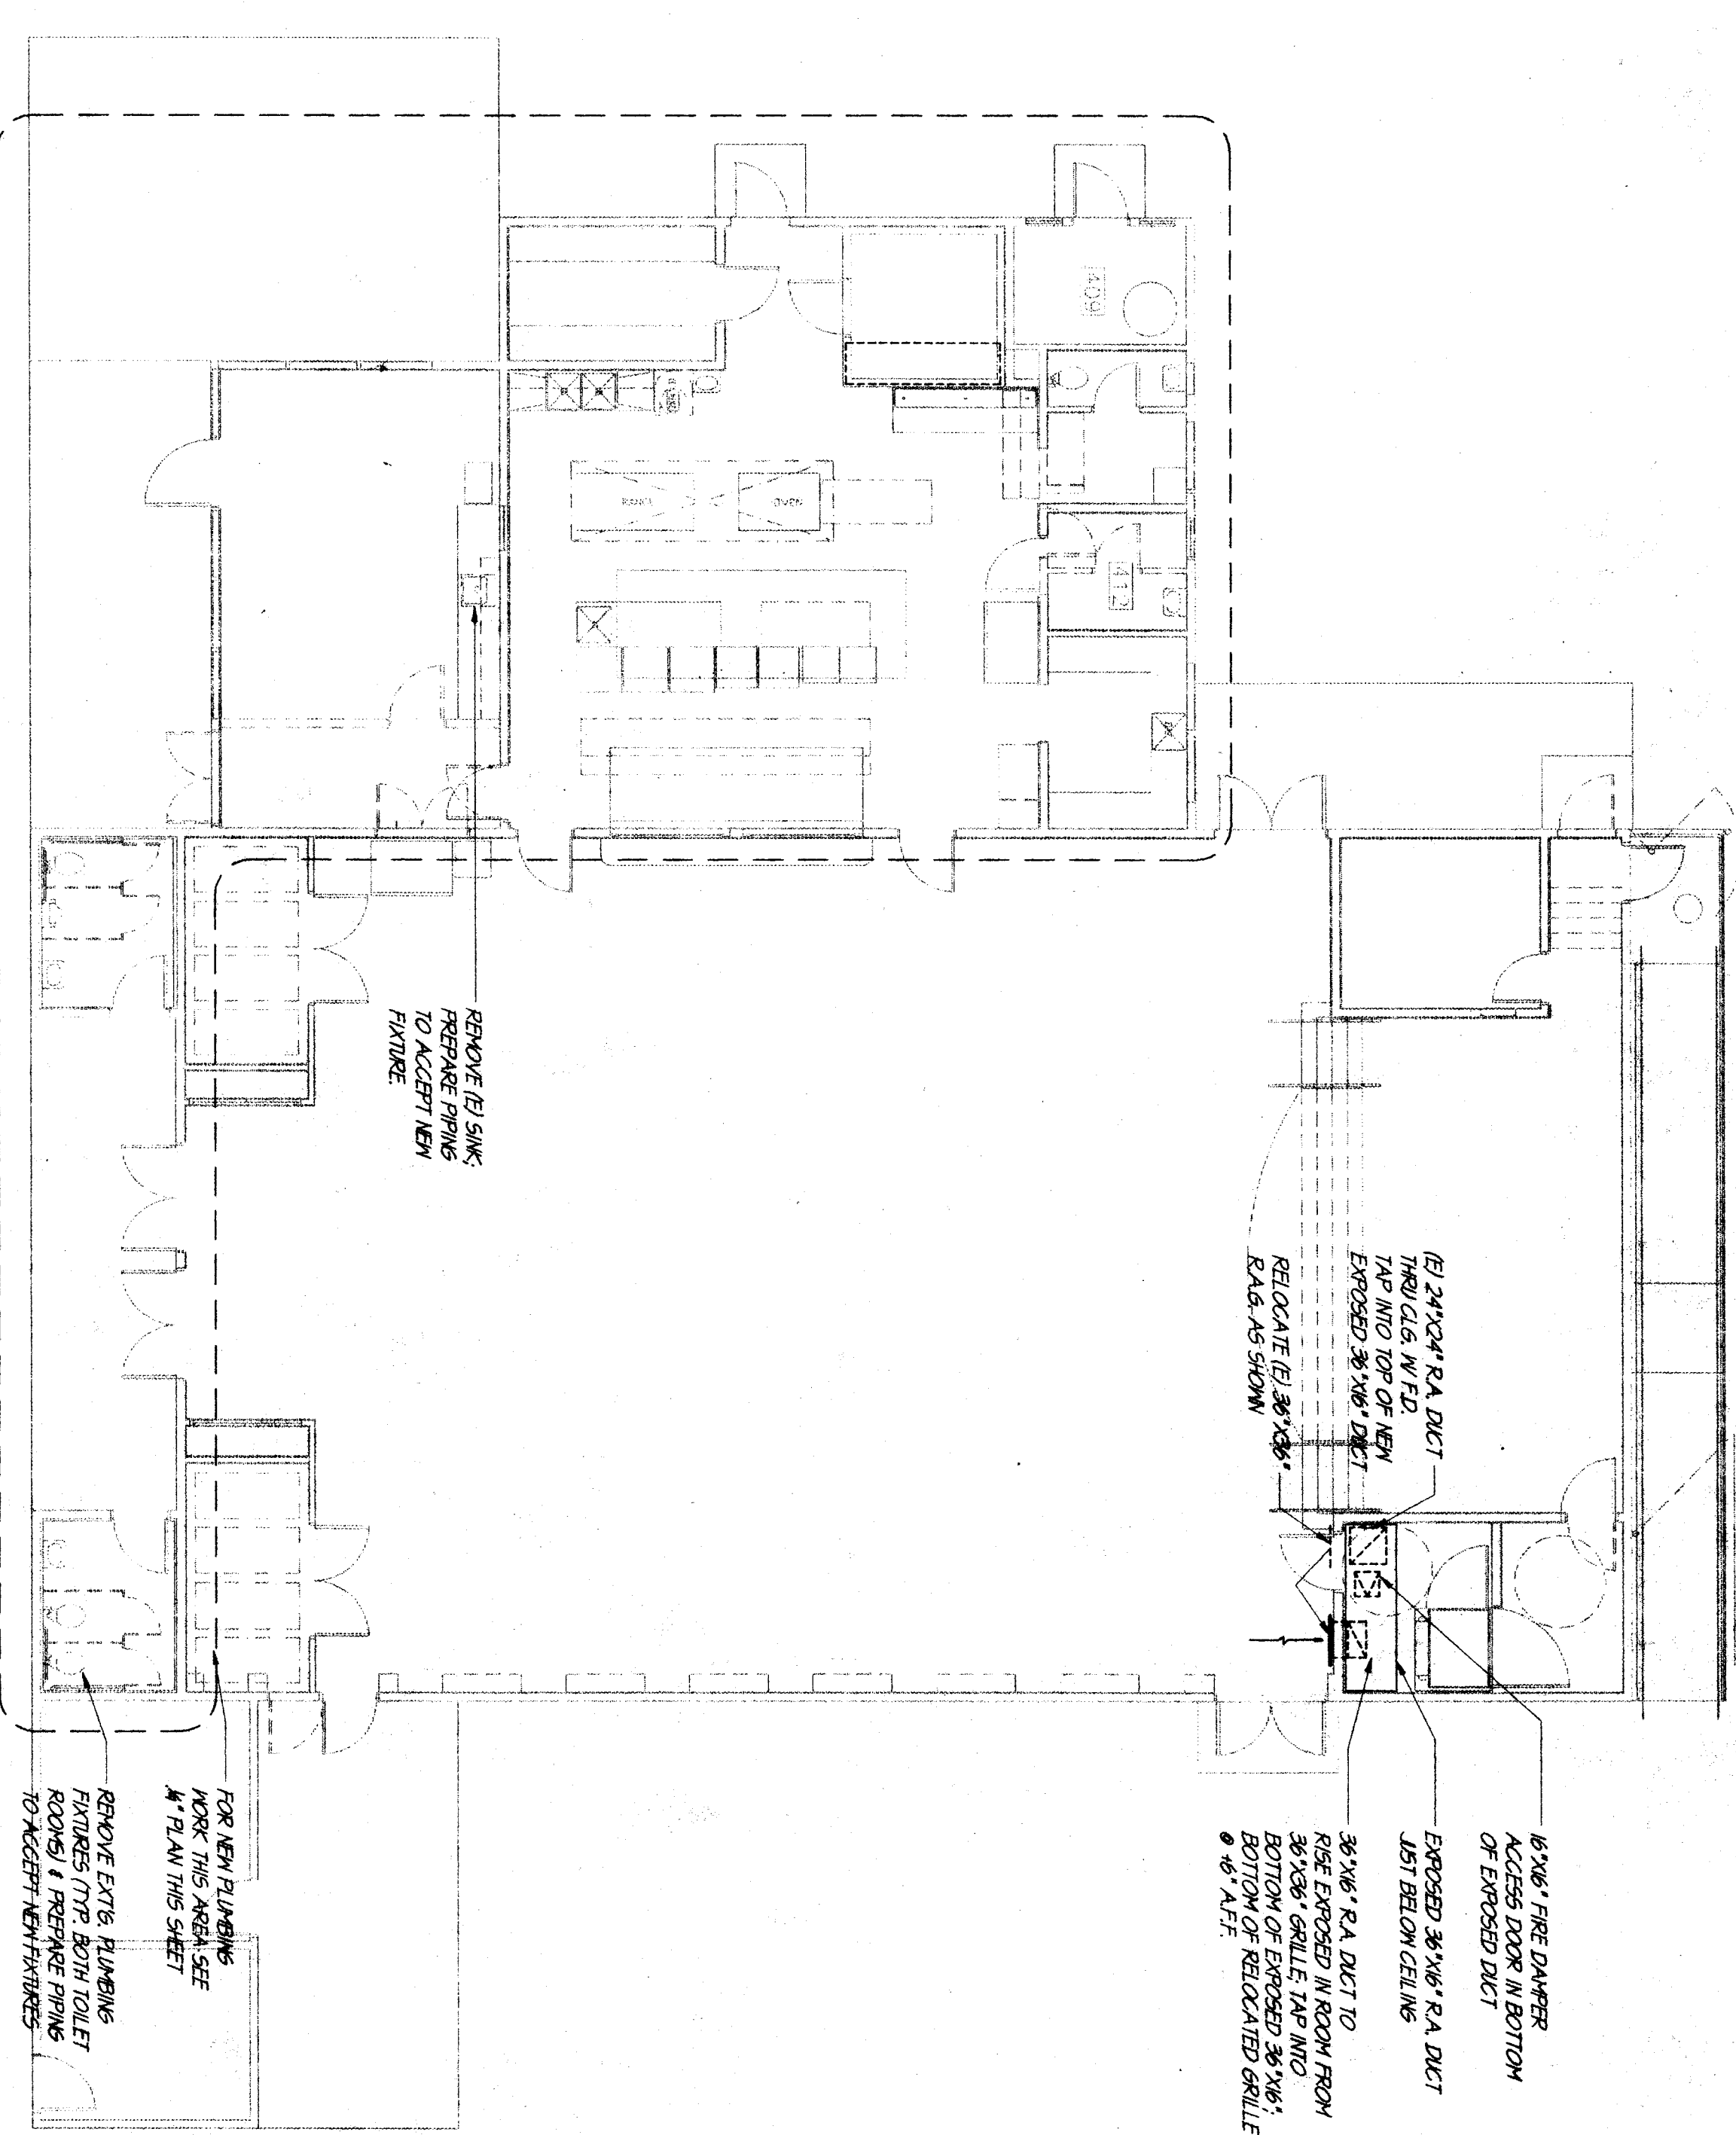

**BLDG. 400 DEMO AND MECHANICAL FLOOR PLAN**  
 SCALE 1/8"=1'-0"

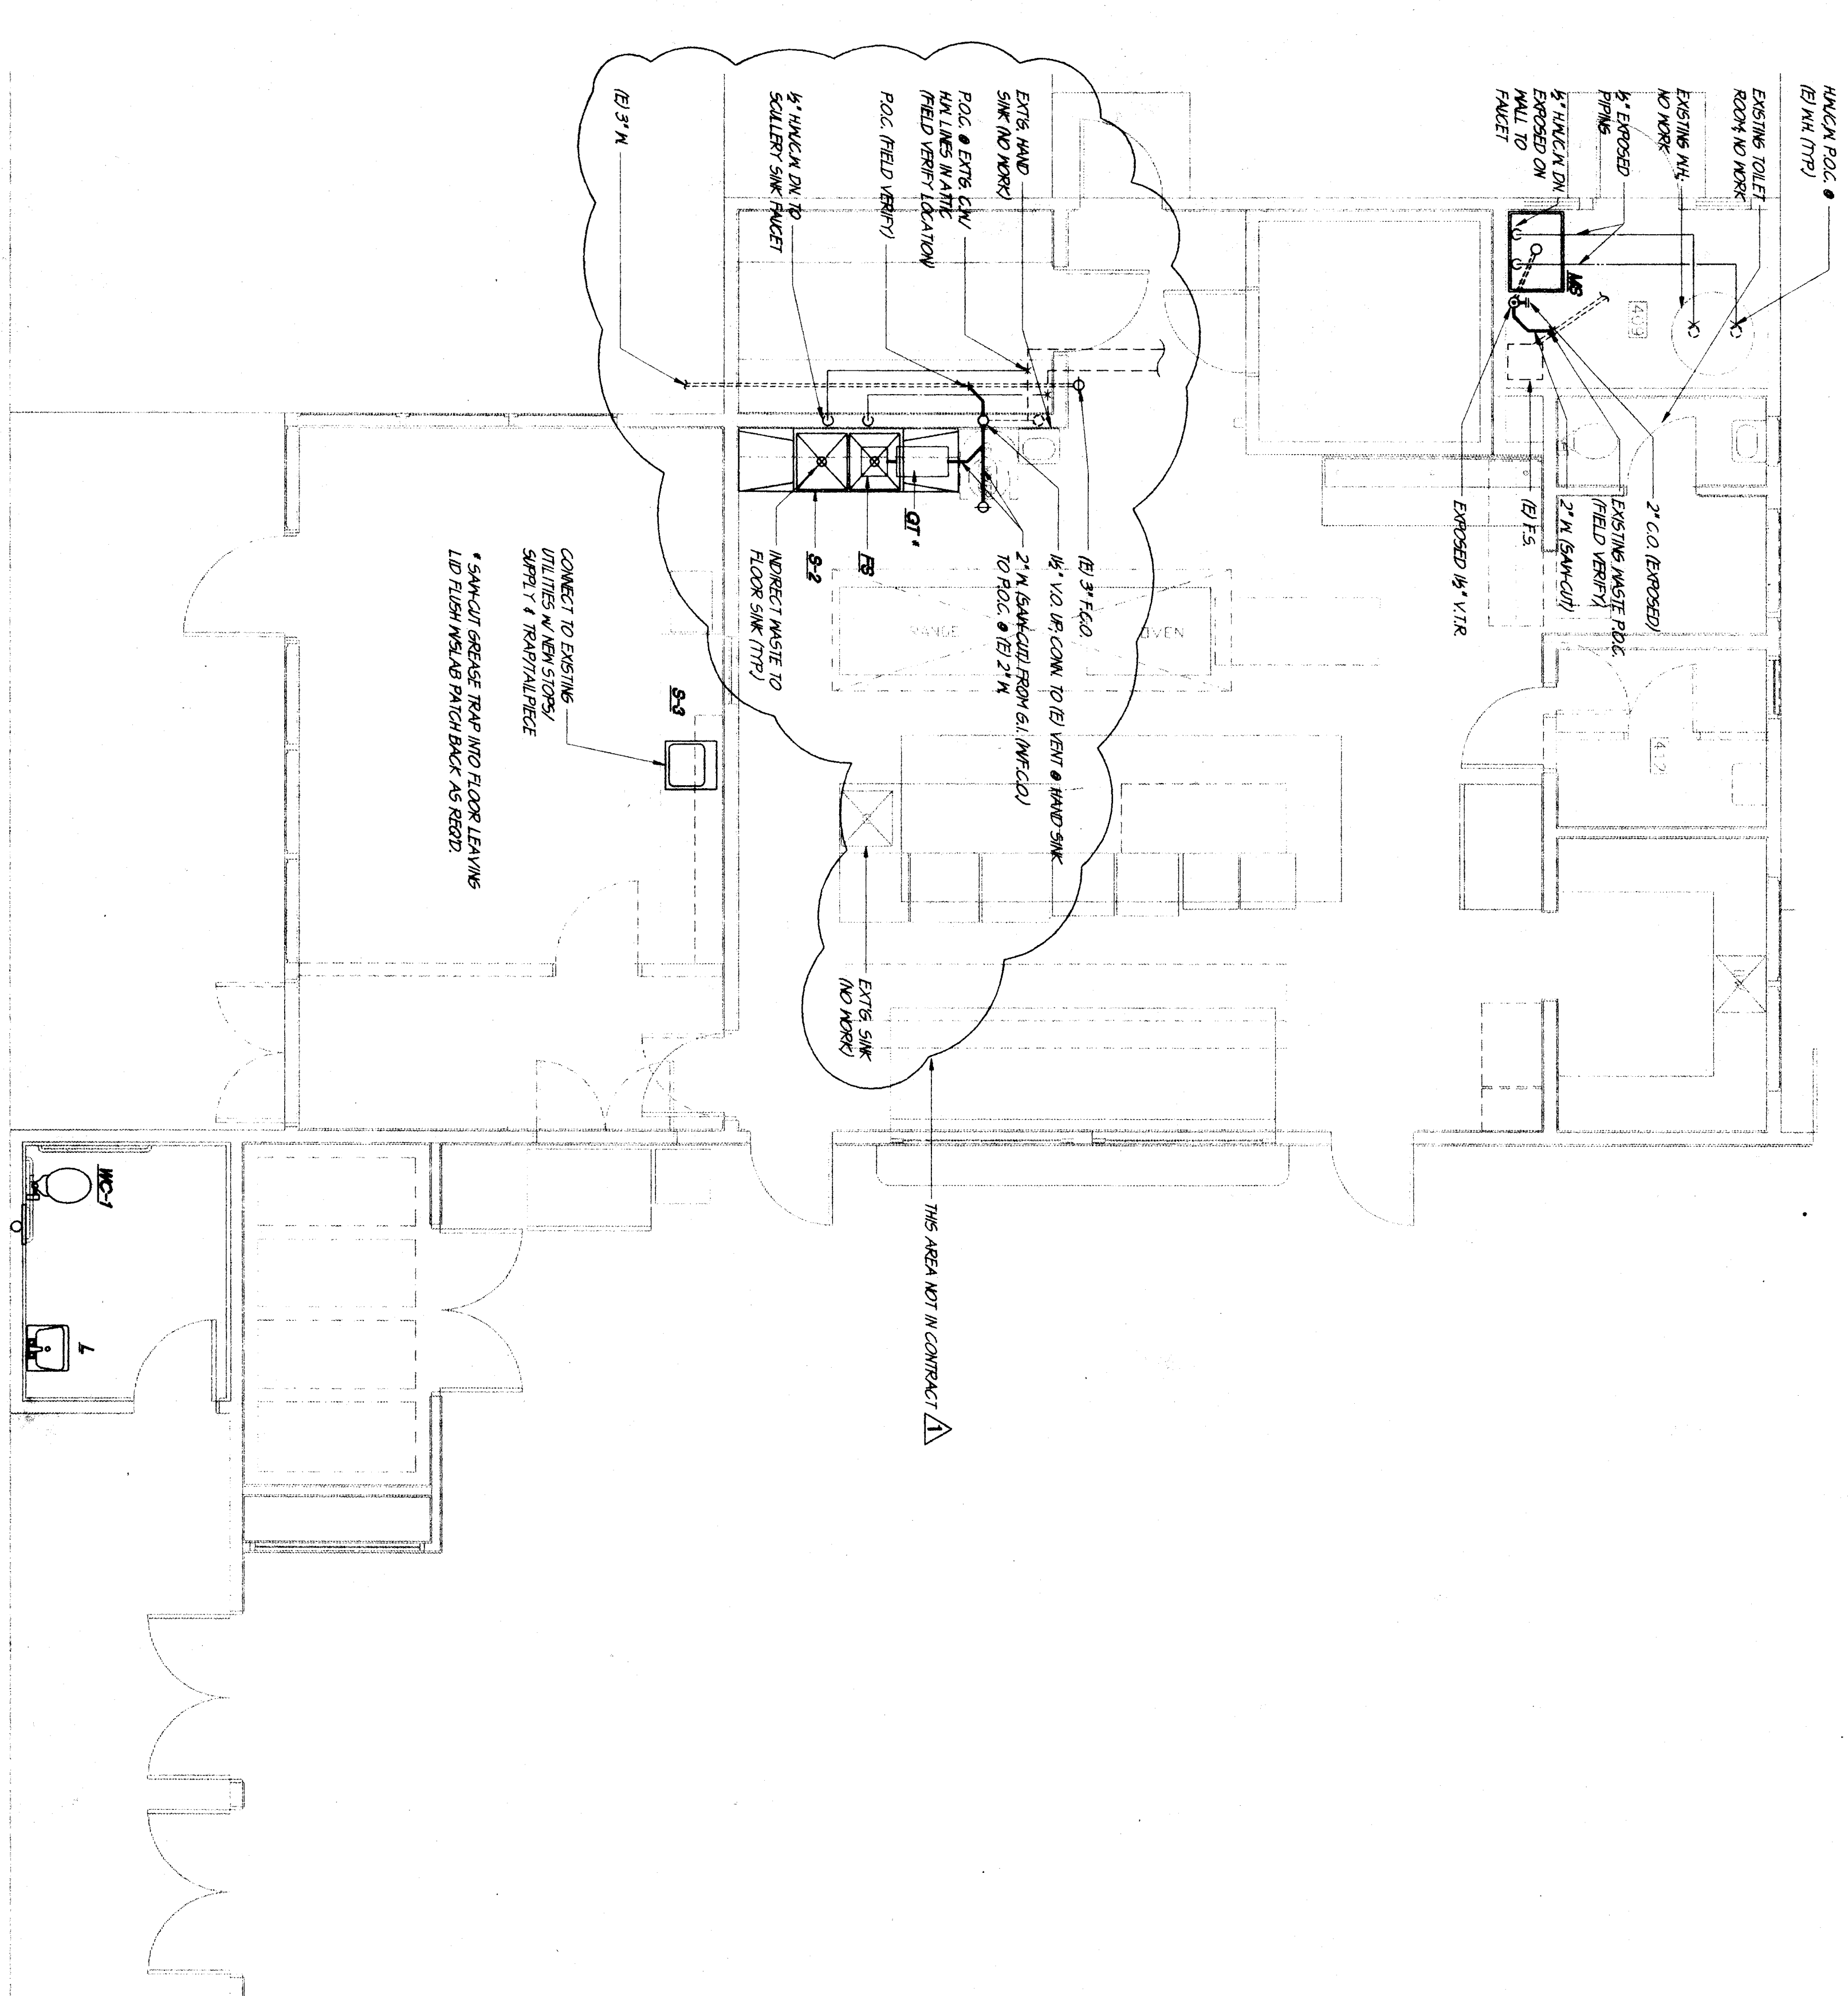

**BLDG. 400 PLB'G. FLOOR PLAN**  
 SCALE 1/8"=1'-0"

**MDC**  
 MECHANICAL ENGINEERING SERVICES  
 4925  
 4847 TULSA AVENUE, BAKERSFIELD, CA 93307  
 TEL (805) 832-7777 FAX (805) 832-7777

REGISTERED PROFESSIONAL ENGINEER  
 WILLIAM J. MELBY  
 License No. 12316  
 State of California