




ELEVATION VIEW - HEATER ROOM  
SCALE: 3/8" = 1'-0"

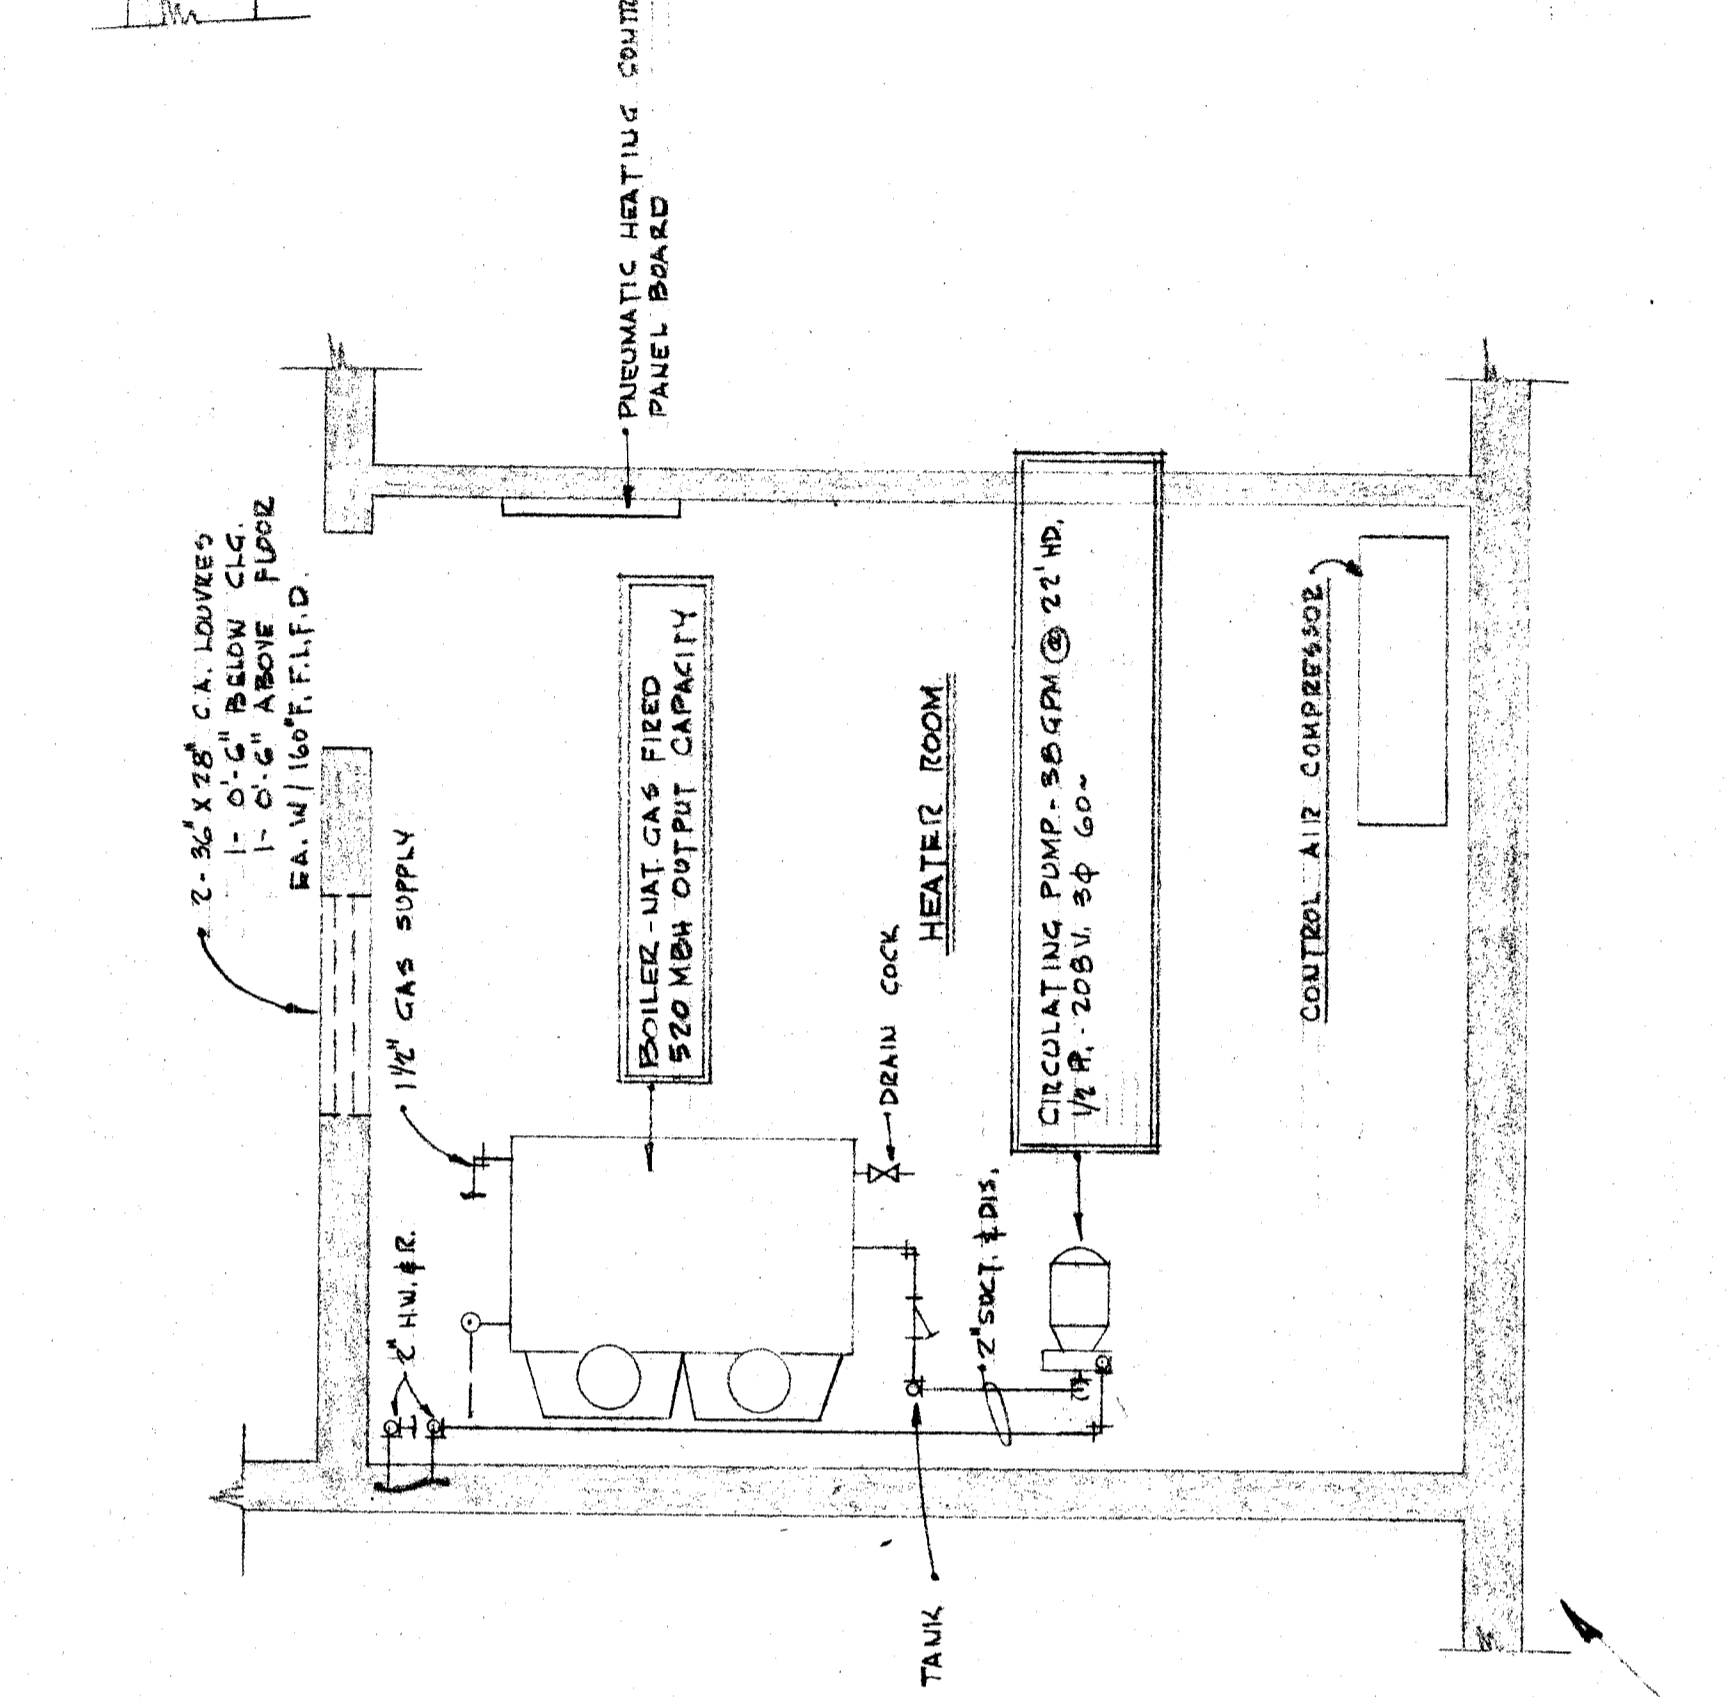


PLAN VIEW - HEATER ROOM  
SCALE: 3/8" = 1'-0"

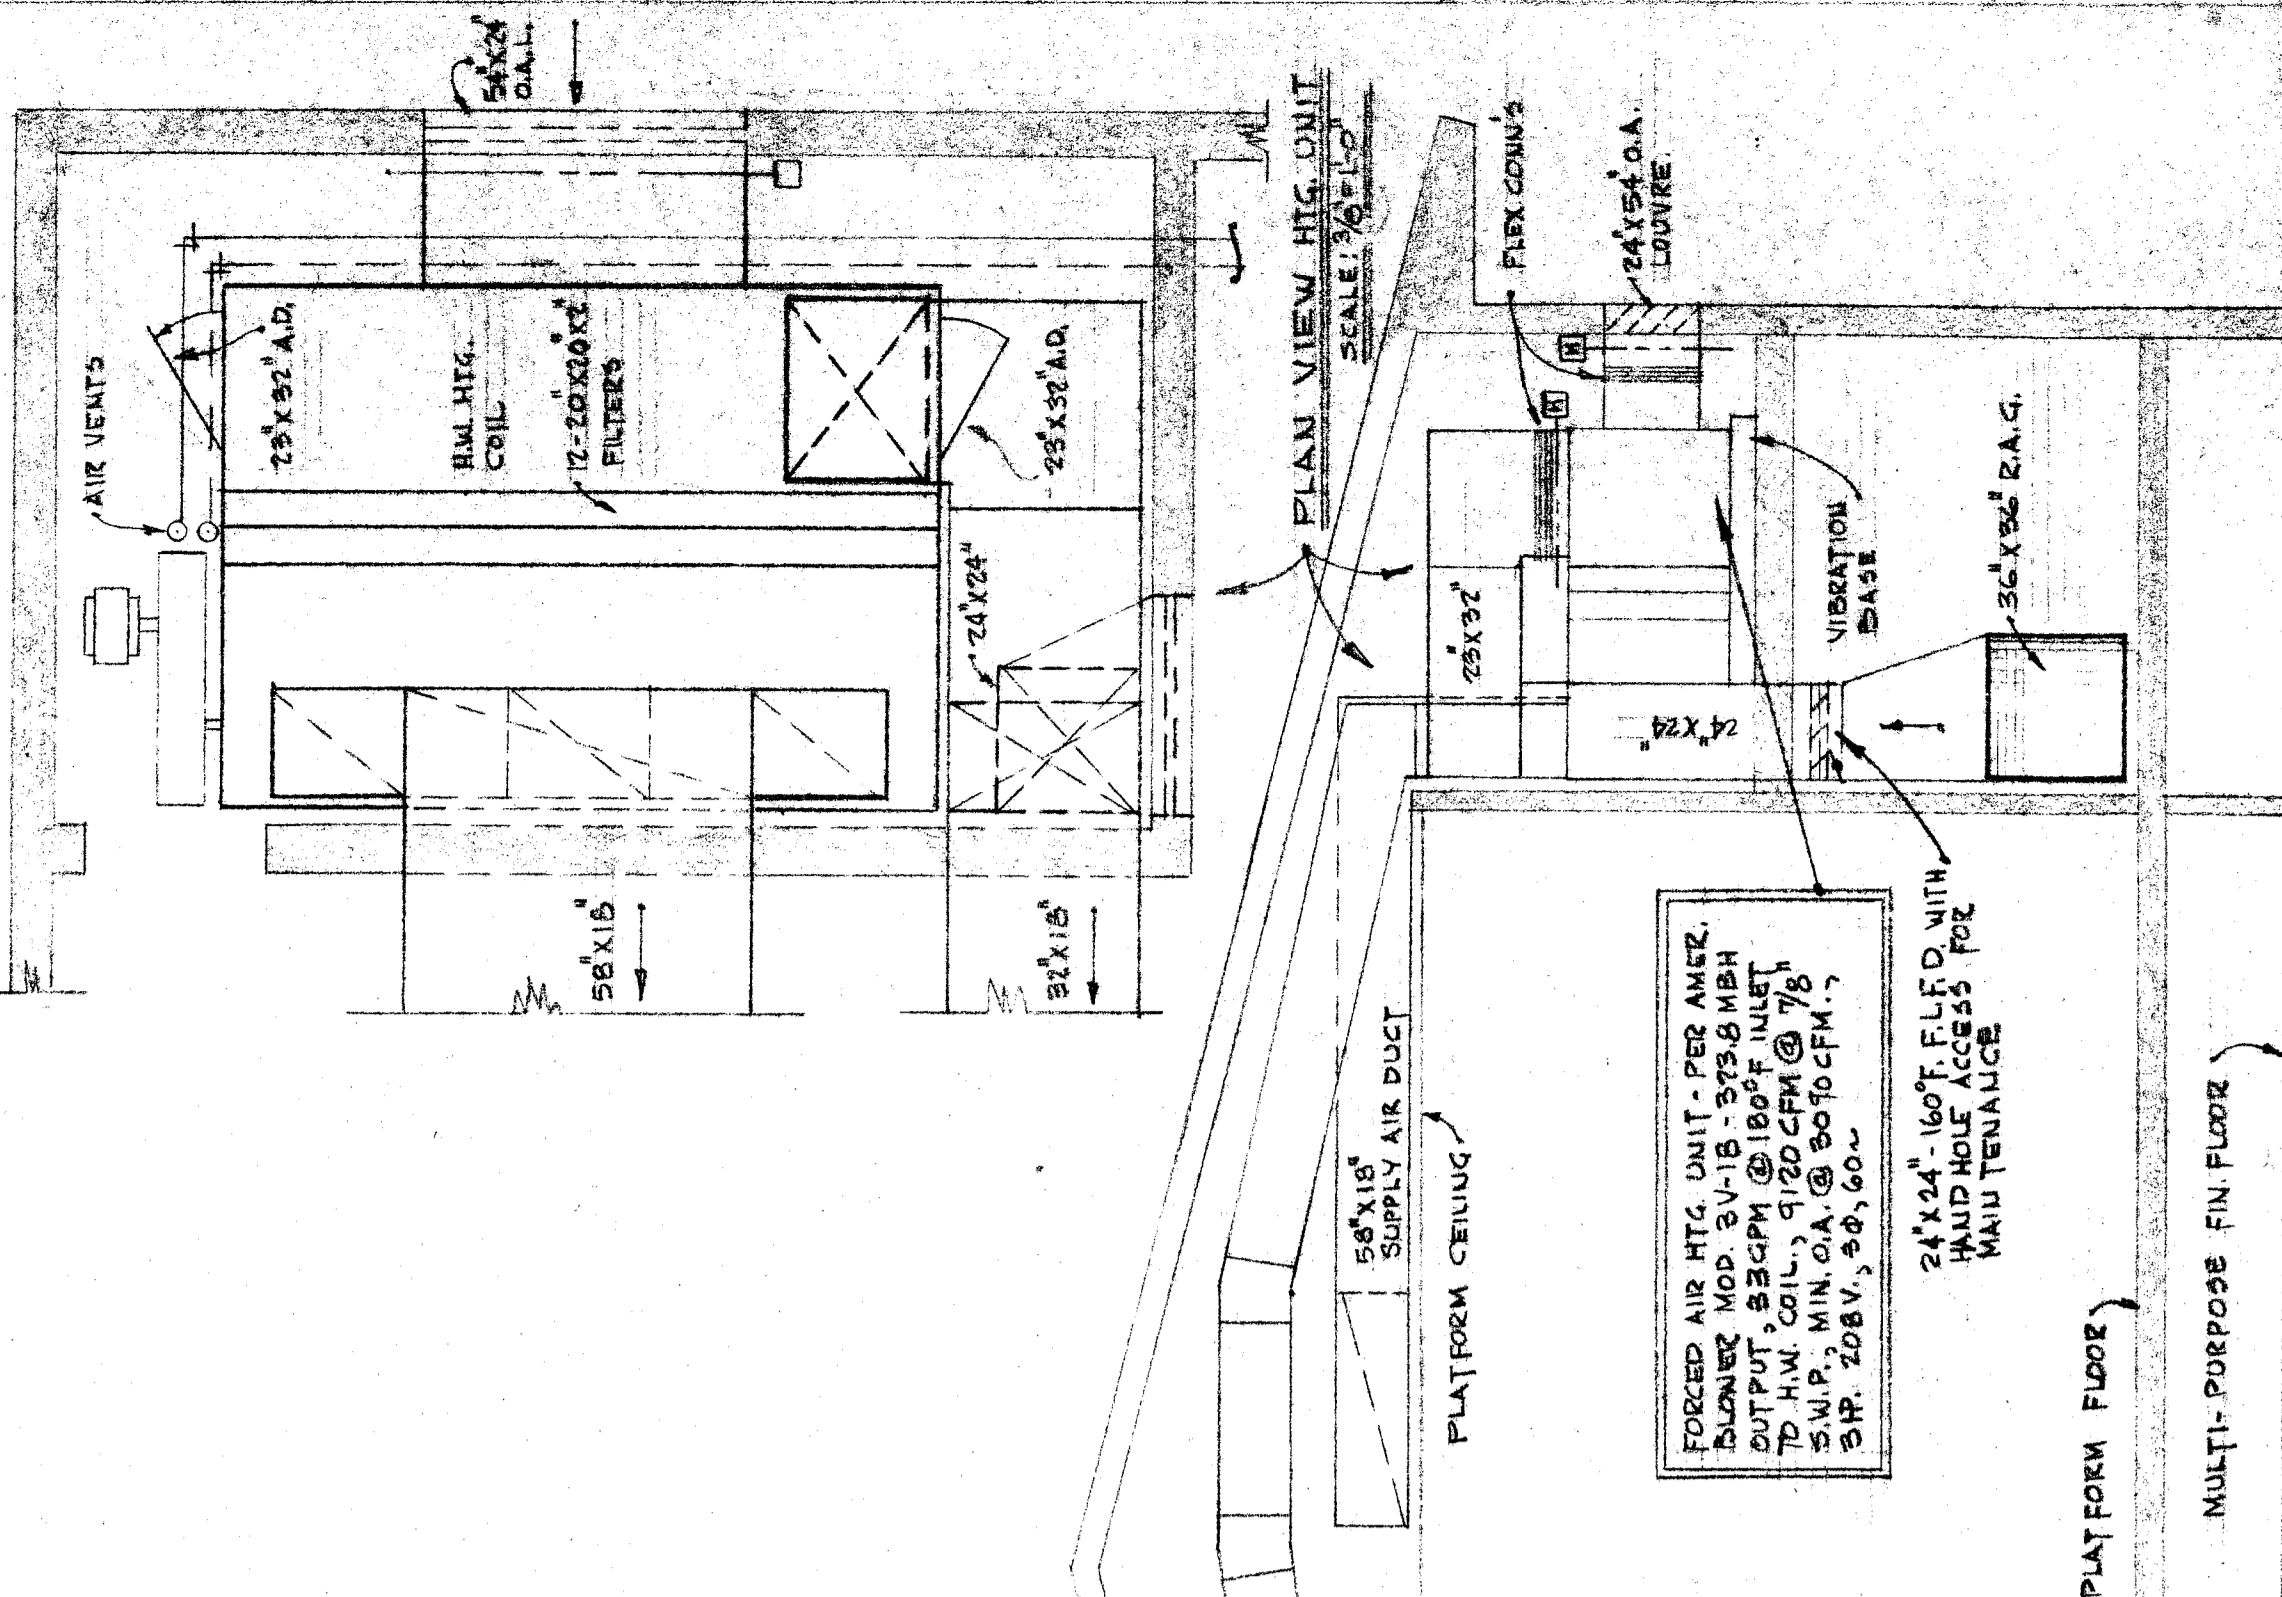

ELEVATION VIEW - HEATER ROOM  
SCALE: 3/8" = 1'-0"

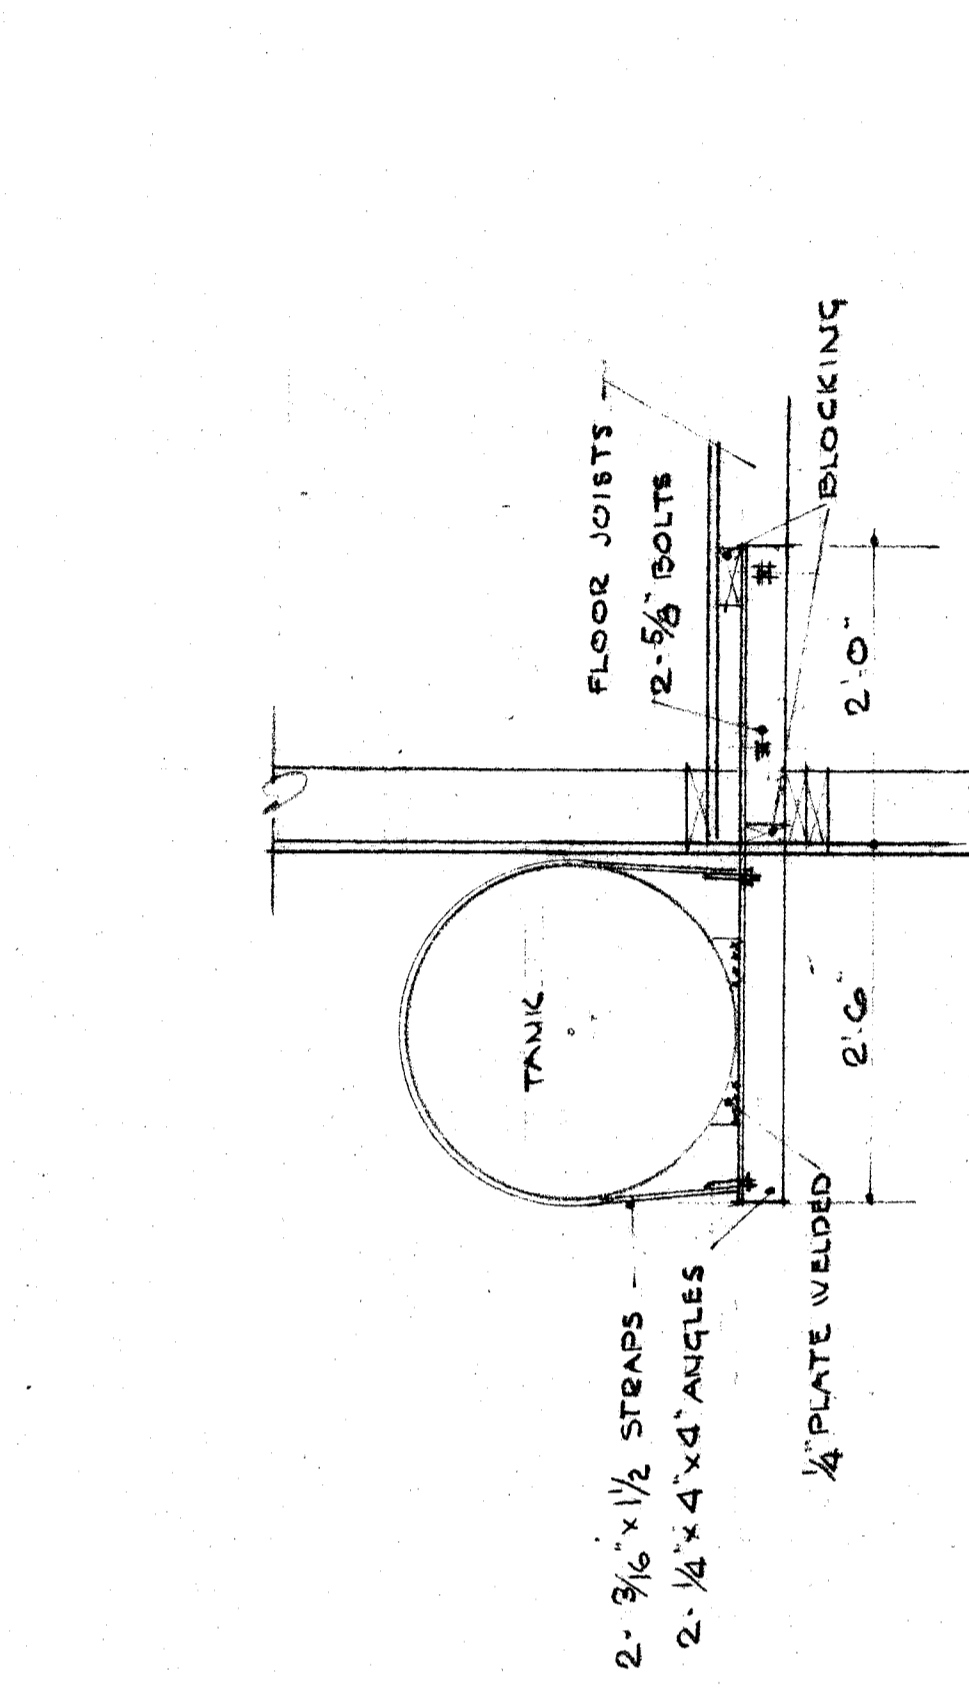

TANK SUPPORT  
SCALE: 1/2" = 1'-0"

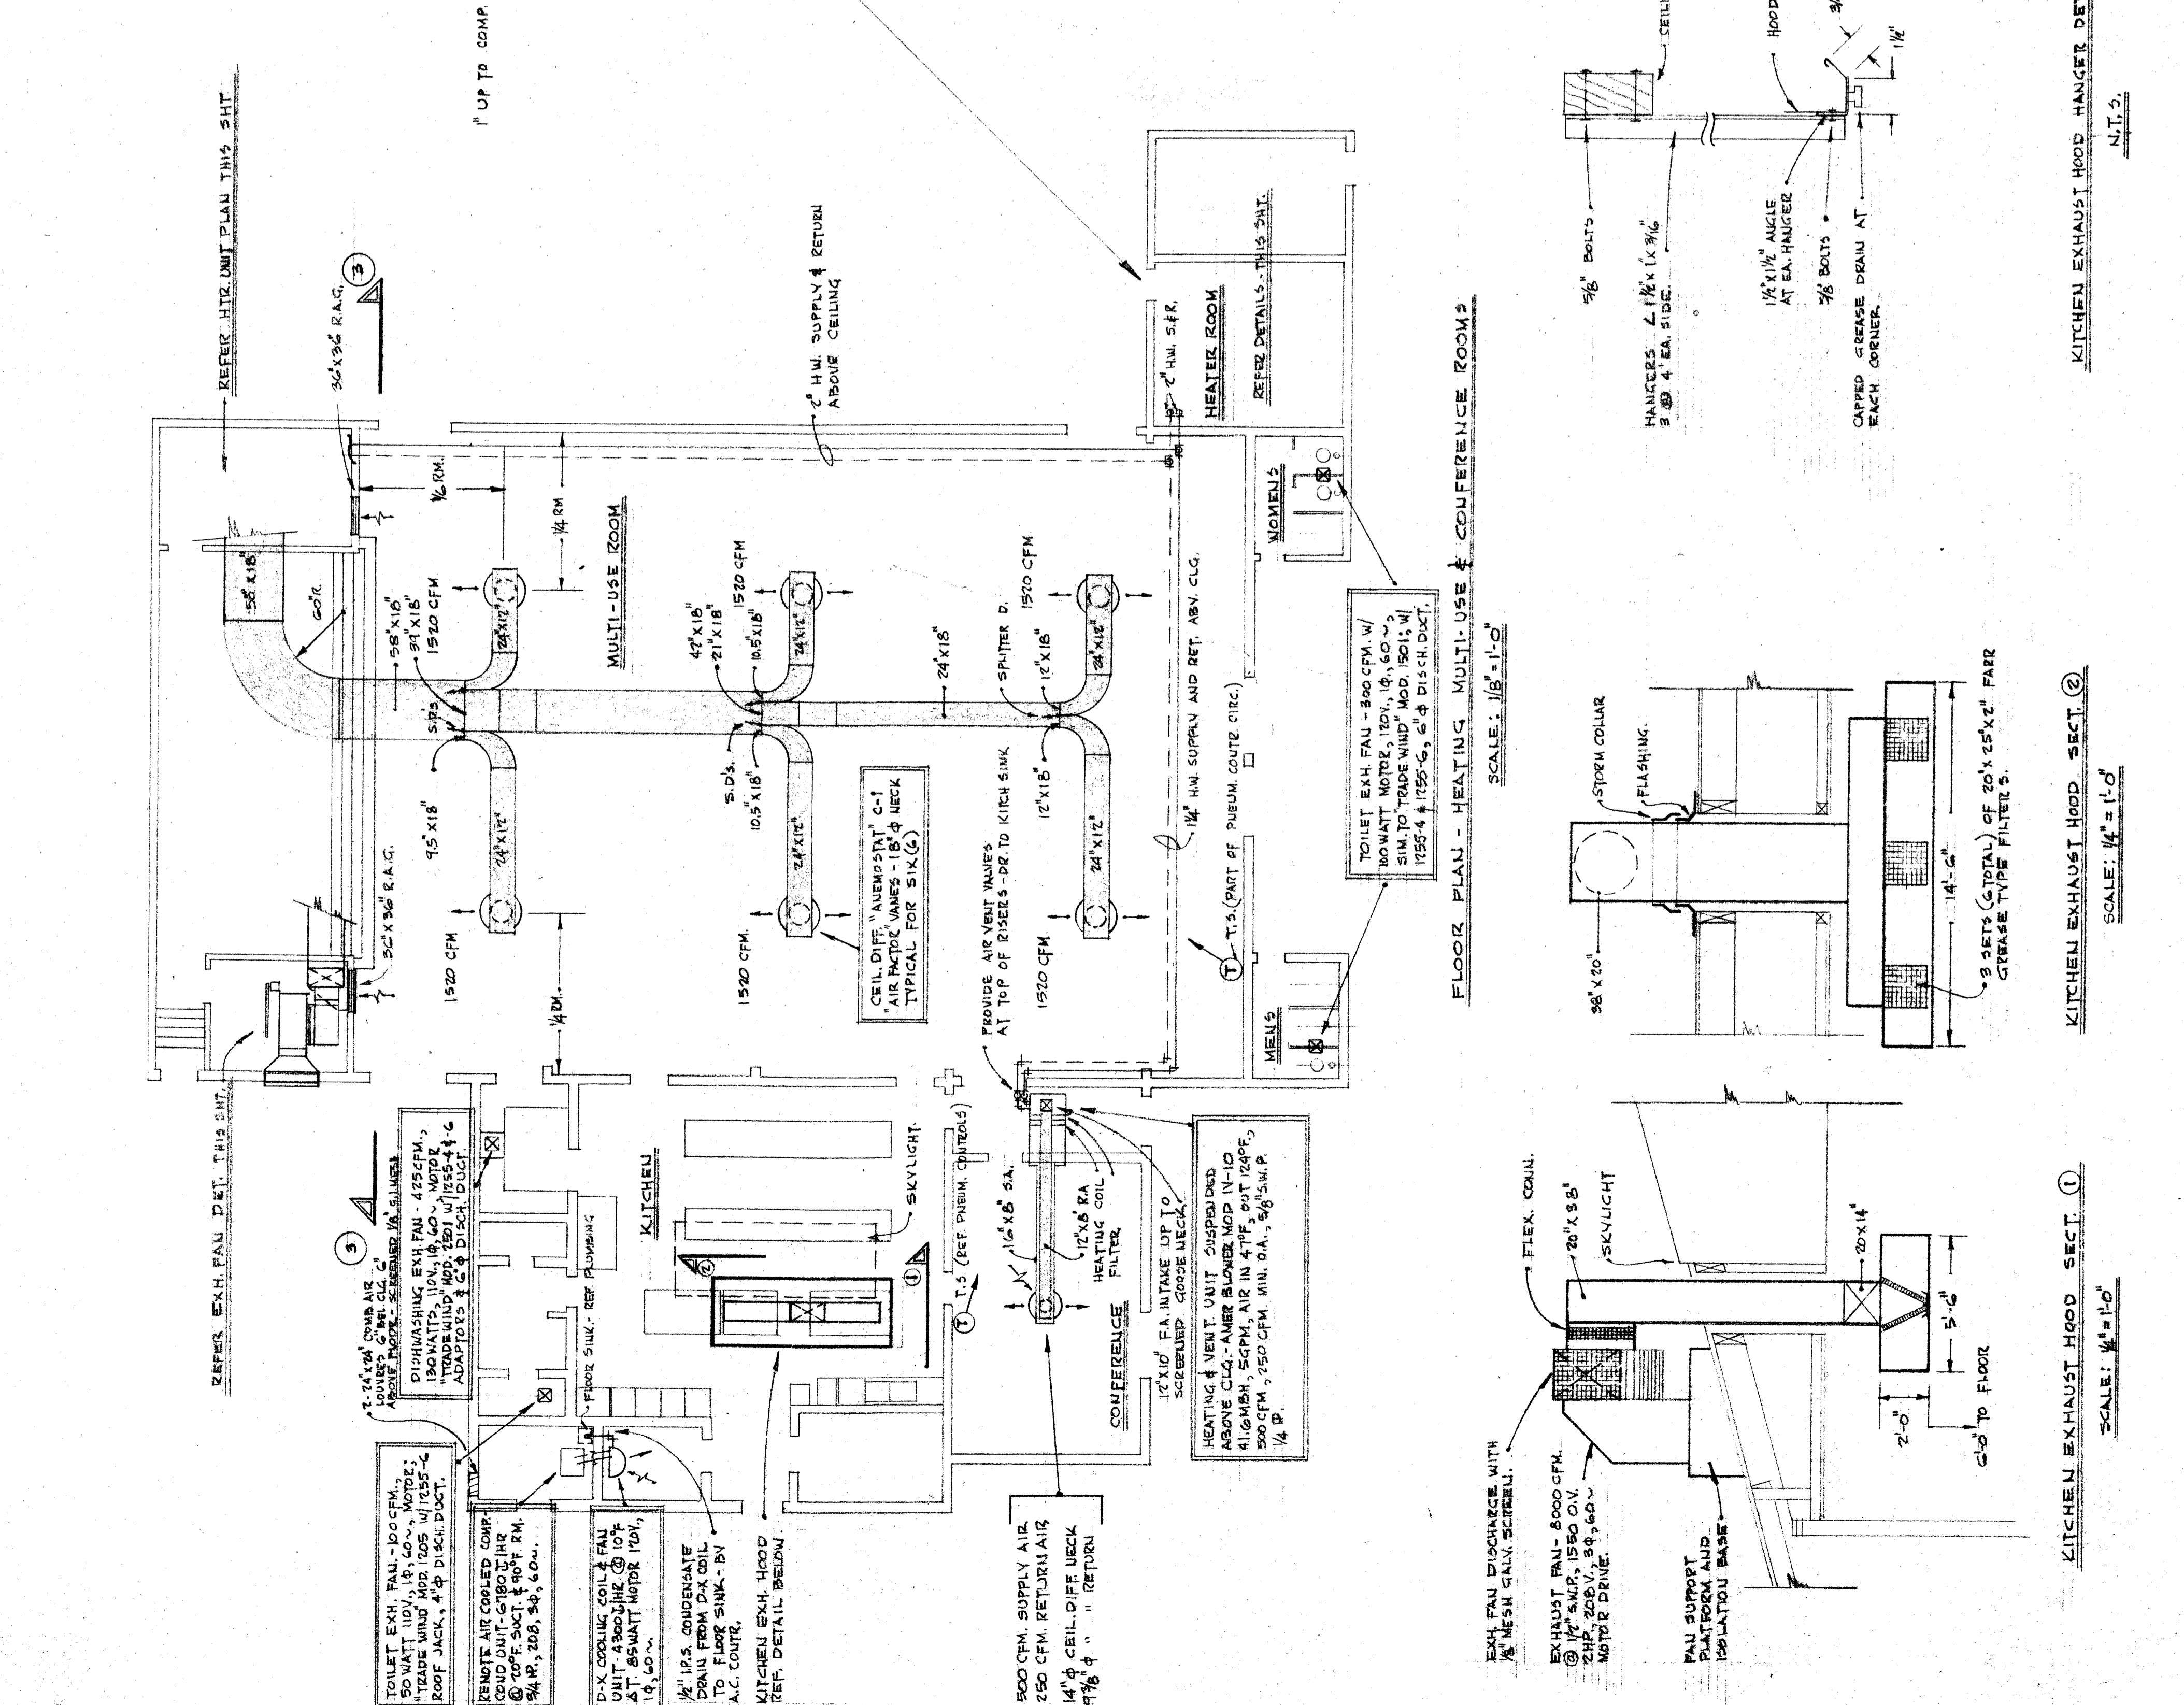

FLOOR PLAN - HEATING, MULTI-USE & CONFERENCE ROOMS  
SCALE: 1/8" = 1'-0"

KITCHEN EXHAUST HOOD - HANGER DETAIL - C REGO  
SCALE: 1/4" = 1'-0"

KITCHEN EXHAUST HOOD - SECT. 1  
SCALE: 1/4" = 1'-0"

KITCHEN EXHAUST HOOD - SECT. 2  
SCALE: 1/4" = 1'-0"

BAKERSFIELD CITY SCHOOL DISTRICT  
 APPROVED MAY 9 1957  
 BOARD OF EDUCATION  
 BY RESOLUTION  
*Paul J. Compton*  
 Chief of Schools

DIVISION OF ARCHITECTURE  
 STATE OF CALIFORNIA - DEPARTMENT OF PUBLIC WORKS  
 DIVISION OF ARCHITECTURE  
 16 079 (REVISED) JULY 9 - 1957

CONTRACTOR: H. B. LEYDENFROST  
 MAY 9 1957  
 H. B. LEYDENFROST  
 ARCHITECTS  
 BAKERSFIELD, CALIFORNIA

MULTI-PURPOSE BUILDING, HEATING & VENTILATING - SECTION 1  
 SCALE: 1/4" = 1'-0"

MULTI-PURPOSE BUILDING, HEATING & VENTILATING - SECTION 2  
 SCALE: 1/4" = 1'-0"

MULTI-PURPOSE ROOM  
 HEIGHT STREET SCHOOL  
 BAKERSFIELD CITY SCHOOL DISTRICT  
 BAKERSFIELD CALIFORNIA

ALFORD, THOMAS & LEYDENFROST  
 C. B. ALFORD • W. J. THOMAS • ARCHITECTS • H. B. LEYDENFROST  
 BAKERSFIELD • CALIFORNIA

ALFORD, THOMAS & LEYDENFROST, ARCHITECTS  
 200 WEST 10TH STREET, BAKERSFIELD, CALIFORNIA  
 CONTRACTOR: H. B. LEYDENFROST  
 416 NORTH 2ND STREET, BAKERSFIELD, CALIFORNIA  
 WITHOUT THE APPROVED ARCHITECTURAL AND  
 ENGINEERING DRAWINGS AND SEAL OF THE  
 ARCHITECT OR ENGINEER, NO CONTRACT SHALL  
 BE VALID.