


DANNY E. ORDIZ, AIA  
 ARCHITECT C-74,728  
 WILLIAM J. MELBY, AIA  
 ARCHITECT C-16,833  
 CONSULTANT

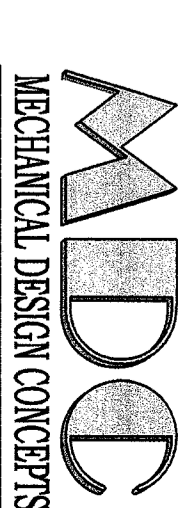


428 Truxtun Avenue  
 Bakersfield, Ca. 93301  
 Tel # (661) 326-1213  
 Fax # (661) 326-1213  
 Mobile # (661) 326-1213  
 E-mail: dordiz@mddc.com

IDENTIFICATION STAMP  
 DIVISION OF THE STATE ARCHITECT  
 OFFICE OF REGULATION SERVICES  
 APRL # 03-107003  
 FILE # 15-6  
 AC \_\_\_\_\_ RS \_\_\_\_\_ SS \_\_\_\_\_  
 DATE \_\_\_\_\_

MODERNIZATION FOR  
 CURRAN JUNIOR  
 HIGH SCHOOL  
 FOR:

BAKERSFIELD  
 CITY SCHOOL  
 DISTRICT


1116 LYMRIC WAY  
 BAKERSFIELD,  
 CALIFORNIA  
 93309

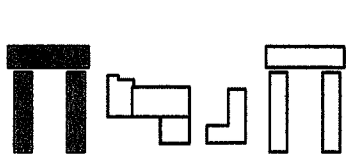

MARK	DATE	DESCRIPTION
SD		
CD		
△		
△		

NO NUMBER  
 2002480  
 000DWG FILE  
 DRAWN BY: NA  
 CHECKED BY: NA  
 DATE: 10/20/07  
 CHECK AND VERIFY ALL DIMENSIONS BEFORE  
 BEGINNING WORK. ALL DIMENSIONS SHALL BE  
 RECHECKED TO THE ARCHITECT'S  
 REPRESENTATIVE ON THIS SHEET AND THE  
 PROPERTY OF THE ARCHITECT.  
 0802/MELBY ARCHITECTS, INC. 2000

SHEET TITLE  
 MECHANICAL FLOOR  
 PLAN -  
 BUILDINGS 'F', 'G' & 'H'  
 SHEET IDENTIFICATION NUMBER  
**M-123A**  
 SHEET 3 OF 5

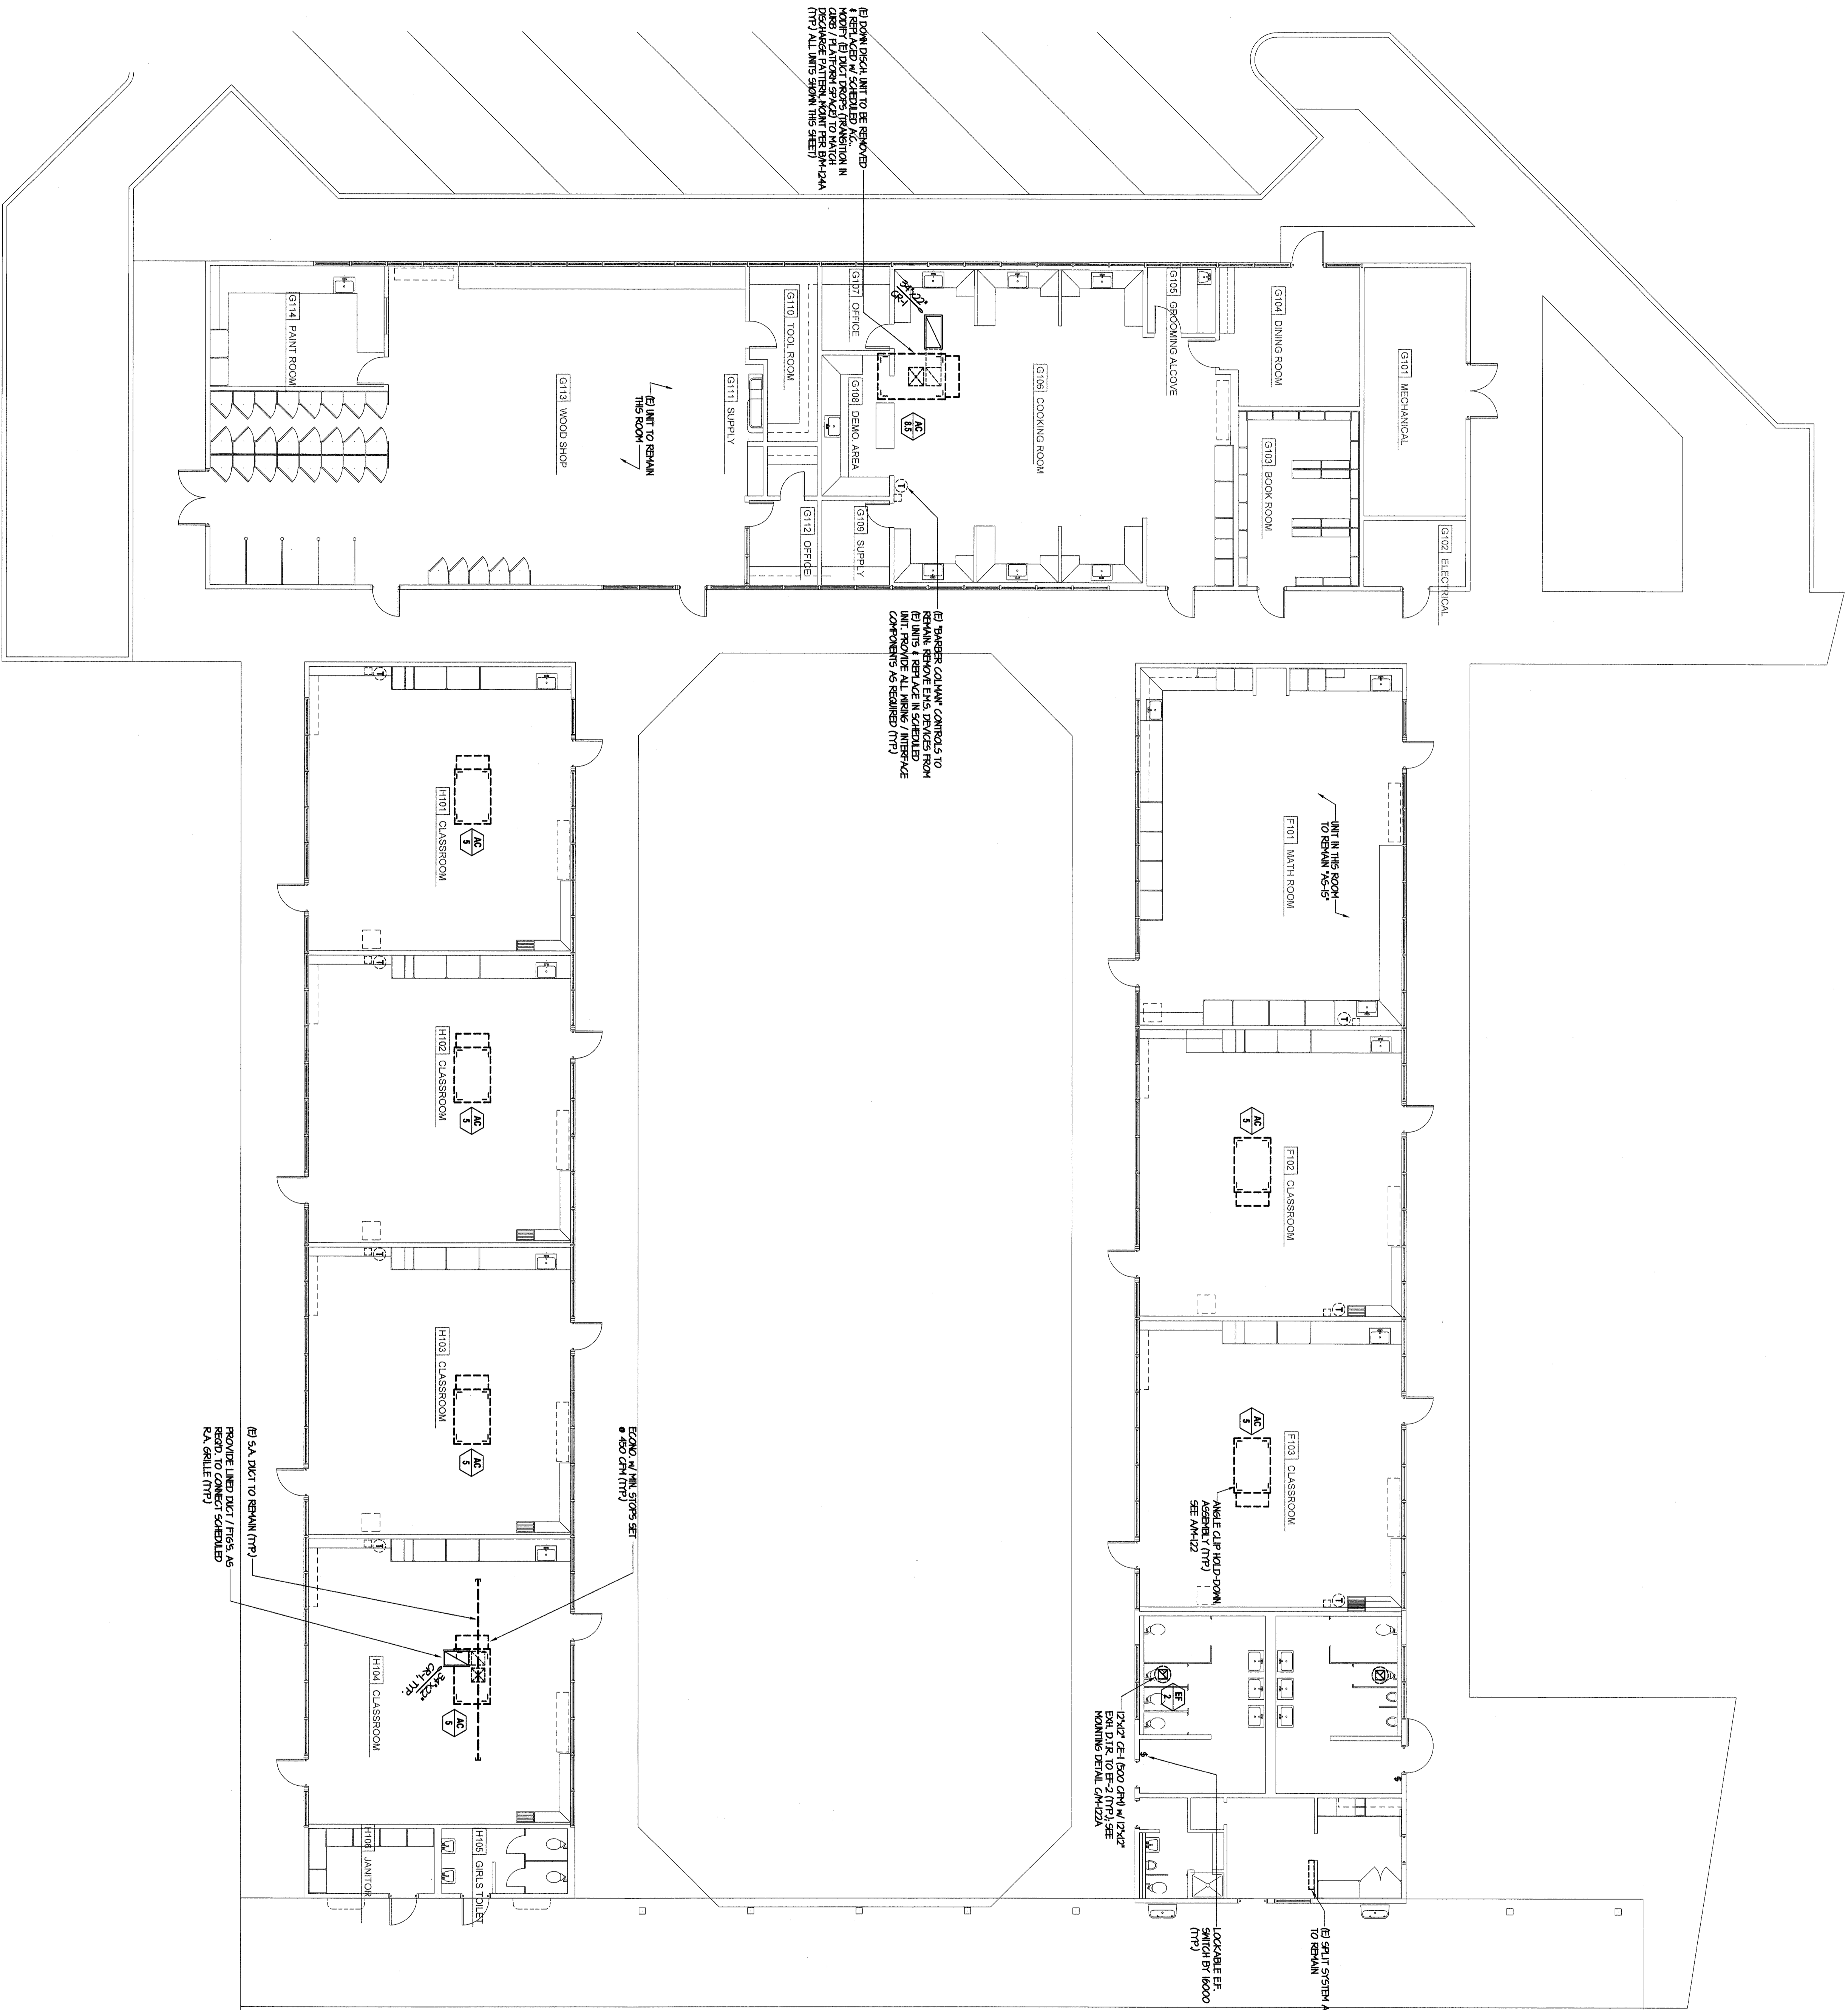

NORTH  
 MECHANICAL FLOOR PLAN - BUILDINGS 'F', 'G' & 'H'  
 SCALE: 1/8"=1'-0"

