




NORTH
PLUMBING PLAN R-1A, R-1B, R-1C & R-1D
 SCALE: 1/8"=1'-0"

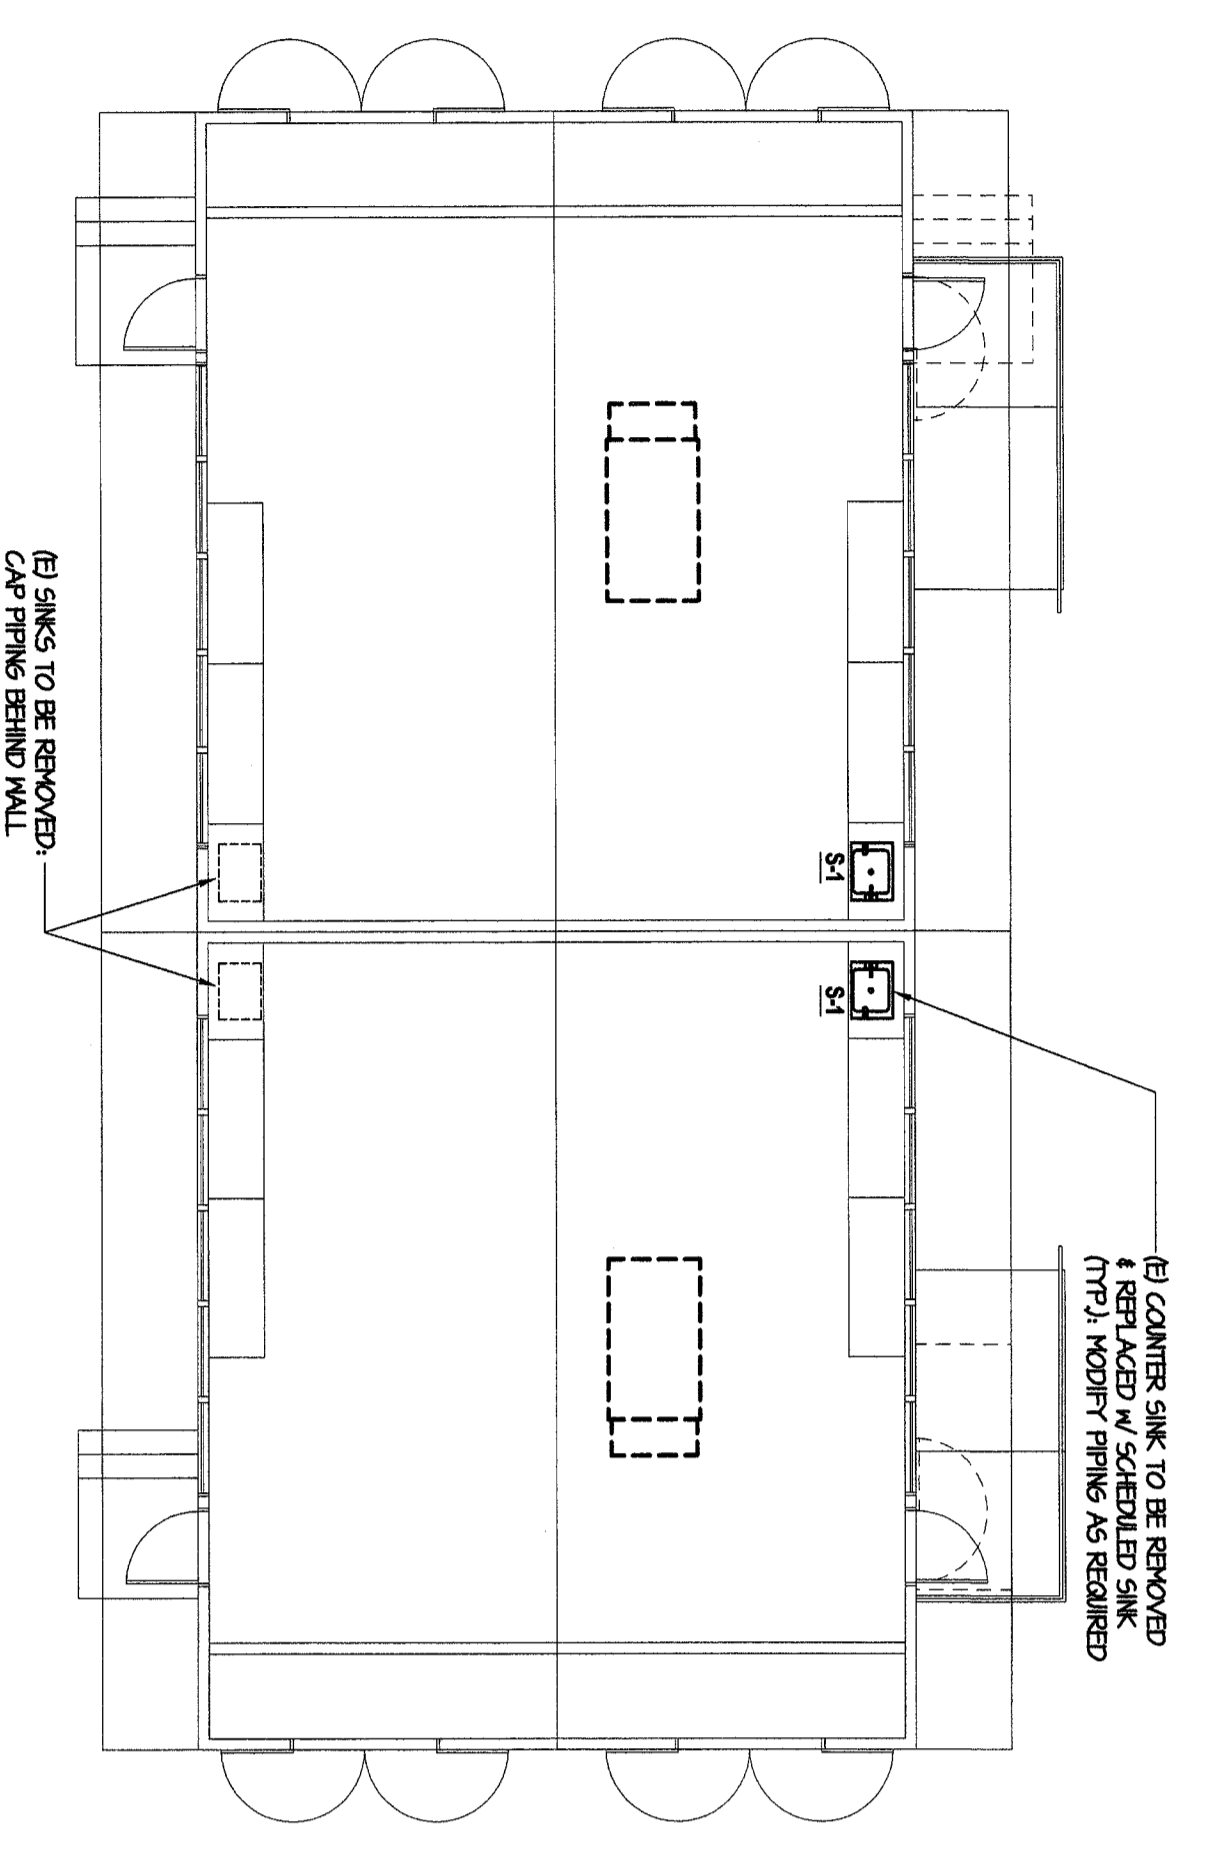

NORTH
PLUMBING PLAN R-7A & R-7B
 SCALE: 1/8"=1'-0"

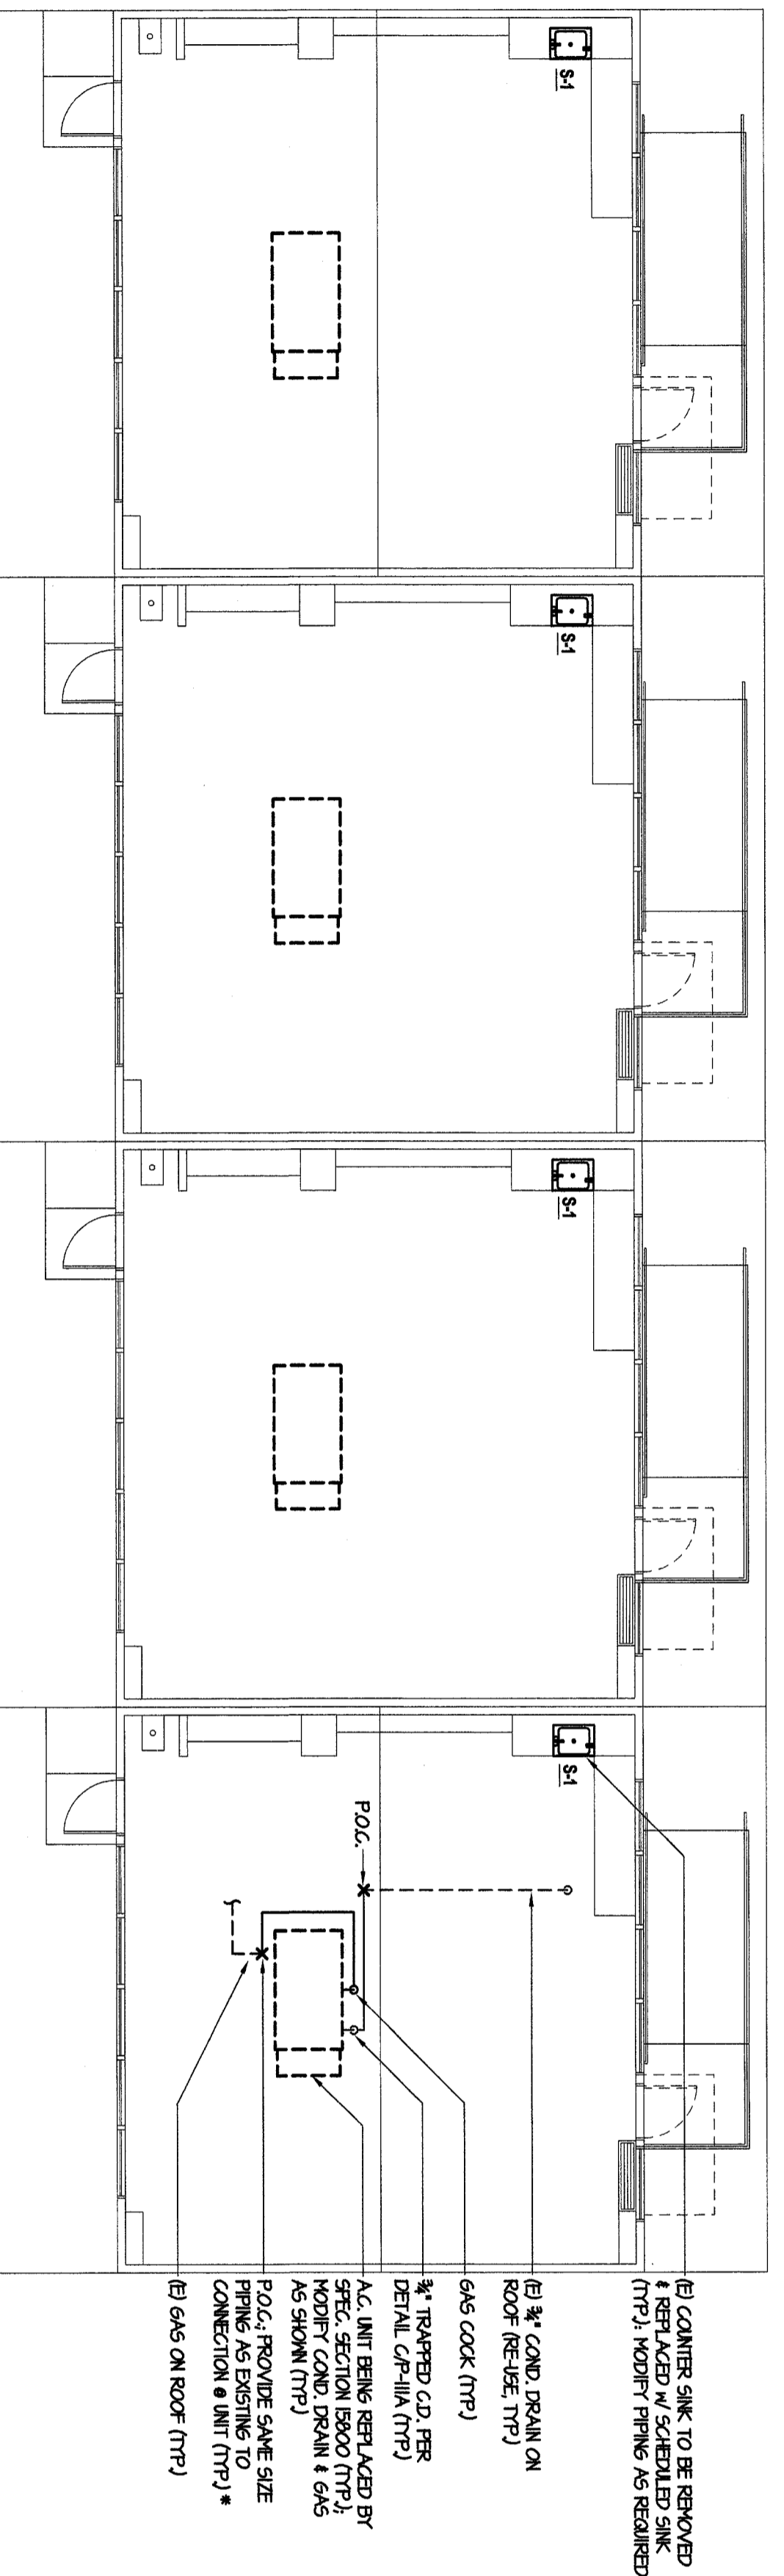

NORTH
PLUMBING PLAN R-6B, R-6C, R-6D & R-6E
 SCALE: 1/8"=1'-0"

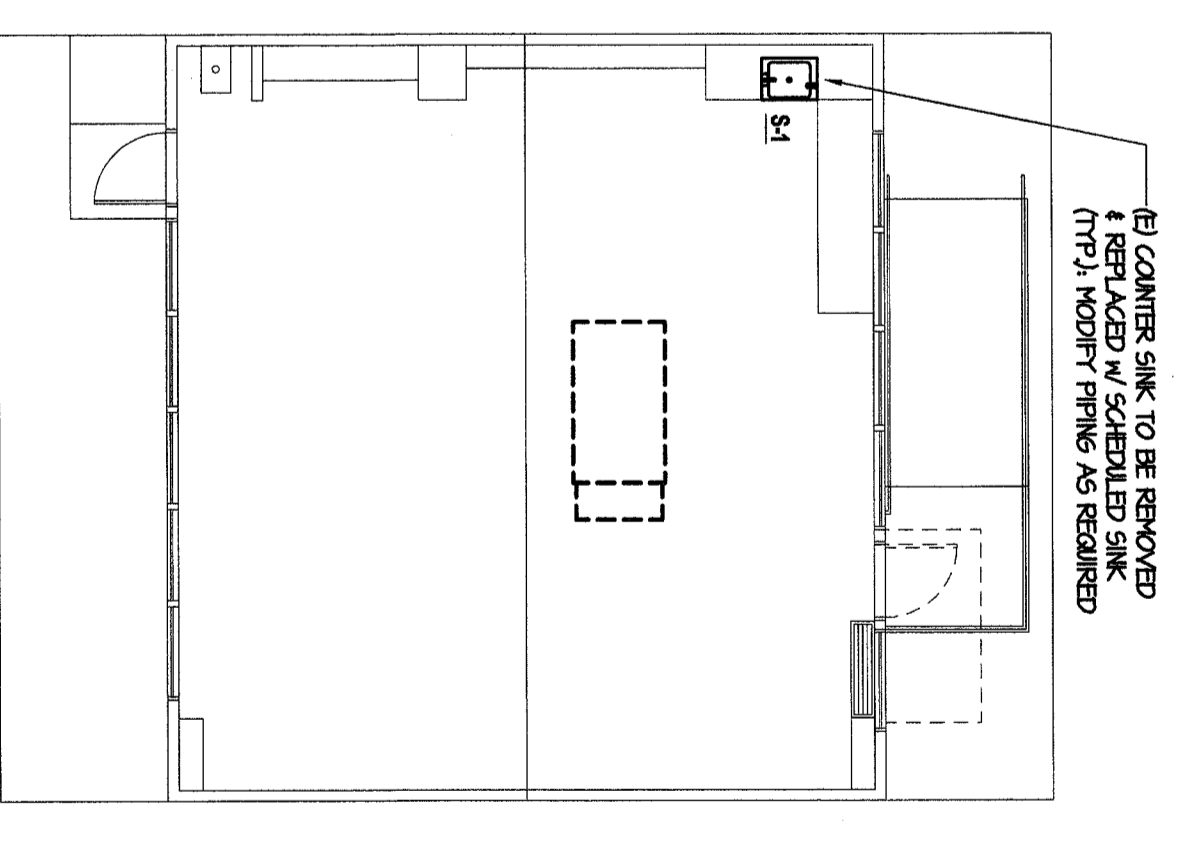


NORTH
PLUMBING PLAN R-3A
 SCALE: 1/8"=1'-0"

NOTE: TYP FOR ALL UNITS THIS SHEET UNLESS NOTED OTHERWISE.

* PAINT EXPOSED BLACK STEEL GAS PIPE ON ROOF W/ 2 COATS OF ROOF PAINTING PRIMER

- 1. SINK TO BE REMOVED & REPLACED W/ SCHEDULED SINK (TYP) MODIFY PIPING AS REQUIRED
- 2. SINKS TO BE REMOVED & REPLACED ON ROOF (RES-USE TYP) 6\"/>

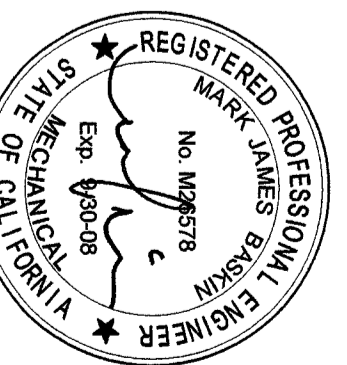

ORDIZ MELBY ARCHITECTS, INC.
 5500 MIKE AVENUE SUITE 280
 BAKERSFIELD, CALIFORNIA 93309
 TELEPHONE (661) 832-5258
 FACSIMILE (661) 832-4291

IDENTIFICATION STAMP
 DIVISION OF THE STATE ARCHITECT
 OFFICE OF REGULATION SERVICES
 APRIL # 03-107003
 FILE # 15-6
 AC FS SS
 DATE

MDDC
 MECHANICAL DESIGN CONSULTANTS
 428 TRuxtun Avenue
 Bakersfield, CA 93301
 Fax # (661) 326-1099
 License Number: 11-1-07

MODERNIZATION FOR
 CURRAN JUNIOR
 HIGH SCHOOL
 FOR:
**BAKERSFIELD
 CITY SCHOOL
 DISTRICT**

1116 LYRIC WAY
 BAKERSFIELD,
 CALIFORNIA
 93309

MARK	DATE	DESCRIPTION
SD		
CD		
△		
△		
△		

CHECK AND VERIFY ALL DIMENSIONS BEFORE
 PROCEEDING WITH THE WORK. ALL
 REVISIONS, DEFS AND DISCREP
 REPRESENTED ON THE SHEET ARE THE
 PROPERTY OF ARCHITECT.
 ORC/MELBY ARCHITECTS, INC. 2000

PLUMBING PLAN RELOS
 R-1A TO R-1D R-3A, R-6B
 TO R-6E, R-7A & R-7B
 SHEET IDENTIFICATION NUMBER
P-125A
 SHEET 6 OF 6