

Bakersfield
5500 Ring Avenue, Suite 450, Bakersfield, CA 93309
661.538.4300
fax 661.538.4311

San Jose
1011
san jose, california 95113
408.264.0841
fax 408.264.0844


San Luis Obispo
4115 Road Street, Suite 3-6
san luis obispo, ca 93401
805.762.8888
fax 805.762.8894

Oakland
300 Frank Ogden Plaza, Suite 300
Oakland, ca 94612
510.881.0070
fax 510.881.0074

Principal Architects
diane s. wilson, aia, c-1890
mark a. gregg, aia, c-1132
brian m. hogan, aia, c-1334
robert l. muller, aia, c-1673
robert l. muller, aia, c-1672
for 825.545.0394



- KEYNOTES**
- NOTE: KEYNOTES IN THIS LIST MAY NOT NECESSARILY OCCUR ON THIS SHEET.
- 201 PROVIDE PLUMBING FIXTURE. REFER TO PLUMBING DRAWINGS.
 - 202 (E) LINE OF ROOF ABOVE.
 - 203 REMOVE PORTION OF (E) CASEWORK. REFER TO DETAIL 24/A10.01.
 - 204 REMOVE PORTION OF (E) CASEWORK. REFER TO DETAIL 24/A10.02.
 - 205 PROVIDE CASEWORK. REFER TO INTERIOR ELEVATIONS FOR EXTENTS.
 - 206 REMOVE (E) COUNTERTOP SHOWN HATCHED. REFER TO INTERIOR ELEVATIONS.
 - 207 PROVIDE COUNTERTOP SHOWN HATCHED. REFER TO INTERIOR ELEVATIONS.
 - 208 REMOVE (E) COUNTERTOP SHOWN HATCHED. REFER TO INTERIOR ELEVATIONS.
 - 209 PROVIDE TOILET PARTITION. REFER TO DETAILS 12/A10.02 & 18/A10.02.
 - 210 PROVIDE TOILET PARTITION. REFER TO DETAILS 12/A10.02 & 18/A10.02.
 - 211 REMOVE (E) WALKWAY.
 - 212 REPAIR ALL (E) WINDOWS AT THIS BUILDING.
 - 213 REMOVE (E) WINDOWS, PROVIDE PARTIAL INFL PER INTERIOR ELEVATIONS. PATCH AND REPAIR EXTERIOR PLASTER AROUND WINDOWS TO MATCH (E) WALL.
 - 214 PROVIDE WOOD FRAME/ EXTERIOR FINISH BELOW INSTALLATION OF WINDOWS TO MATCH (E) WALL.
 - 215 REPLACE HANDRAIL REFER TO 2/A3.11 FOR DIMENSIONS.
 - 216 PATCH AND REPAIR (E) TILE FLOOR TO MATCH (E) ADJACENT WHERE REMODEL OCCURS.
 - 217 (E) ADA COMPLIANT FRAME TO REMAIN.
 - 218 REMOVE (E) OBSERVATION WINDOW AND INFL OPENING.
 - 219 (E) FIRE EXTINGUISHER/CABINET TO REMAIN.
 - 220 REMOVE (E) OBSERVATION WINDOW AND INFL OPENING, PATCH & REPAIR TO MATCH THE ADJACENT WALL.
 - 221 PROVIDE PORTABLE ASSISTIVE LISTENING DEVICE.
 - 222 REFER TO DETAIL 22/A10.03.
 - 223 REMOVE (E) PORTABLE ASSISTIVE LISTENING DEVICE.
 - 224 PROVIDE 2" CONTRASTING COLORSTRIP AT TOP AND BOTTOM TREAD.
 - 225 PROVIDE 2" CONTRASTING COLORSTRIP AT EACH TREAD.
 - 226 PROVIDE 2" CONTRASTING COLORSTRIP AT EACH TREAD.
 - 227 PROVIDE 2" CONTRASTING COLORSTRIP AT EACH TREAD.
 - 300 PROVIDE 2" CONTRASTING COLORSTRIP AT EACH TREAD.

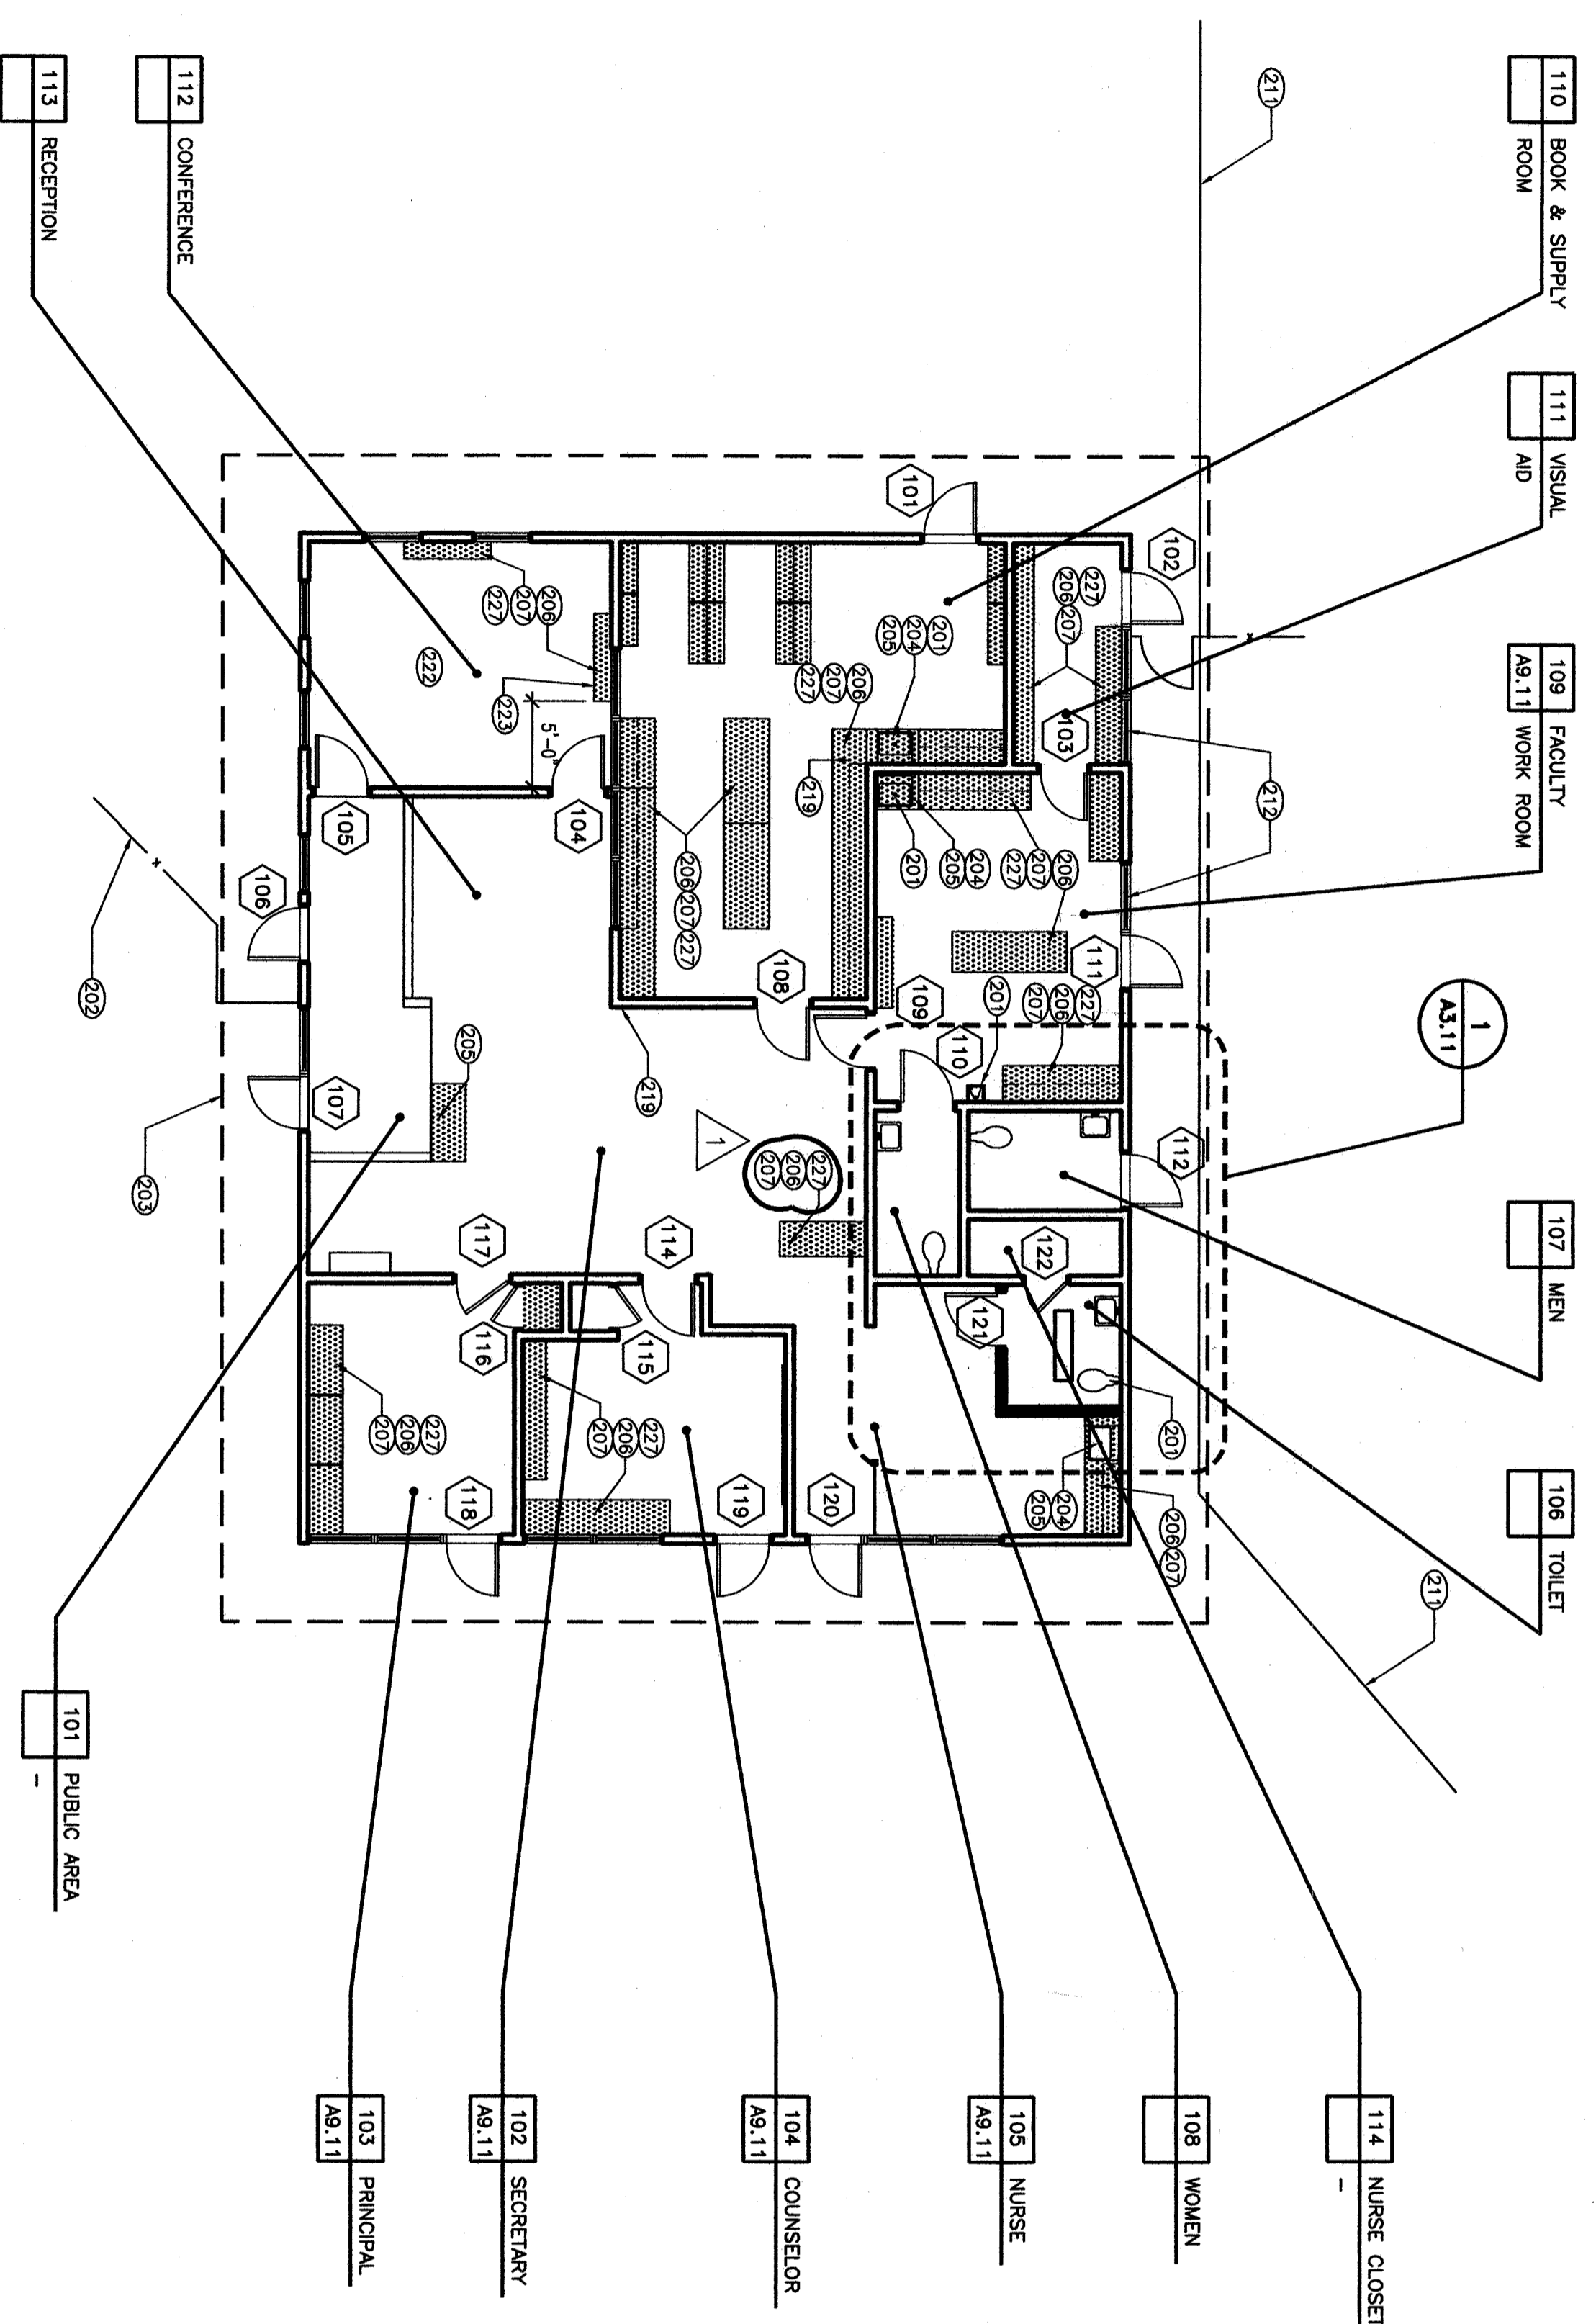


BUILDING 100 FLOOR PLAN

PLAN LEGEND

- NOTE: ALL SYMBOLS AND PATTERNS MAY NOT NECESSARILY OCCUR ON THIS SHEET.
- 2x STUD WALL / INFL WALL. SEE KEYNOTES FOR REMODEL AND REPAIR. REFER TO SPT. A10.01 FOR WALL TYPES (REFER TO DET. 27/A10.01 FOR INFL OF (E) WALL OPENING).
 - 60-INCH ACCESSIBLE FLOOR SPACE LOCATION
 - 32-INCH X 48-INCH ACCESSIBLE FLOOR SPACE LOCATION
 - ONE HOUR WALL W/90 MIN. RATED OPENINGS PER CBC SEC. 702.3 (OCCUPANCY SEPARATION)
 - EXITS

KEY PLAN

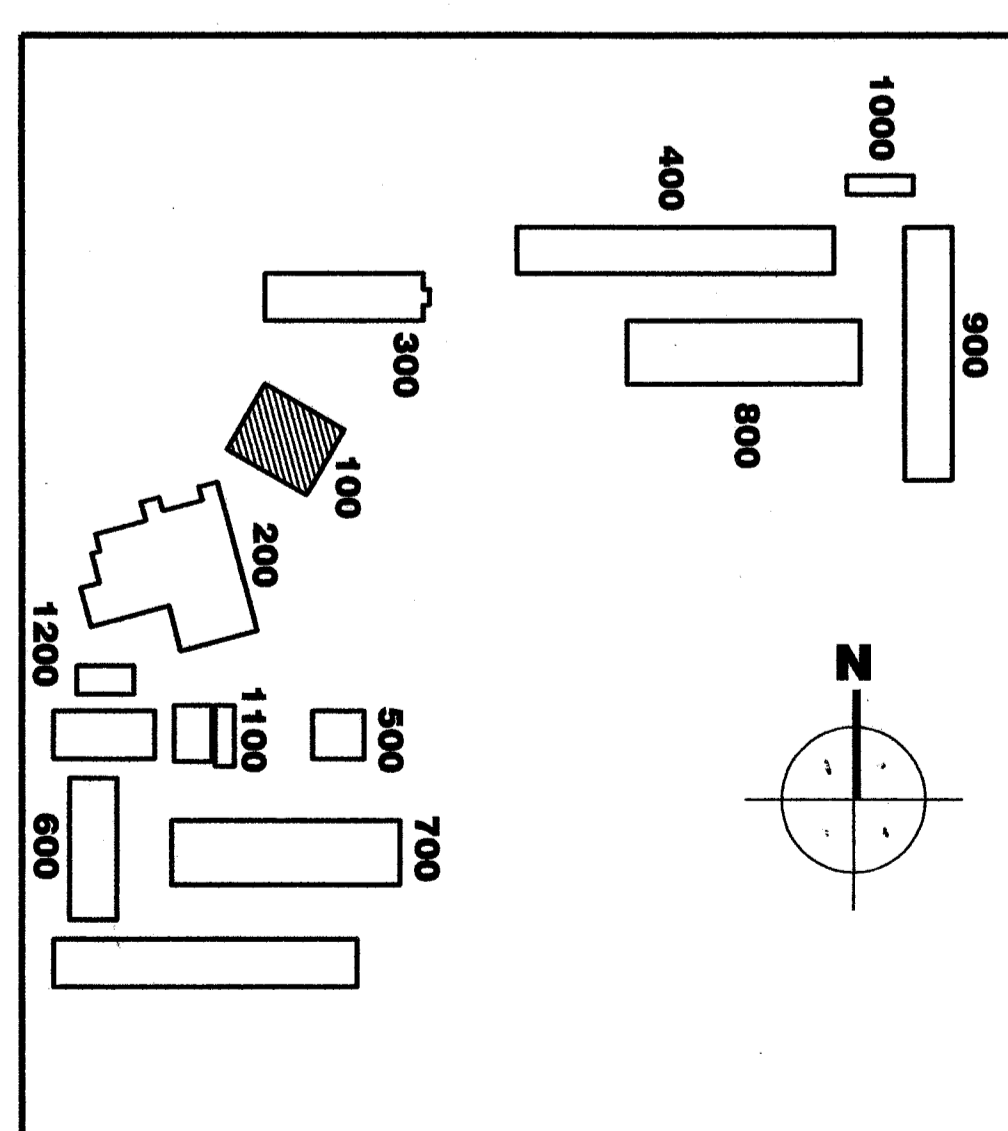

REV. NO.	REV. DATE:	REVISION:
1	5-14-07	OWNER REVISION
2		
3		
4		
5		

FILE NO. 15-6
DWG. OF THE FINAL STUDY
DATE 03-28-03
AC-1132
R.L.S. SS

MODERNIZATION
FOR
HENRY ESSLER SCHOOL
2901 ESSLER STREET
BAKERSFIELD, CA 93306

BAKERSFIELD CITY
SCHOOL DISTRICT

BUILDING 100 FLOOR PLAN

Version Date: 02-17-03
Job no.: 6-24-03
date: 6-24-03
drawn by: D.HERBERA
chk'd by: R.TROST
©Copyright 2003