

**Bakersfield**  
5500 mirza avenue, suite 450, bakersfield, ca 93309  
661.836.4200 fax 661.836.4311

**San Jose**  
150 south first st., suite 200  
san jose, california 95113  
for 408.924.0844

**San Luis Obispo**  
201 lajolla square, suite 5340  
san luis obispo, ca 93401  
for 805.946.0094

**Oakland**  
300 frank square plaza, suite 300  
oakland, california 94612  
for 510.510.0574

**Principal Architect**  
James W. Gierman, P.E., C-2136  
James W. Gierman, P.E., C-2136  
James W. Gierman, P.E., C-2136  
James W. Gierman, P.E., C-2136  
James W. Gierman, P.E., C-2136

**INTERSTATE ENGINEERING**  
4660 W. 14th Street, Suite 106  
Tulsa, Oklahoma 74116  
(918) 432-4800 / (505) 438-8424 fax  
www.interstateeng.com



James W. Gierman, Electrical Engineer  
ET #9101

rev. no. \_\_\_\_\_ rev. date: \_\_\_\_\_ revision: \_\_\_\_\_

**KEYNOTES**

- 1 INSTALL WIREMOLD # 5400 WITH OUTLETS AT 30" O.C. COORDINATE MTD. HEIGHT WITH ARCHITECT'S ELEVATIONS.
- 2 REPLACE EXISTING EXTERIOR DOWNLIGHT. USE RETROFIT MIT FUTURE TYPE "T".
- 3 REPLACE EXISTING WALL BRACKET FIXTURE. USE FIXTURE TYPE "G".
- 4 REPLACE EXISTING FIXTURES. USE FIXTURES TYPE "C1".
- 5 DISCONNECT AND REMOVE EXISTING 2-4 SURFACE METAL SIDED FIXTURES. REUSE (E) HOME RUN AS APPLICABLE.
- 6 REPLACE EXISTING FIXTURE WITH NEW FIXTURE TYPE "D". EXISTING FIXTURE TO REMAIN.
- 7 EXISTING 2-4 SURFACE METAL SIDED FIXTURES WITH (2) 40W T-12 LAMPS. REPLACE LAMPS WITH (2) 18 LAMPS. EXISTING BALLASTS TO REMAIN. REPLACE LENS WITH KSH K12.125 ACRYLIC LENS.
- 8 DISCONNECT AND REMOVE EXISTING FIXTURES.
- 9 WIREMOLD # 5400 RISER UP TO CEILING.
- 10 REPLACE (E) PANEL, "A". NEW PANEL SHALL HAVE (42) 20/1 BREAKERS, 100A BUS. USE SQUARE "D" MOOD(B) OR EQUAL, RECONNECT (E) CIRCUITS AND FEEDER.

NOT ALL KEYNOTES APPLY TO THIS SHEET.

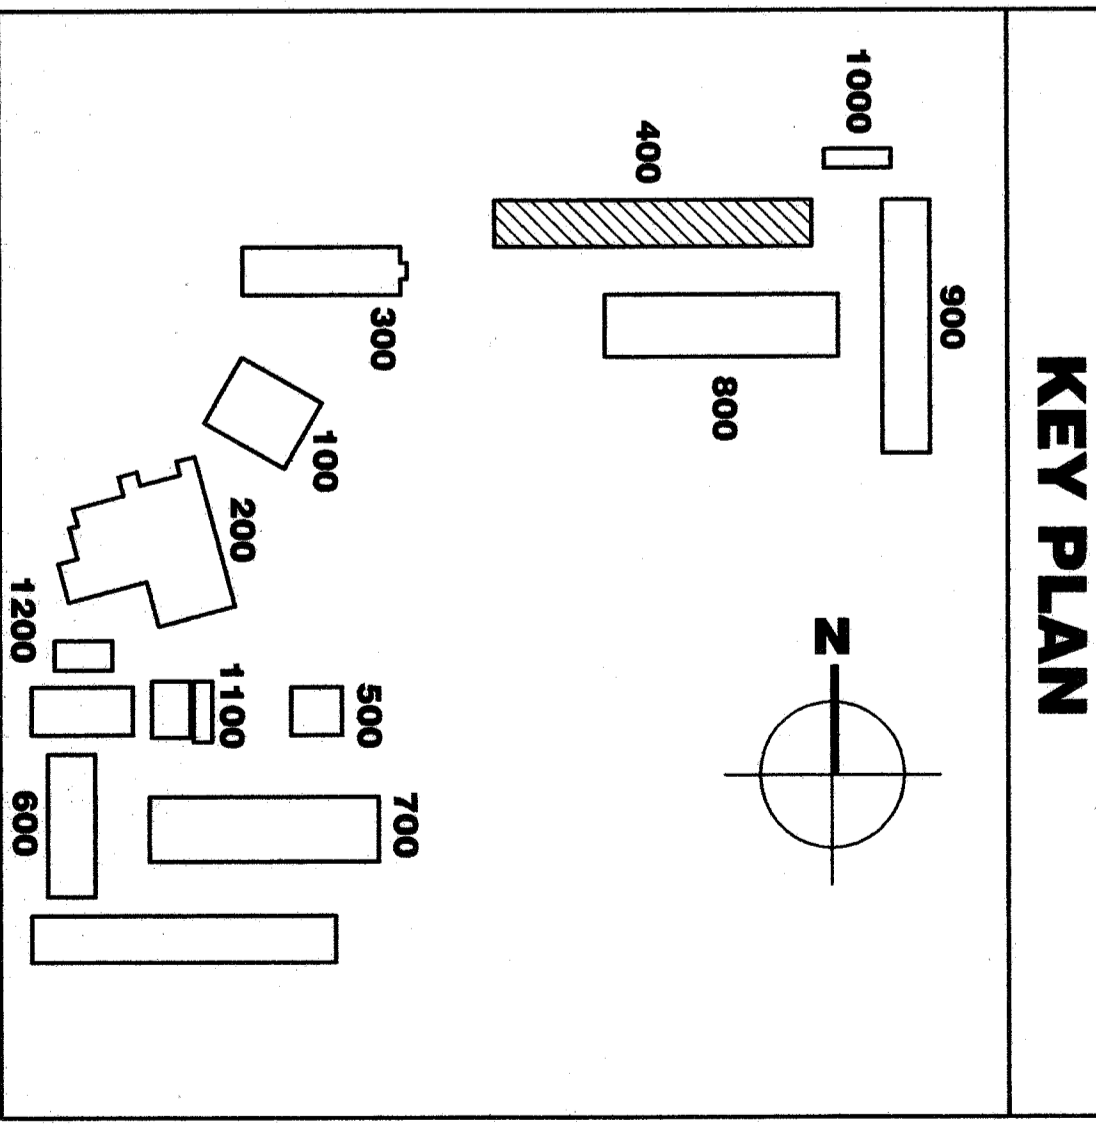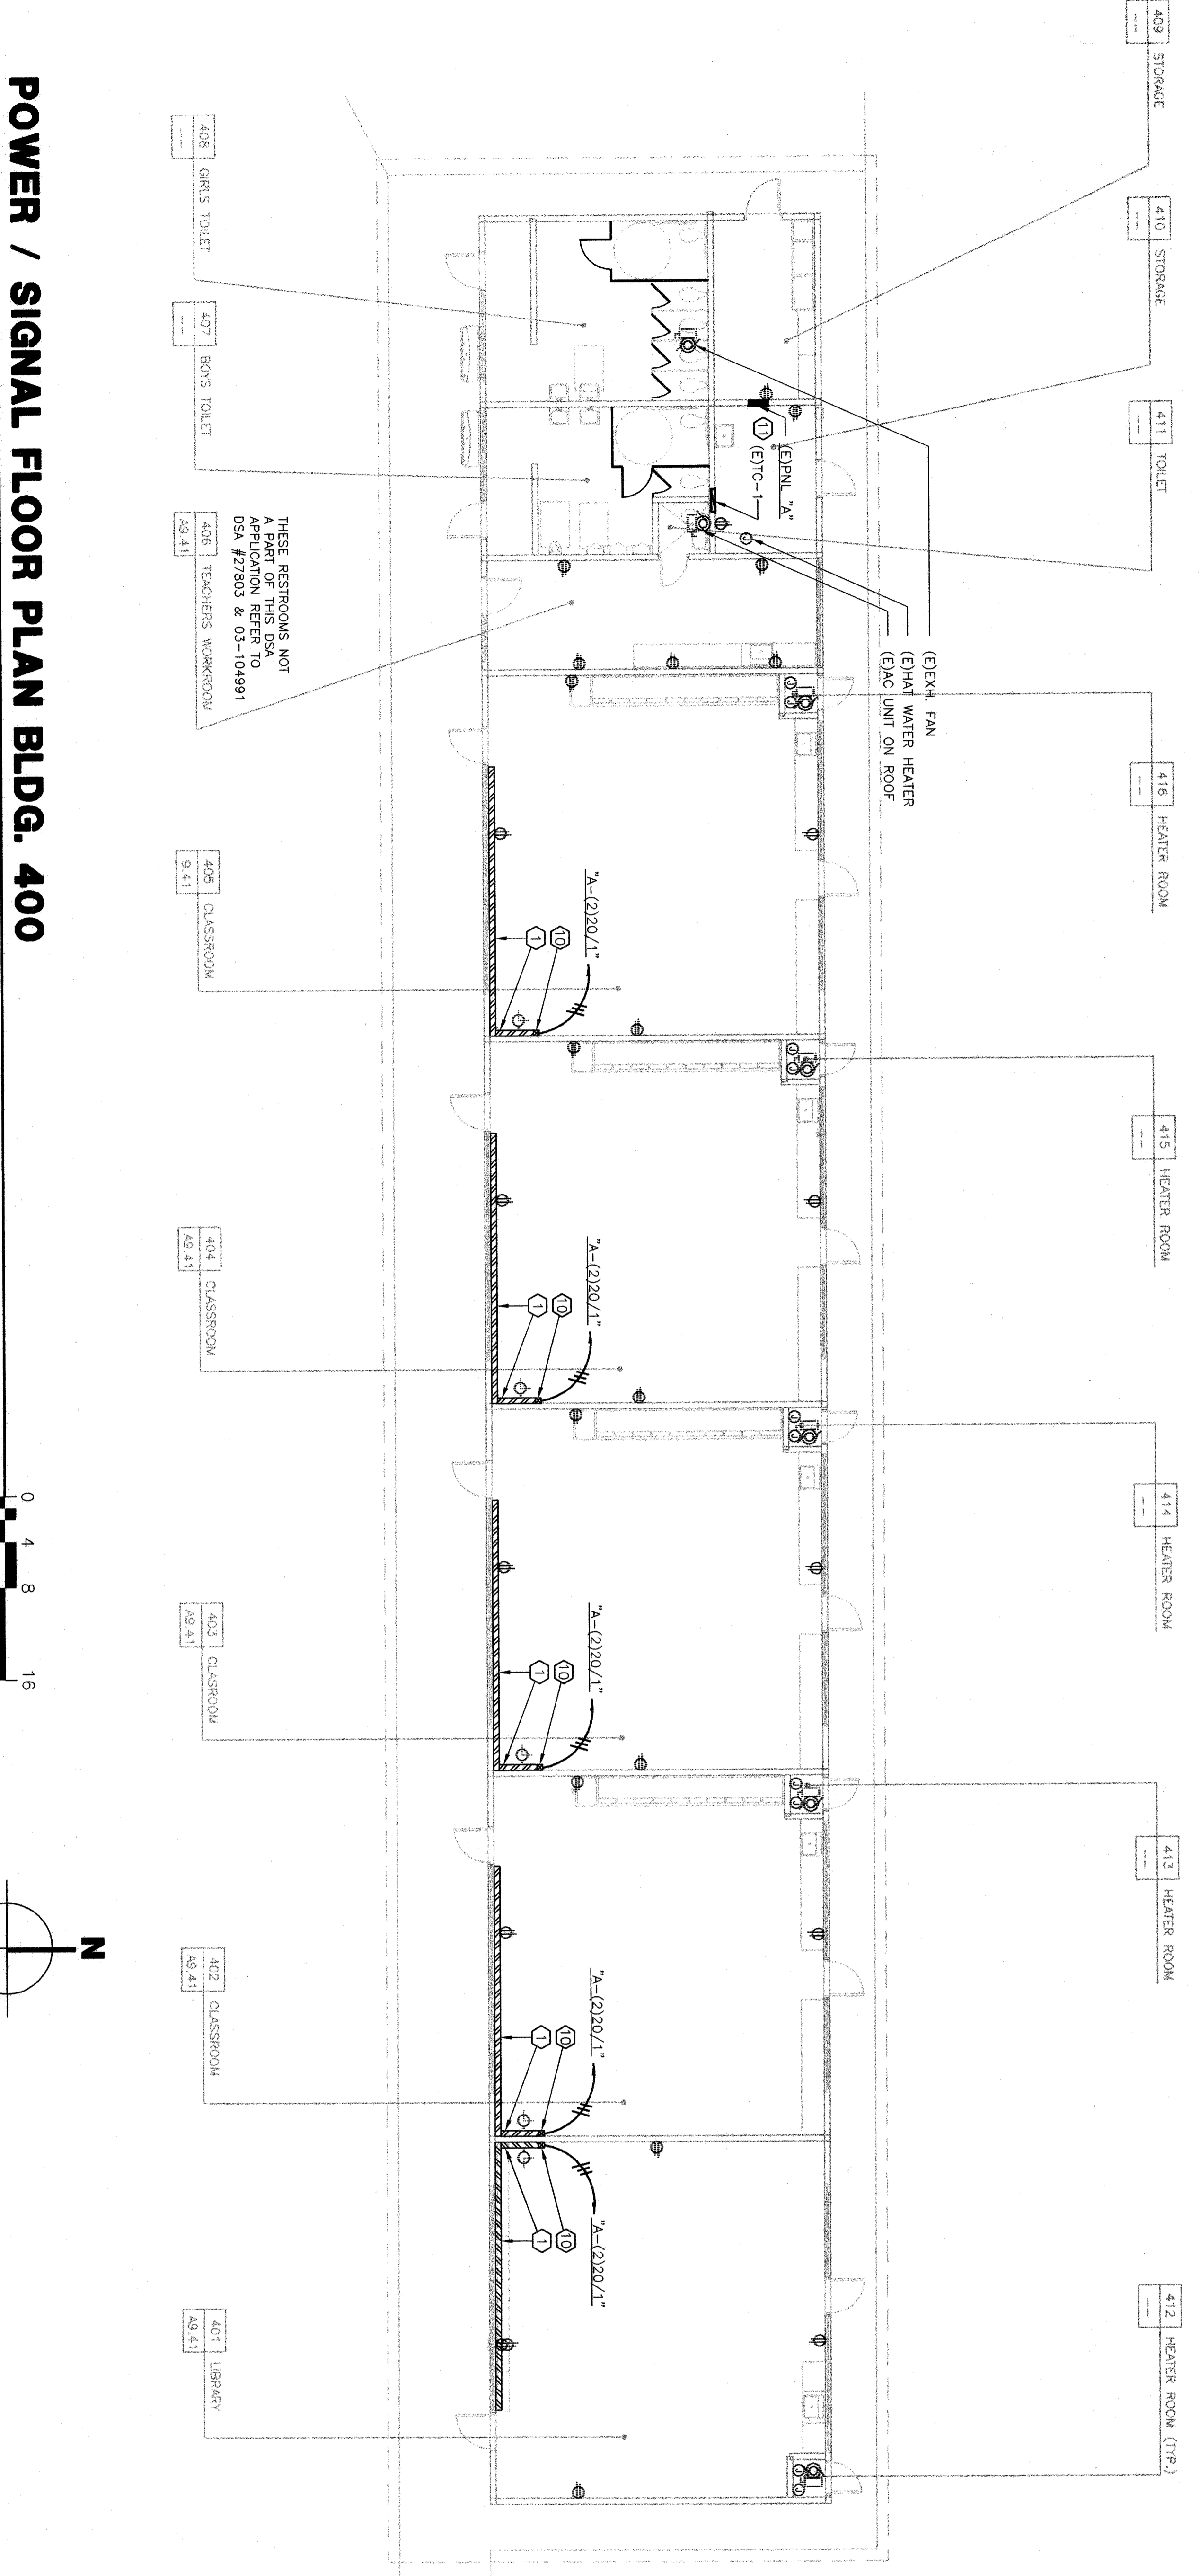

- Item (13) Refer to Electrical Drawings, Sheet E2-22 - Building 400, Power and Signal.
- a. DELETE two compartment Wiremold and all related wiring in Room 401.
  - b. Refer to Keynote 11, PROVIDE panel with 225 Amp bus and 1500 main breaker.

**MODERNIZATION**

FOR

**HENRY ESSLER SCHOOL**  
2901 ESSLER STREET  
BAKERSFIELD, CA 93306

**BAKERSFIELD CITY SCHOOL DISTRICT**

**BUILDING 400 POWER / SIGNAL FLOOR PLAN**

Version Date: 02-125

job no. 06/24/03

date 06/24/03

drawn by T.V.A.

chk'd by D.P.C.

©copyright 2003

Version time: **2.142**

AGENCY TRACKING NO: \_\_\_\_\_

FILE NO.: 15-6

IDENTIFICATION STAMP  
DIV. OF THE STATE ARCHITECT  
PART NO. 03-106663  
DATE 06-24-03