




ADMIN FLOOR PLAN - LIGHTING LAYOUT  
SCALE: 1/8" = 1'-0"

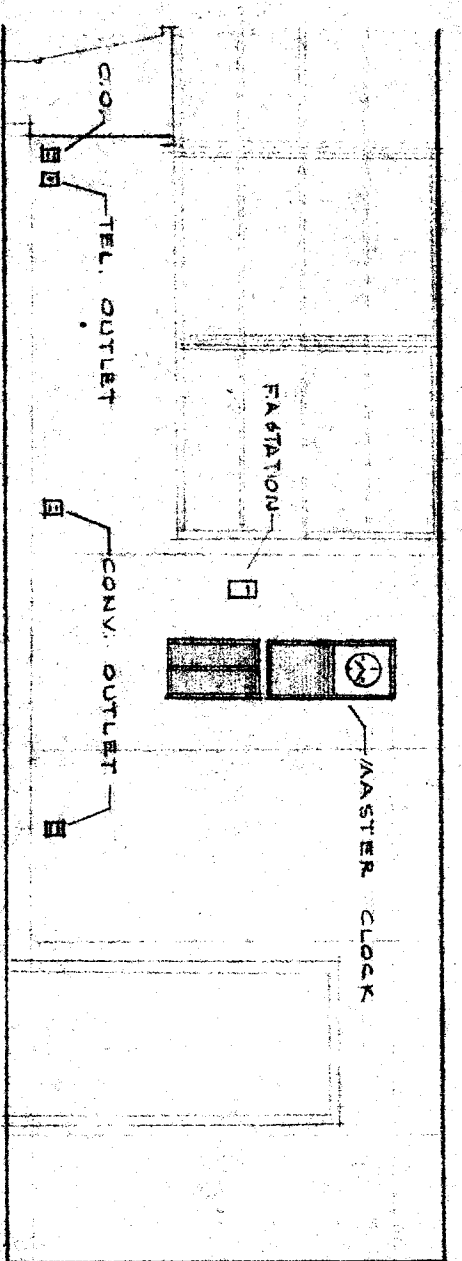

WEST ELEVATION SECRETARY B-2  
SCALE: 1/4" = 1'-0"

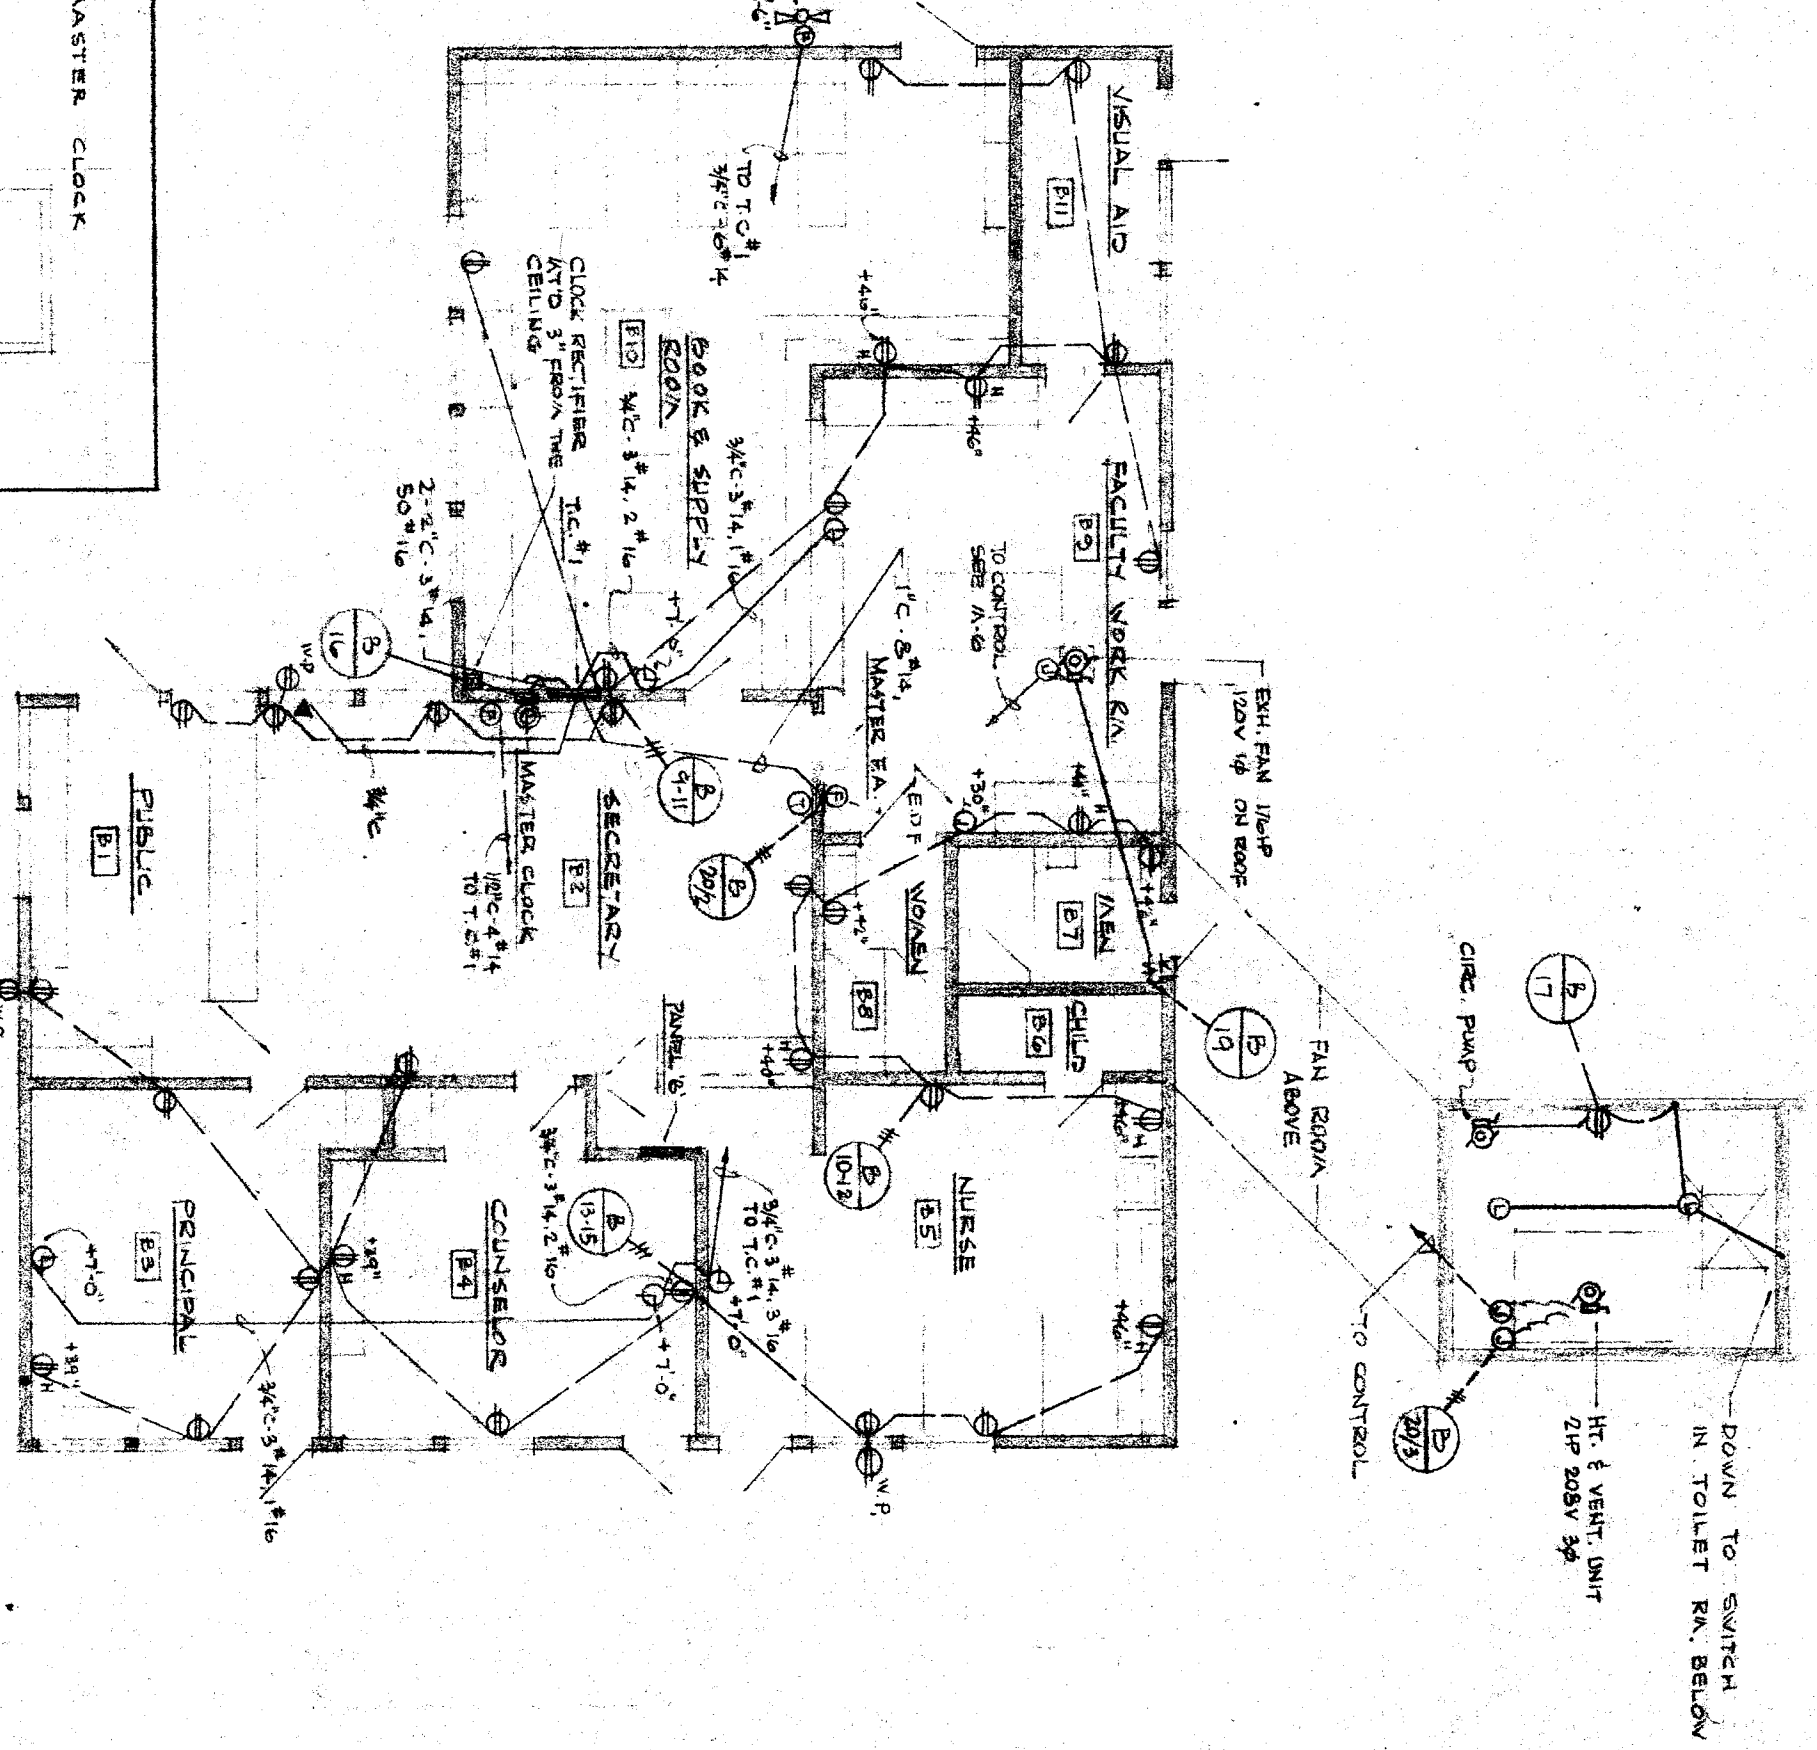

POWER & SIGNAL LAYOUT

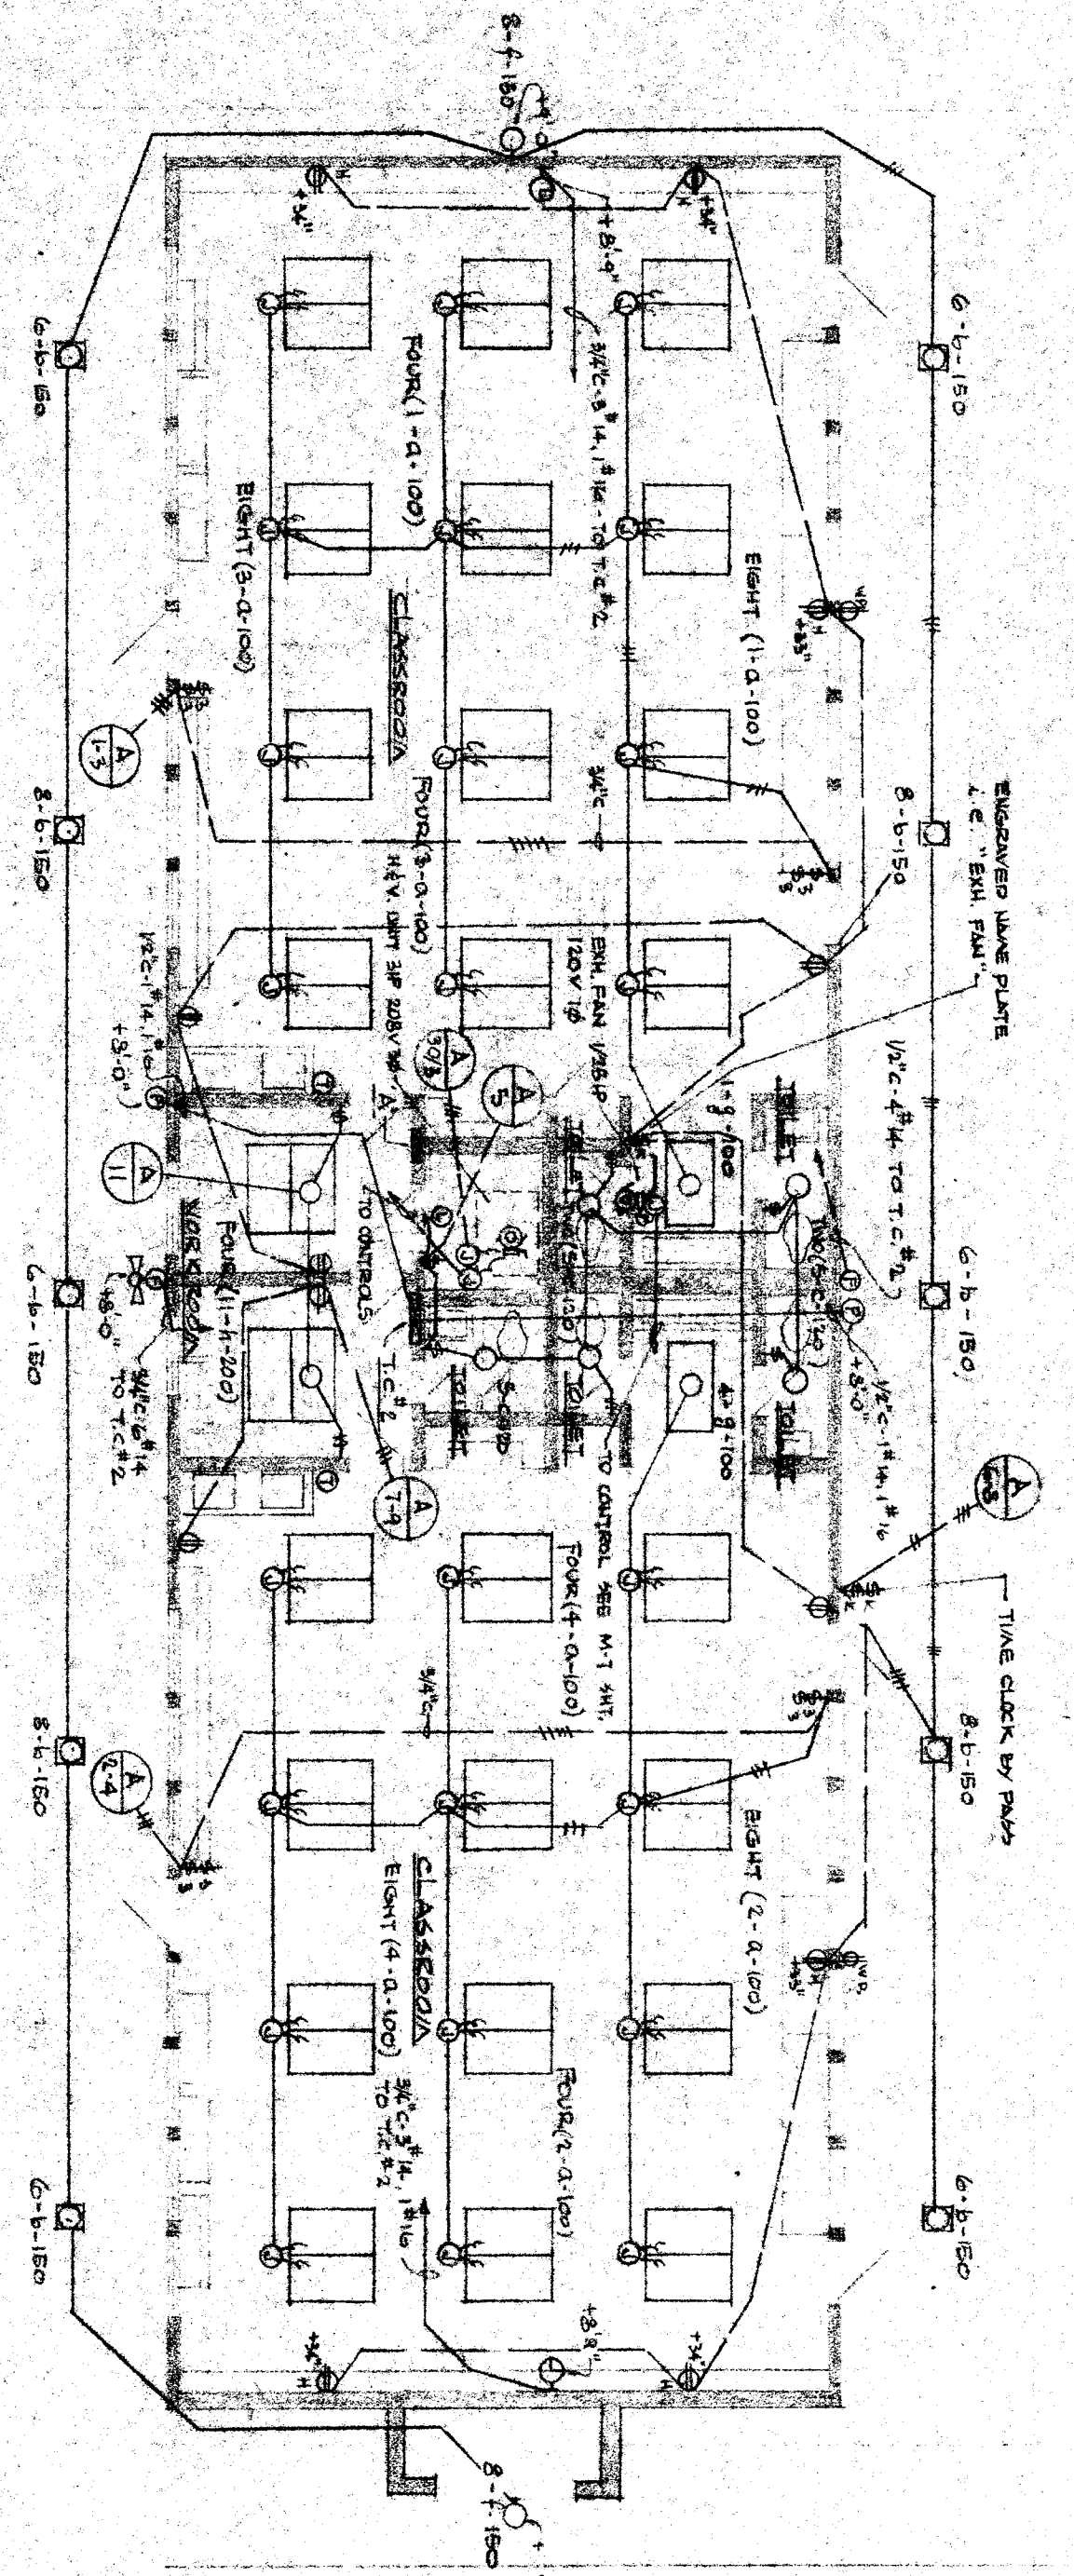

FLOOR PLAN - ELECTRICAL LAYOUT  
SCALE: 3/16" = 1'-0"

**PANEL 'A' SCHEDULE**

CIRCUIT NO.	WATTS	CIRCUIT DESCRIPTION
1	1500	LIGHTS
2	1500	LIGHTS
3	1500	LIGHTS
100	1500	LIGHTS
TOTAL	150000	

**PANEL 'B' SCHEDULE**

CIRCUIT NO.	WATTS	CIRCUIT DESCRIPTION
1	1500	LIGHTS
2	1500	LIGHTS
3	1500	LIGHTS
100	1500	LIGHTS
TOTAL	150000	

**PANEL 'C' SCHEDULE**

CIRCUIT NO.	WATTS	CIRCUIT DESCRIPTION
1	1500	LIGHTS
2	1500	LIGHTS
3	1500	LIGHTS
100	1500	LIGHTS
TOTAL	150000	

STATE OF CALIFORNIA  
STATE FIRE MARSHAL  
APPROVED UNDER STATUTES OF CALIFORNIA

REPORT AND DISSEMINATION TO THE ARCHITECT

25099 APPROVED OCT 8 1934

SECTION K SCHOOL  
HENRY EIBLER ELEM. SCHOOL  
CALIFORNIA

E.2