




PLUMBING FLOOR PLAN - KINDERGARTEN  
SCALE 1/8" = 1'-0"

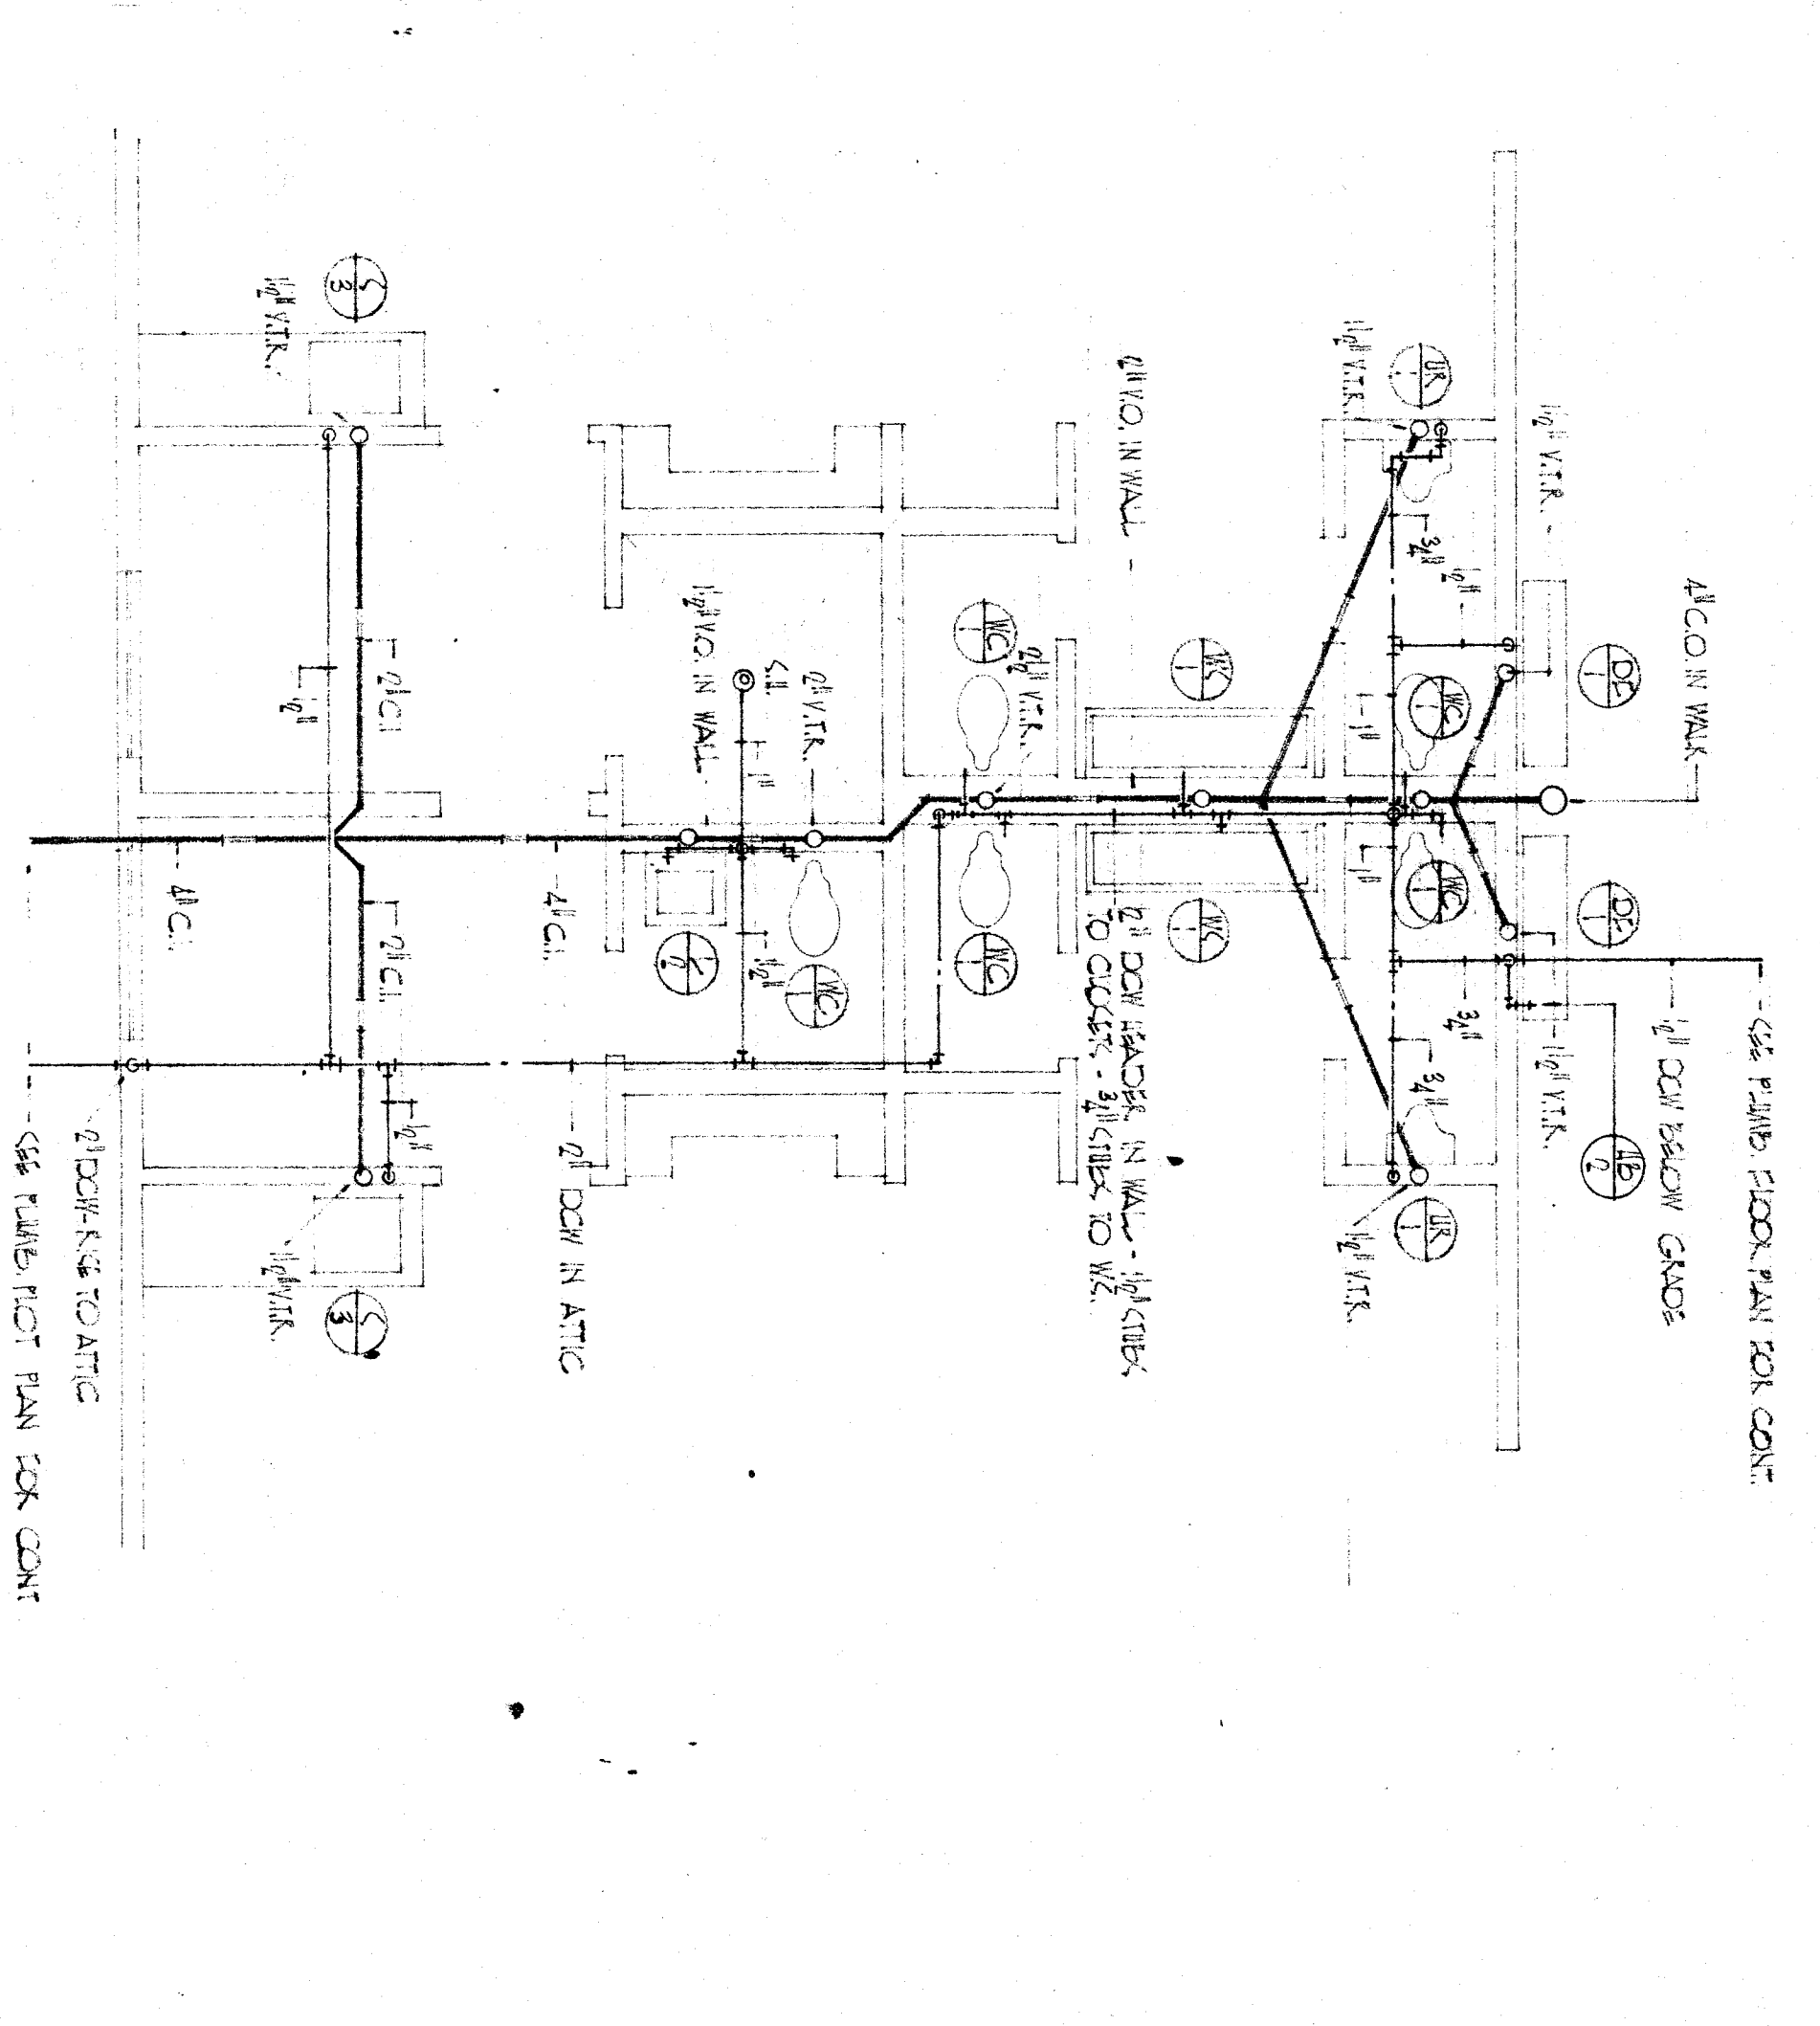

PLUMBING PART FLOOR PLAN - KINDERGARTEN  
SCALE 1/8" = 1'-0"

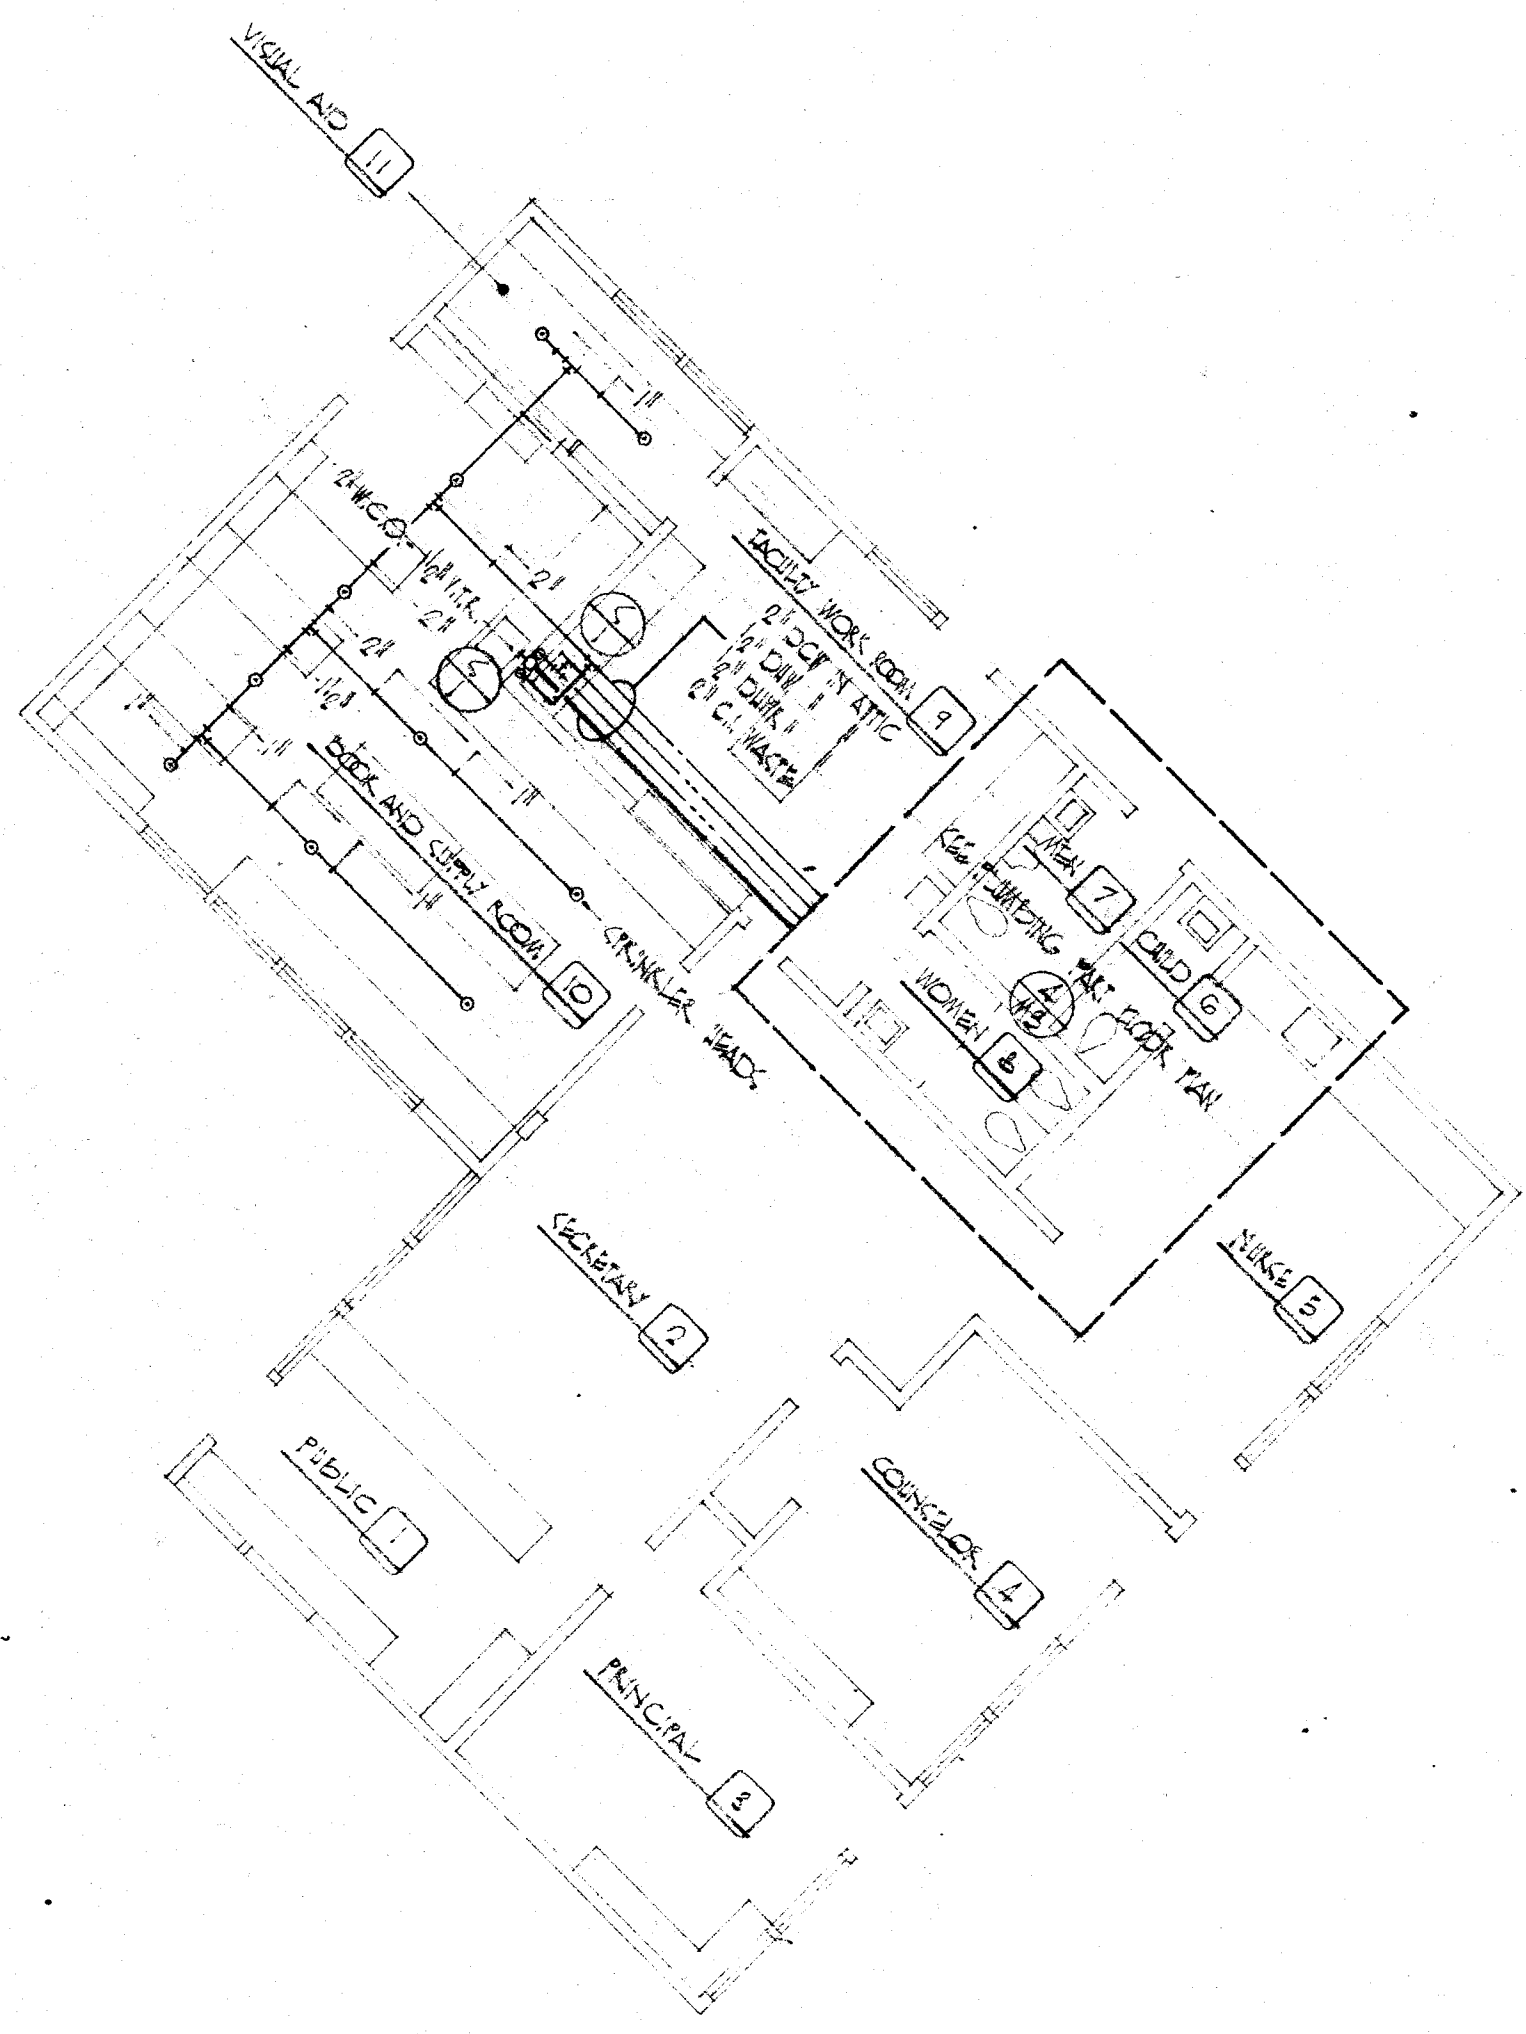

PLUMBING FLOOR PLAN - ADMINISTRATION  
SCALE 1/8" = 1'-0"

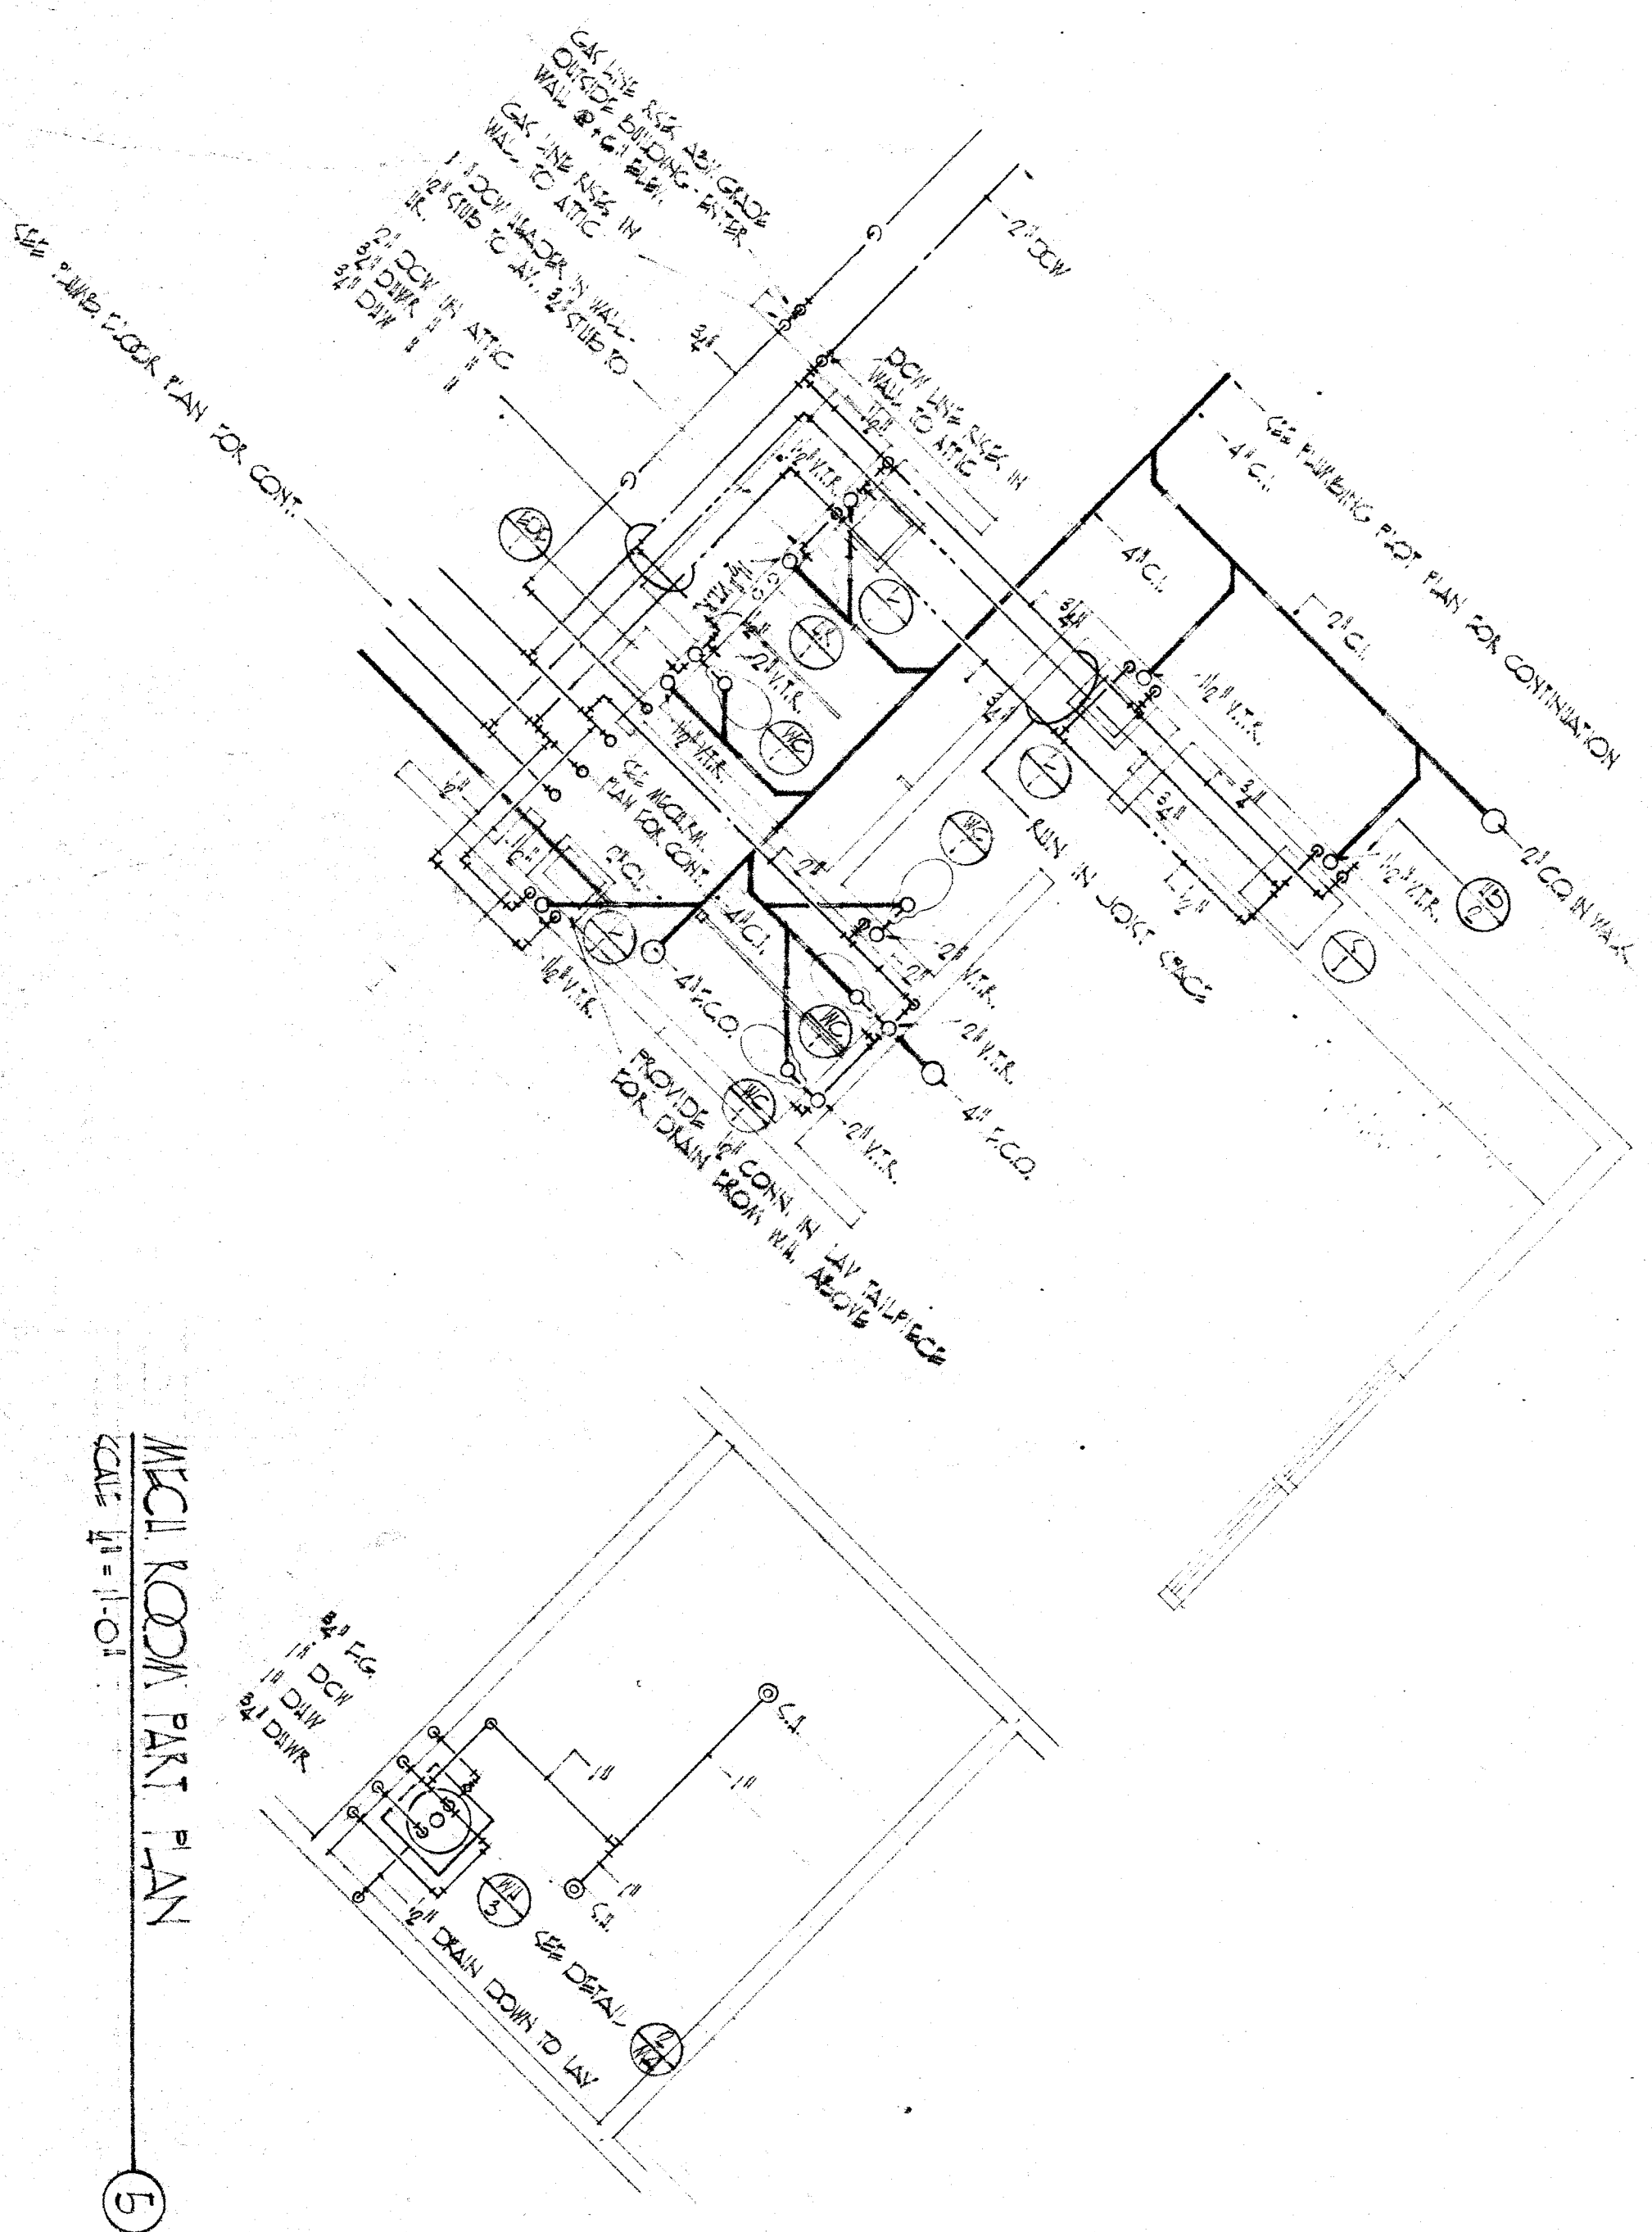

PLUMBING PART FLOOR PLAN - ADMINISTRATION  
SCALE 1/8" = 1'-0"

CHECK AND VERIFY ALL DIMENSIONS AND CONDITIONS AT JOB SITE BEFORE PROCEEDING WITH THE WORK.		REPORT ANY DISCREPANCIES TO THE ARCHITECT.		DRAWN		CHECKED		APPROVED - DATE		JOB NO. 63-17	
REVISIONS		STATE OF CALIFORNIA		DRAWN		CHECKED		APPROVED - DATE		JOB NO. 63-17	
BY	DATE	STATE FIRE MARSHAL		DRAWN		CHECKED		APPROVED - DATE		JOB NO. 63-17	
AS BUILT		APPROVED UNDER STATUTE OF CALIFORNIA		DRAWN		CHECKED		APPROVED - DATE		JOB NO. 63-17	
CHANGE ORDER		BY		DRAWN		CHECKED		APPROVED - DATE		JOB NO. 63-17	
CLASSIFICATION		BY		DRAWN		CHECKED		APPROVED - DATE		JOB NO. 63-17	
		5 09 9		DRAWN		CHECKED		APPROVED - DATE		JOB NO. 63-17	
		S. M. M.		DRAWN		CHECKED		APPROVED - DATE		JOB NO. 63-17	
		ERNEST L. MCCOY A.I.A. ARCHITECT		DRAWN		CHECKED		APPROVED - DATE		JOB NO. 63-17	
		HENRY EISENLEZ ELEMENTARY SCHOOL		DRAWN		CHECKED		APPROVED - DATE		JOB NO. 63-17	
		BAKERFIELD CITY SCHOOL DISTRICT		DRAWN		CHECKED		APPROVED - DATE		JOB NO. 63-17	
		BAKERFIELD, CALIFORNIA		DRAWN		CHECKED		APPROVED - DATE		JOB NO. 63-17	