


ADMINISTRATION CONTROL DIAGRAM  
NO SCALE

- GENERAL NOTES:
1. PROVIDE ACCESS TO ALL FIRE DAMPERS
  2. WELD ALL GYPSUM AND GYPSUM AIR DAMPERS IN PLACE WITH PERFORATED INSULATION SET STRIPS FOR SEAL AND TENSILE
  3. INDICATE COST TO BE LINED SEE SPEC FOR SIZE AND DENSITY SEE DRAWING TO BE WITH INSIDE LINING

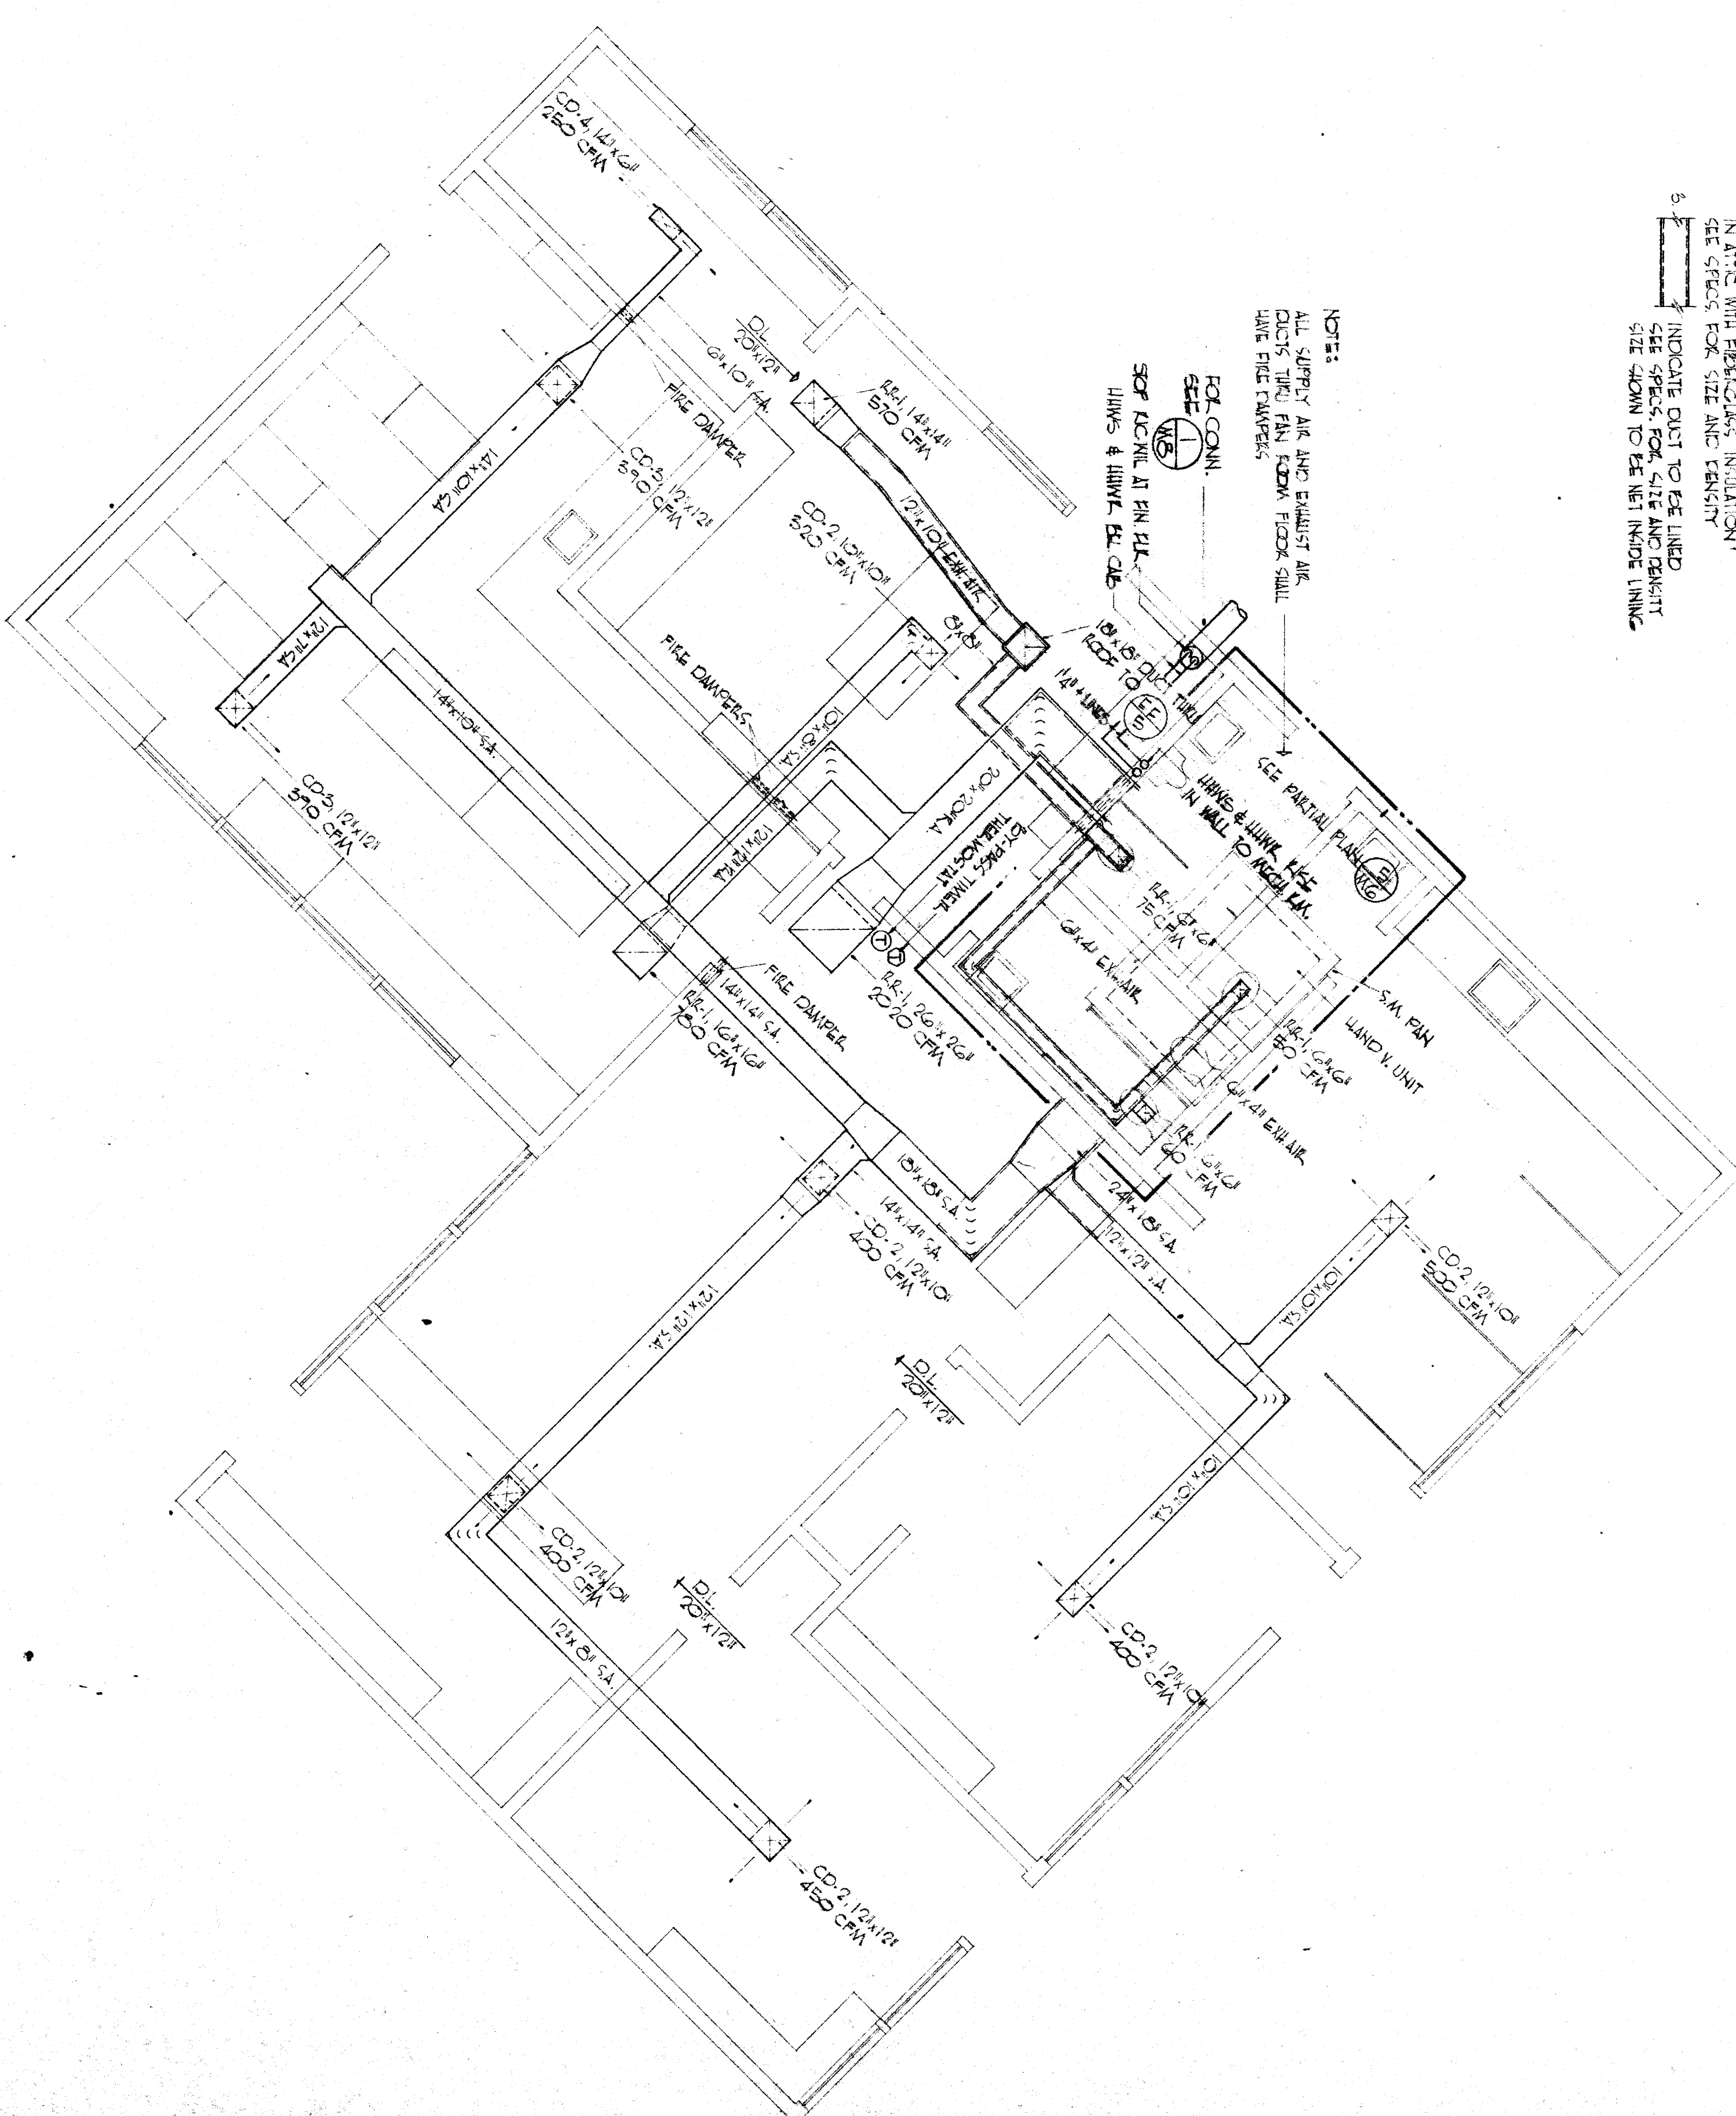

ADMINISTRATION HEATING AND VENTILATING FLOOR PLAN  
SCALE: 1/8" = 1'-0"

<p>REVISIONS</p> <table border="1"> <tr> <th>NO.</th> <th>DATE</th> <th>DESCRIPTION</th> </tr> <tr> <td>1</td> <td>AS BUILT</td> <td>STATE OF CALIFORNIA STATE FIRE MARSHAL APPROVED UNDER STATUTES OF CALIFORNIA</td> </tr> <tr> <td>2</td> <td>5 09 9</td> <td>APPROVED OCT 8 - 1964 BY: <i>W. M. ...</i></td> </tr> </table>	NO.	DATE	DESCRIPTION	1	AS BUILT	STATE OF CALIFORNIA STATE FIRE MARSHAL APPROVED UNDER STATUTES OF CALIFORNIA	2	5 09 9	APPROVED OCT 8 - 1964 BY: <i>W. M. ...</i>	<p>REPORT AND DISBURSEMENTS TO THE ARCHITECT: DRAWN: N.C. JACKSON CHECKED: T.H. WILKINSON</p>	<p>APPROVED - DATE</p> <p>ERNEST L. MCGOY AIA ARCHITECT 2811 KATHERINE MADERFIELD CALIFORNIA 95903</p>	<p>CLIENT: HENRY EISENBERG ELEMENTARY SCHOOL BAKERFIELD DISTRICT BAKERFIELD, CALIFORNIA</p>
NO.	DATE	DESCRIPTION										
1	AS BUILT	STATE OF CALIFORNIA STATE FIRE MARSHAL APPROVED UNDER STATUTES OF CALIFORNIA										
2	5 09 9	APPROVED OCT 8 - 1964 BY: <i>W. M. ...</i>										