


PANEL E		TYPE LOADS - ROUNDED TO 200 AMP		LOCATION	
NO.	LOAD	NO.	LOAD	NO.	LOAD
1	1800	1	1800	1	1800
2	1800	2	1800	2	1800
3	1800	3	1800	3	1800
4	1800	4	1800	4	1800
5	1800	5	1800	5	1800
6	1800	6	1800	6	1800
7	1800	7	1800	7	1800
8	1800	8	1800	8	1800
9	1800	9	1800	9	1800
10	1800	10	1800	10	1800
11	1800	11	1800	11	1800
12	1800	12	1800	12	1800
13	1800	13	1800	13	1800
14	1800	14	1800	14	1800
15	1800	15	1800	15	1800
16	1800	16	1800	16	1800
17	1800	17	1800	17	1800
18	1800	18	1800	18	1800
19	1800	19	1800	19	1800
20	1800	20	1800	20	1800
21	1800	21	1800	21	1800
22	1800	22	1800	22	1800
23	1800	23	1800	23	1800
24	1800	24	1800	24	1800
25	1800	25	1800	25	1800
26	1800	26	1800	26	1800
27	1800	27	1800	27	1800
28	1800	28	1800	28	1800
29	1800	29	1800	29	1800
30	1800	30	1800	30	1800
31	1800	31	1800	31	1800
32	1800	32	1800	32	1800
TOTAL	57600	TOTAL	57600	TOTAL	57600

PANEL F		TYPE LOADS - ROUNDED TO 200 AMP		LOCATION	
NO.	LOAD	NO.	LOAD	NO.	LOAD
1	1800	1	1800	1	1800
2	1800	2	1800	2	1800
3	1800	3	1800	3	1800
4	1800	4	1800	4	1800
5	1800	5	1800	5	1800
6	1800	6	1800	6	1800
7	1800	7	1800	7	1800
8	1800	8	1800	8	1800
9	1800	9	1800	9	1800
10	1800	10	1800	10	1800
11	1800	11	1800	11	1800
12	1800	12	1800	12	1800
13	1800	13	1800	13	1800
14	1800	14	1800	14	1800
15	1800	15	1800	15	1800
16	1800	16	1800	16	1800
17	1800	17	1800	17	1800
18	1800	18	1800	18	1800
19	1800	19	1800	19	1800
20	1800	20	1800	20	1800
21	1800	21	1800	21	1800
22	1800	22	1800	22	1800
23	1800	23	1800	23	1800
24	1800	24	1800	24	1800
25	1800	25	1800	25	1800
26	1800	26	1800	26	1800
27	1800	27	1800	27	1800
28	1800	28	1800	28	1800
29	1800	29	1800	29	1800
30	1800	30	1800	30	1800
31	1800	31	1800	31	1800
32	1800	32	1800	32	1800
TOTAL	57600	TOTAL	57600	TOTAL	57600

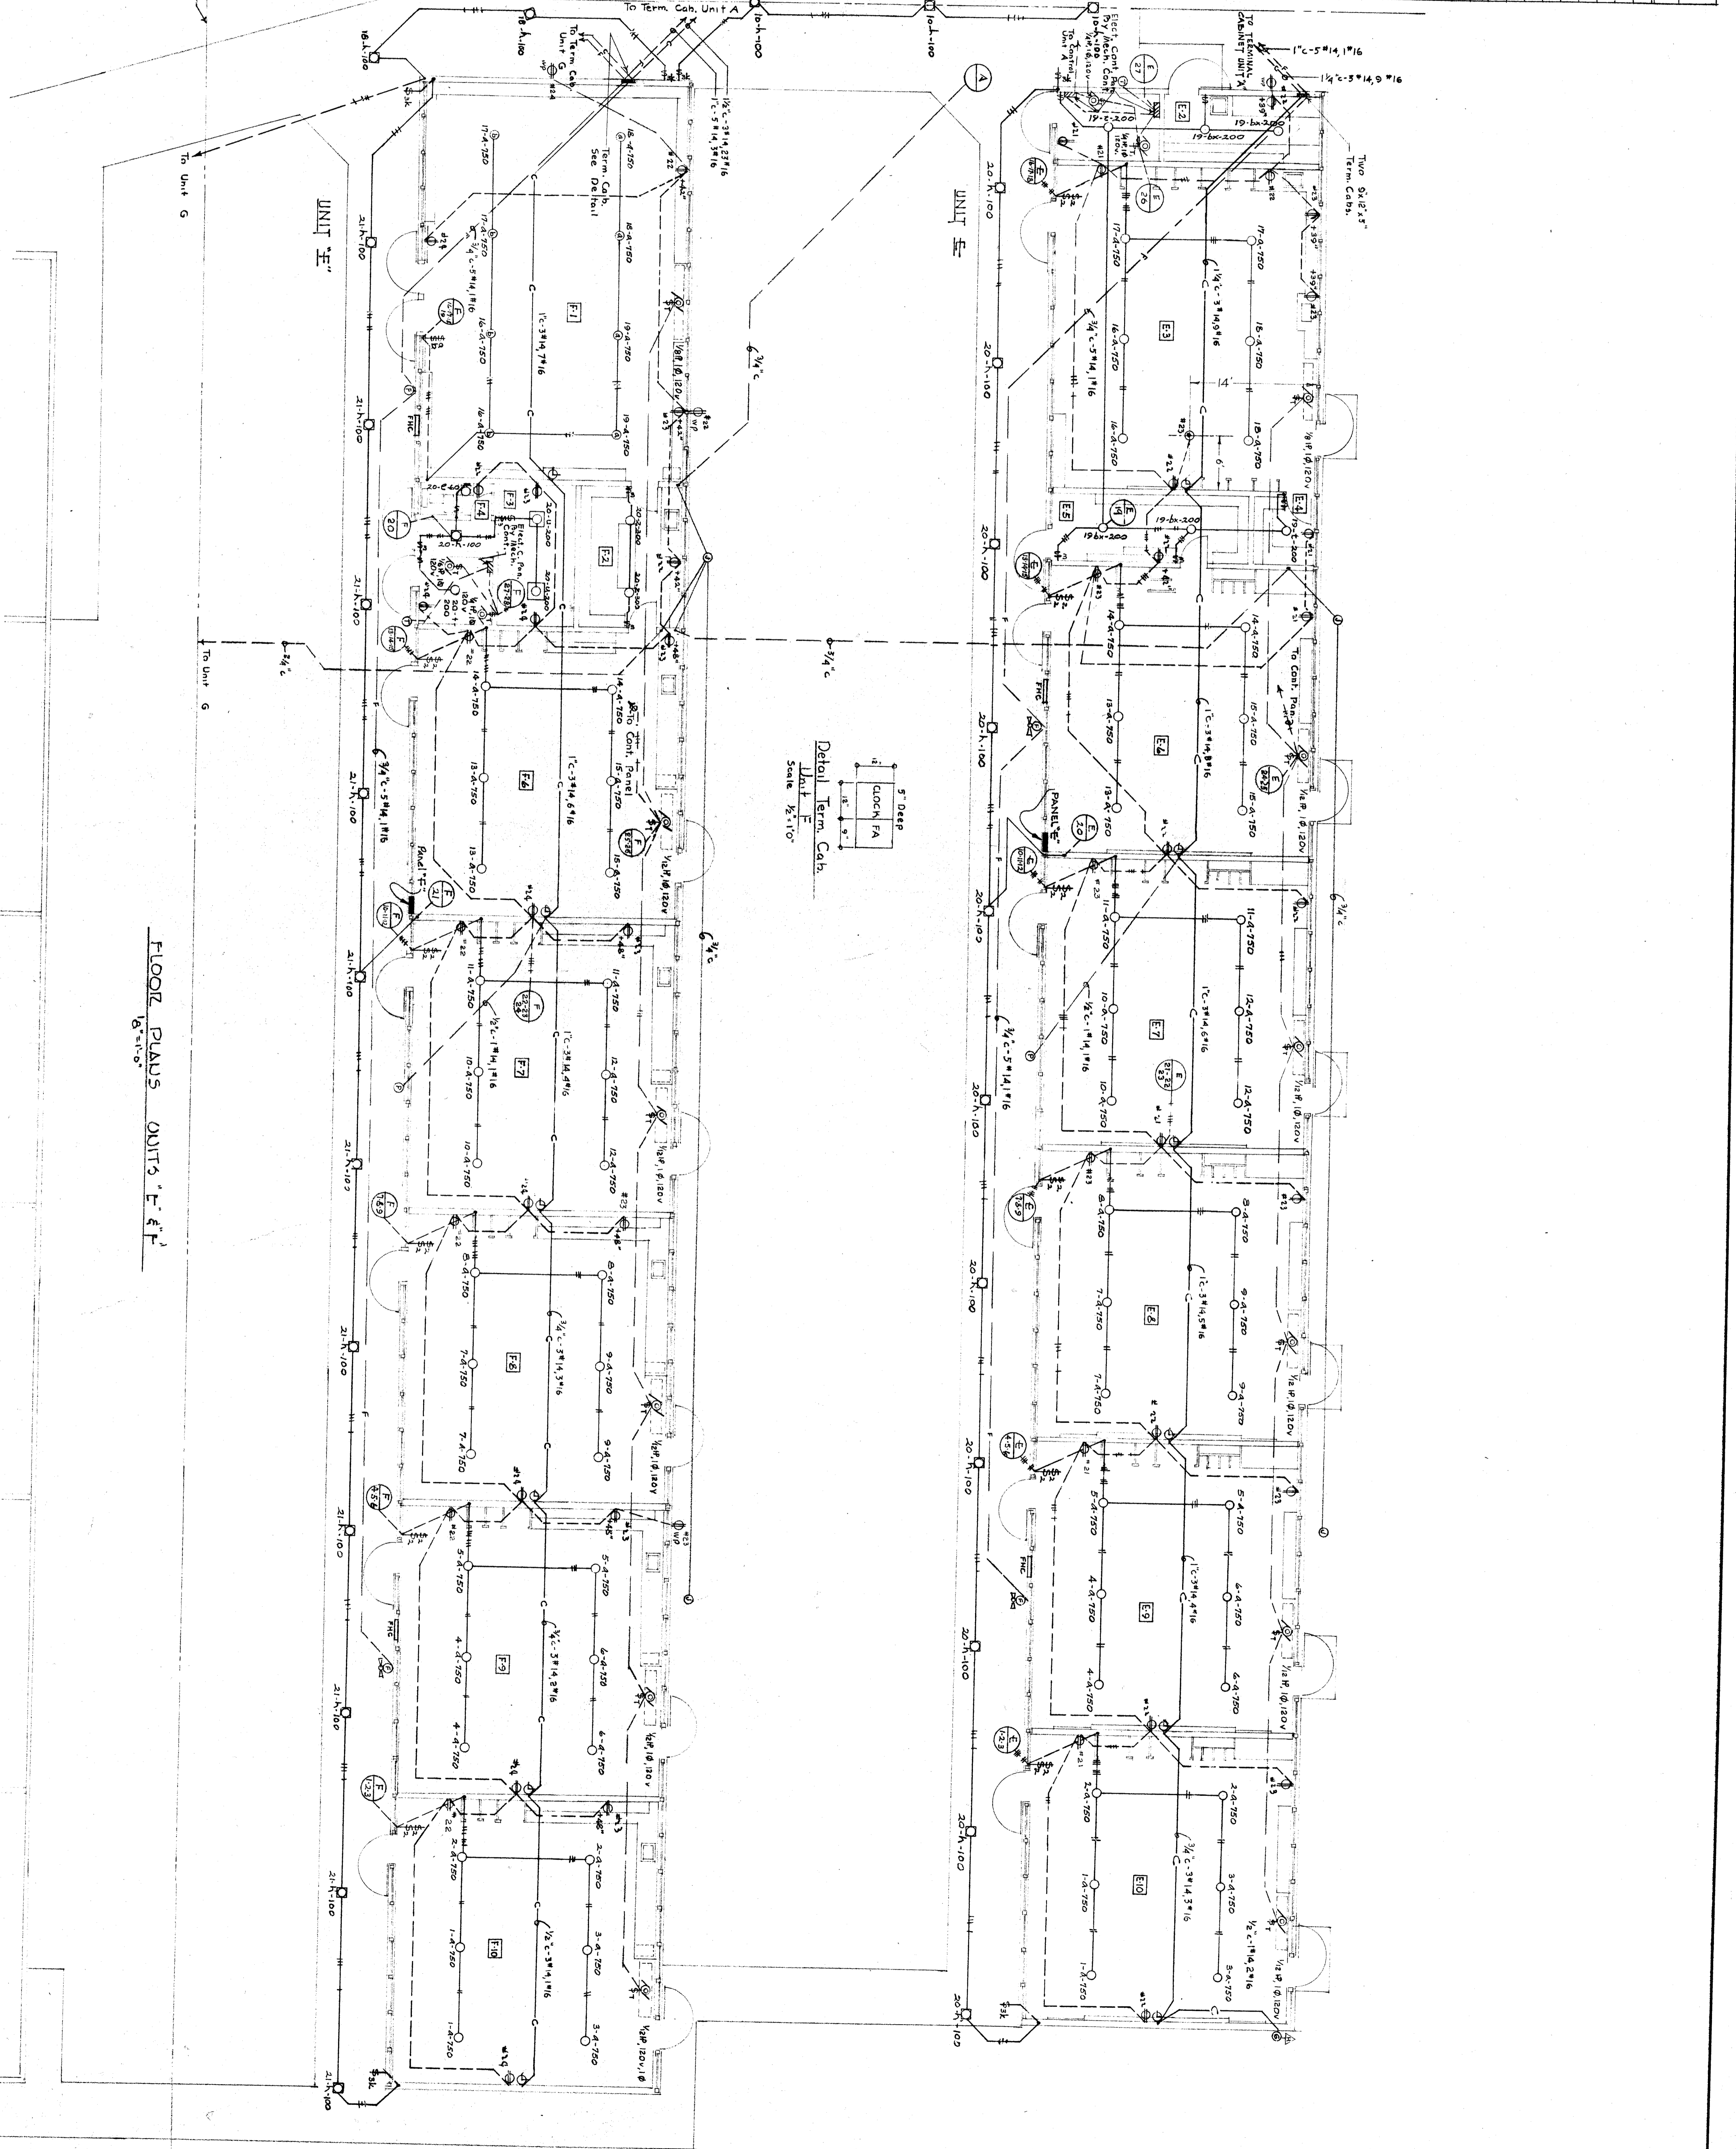

FLOOR PLANS UNITS E-F & F

EDWARD LOWE
ELECTRICAL ENGINEER
1045 PULFORD ST.
FRESNO CALIFORNIA

OFFICE OF SUPERINTENDENT OF SCHOOLS
DEPARTMENT OF PUBLIC WORKS
DIVISION OF ARCHITECTURE

STATE OF CALIFORNIA - DEPARTMENT OF PUBLIC WORKS
DIVISION OF ARCHITECTURE
NOV 4 1953
ERNEST L. MCCOY ARCHITECT

BAKER-SHELDON CITY SCHOOLS
1600 K ST BAKER-SHELDON CAL
BOARD OF EDUCATION

APPROVED DATE NOV 3, 1953
EMERSON JUNIOR HIGH SCHOOL
BAKER-SHELDON CITY SCHOOLS DISTRICT
FOURTH AND 'P' STREETS
BAKER-SHELDON CALIFORNIA

ERNEST L. MCCOY A.I.A. ARCHITECT
BAKER-SHELDON

CASE JOB NO. C-116
DATE 10-21-53
DRAWN BY
CHECKED BY
SHEET NO. 5

APPROVED DATE NOV 3, 1953
EMERSON JUNIOR HIGH SCHOOL
BAKER-SHELDON CITY SCHOOLS DISTRICT
FOURTH AND 'P' STREETS
BAKER-SHELDON CALIFORNIA

ERNEST L. MCCOY A.I.A. ARCHITECT
BAKER-SHELDON

CHECK AND VERIFY ALL DIMENSIONS AND CONDITIONS AT JOB SITE BEFORE PROCEEDING WITH THE WORK. REPORT ANY DISCREPANCIES TO THE ARCHITECT.