


LOCH LC

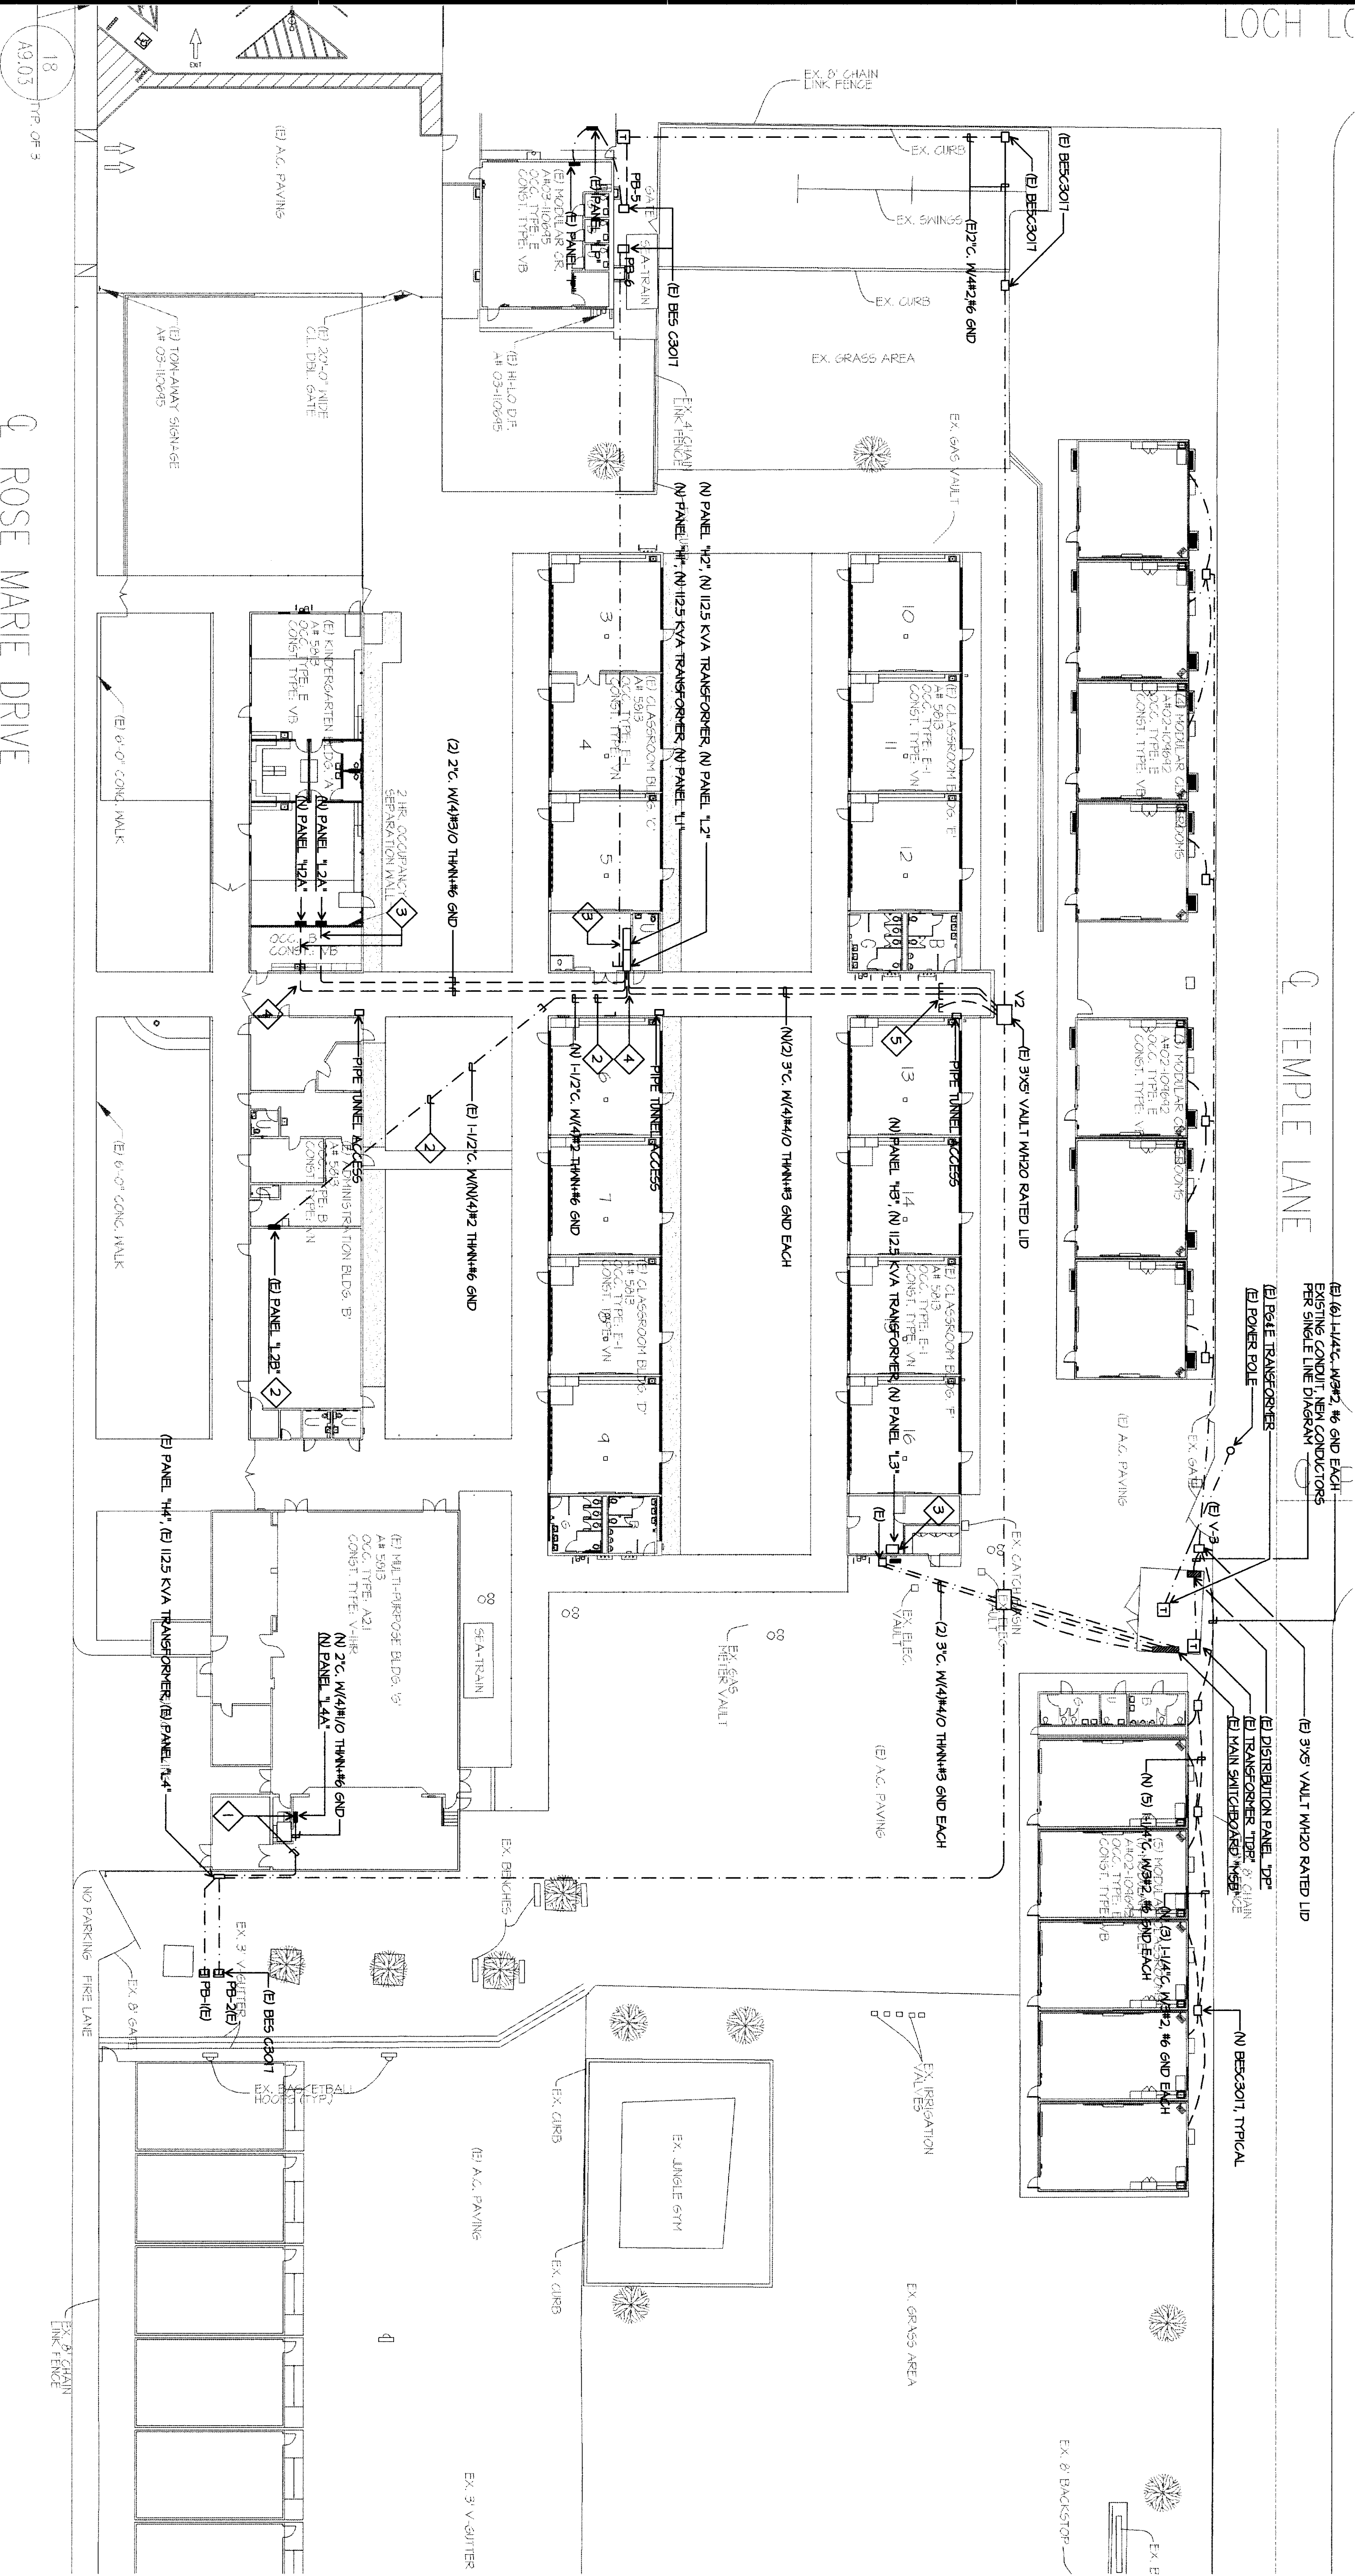


ELECTRICAL SITE PLAN

Q ROSE MARIE DRIVE


Q TEMPLE LANE

ITY ST.

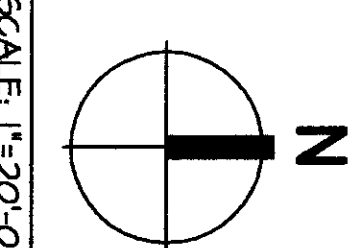



SCALE 1"=20'-0"

- ELECTRICAL SITE PLAN NOTES**
- 1 EXISTING FEEDER UNDER STAGE. INSTALL PANEL 14A IN NEW WALL.
 - 2 INTERCEPT RIGGING CONDUIT BETWEEN ZINCO DISTRIBUTION PANEL AND PANEL H. REMOVE CONDUITS COMPLETE. INTERCEPT AND EXTEND CONDUIT TO PANEL 12. INSTALL NEW FEEDERS AS SHOWN. PROVIDE GROUND BUS. REPAIR PANEL 12B.
 - 3 SAWCUT FLOOR. REPAIR TO MATCH EXISTING.
 - 4 CORE THROUGH TUNNEL.
 - 5 EXISTING CONDUIT FROM MAIN POT TUNNEL. EXTEND (A) TO CONDUIT TO NEW PANEL H1 AND H2. PROVIDE FEEDERS AS SHOWN ON SINGLE LINE DIAGRAM SHEET E-11.

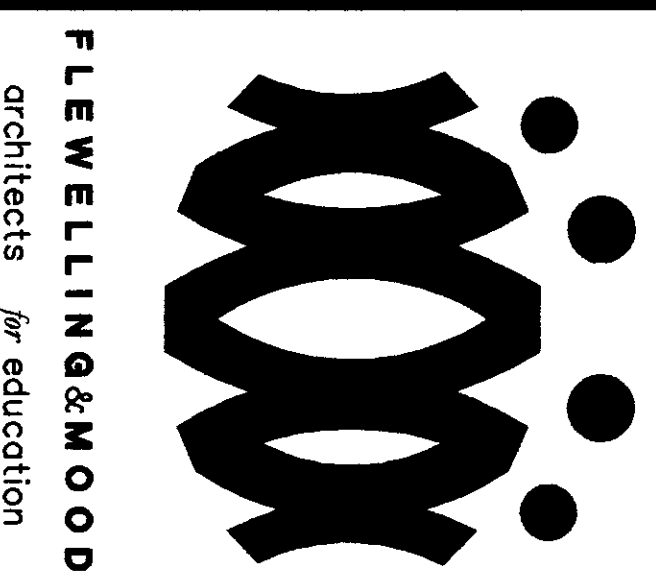

HEADQUARTERS OFFICE:
 14 South Lake Avenue, 2nd Floor
 Pasadena, California 91101
 Telephone: 626.799.1100
 Fax: 626.799.1101
 Email: fmoody@flemingmoody.com

ANTelope VALLEY OFFICE:
 10000 North Main Street, Suite 100
 Lancaster, California 93534
 Telephone: 805.338.8800
 Fax: 805.338.8801
 Email: antelope@flemingmoody.com
 An Employee Owned Corporation

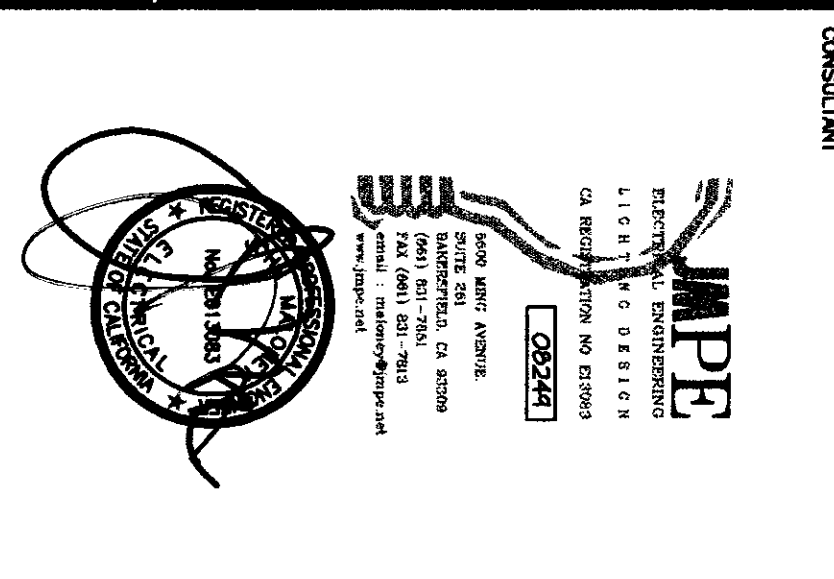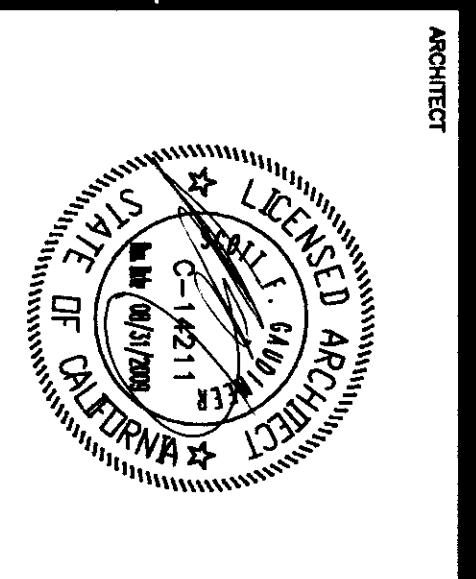

AGENCY:
 REGISTRATION STATE:
 DIV OF THE STATE ARCHITECTS
 APPROX 11 28 17
 DATE: 11 28 17
 AC: RST/MS/LS
 DATE: 11 28 17

Drawn by:	AC	
Checked by:	PH	
Revisions:		
No.	Date	Description

**MODERNIZATION PROJECT AT
 EVERGREEN ELEMENTARY SCHOOL**
 2600 ROSE MARIE DRIVE
 BAKERSFIELD, CA 93304

BAKERSFIELD CITY SCHOOL DISTRICT

**ELECTRICAL
 SITE PLAN**

JOB No.
1894200

Date
1-14-2009

E-11