

SITE HVAC ELECTRICAL PLAN NOTES

1 GRIFFOOF RECEPTAFPTACTES SHALL HAVE W.P.N.-ISE COVERS, TYPICAL.


2 RE-FREED UNITS FROM NEW PANTHS AS SHOWN ON SHEET E-12.



HEADQUARTERS OFFICE:
 40 South Main Street
 Pasadena, California 91101
 Telephone: (626) 799-1111
 Fax: (626) 799-1111
 Email: fmoody@fmoody.com

ANTELOPE VALLEY OFFICE:
 4000 West 10th Street
 Lancaster, California 93534
 Telephone: (805) 391-3333
 Fax: (805) 391-3333
 Email: fmoody@fmoody.com

An Equal Opportunity Employer

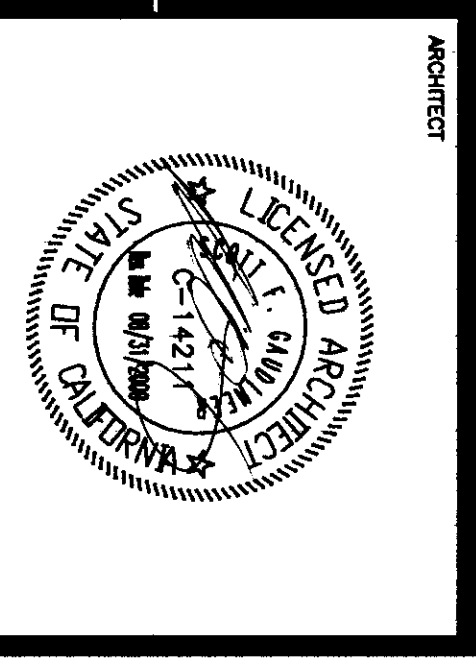

CONSULTANT:

MJPE
 M. J. MPE
 10000 S. GARDEN AVENUE
 SUITE 100
 GARDEN GROVE, CA 92640
 TEL: 949.440.1111
 FAX: 949.440.1112
 WWW.MJPE.COM

ARCHITECT:

FLEWELLING & MOODY
 40 SOUTH MAIN STREET
 PASADENA, CA 91101
 TEL: 626.799.1111
 FAX: 626.799.1111
 WWW.FLEWELLINGANDMOODY.COM

OWNER:

DIABETERIA STAMPE
 DM 9 HERSHMAN BLVD
 AMYD 112 817
 AC FRESNO, CA 93721
 DATE: MAR 18 2010

DESIGNED BY: AC

CHECKED BY: EH

No.	Date	Description
-	-	-

MODERNIZATION PROJECT AT EVERGREEN ELEMENTARY SCHOOL
 2800 ROSE MARIE DRIVE
 BAKERSFIELD, CA 93304


BAKERSFIELD CITY SCHOOL DISTRICT

SITE HVAC ELECTRICAL PLAN


DATE: 1-14-2009

NO. 1894200

E-12

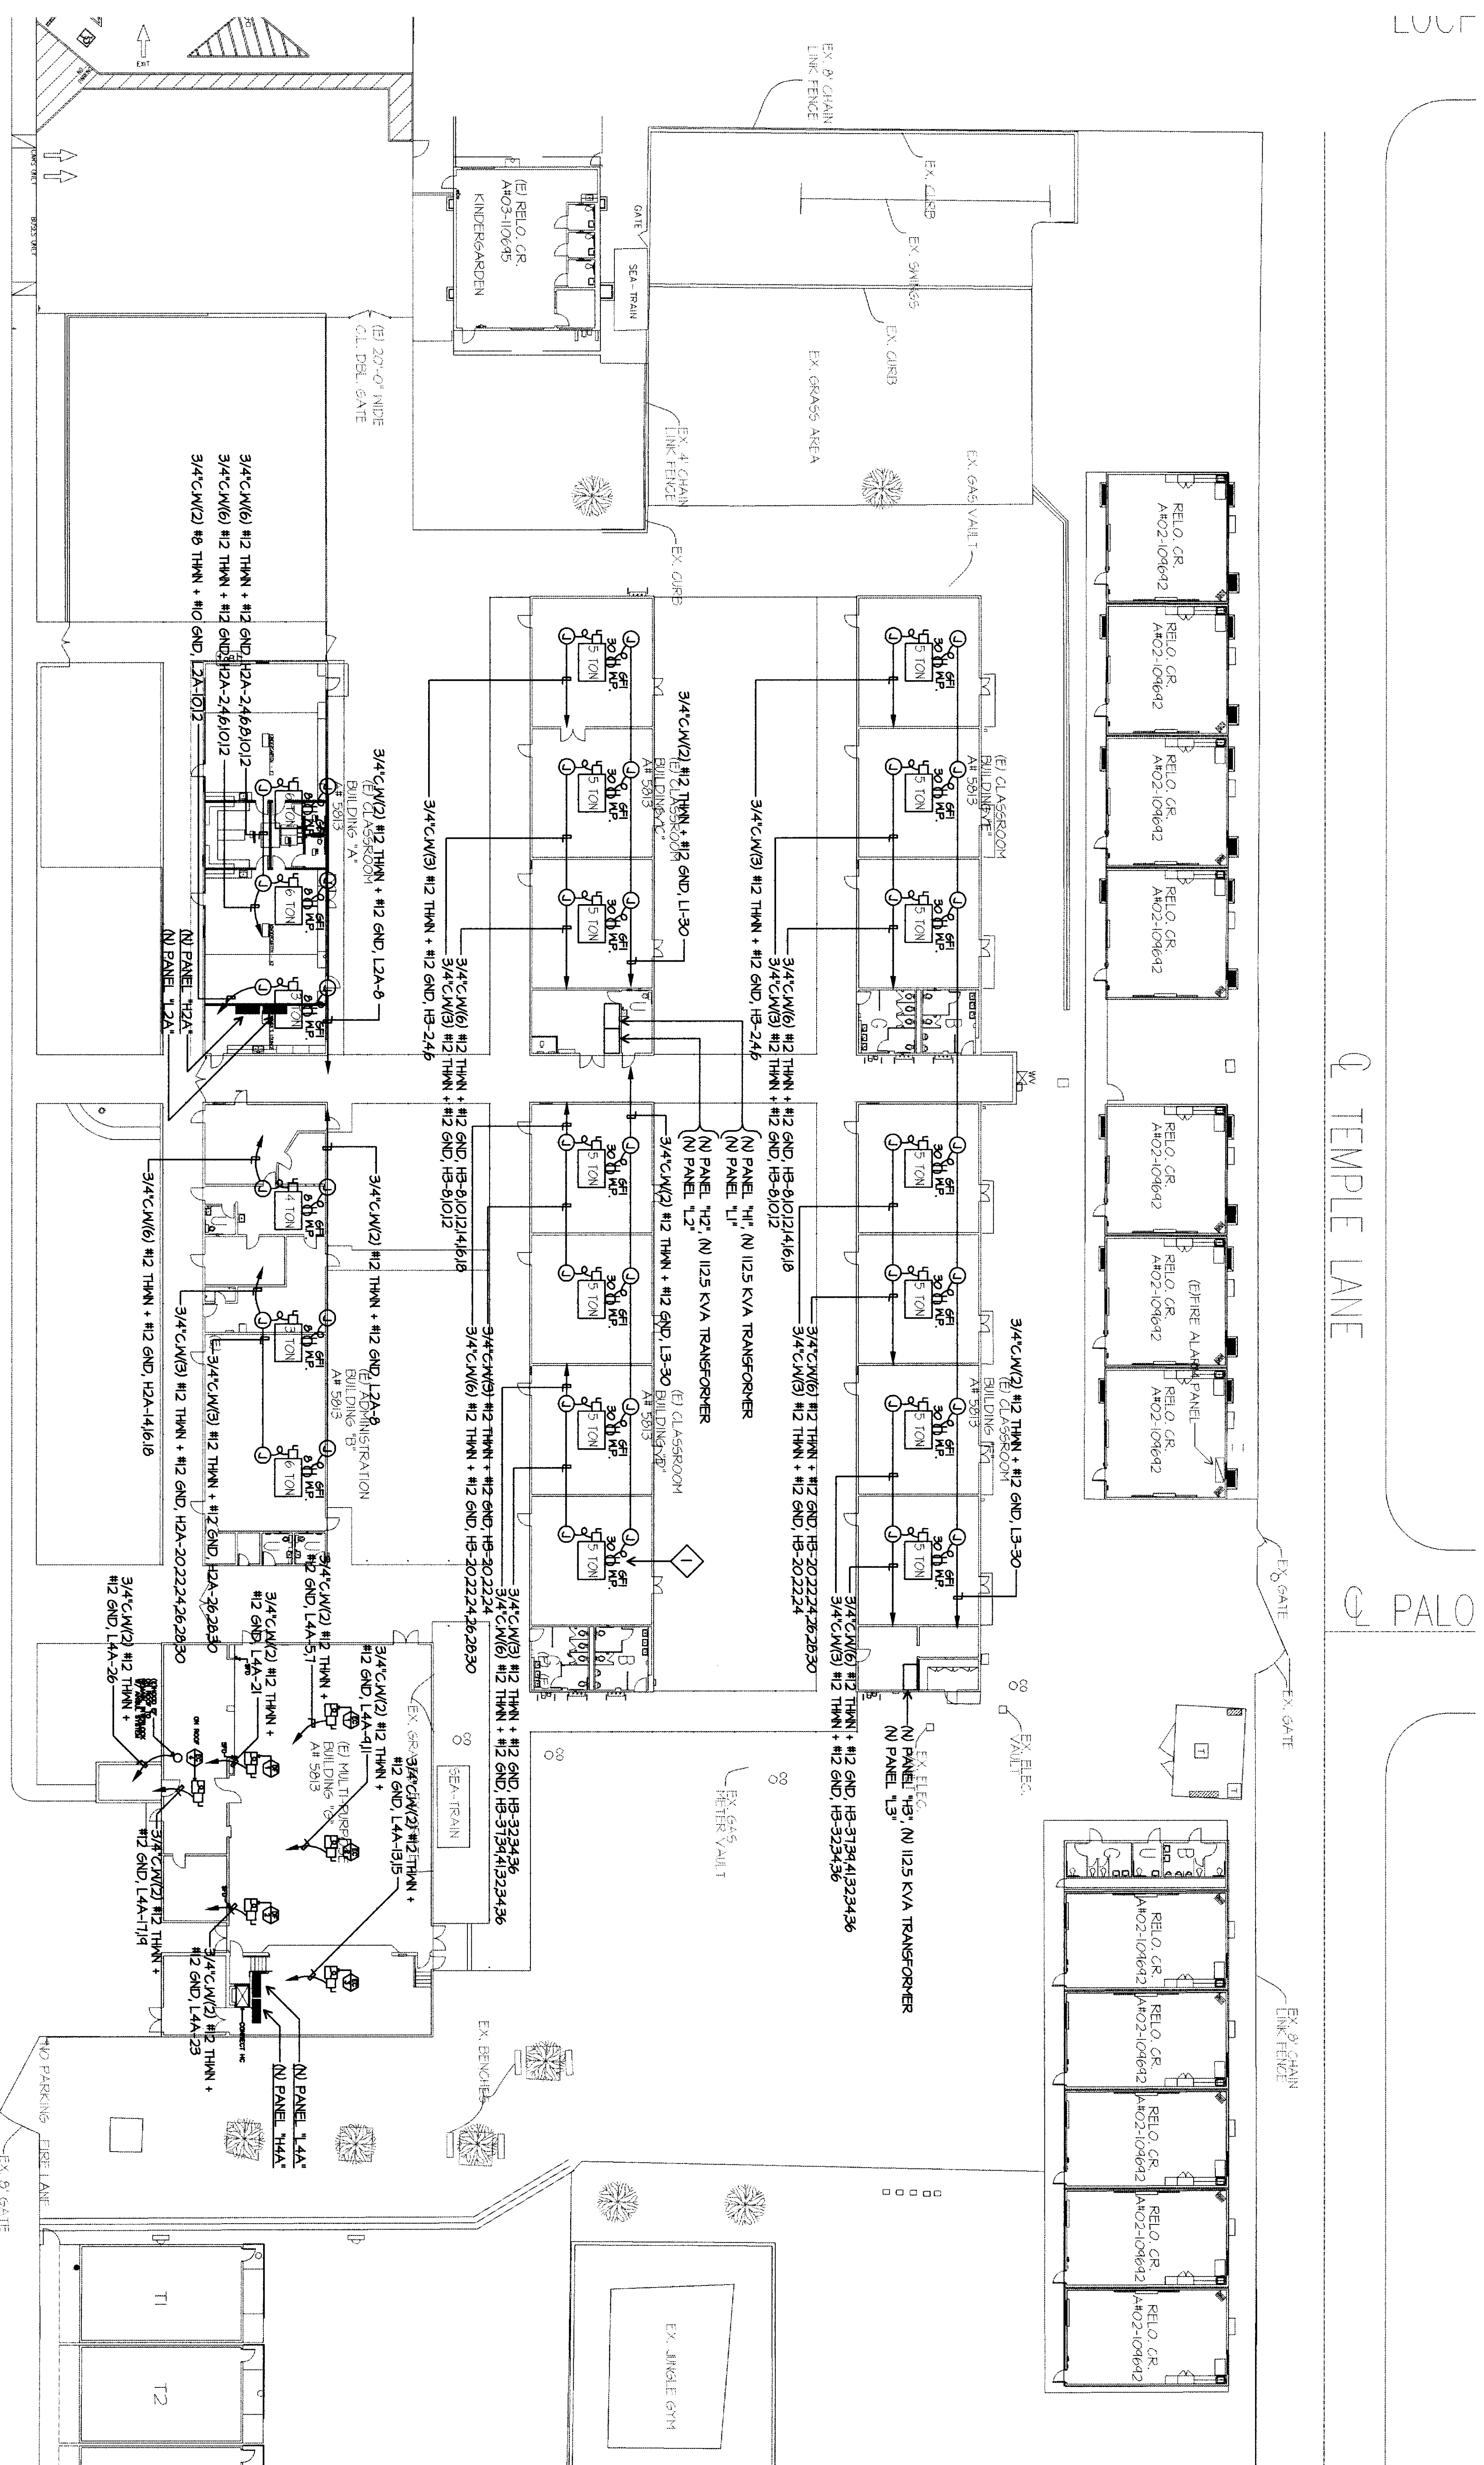

SITE HVAC ELECTRICAL PLAN

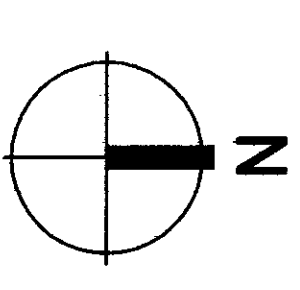

SCALE: 1"=20'-0"