

1 2 3 4 5 A B C D E F


LOCH LOMOND DR.

TEMPLE LANE


PALOMA ST.

HARTY ST.


ROSE MARIE DRIVE

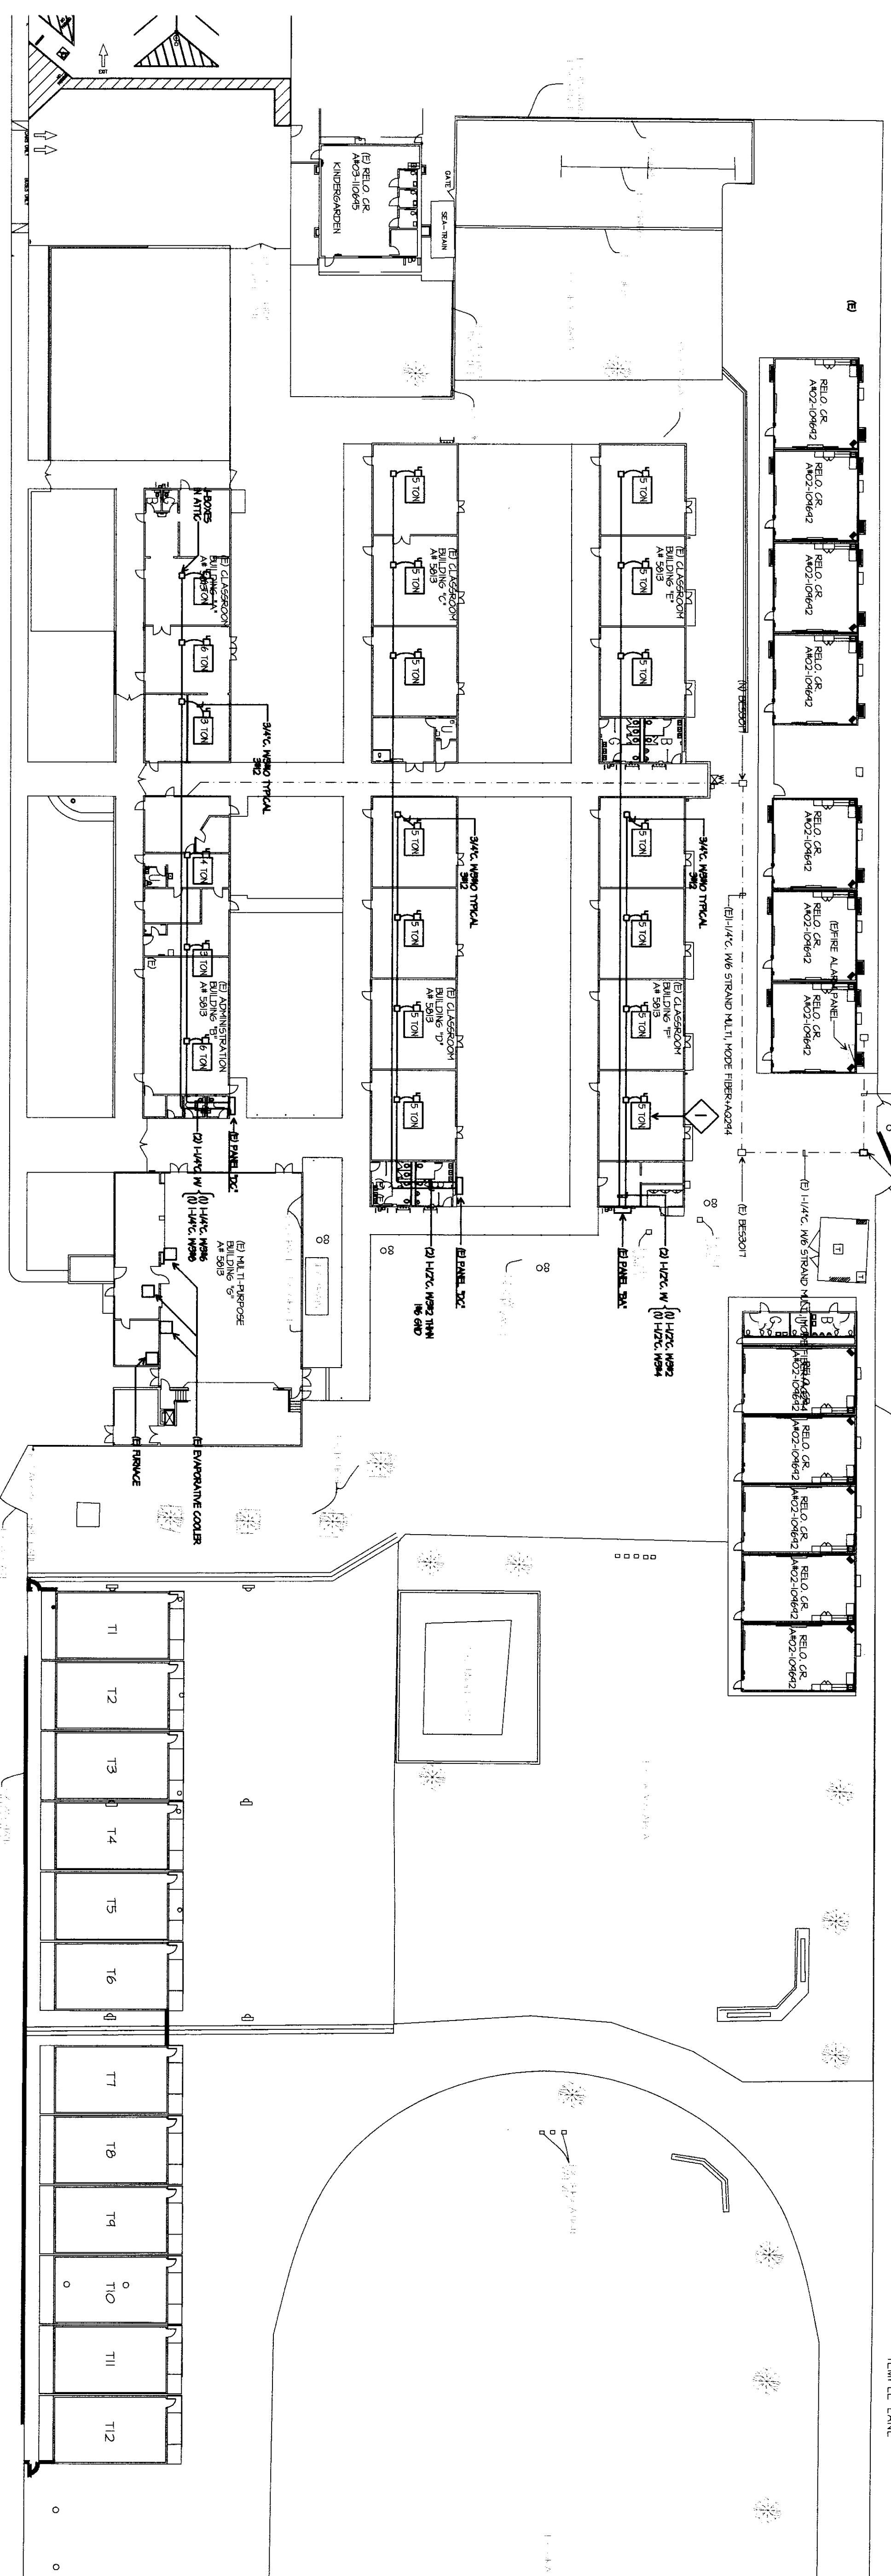

EXISTING SITE HVAC ELECTRICAL PLAN

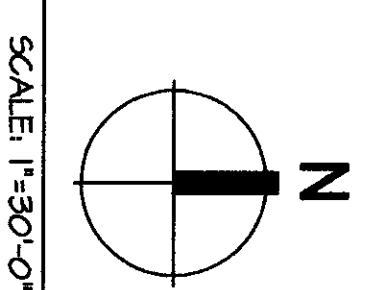

- EXISTING SITE HVAC ELECTRICAL PLAN NOTES**
- 1 REMOVE ALL FEEDERS FROM HVAC UNITS COMPLETE. ENSURE THAT ENERGY MANAGEMENT SYSTEMS ARE INSTALLED AND OPERATING. ALL CONNECTIONS AS REQUIRED TO MAINTAIN UNITS SHALL BE IDENTIFIED WITH BRASS TAG ROOM, BAKERSFIELD CITY SCHOOL DISTRICT, 661-431-5883.
  - 2 RE-FEED UNITS FROM NEW PANELS AS SHOWN ON SHEET E-12.

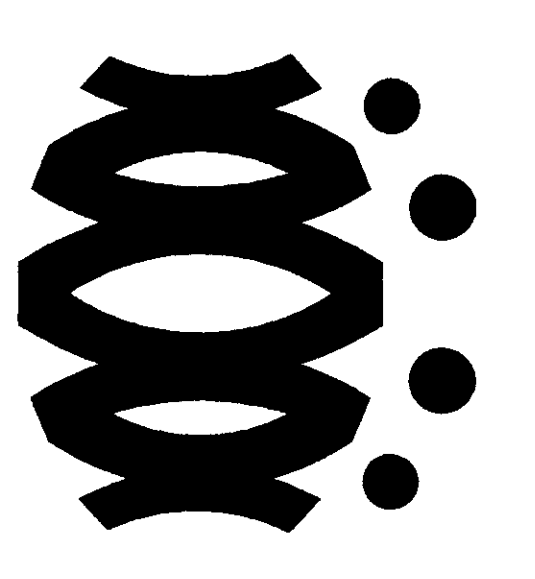


**FLEWELLING & MOODY**  
architects for education

**HEADQUARTERS OFFICE:**  
141 South Main Avenue, 2nd Floor  
Bakersfield, CA 93304  
Phone: 805.833.4100  
Fax: 805.833.4107  
Email: flewelling@flewellingmoody.com

**ANTIOPE VALLEY OFFICE:**  
1033 Main Street, Bakersfield  
805.833.4100  
805.833.4107  
805.833.4107  
Email: flewelling@flewellingmoody.com

An Employee Owned Corporation

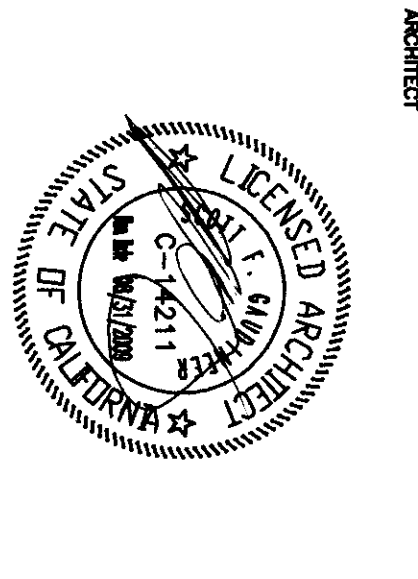

**CONSULTANT**

**AGENCY**

MODERNIZATION GROUP  
DIVISION OF EDUCATION  
APR03 11 28 17  
AC: FLEWELLING & MOODY  
DATE: APRIL 19 2010

Drawn by:	AC	
Checked by:	PH	
Revisions:		
No.	Date	Description

At the direction of the Board of Directors of the City of Bakersfield, the undersigned hereby certifies that he is a duly Licensed Professional Engineer in the State of California, License No. 14111, and that he is the author of the above described drawings. He further certifies that the drawings were prepared by him or under his direct supervision and that he is a duly Licensed Professional Engineer in the State of California, License No. 14111, and that he is the author of the above described drawings.

**MODERNIZATION PROJECT AT  
EVERGREEN ELEMENTARY SCHOOL,  
2600 ROSE MARIE DRIVE  
BAKERSFIELD, CA 93304**

**BAKERSFIELD CITY SCHOOL DISTRICT**

**EXISTING SITE HVAC  
ELECTRICAL PLAN**

Job No. 1984300  
Date: 1-14-2009  
**E-13**