
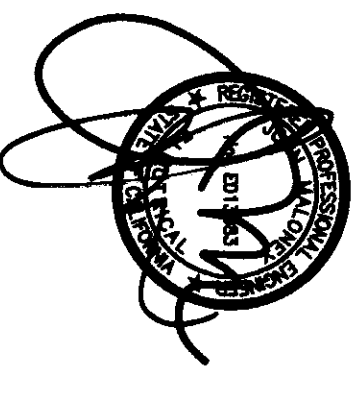
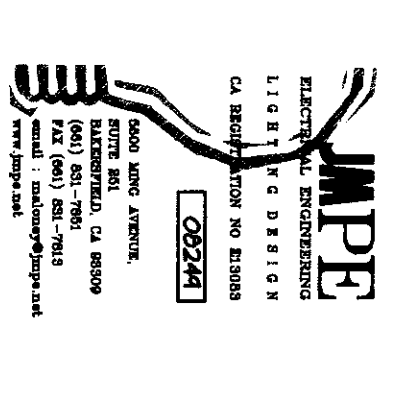


HEADQUARTERS OFFICE:
411 South Lake Avenue, Suite 100
West Covina, CA 91791
TEL: 626-835-8877
FAX: 626-835-8878
EMAIL: flewelling@flewellingmoody.com

ANTELOPE VALLEY OFFICE:
1025 West Lancaster Boulevard
Antelope, CA 95721
TEL: 916-867-7711 FAX: 916-867-8843
EMAIL: fv-office@flewellingmoody.com

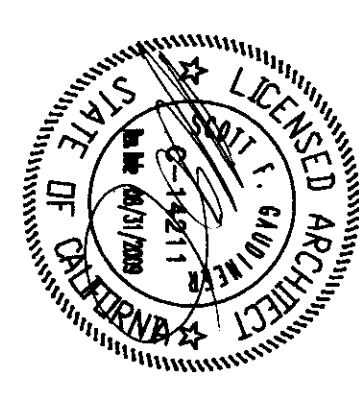


AGENCY:
IDENTIFICATION STAMP
DIV. OF THE STATE ARCHITECT
APPROVED 12 8 17
AC 1254
DATE 12/8/17

Drawn by	AC	
Checked by	PH	
Revisions		
No.	Date	Description


**MOOREHEAD PROJECT AT
EMERGEN ELEMENTARY SCHOOL,
BAKERSFIELD, CA 93304**

**BAKERSFIELD CITY SCHOOL DISTRICT
BUILDING A FIRE ALARM
DEMOLITION PLAN
BUILDING A FIRE ALARM
PLAN**

Job No.
1894200
Date
1-14-2009
E-3.3

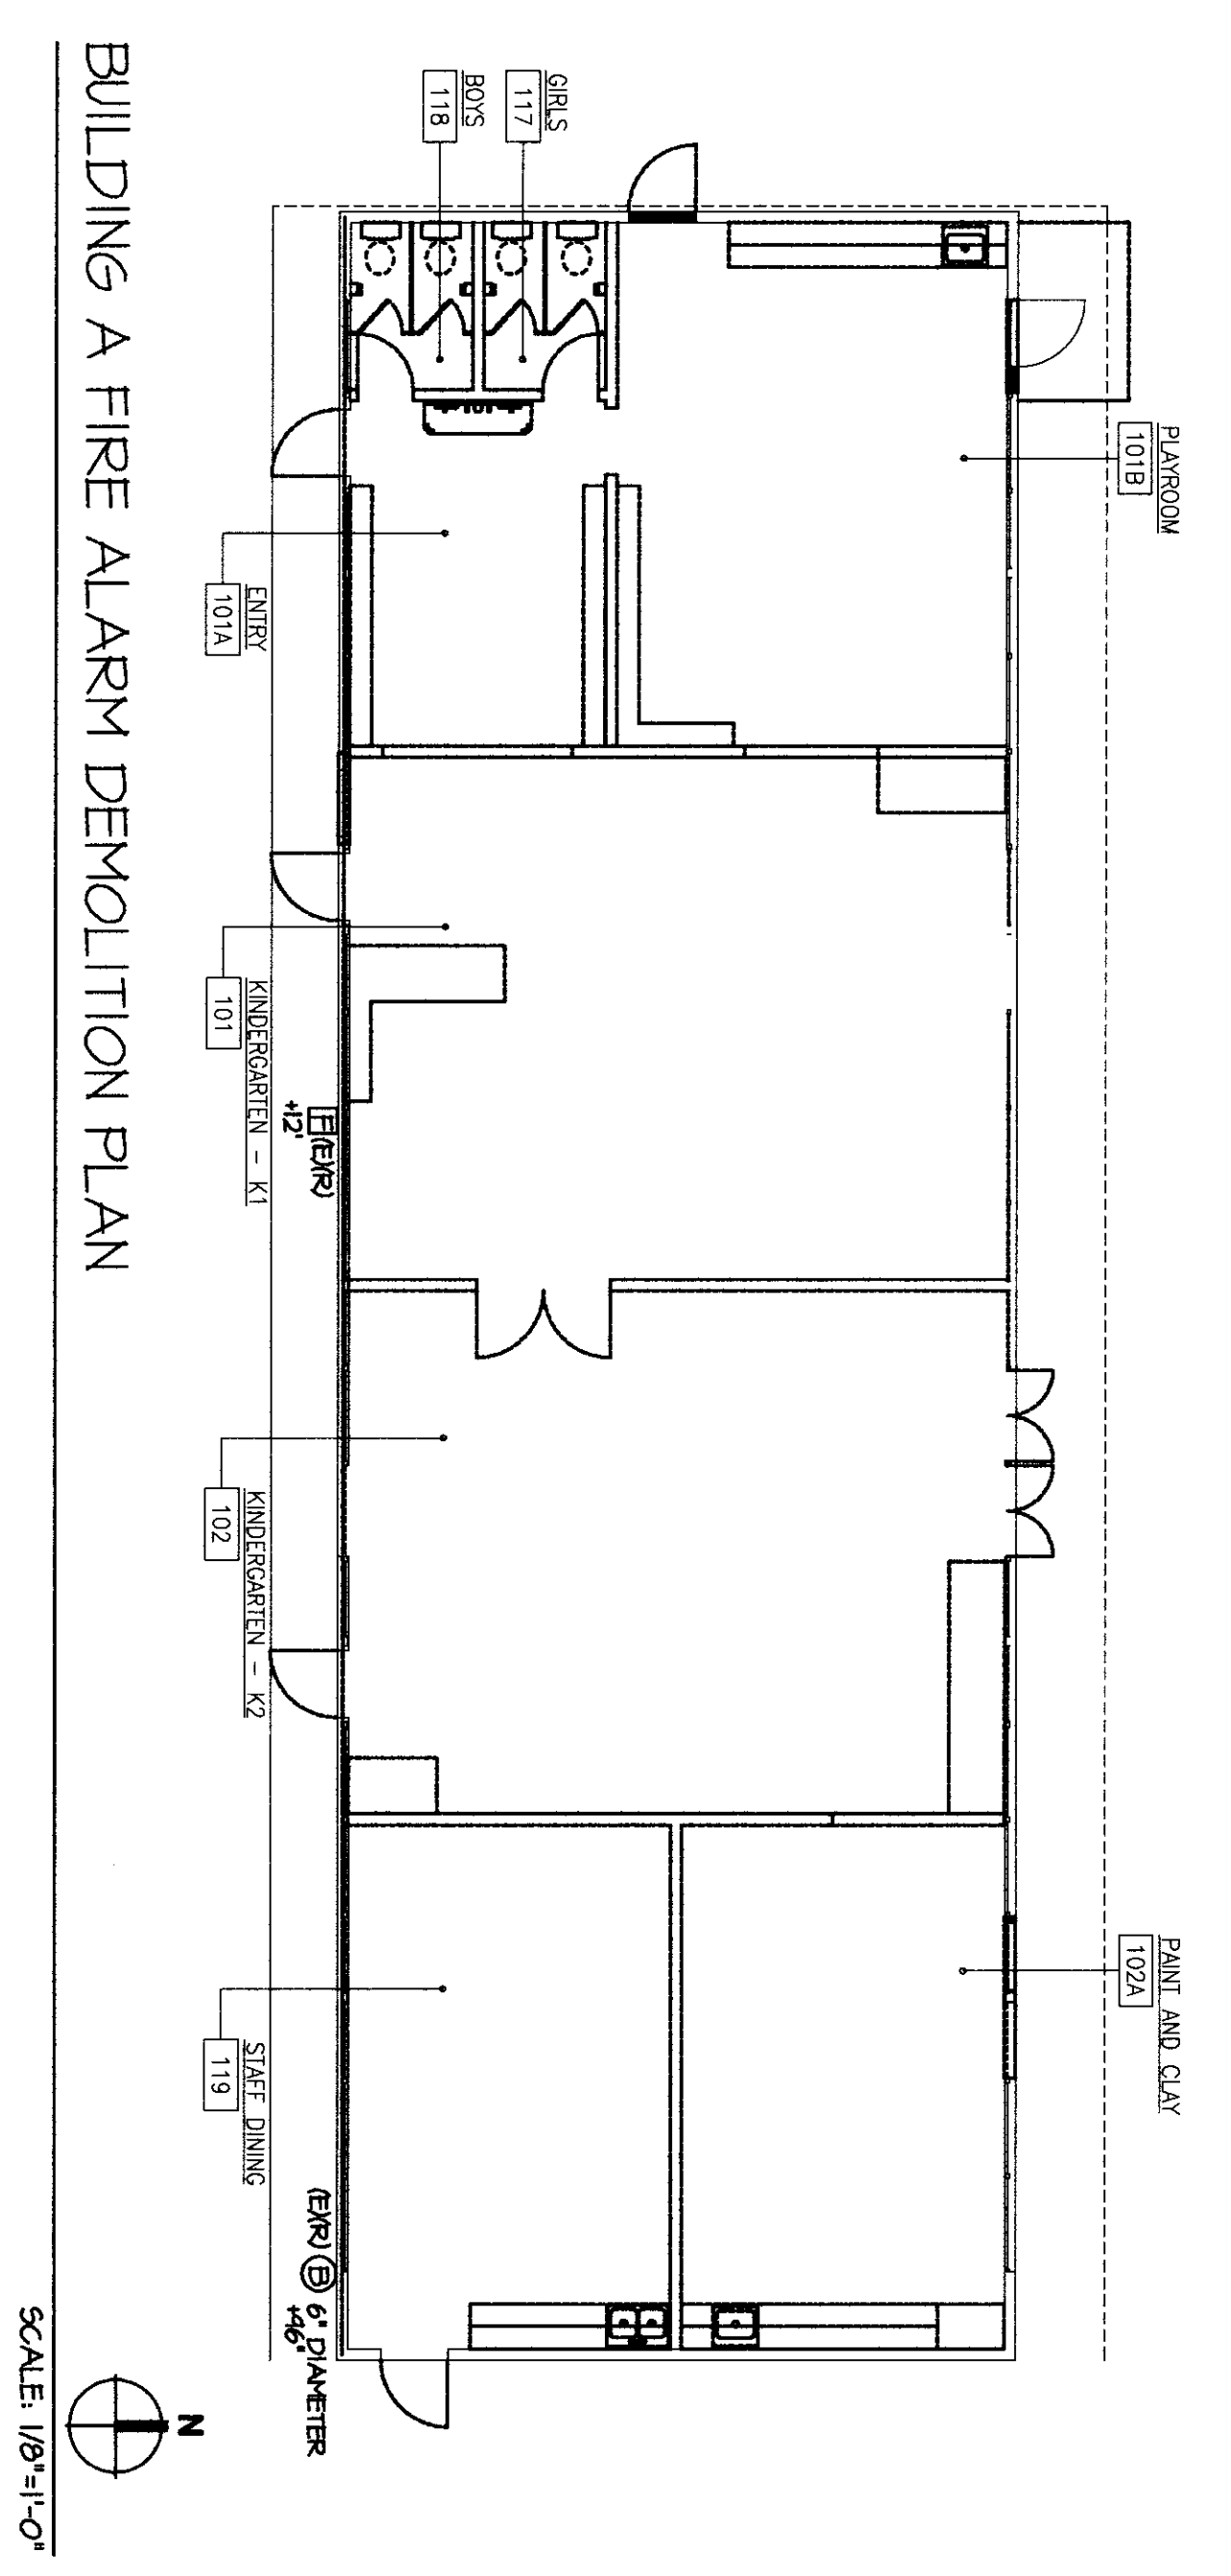

BUILDING A FIRE ALARM DEMOLITION PLAN
SCALE: 1/8"=1'-0"

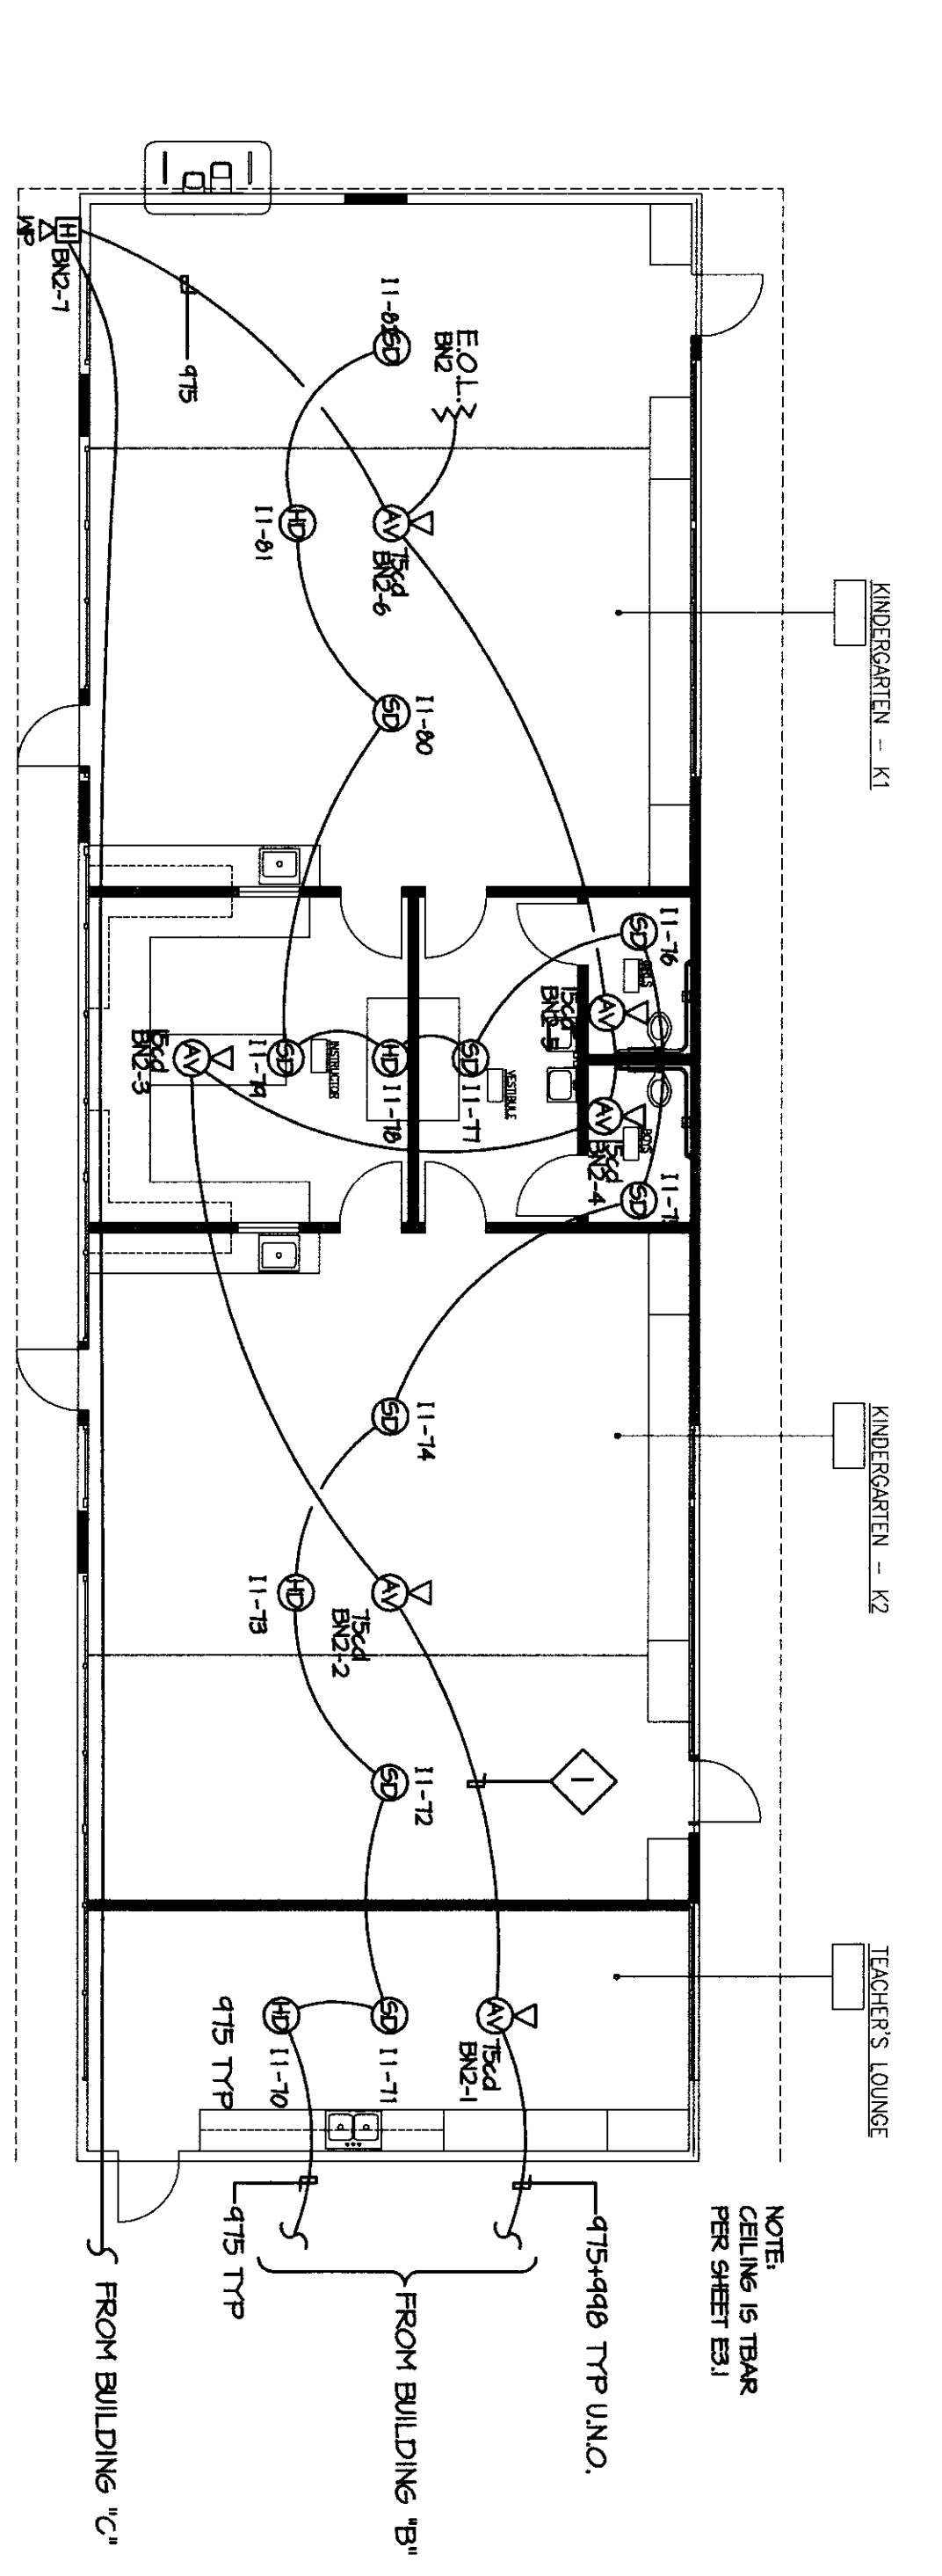

BUILDING A FIRE ALARM PLAN
SCALE: 1/8"=1'-0"

FIRE ALARM PLAN NOTES
SUPPORT FIRE ALARM CABLES RUN BY RW/RED HOOKS AT LEAST 8" ABOVE CEILING. TYPICAL. FIRE ALARM CABLES AND THEIR SUPPORTS SHALL BE INDEPENDENT FROM COMMUNICATION CABLE SUPPORT TYPICAL.

