




BUILDING B COMMUNICATION DEMOLITION PLAN

SCALE: 1/8"=1'-0"

BUILDING B COMMUNICATION PLAN

SCALE: 1/8"=1'-0"


- COMMUNICATION PLAN NOTES**
- 1 EXISTING DATA DROPS TO REMAIN.
 - 2 SUPPORT TELEPHONE AND/OR DATA AND/OR SPEAKER CABLES EVERY 5' W/VELLOW/HOOKS AT LEAST 8" ABOVE CEILING. TYPICAL COMMUNICATION CABLE(S) AND THEIR SUPPORT(S) SHALL BE INDEPENDENT FROM FIRE ALARM CABLE SUPPORT, TYPICAL.
 - 3 PROVIDE ATLAS MODEL #8922, W 25W/70W OR EQUAL, CEILING MOUNTED SPEAKER. PROVIDE A DEDICATED CAT5 CABLE BACK NEAREST THE TERMINATE ON 66 BLOCK. TERMINATE STRIPPED CABLE ON SPEAKER. PROVIDE 3 SERVICE LOOPS OF CABLE AT EACH SPEAKER LOCATION.
 - 4 EXISTING PHONES TO REMAIN.

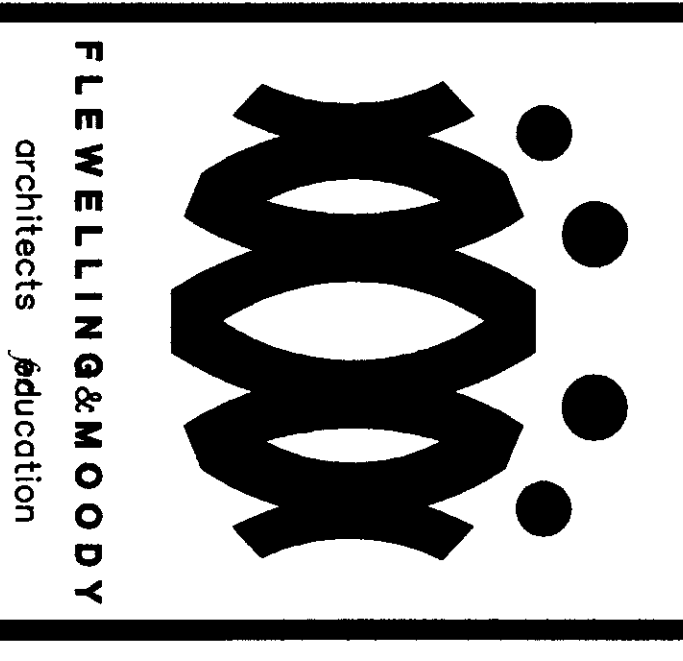

HEADQUARTERS OFFICE:
 141 SOUTH LAKE AVENUE, SUITE 100
 RIVERSIDE, CA 92506-1417
 PHONE: 951-514-1100
 FAX: 951-514-1177
 EMAIL: fw@flewellingandwoody.com

ANTELOPE VALLEY OFFICE:
 1025 SHIELD AVENUE, SUITE 100
 RIVERSIDE, CA 92506-1417
 PHONE: 951-514-1100
 FAX: 951-514-1177
 EMAIL: fw@flewellingandwoody.com

An Employee-Owned Corporation

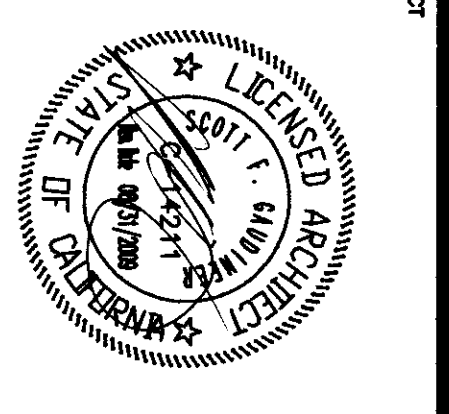

CONSULTANT:

JMPE
 JAMES M. PETERSON ENGINEERS
 11111 WILSON AVENUE, SUITE 100
 RIVERSIDE, CA 92506-1417
 PHONE: 951-514-1100
 FAX: 951-514-1177
 EMAIL: jim@jmpe.com

ARCHITECT:

IDENTIFICATION STAMP
 DIV. OF THE STATE ARCHITECT
 APR 03 11 2 8 17
 ANTHONY J. LEWIS
 DATE 08/11/99
 NO. 10154

Drawn by: AC
 Checked by: PH

Revisions:

No.	Date	Description

**MODERNIZATION PROJECT AT
 EVERGREEN ELEMENTARY SCHOOL**
 2600 ROSE MADE DRIVE
 BAKERSFIELD, CA 93304

BAKERSFIELD CITY SCHOOL DISTRICT

**BUILDING B COMMUNICATION
 DEMOLITION PLAN
 BUILDING B COMMUNICATION
 PLAN**

Job No. 1804300
 Date 1-14-2009
E-4.2