



PLUMBING SITE PLAN  
SCALE: 1/8"=1'-0"

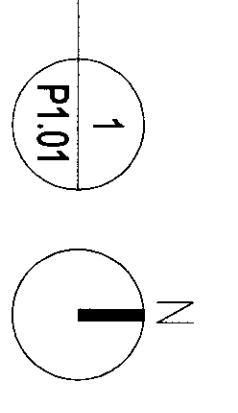

- NUMBERED NOTES**
- 1 EXISTING WATER METER IN WATER BOX TO REMAIN. DISCONNECT AND REMOVE (3/4" SW GALVANIZED IRON PIPE).
  - 2 MAKE PUP AT WATER METER WITH 1/2" ELECTRIC UNION AND NON-FER 2" TYPE "K" COPPER PIPE BELOW GRADE.
  - 3 REMOVE (3/4" GALVANIZED IRON WATER PIPE BELOW GRADE AND REPLACE WITH NEW 1/2" TYPE "K" COPPER PIPE. SIZE AS INDICATED.
  - 4 RECONNECT EXISTING JUNCTION BOX WHEN PERMITS, CAP ENDS AND ABANDON IN PLACE.
  - 5 REMOVE EXISTING WATER SPRING ALUMINUM TUBING AND REMOVE WITH NEW 1/2" TYPE "K" COPPER PIPE. SIZE AS INDICATED.
  - 6 SAW-CUT EXISTING CONCRETE WALL FOR NEW PIPE INSTALLATION AND PATCH AND REPAIR TO MATCH EXISTING.
  - 7 RE-USE EXISTING OPENING THRU TUNNEL WALL NETWORK AS INDICATED FOR NEW PERMITTING AND AFTER NEW PIPE INSTALLATION PATCH & SEAL WITH THERM-A-BOND.
  - 8 INSTALL BUILDING SERVICE IN YARD BOX AND NON-FER TYPE "K" COPPER PIPE. SIZE AS INDICATED (FOR COMBINATION SEE FLOOR PLAN EACH BUILDING).
  - 9 PILE 2'0" BELOW GRADE FOR FUTURE USE.
  - 10 INSTALL 2' 0" IN YARD BOX AND RECONNECT 2'0" TO EXISTING WITH 1/2" ELECTRIC UNION TO SERVICE BLDG. 'G'.

**NOTE:**  
FIELD VERIFY EXISTING WATER SERVICE TO (4), (3) & (5) CLASSROOM BUILDINGS AND RECONNECT TO NEW WATER DISTRIBUTION SYSTEM AS NECESSARY.

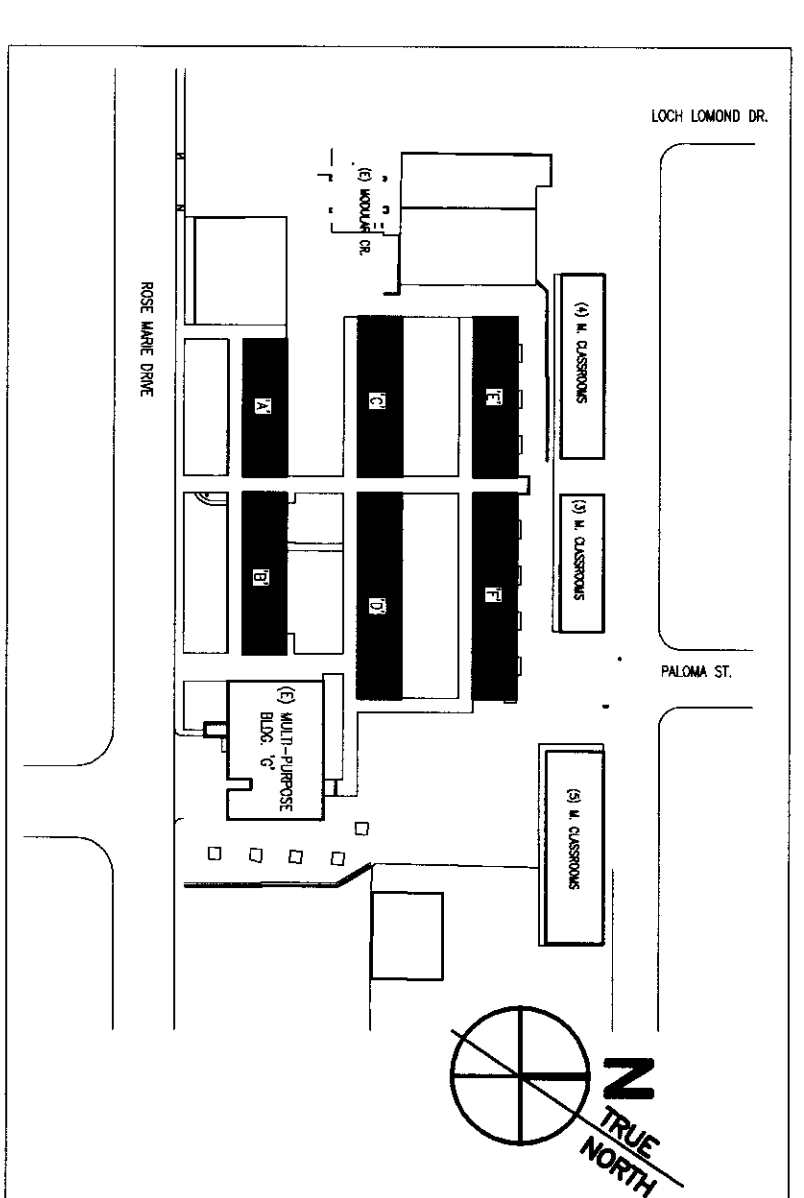

KEY PLAN

**FLEWELLING & MOODY**  
architects + education

**HEADQUARTERS OFFICE:**  
44 South Lake Avenue, 2nd Floor  
Pasadena, California 91101  
Tel: 626.799.3333  
Fax: 626.799.3334  
Email: [info@flemo.com](mailto:info@flemo.com)

**ANTELOPE VALLEY OFFICE:**  
1025 West Lincoln Street  
Lodi, California 93240  
Tel: 209.337.7777  
Fax: 209.337.7778  
Email: [antelope@flemo.com](mailto:antelope@flemo.com)

An Employee-Owned Corporation



CONTRACT NO. 4310

DATE: 11/28/17

PROJECT: MODERNIZATION PROJECT AT EVERGREEN ELEMENTARY SCHOOL, BAKERSFIELD, CA 93304

DESIGNED BY: DANIEL J. BESS, REGISTERED PROFESSIONAL ENGINEER, LICENSE NO. 4310

CHECKED BY: [Signature]

DATE: 11/28/17

No.	Date	Description

**MODERNIZATION PROJECT AT EVERGREEN ELEMENTARY SCHOOL, BAKERSFIELD, CA 93304**

2800 ROSE LANE DRIVE  
BAKERSFIELD, CA 93304

**BAKERSFIELD CITY SCHOOL DISTRICT**

PLUMBING  
SITE PLAN

Sheet No. **2804**

Date: **1-28-2010**

**P1.01**