
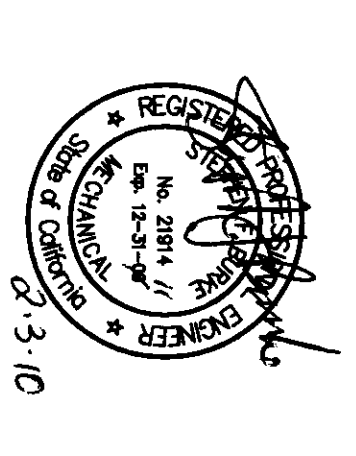


FLEWELLING & MOODY
architects & planners

HEADQUARTERS OFFICE:
141 South Lake Avenue, 2nd Floor
Beverly Hills, CA 90212
Phone: 310.277.1111
Fax: 310.277.1112
E-Mail: info@flewellingmoody.com

ANTELOPE VALLEY OFFICE:
1525 West Lancaster Boulevard
Antelope Valley, CA 91701
Phone: 916.835.3434
Fax: 916.835.3435
E-Mail: antelope@flewellingmoody.com

An Employee Owned Corporation

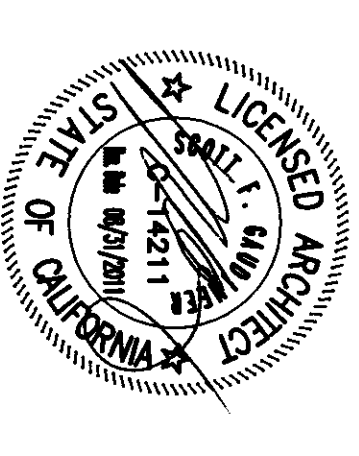


REGISTRATION STAMP
DIV. OF THE STATE ARCHITECT
APPROX. 11.2.8.11
DATE: 11.2.8.11
BY: [Signature]
11.2.8.2010

DATE: 11.2.8.2010

MODERNIZATION PROJECT AT
EVERGREEN ELEMENTARY SCHOOL
2000 ROSE LAURE DRIVE
BRACKENFIELD, CA 95305

BAKERFIELD CITY SCHOOL DISTRICT
BUILDING 'G' - MULTI-PURPOSE
PLUMBING
DEMOLITION PLAN
RECONSTRUCTION PLAN


Job No. 1004
Date 1-28-2010
P2.01G

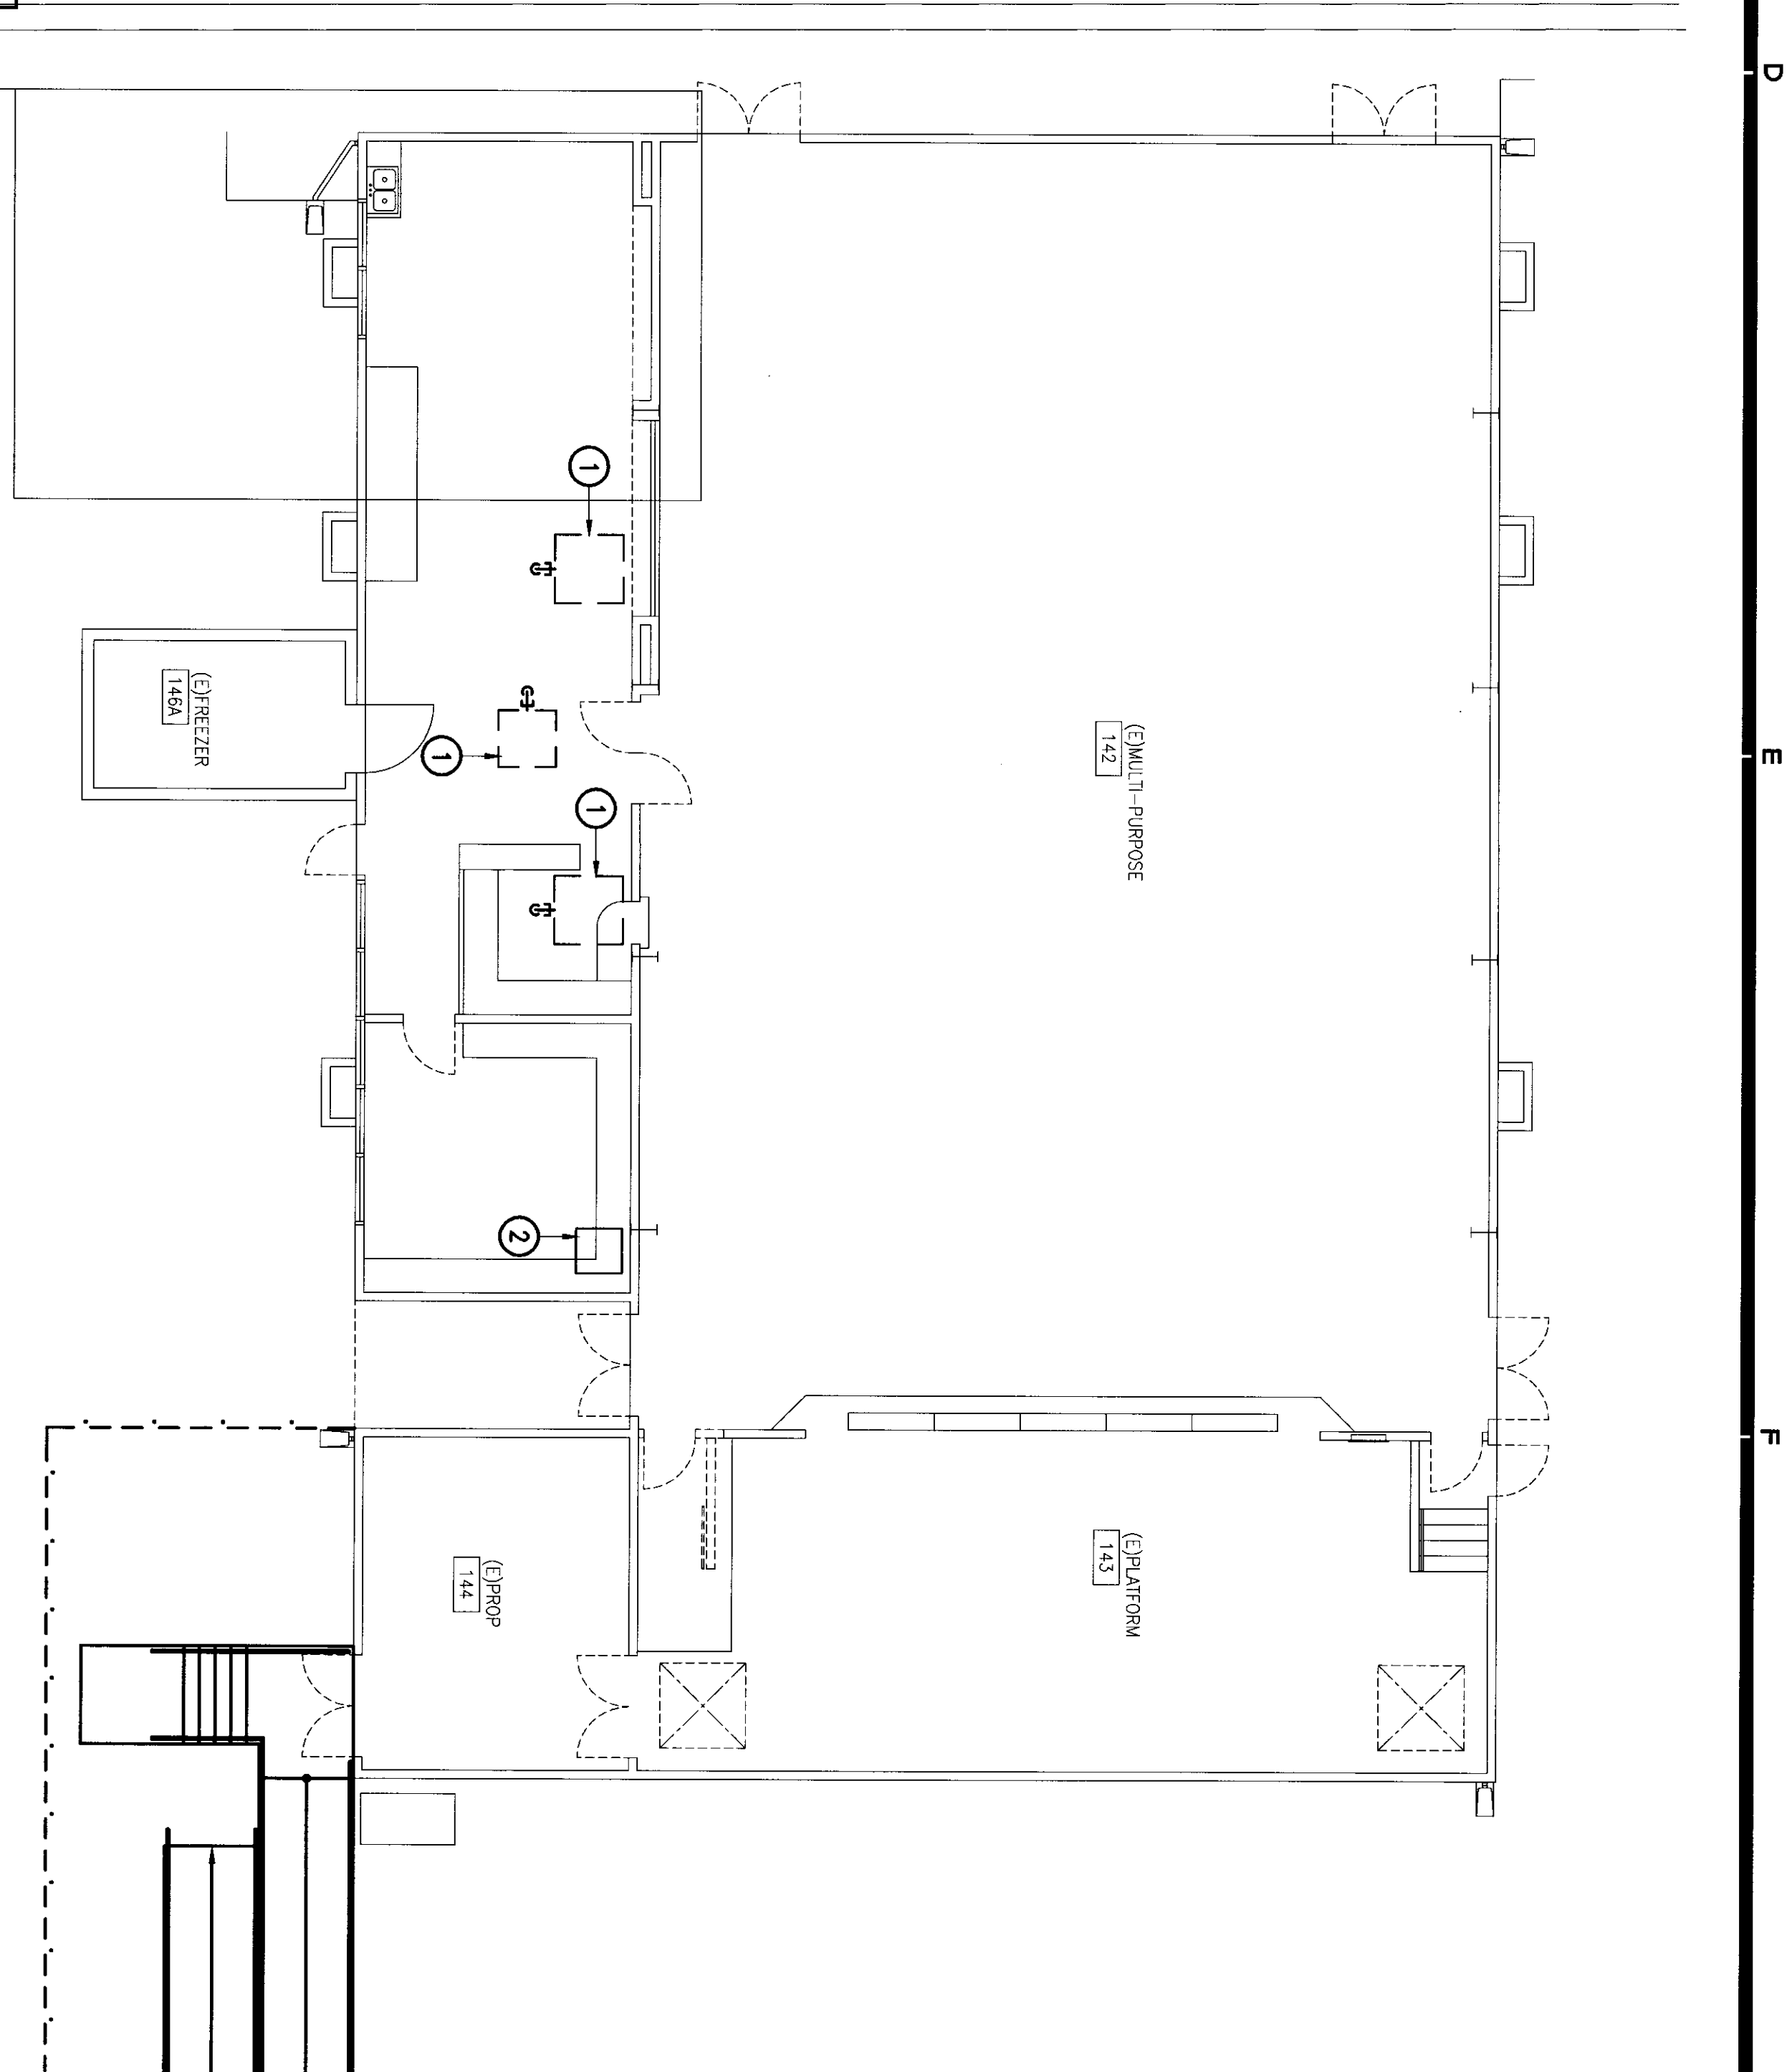

PLUMBING DEMOLITION FLOOR PLAN - BUILDING 'G' - MULTI-PURPOSE
SCALE: 1/8"=1'-0"

DEMOLITION NOTES


- EXISTING A/C UNIT ON ROOF TO BE REMOVED. SEE MECHANICAL DRAWINGS, DISCONNECT (SWITCHER LINE AND CAP FOR NEW P.O.C. VENT/FLUE LOCATION).
- EXISTING FINISH IN STORAGE ROOM TO BE REMOVED. SEE MECHANICAL DRAWINGS, DISCONNECT (E)-1/4" GAS AND CAP.

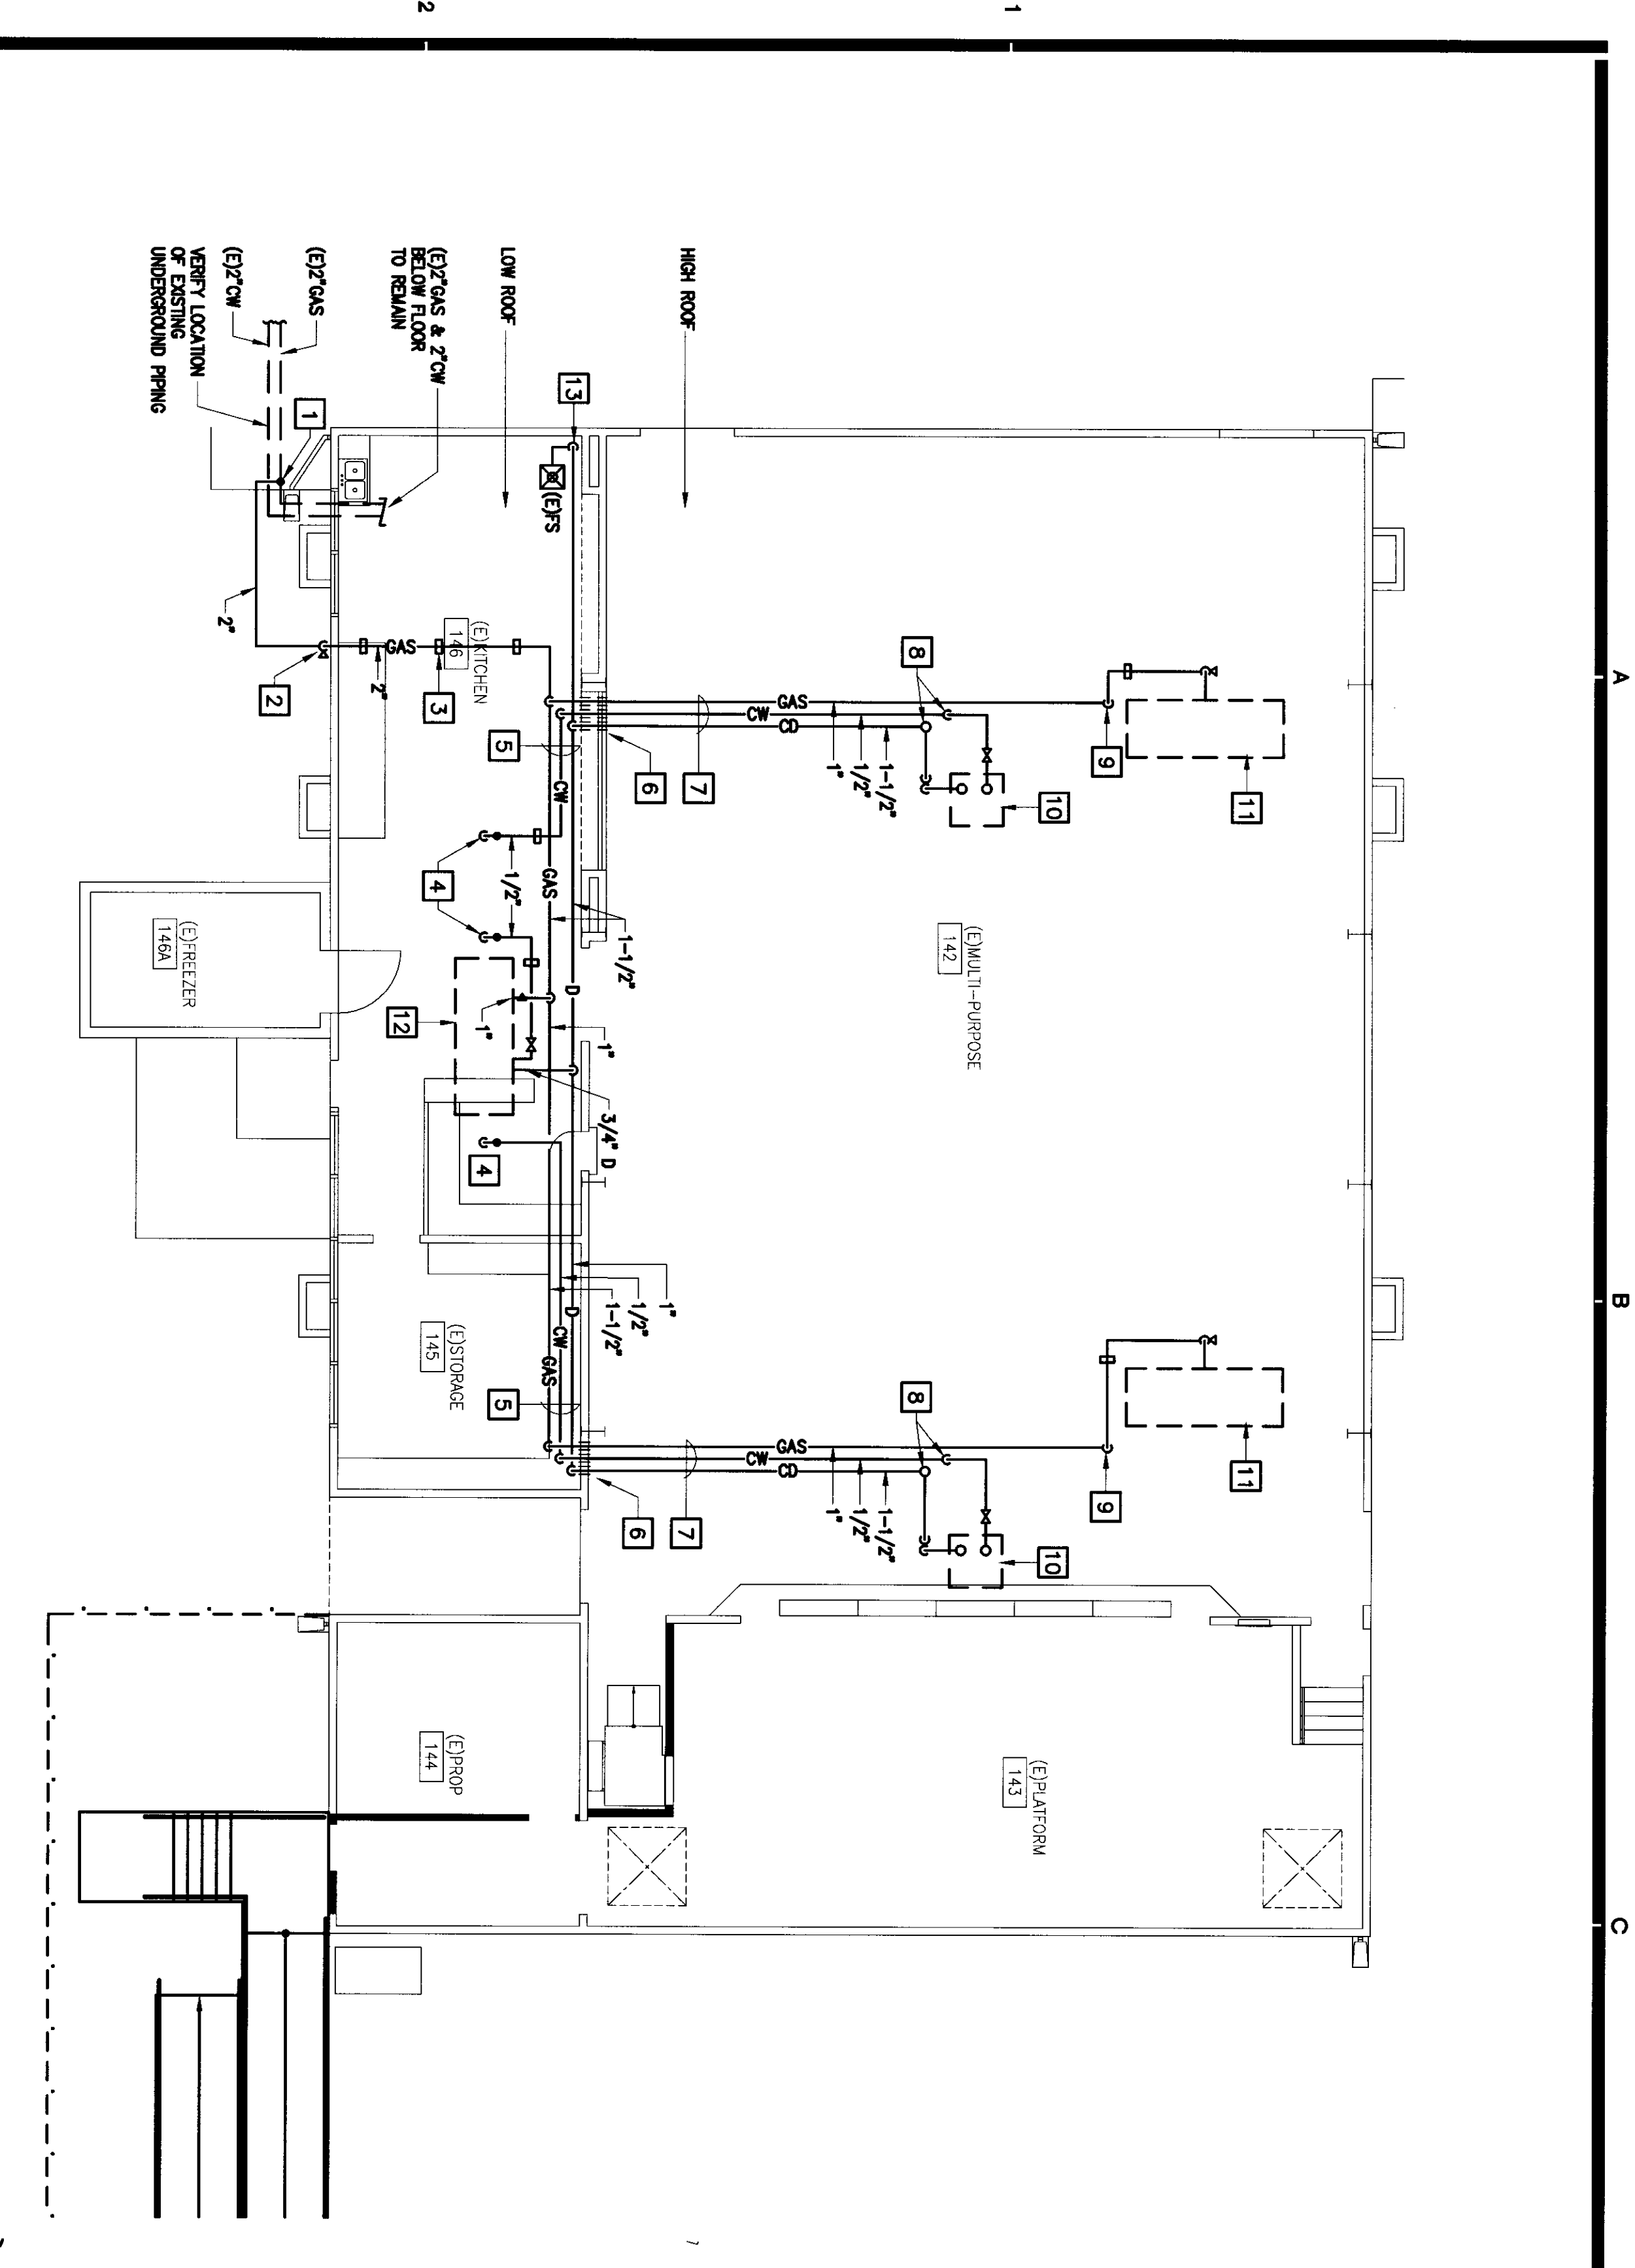


PLUMBING RECONSTRUCTION FLOOR PLAN - BUILDING 'G' - MULTI-PURPOSE
SCALE: 1/8"=1'-0"

RECONSTRUCTION NOTES


- MAKE P.O.C. TO (E) 2" GAS WITH NEW FITTINGS AND RUN NEW 2" GAS BELOW GRADE.
- RISE 2" GAS UP EXPOSED ON WALL AND OFFSET TO RUN ON LOW ROOF. INSTALL GAS SOY AT BASE OF RISER, PRIME AND PAINT EXPOSED PIPE TO MATCH WALL COOK.
- SUPPORT PIPING TO ROOF WITH ONE-STRUT PIPE SUPPORTS. SEE DETAIL. (P2.01G)
- MAKE P.O.C. TO (E) 1/2" CW AND EXTEND NEW PIPING ON ROOF TO SERVE NEW MECHANICAL EQUIPMENT.
- RACK DRAIN, WATER AND GAS PIPING ON MULTI-PURPOSE EXTERIOR WALL. SUPPORT TO WALL WITH ONE-STRUT PIPE SUPPORTS.
- PROVIDE OPENING THRU WALL BELOW HIGH ROOF AS REQUIRED FOR NEW PIPE PENETRATION, AND PATCH AND SEAL WATER TIGHT.
- RUN PIPING EXPOSED AT CEILING NEXT TO STRUCTURAL BEAM, SUPPORT TO ROOF STRUCTURE WITH PIPE TRAPEZE, SLOPE DRAIN LINE AT 1% MIN. PRIME AND PAINT EXPOSED PIPING CEILING COOK.
- 1/2" CW UP THRU ROOF AND 1-1/2" CD DOWN FROM ROOF WITH ROOF FLASHING. SEE TYP. DETAIL. (P1)
- 1" GAS UP THRU ROOF WITH ROOF FLASHING.
- EWAP COOLER ON ROOF. SEE MECHANICAL DRAWINGS, ROUGH-IN AND CONNECT 1/2" CW WITH SOY, AND 3/4" CD WITH VENTED TRAP. SEE DETAIL. (P2.01G)
- ROOF MOUNTED GAS FINNAGE. SEE MECHANICAL DRAWINGS, ROUGH-IN AND CONNECT 1-1/4" GAS WITH GAS COCK AND FLEX CONNECTOR 1/2" CW WITH SEE TYP. DETAIL. (P2)
- 1-1/2" DRAIN LINE DOWN THRU ROOF WITH ROOF FLASHING, EXTEND DOWN EXPOSED ON INTERIOR WALL AND STILL TO FLOOR SINK WITH 2" AIR GAP.

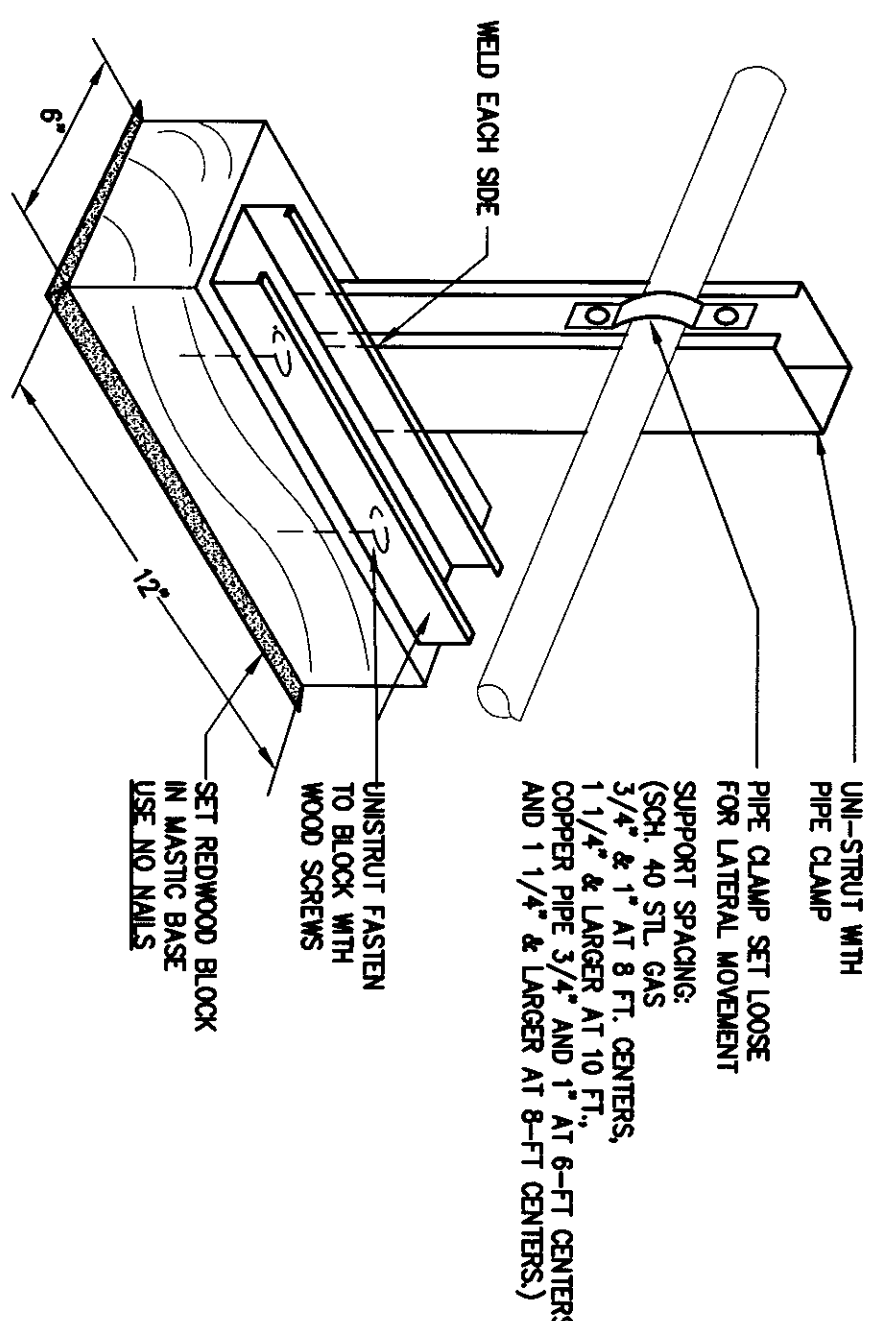

TYP. PIPE SUPPORT ON ROOF
SCALE: 1/4"=1'-0"

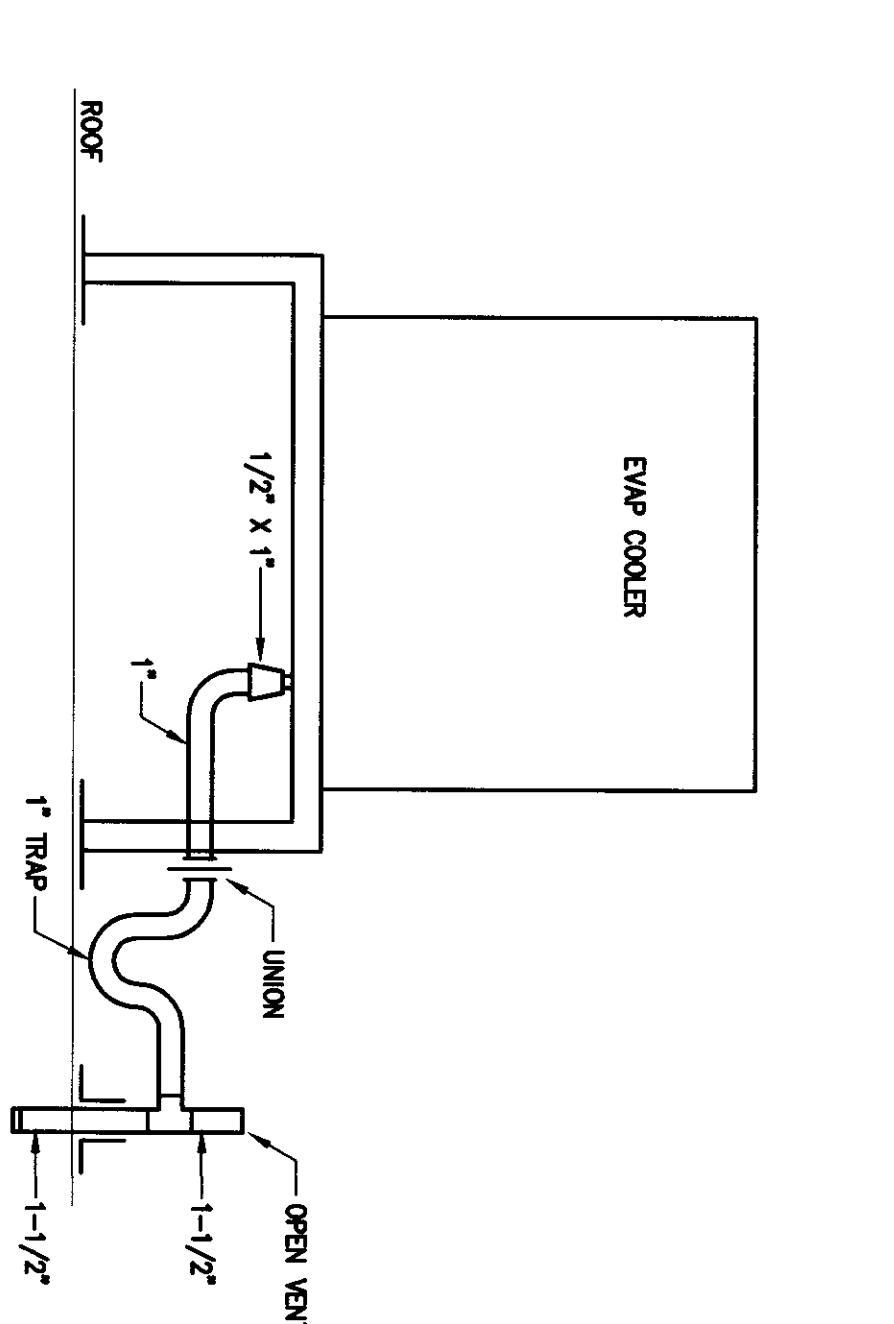

DRAIN CONNECTION DETAIL
SCALE: 1/4"=1'-0"

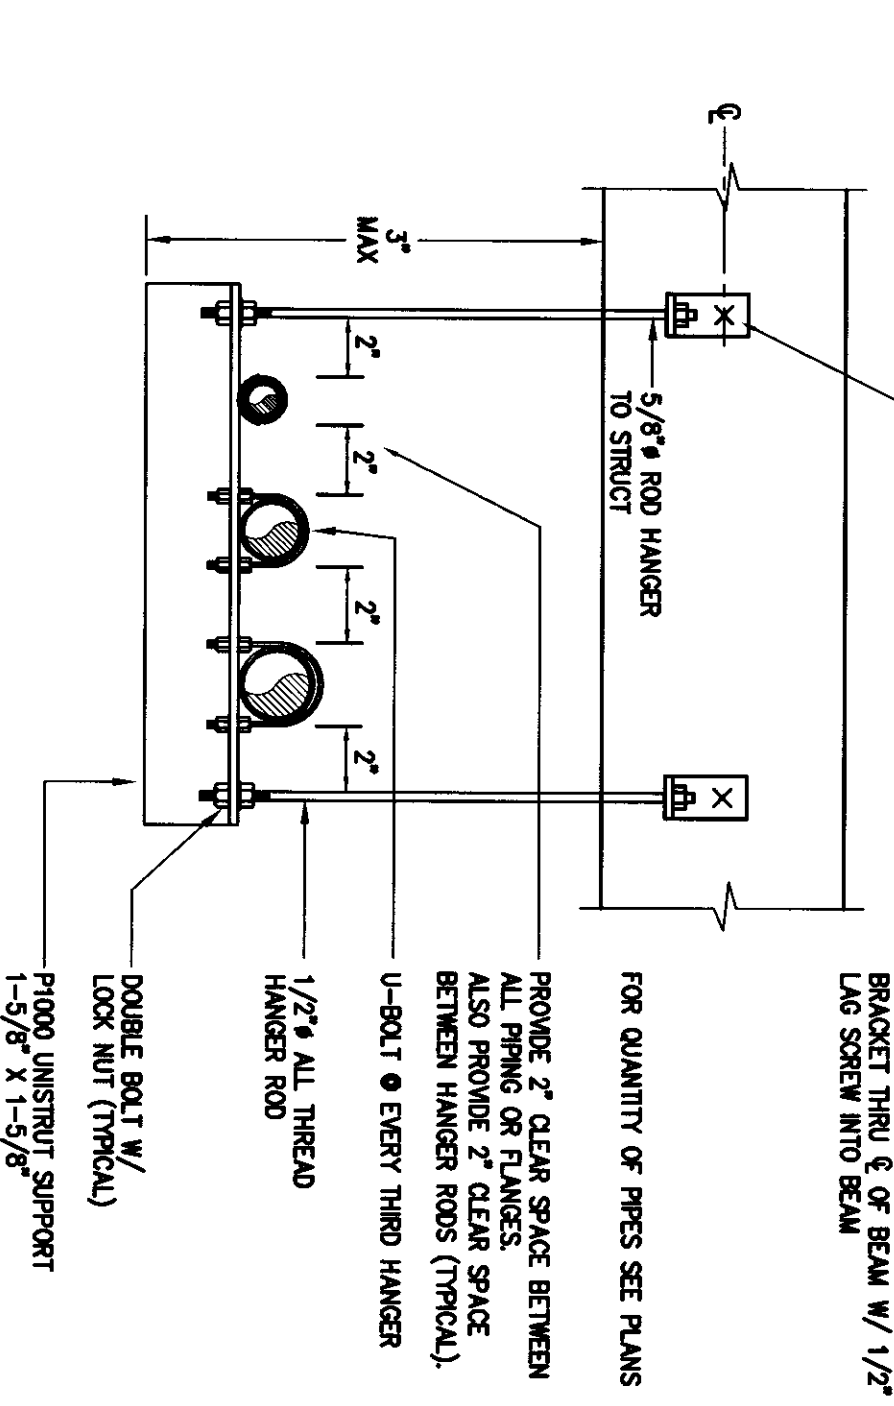

PIPE TRAPEZE DETAIL
SCALE: 1/4"=1'-0"