



TYPICAL CL. RM. ELEVATIONS
SCALE 1/4" = 1'-0"

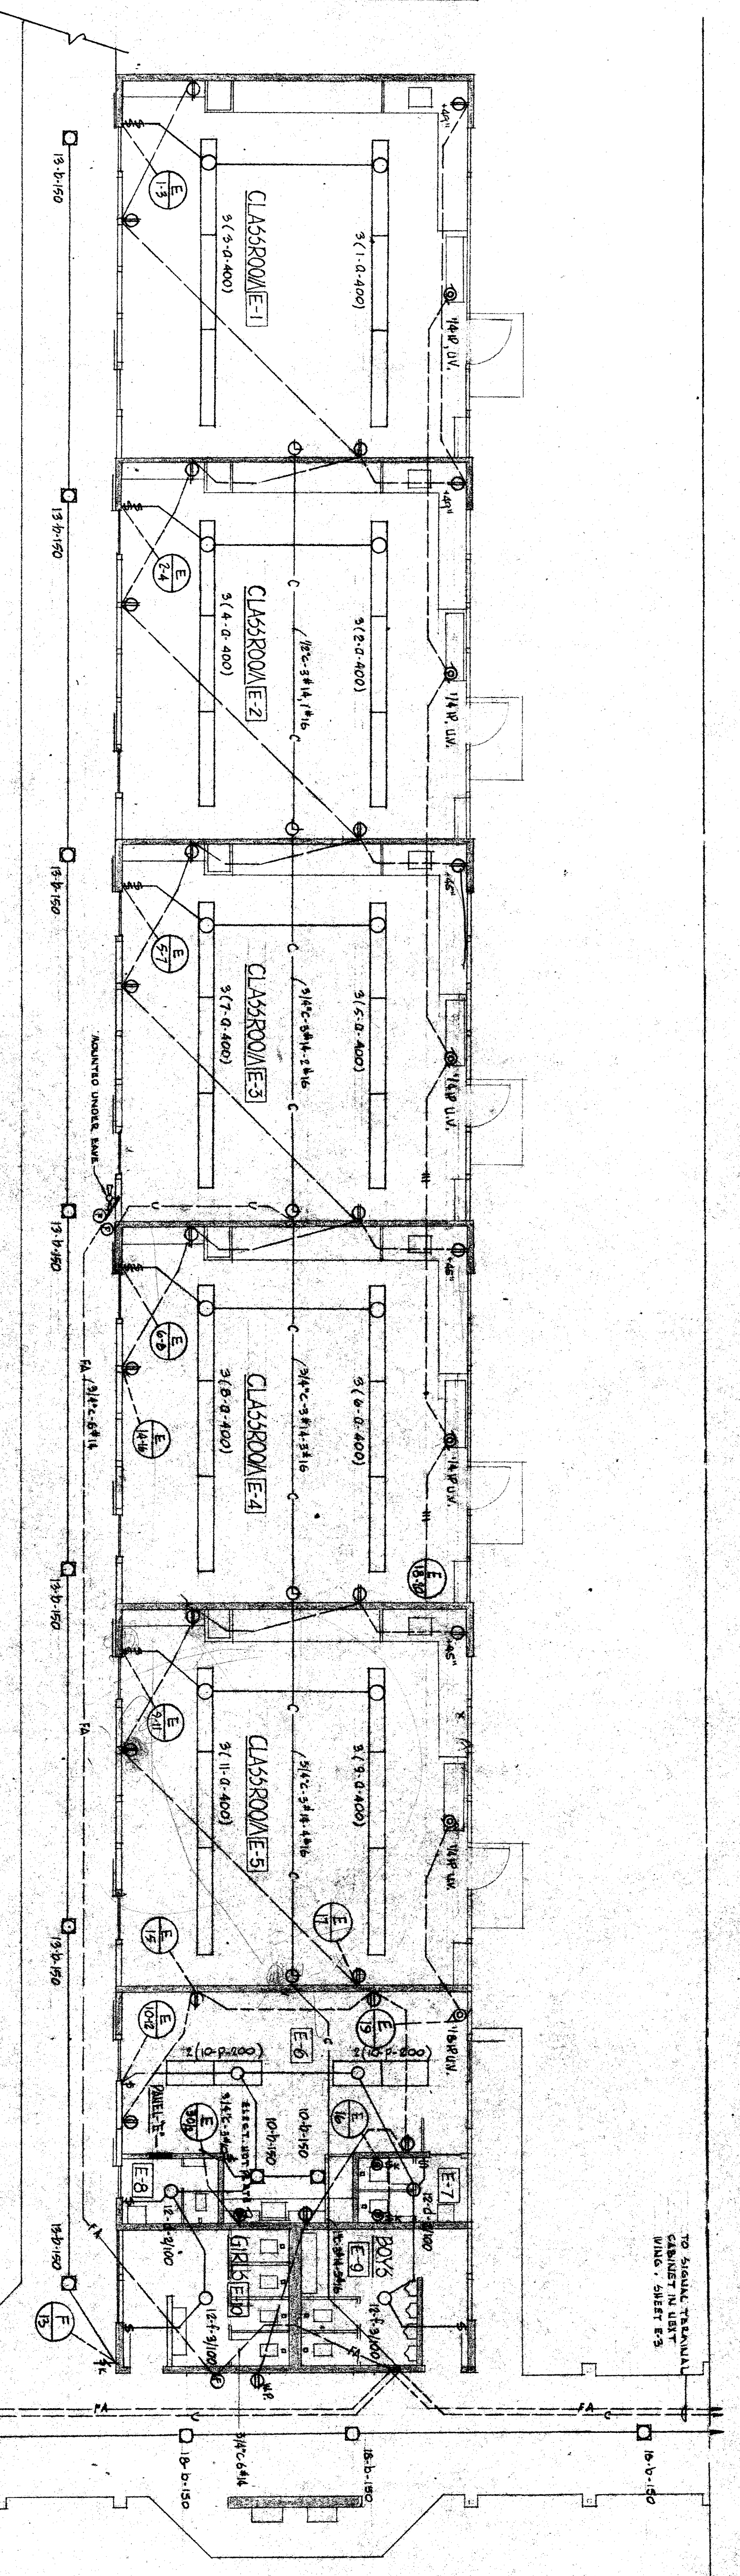


FLOOR PLAN OF UNIT "E" - ELECTRICAL LAYOUT
SCALE 1/8" = 1'-0"

NOTE
SEE SECTION DRAWING
THIS SHEET FOR TYPE "B"
ACCOUNTING.

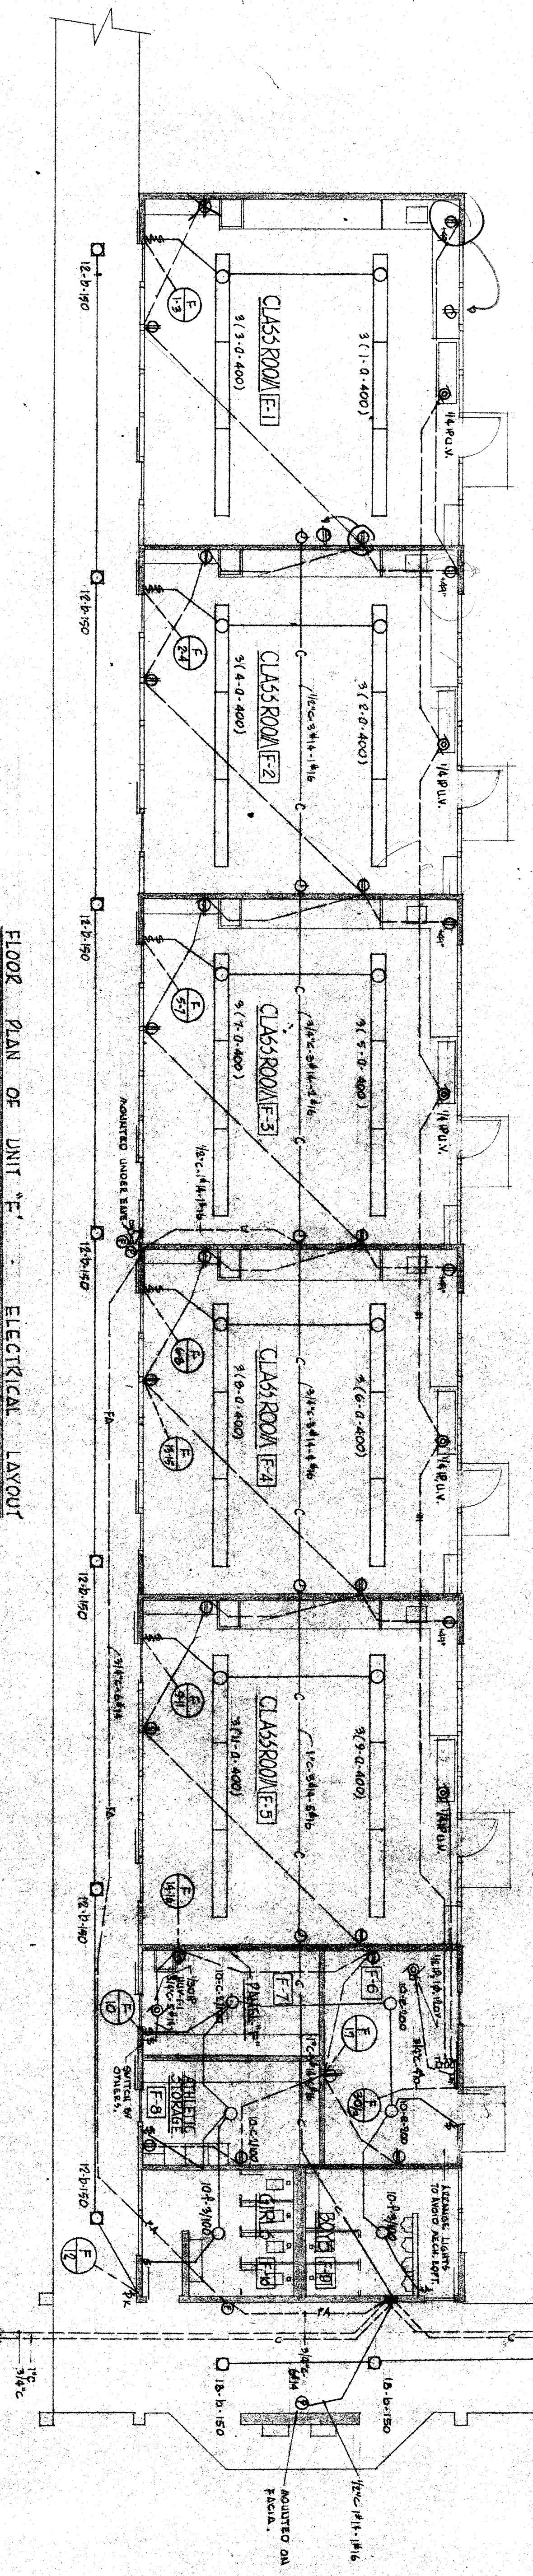

FLOOR PLAN OF UNIT "F" - ELECTRICAL LAYOUT
SCALE 1/8" = 1'-0"

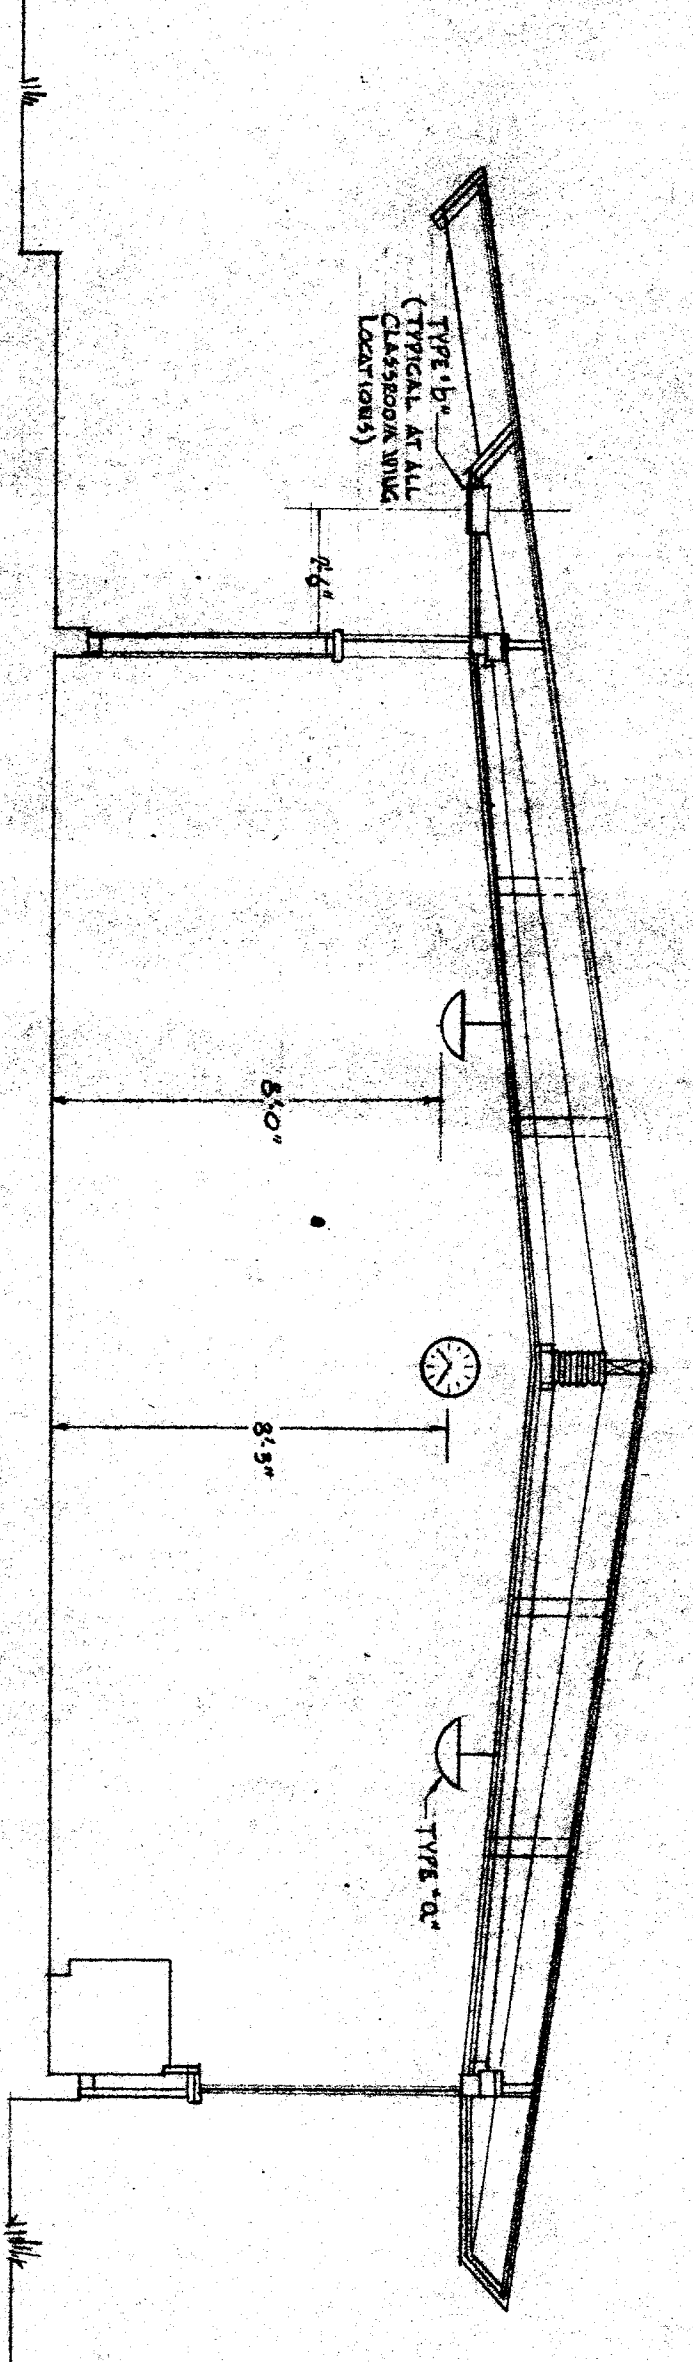

TYPICAL CL. RM. & KINDERGARTEN SECTION
SCALE 1/4" = 1'-0"

OFFICE OF SUPERINTENDENT OF SCHOOLS STATE OF CALIFORNIA DEPARTMENT OF PUBLIC WORKS DIVISION OF ARCHITECTURE		PAKERSFIELD CITY SCHOOL DIST. PAKERSFIELD, CALIFORNIA BOARD OF EDUCATION	
APPROVED	DATE	REVISIONS	DATE
E. W. KROG ELECTRICAL ENGINEER REGISTERED CALIFORNIA		ERNEST L. MCGOY A.I.A. ARCHITECT PAKERSFIELD CALIFORNIA	
BENTON PARK SCHOOL WILSON ROAD & BENTON STREET PAKERSFIELD, CALIFORNIA		SHEET NO. 42	