

OFFICE OF SUPERINTENDENT OF SCHOOLS
 STATE OF CALIFORNIA
 DEPARTMENT OF PUBLIC WORKS
 DIVISION OF ARCHITECTURE

BAKERFIELD CITY SCHOOLS, DIST.
 BAKERFIELD, CALIFORNIA
 BOARD OF EDUCATION

APPROVED _____ DATE _____

CHIEF AND VARIOUS ALL DIMENSIONS AND CONDITIONS OF THE WORK. REPORT ALL DISCREPANCIES TO THE ARCHITECT.

MARK	DATE	REVISIONS
▲		
▲		
▲		

DATE _____

DRAWN BY _____

CHECKED BY _____

DATE _____


ERNEST L. MCCOY A.F.A. ARCHITECT
 3811 H STREET
 BAKERSFIELD

BENTON PARK SCHOOL
 WILSON ROAD & BENTON STREET
 BAKERSFIELD, CALIFORNIA

SHEET NO. 12

PLUMBING PLAN
 Scale 1/8" = 1'-0"

NORTH

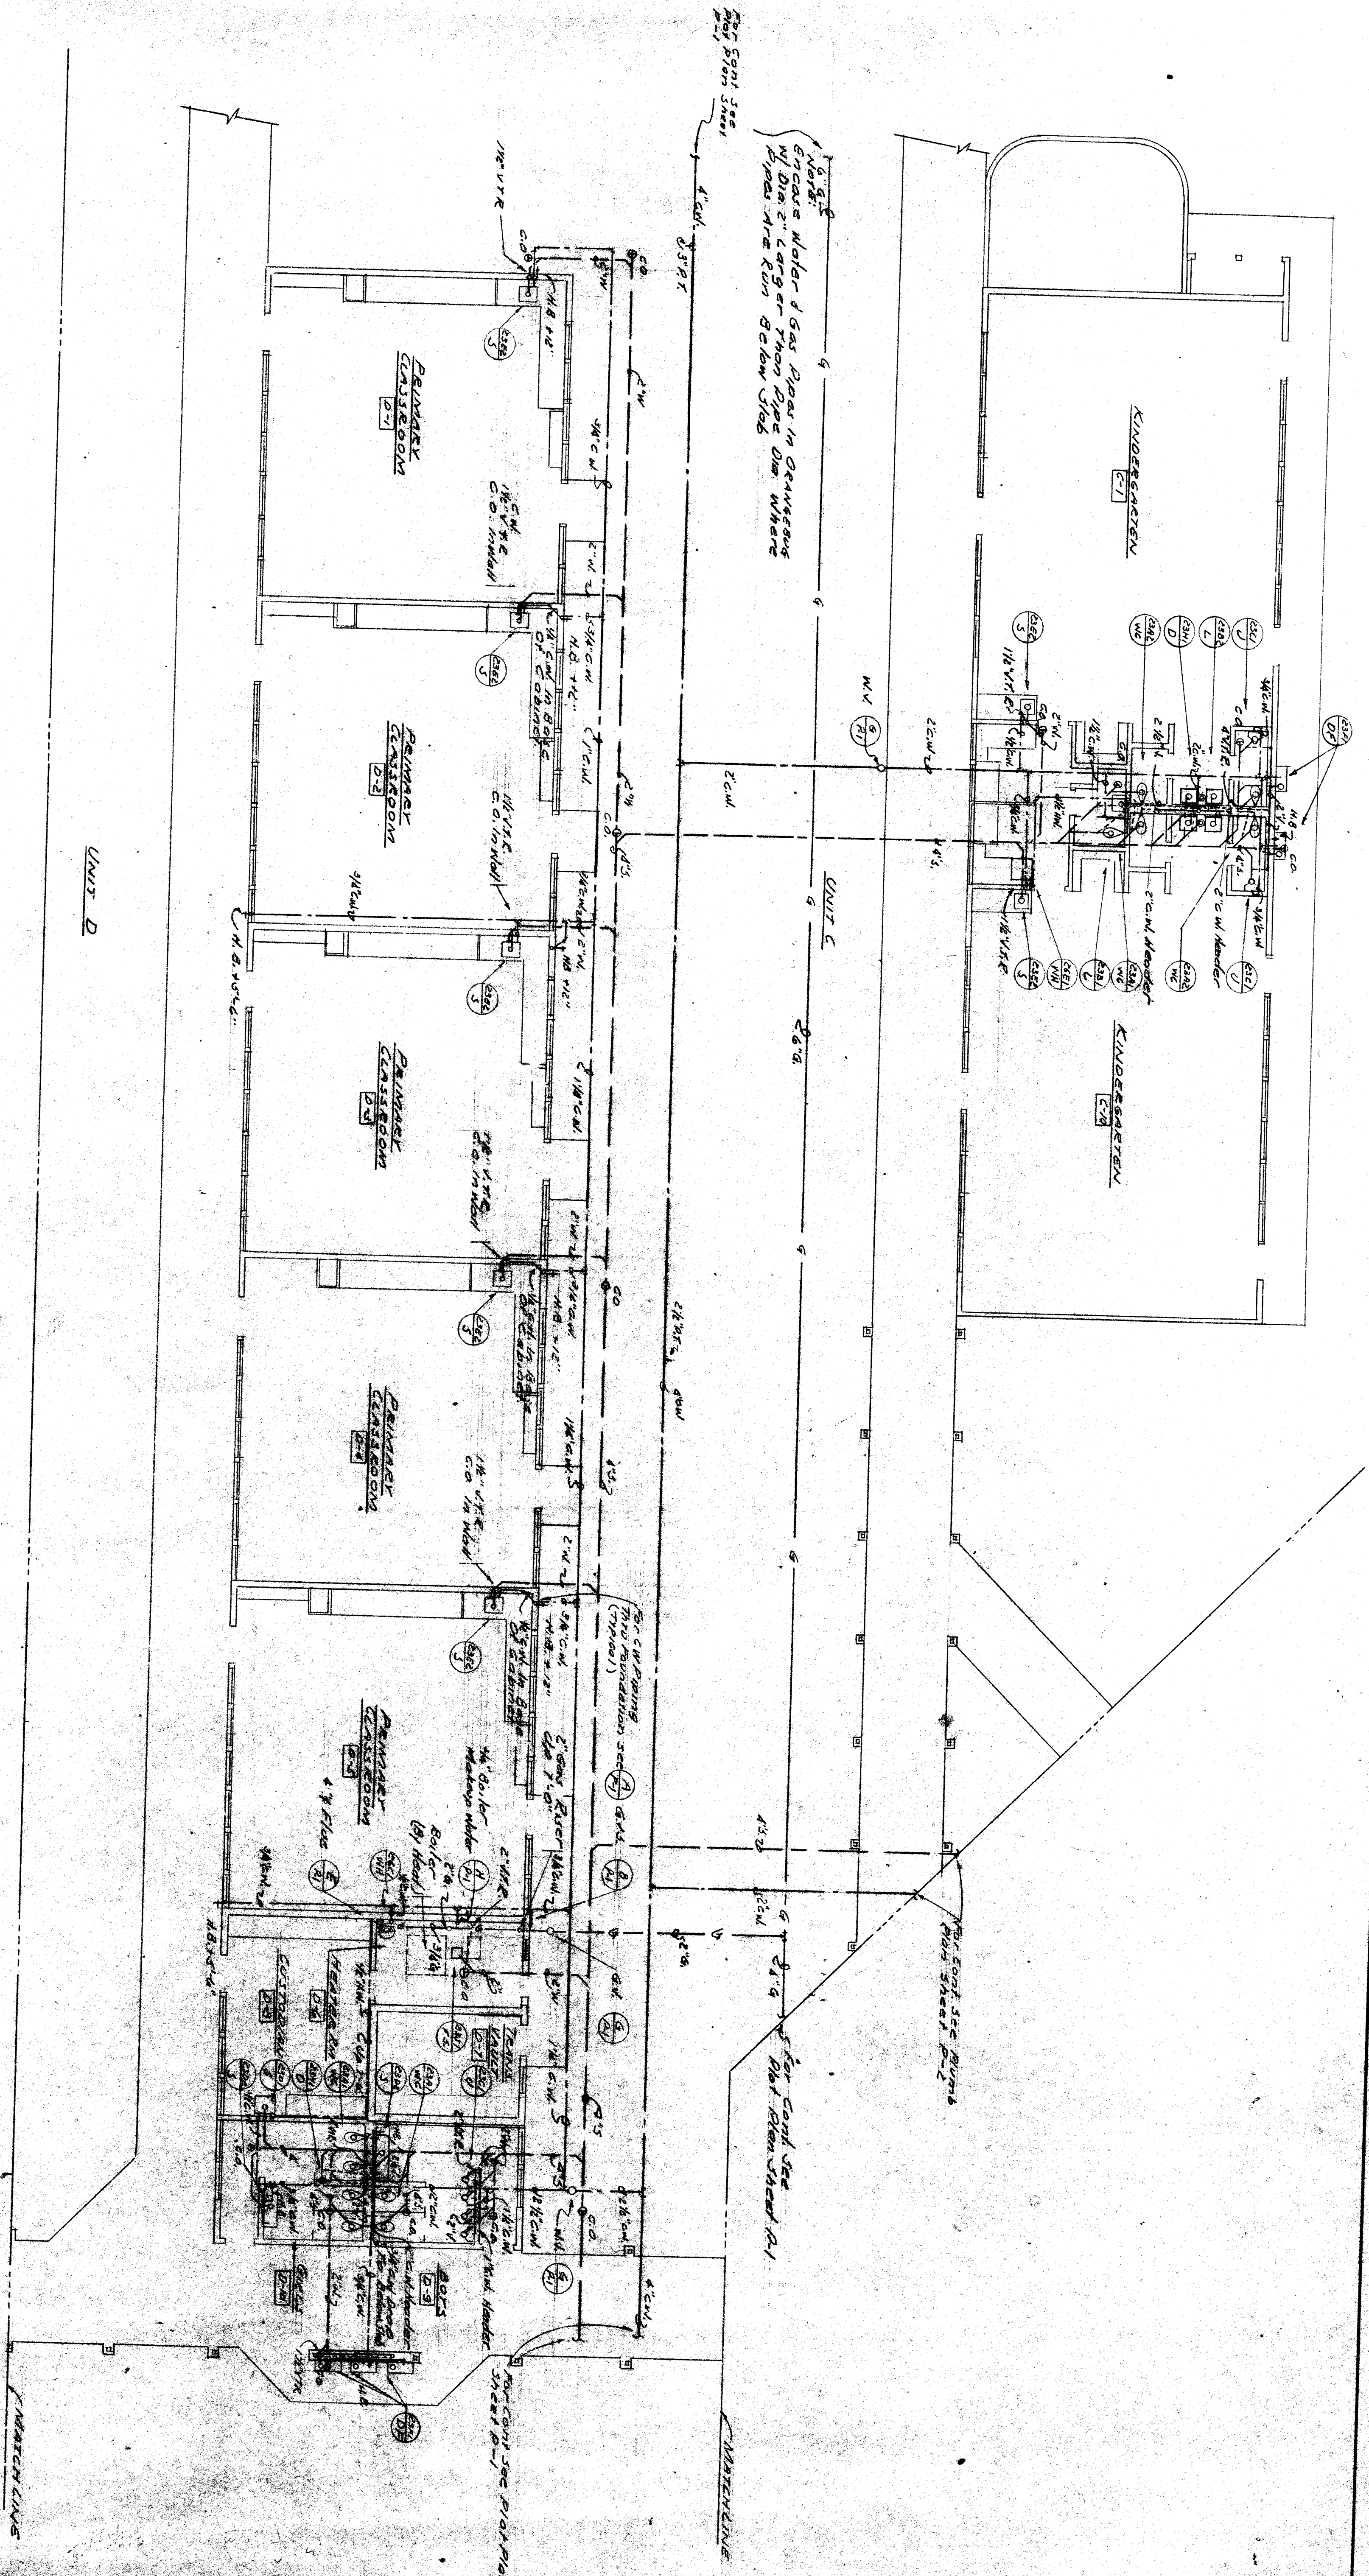

Water Meter & Gas Meter in Dressing Room
 Note: Water Meter & Gas Meter in Dressing Room
 Note: Water Meter & Gas Meter in Dressing Room

See Foundation Section (17000)
 Note: See Foundation Section (17000)
 Note: See Foundation Section (17000)

See Foundation Section (17000)
 Note: See Foundation Section (17000)
 Note: See Foundation Section (17000)