


THE ARCHITECT, ENGINEER, AND INTERIOR DESIGNER SHALL BE RESPONSIBLE FOR OBTAINING ALL NECESSARY PERMITS AND APPROVALS FROM THE LOCAL, STATE, AND FEDERAL AGENCIES. THE CONTRACTOR SHALL BE RESPONSIBLE FOR OBTAINING ALL NECESSARY PERMITS AND APPROVALS FROM THE LOCAL, STATE, AND FEDERAL AGENCIES. THE CONTRACTOR SHALL BE RESPONSIBLE FOR OBTAINING ALL NECESSARY PERMITS AND APPROVALS FROM THE LOCAL, STATE, AND FEDERAL AGENCIES.

KEY PLAN


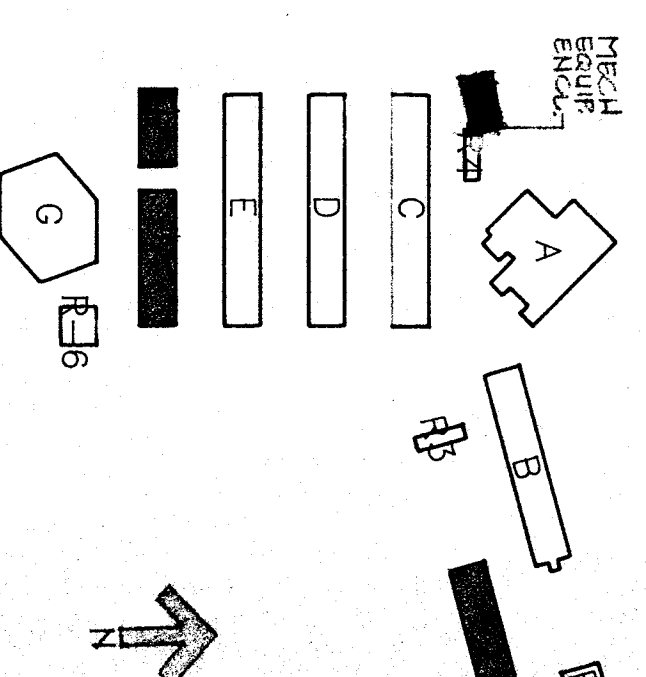


BAKERSFIELD CITY SCHOOL DISTRICT BOARD OF EDUCATION


DATE	APPROVED
7-25-91	EDICONS
DATE	ISSUED FOR
DATE	REVISIONS

SHEET TITLE
PLUMBING FLOOR PLANS
BUILDINGS F, R-5 & R-2


APPROVED ARCHITECT: *Donald W. Renfro*
 CHECKED: JFM
 DRAWN BY: JES, B
 PROJECT NO.: 86-316/PW
 SHEET NUMBER: B6161E20086

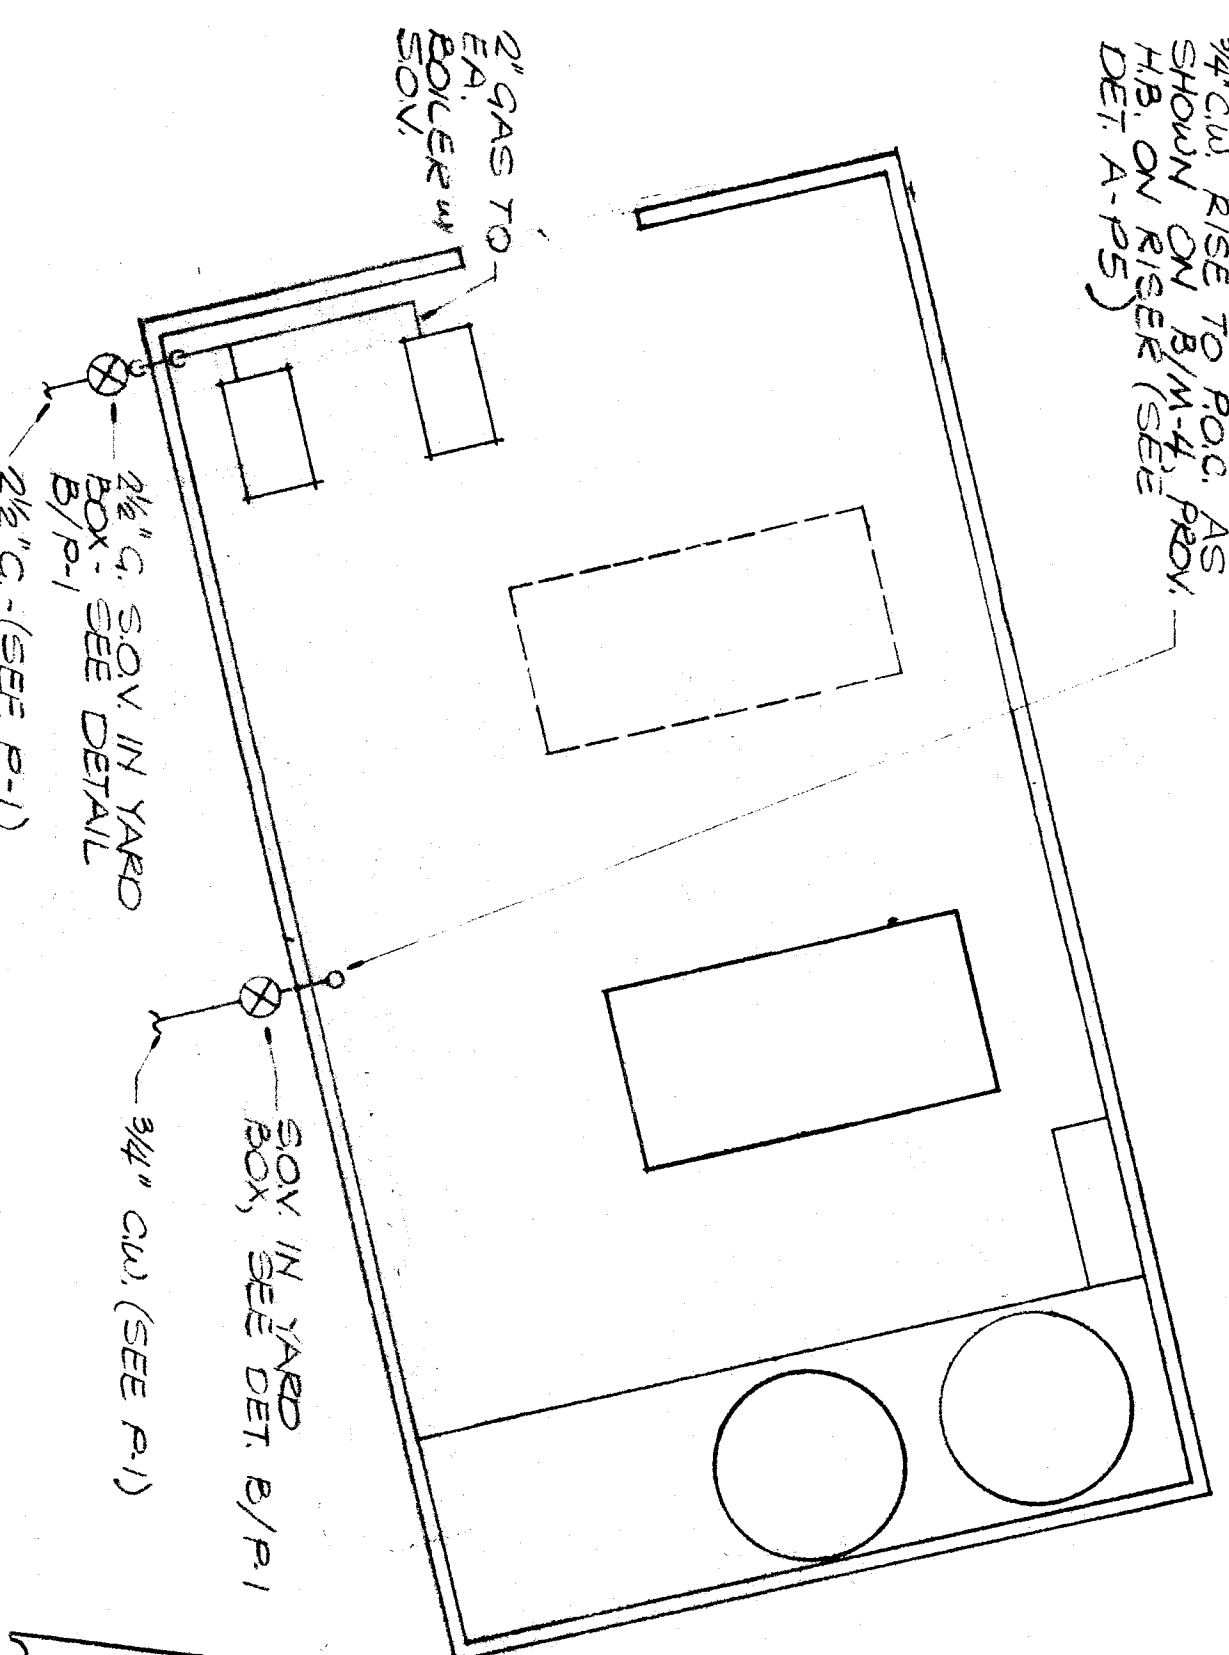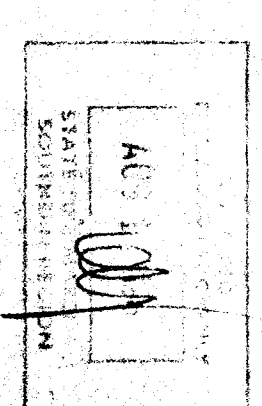


MECHANICAL EQUIPMENT ENCLOSURE
 SCALE: 1/8" = 1'-0"

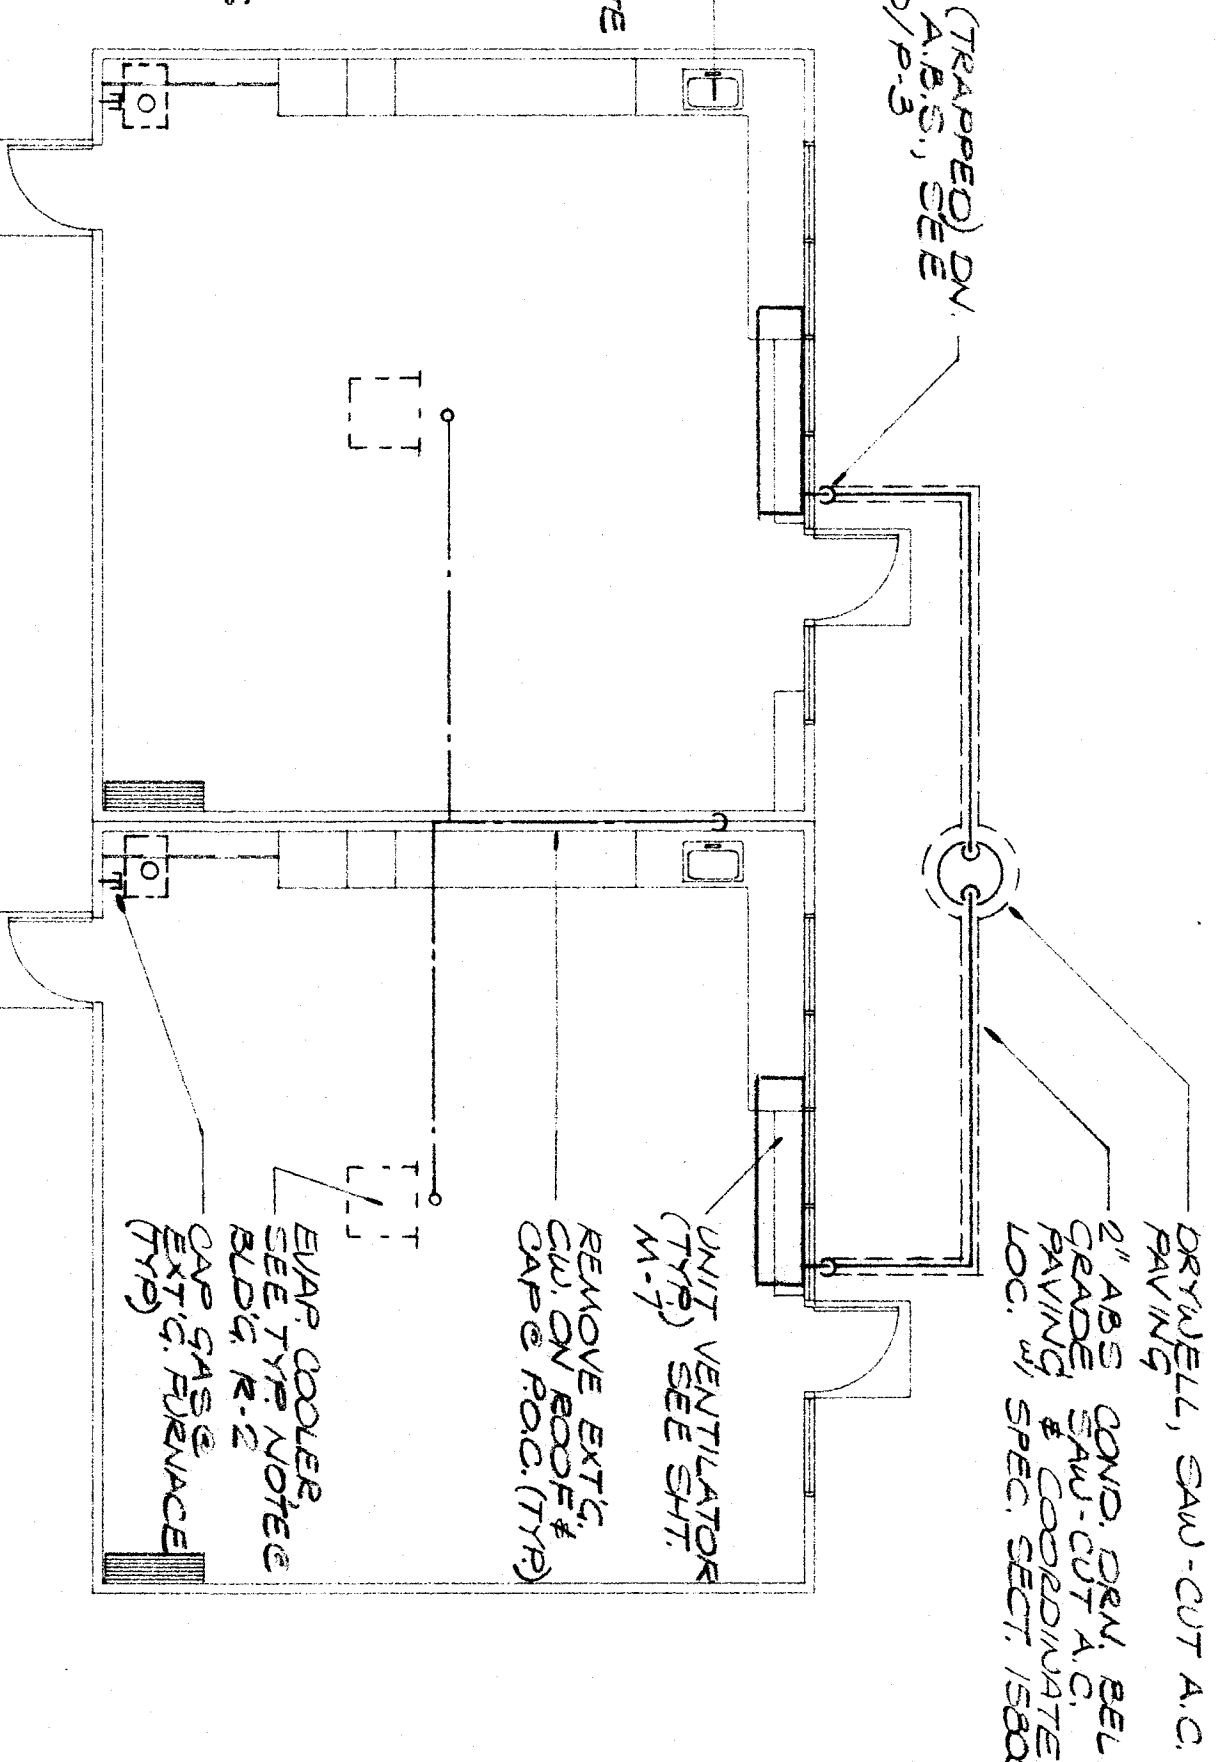


BUILDING R-5 (PLUMBING FLOOR PLAN)
 SCALE: 1/8" = 1'-0"

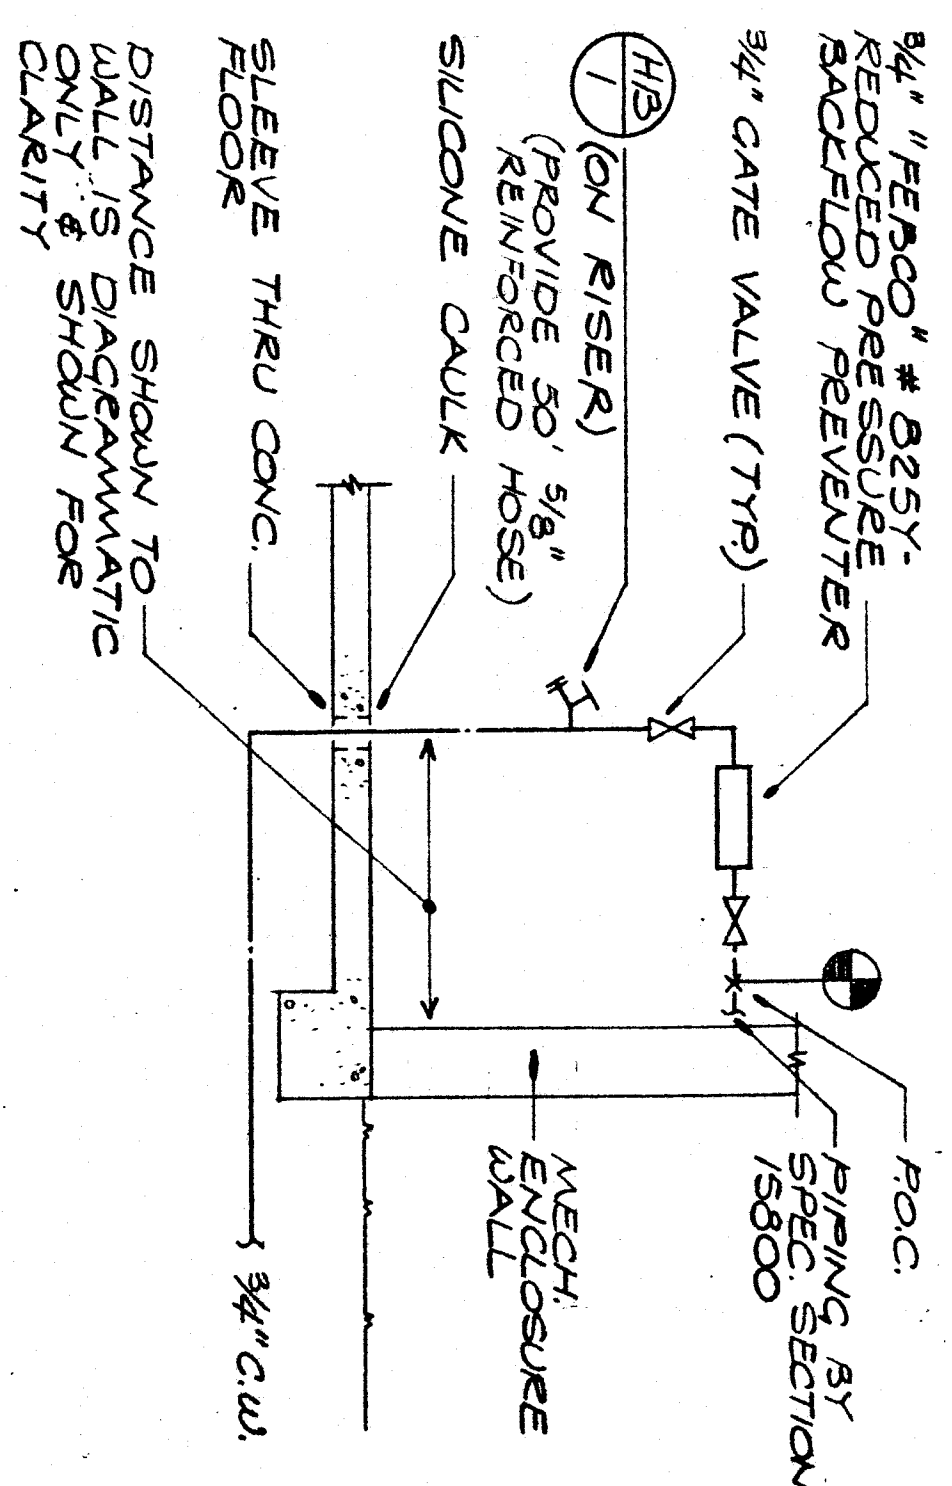


MAKE-UP WATER DETAIL
 SCHEMATIC

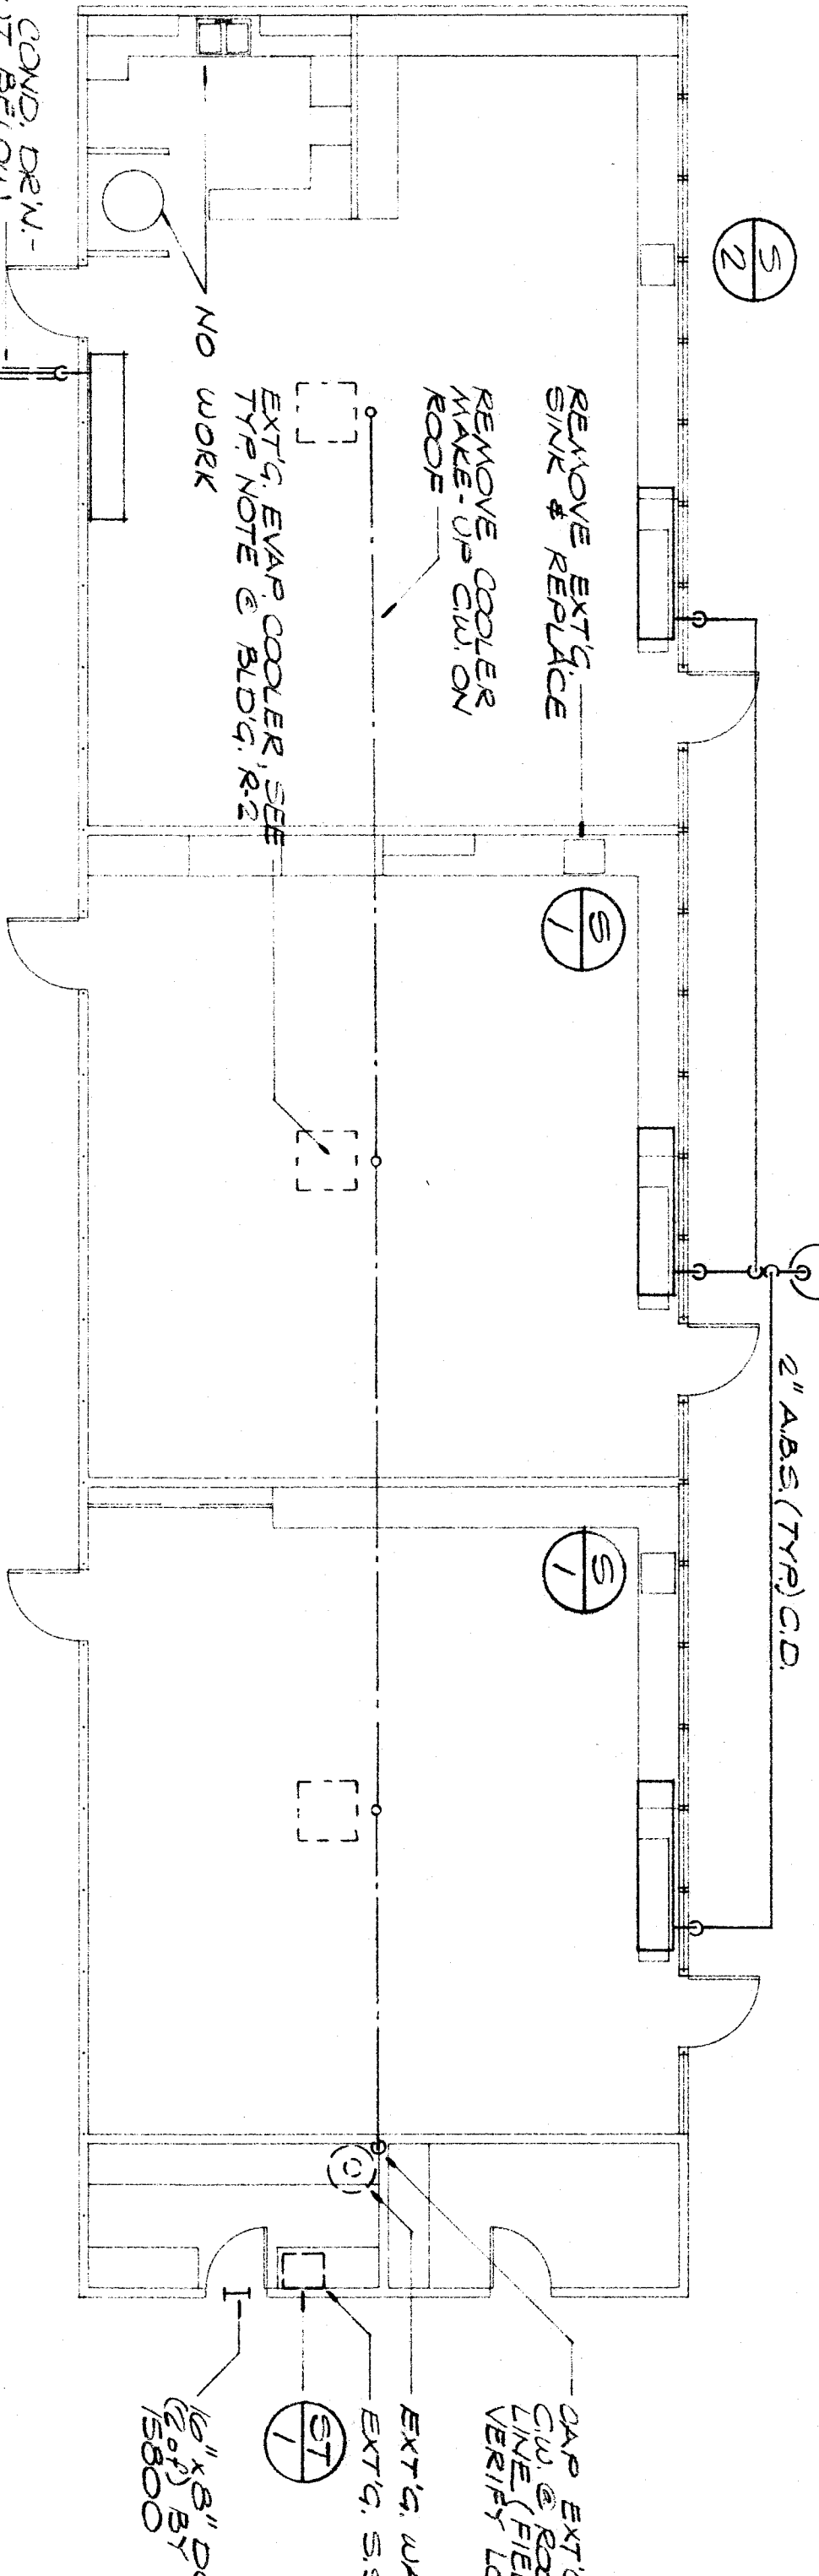


BUILDING F (PLUMBING FLOOR PLAN)
 SCALE: 1/8" = 1'-0"

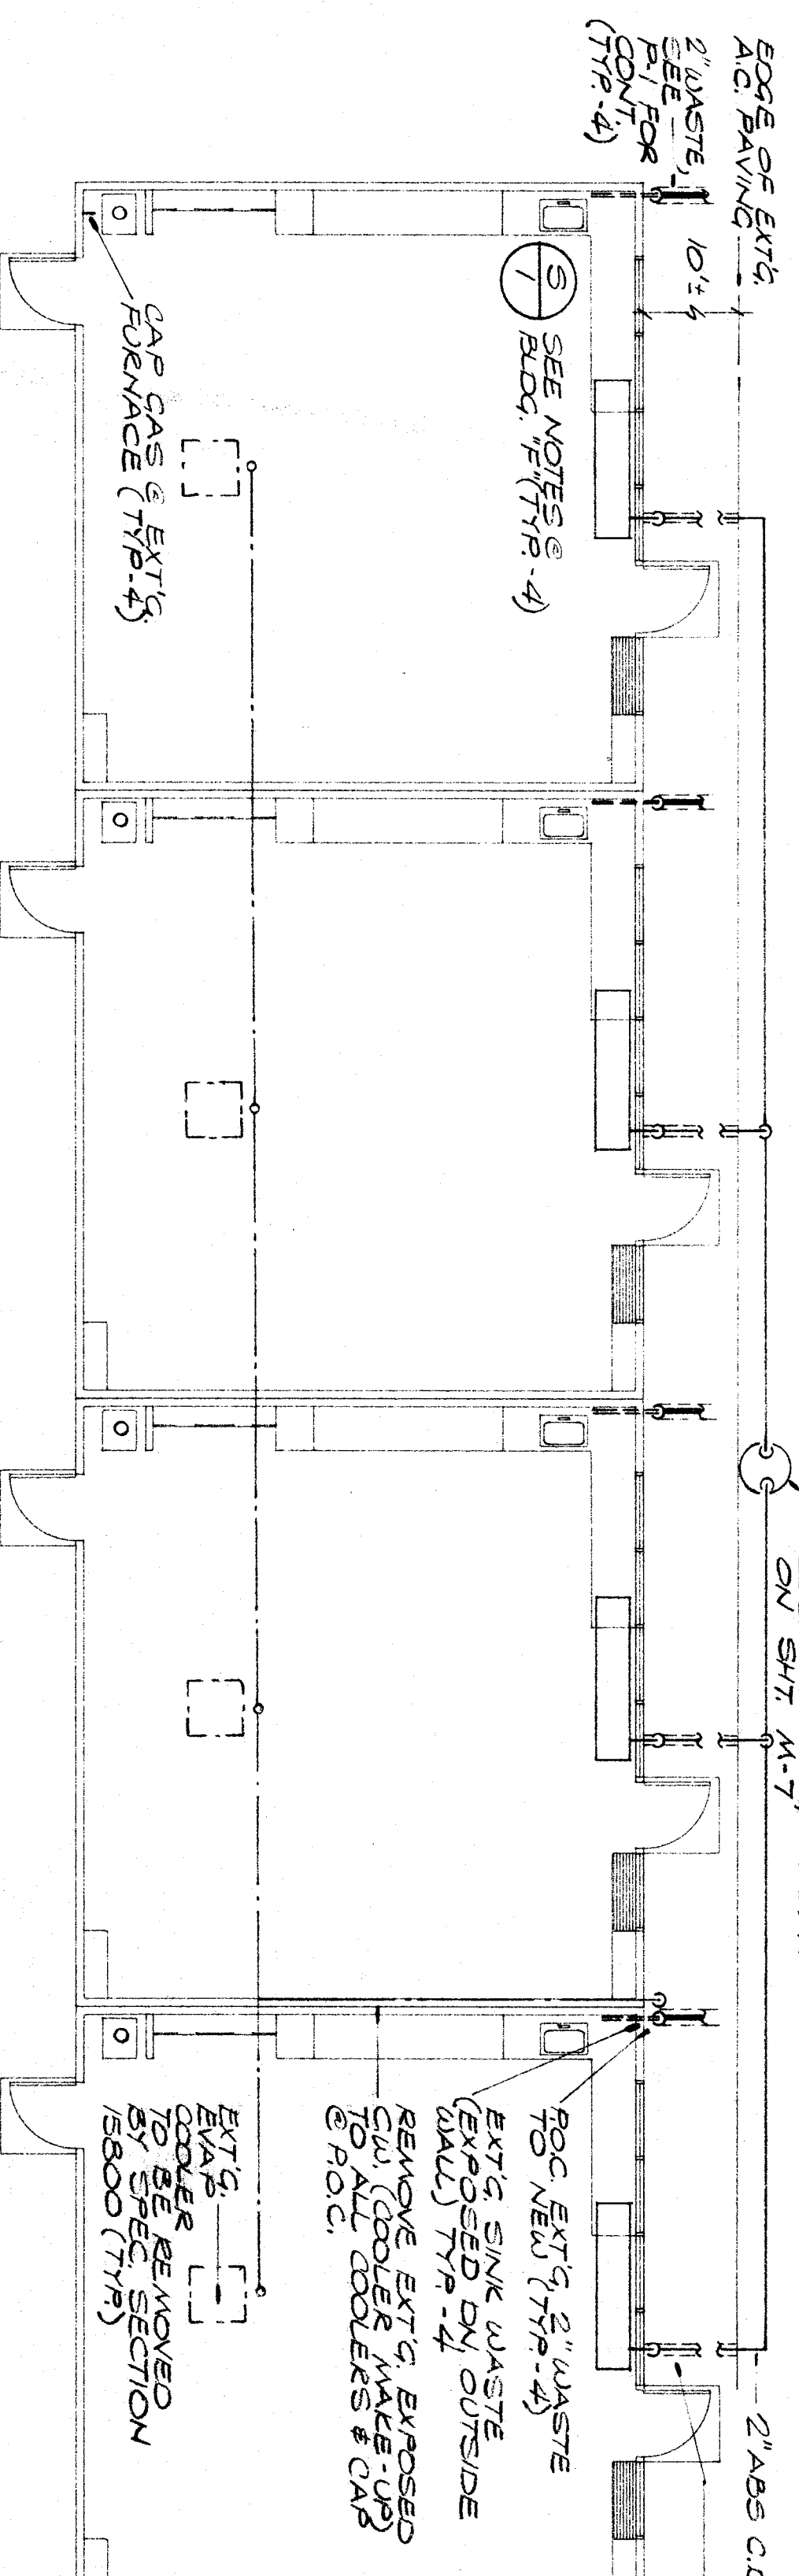

 BUILDING R-2 (PLUMBING FLOOR PLAN)
 SCALE: 1/8" = 1'-0"



WALL PIPE ANCHOR

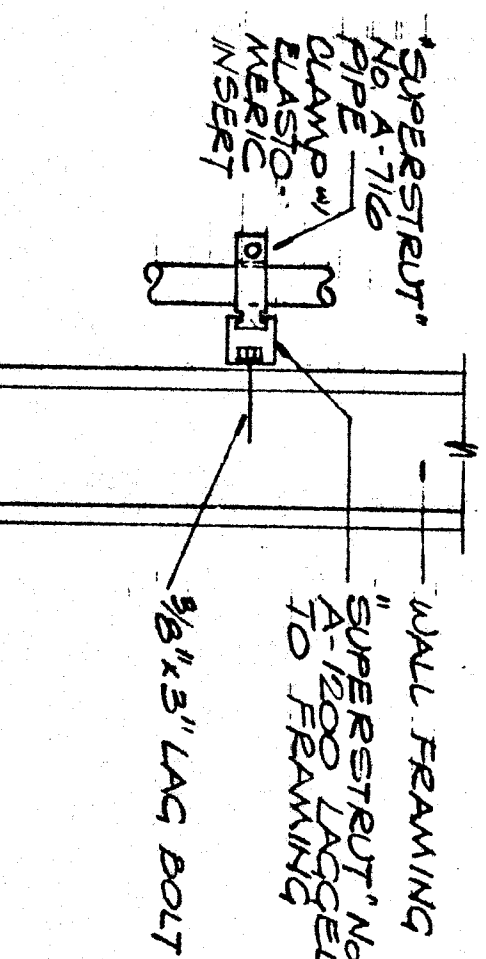

DETAIL
 NO SCALE