



PLAN OF MECHANICAL EQUIPMENT ROOM A-5  
SCALE 1/4" = 1'-0"  
DETAIL P-2

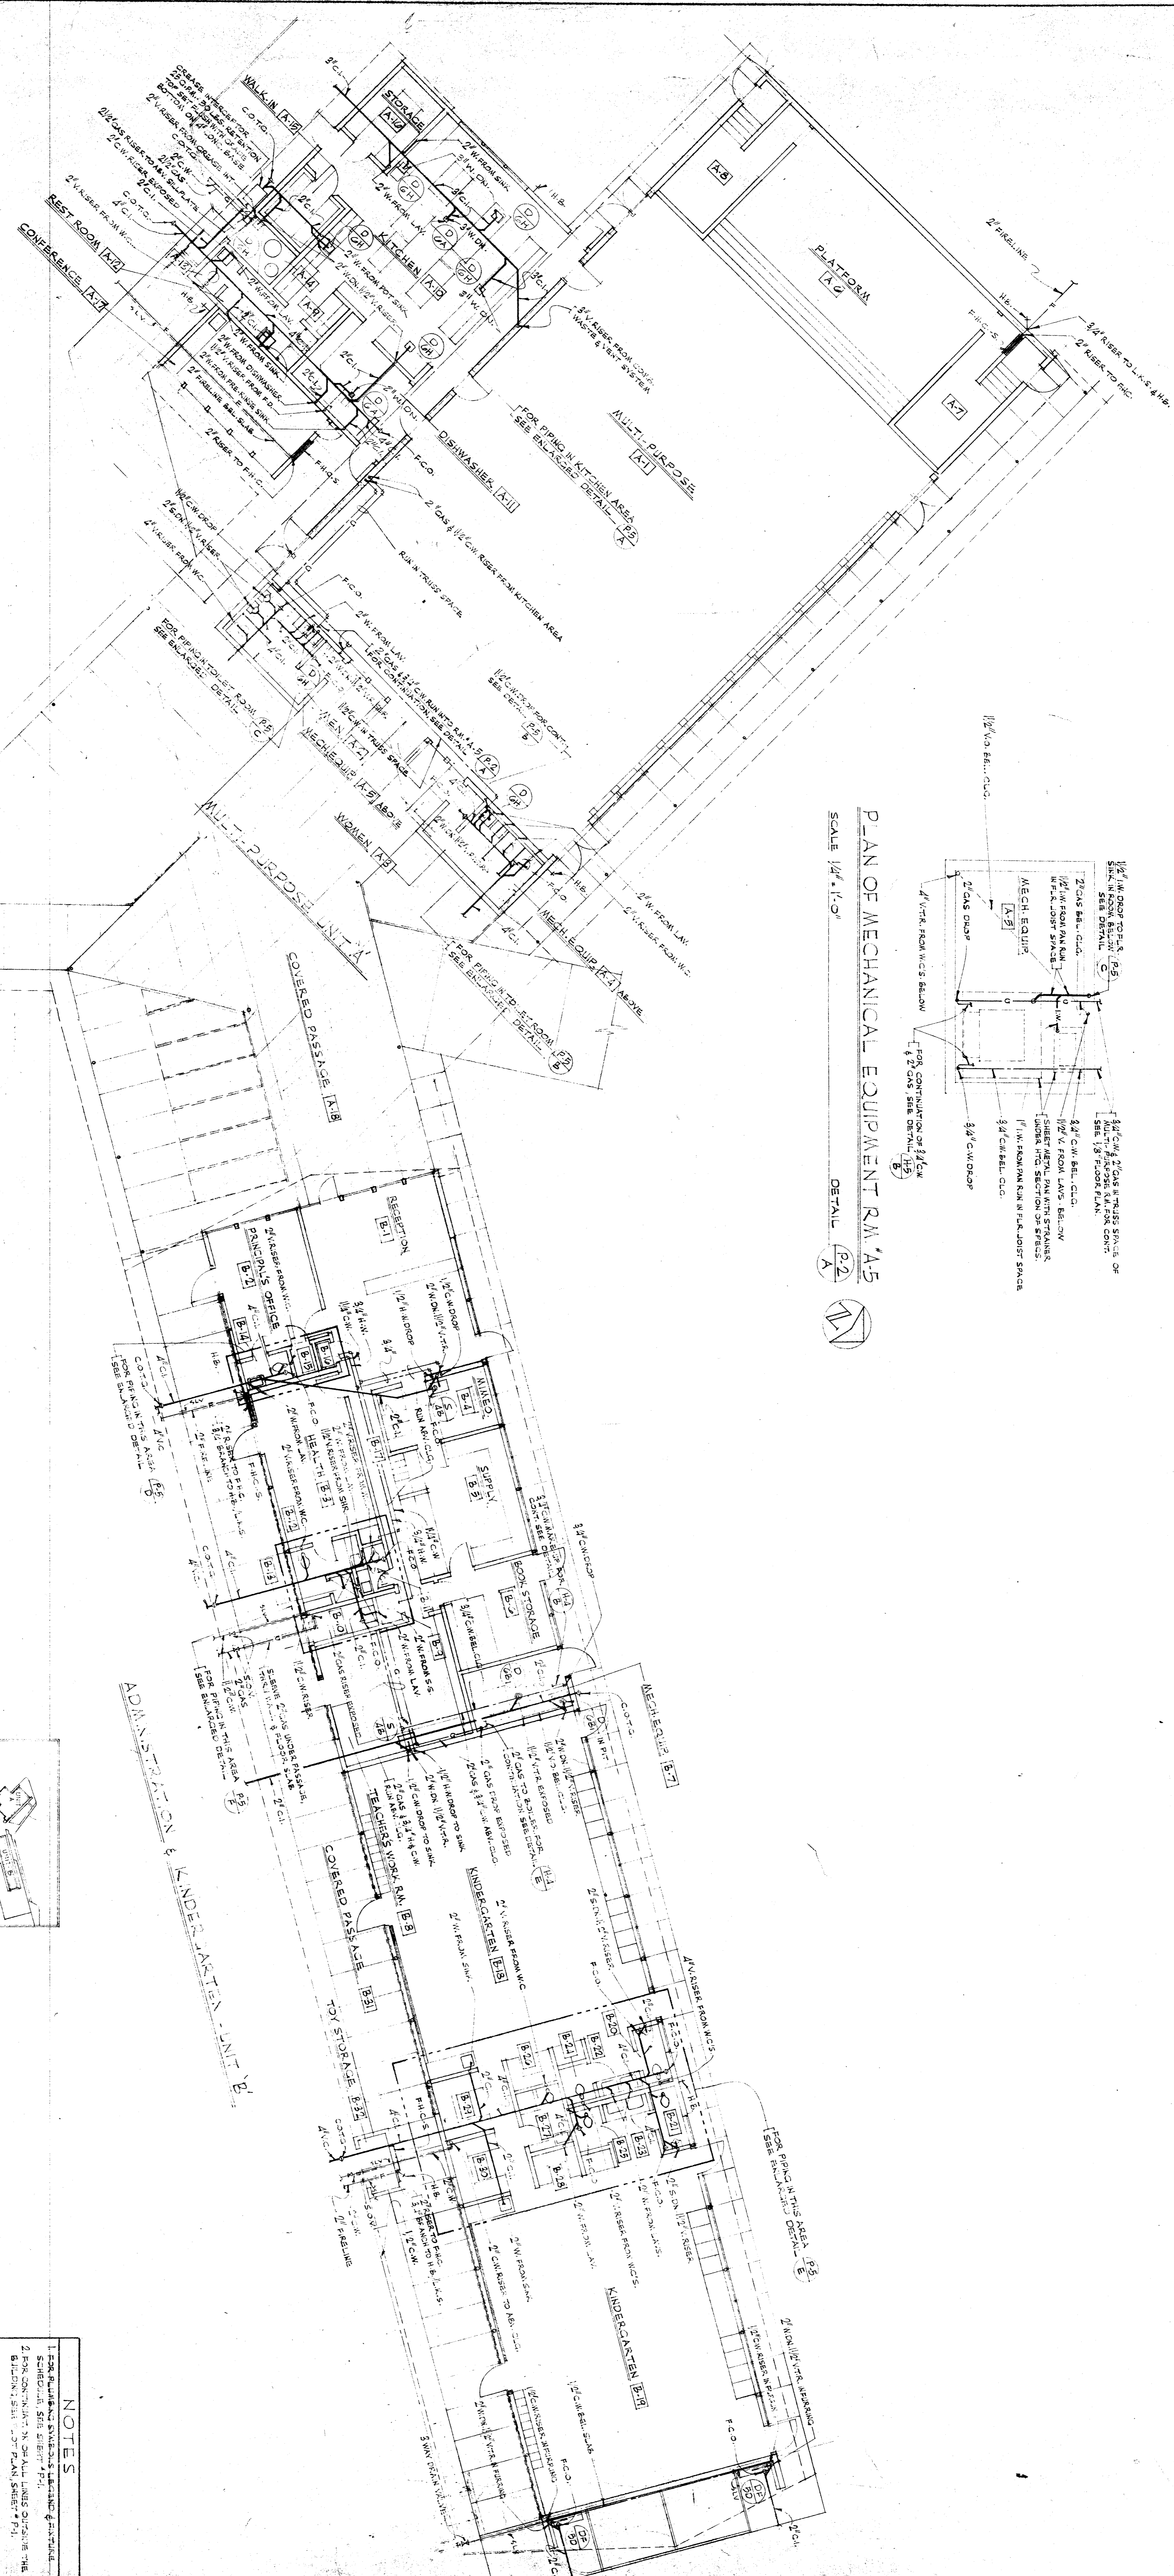

PLUMBING FLOOR PLANS  
SCALE 1/8" = 1'-0"

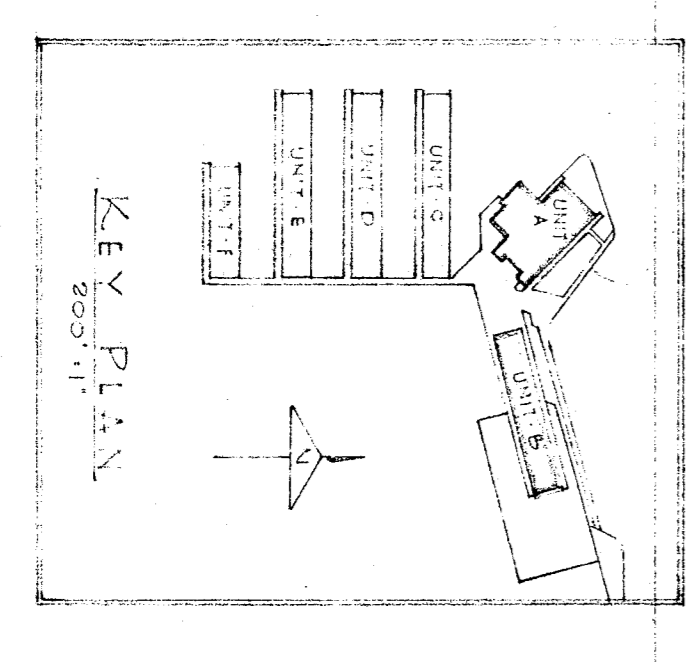

NOTES  
1. FOR PLUMBING SYMBOLS REFER TO STANDARD SYMBOLS FOR MECHANICAL ENGINEERS, 1965 EDITION, SEE SHEET P-1.  
2. FOR CONTINUED OR ALL LINES CROSSING THE BUILDING, SEE '2' PLAN SHEET P-1.

CHESTER D. WRIGHT CONSULTING MECHANICAL ENGINEER 2015 SOUTH BEND AVENUE DALLAS, TEXAS 75201 DATE: 10-25-53	STATE DIVISION OF HEALTH SHEET NO. 11152 PROJECT NO. 11152 DATE: 10-25-53	WRIGHT METCALF & ORR 2111 E. STREET, SUITE 401 DALLAS, TEXAS 75201 DATE: 10-25-53	KEAN COUNTY SUPERVISOR APPROVED: _____ DATE: _____	BAKERSFIELD CITY SCHOOL DISTRICT BOARD OF EDUCATION APPROVED: _____ DATE: _____	JOHN C. FREMONT SCHOOL DISTRICT BAKERSFIELD 11TH STREET BAKERSFIELD, TEXAS DATE: 10-25-53	JOB NO. 209 SHEET NO. 11152
--	--	--	--	--	--	--------------------------------