

COMPLETE FIRE ALARM SYSTEM SUBMITTAL

THE FIRE ALARM SYSTEM INDICATED IN THESE DRAWINGS SHALL BE USED FOR BIDDING PURPOSES ONLY. IT SHALL NOT BE USED FOR CONSTRUCTION.

ASBESTOS ABATEMENT NOTES

- 1. THE GENERAL CONTRACTOR SHALL INVESTIGATE WORK FROM THE OWNER AND THE ARCHITECT IF ASBESTOS IS LOCATED IN ANY LOCATION OTHER THAN INDICATED ON THESE PLANS WHERE WORK OF THIS CONTRACT IS SCHEDULED.

- MNS 300' - ON FLOOR UNDER TILE IS ASSIGNED VINYL FLOOR TILE - THROUGHOUT EXCEPT RESTROOMS AND SHOWER.

LEGEND

ABBREVIATIONS



- GRID LINES
- DOOR SYMBOL
- WINDOW SYMBOL
- REVISION NUMBER
- WORK POINT ELEVATION
- MATCH LINE (SHARED PORTION IS THE SIDE SHOWN)
- NORTH ARROW
- SECTION LETTER
- SHEET NUMBER
- ROOM NUMBER / NAME
- INT. ELEVATION OF ROOM
- DETAIL NUMBER
- SHEET NUMBER
- REVISION NUMBER
- EXISTING GRADE
- COVERED CORRIDOR LETTER DESIGNATION FOR OFFICE OF PUBLIC SCHOOL CONST. USE ONLY

Table with columns for Abbreviations and their corresponding symbols or descriptions.

RUTH HARDING S 3201 PICO AVE. MODERNIZATION

BAKERSFIELD CITY SCHOOL DISTRICT BAKERSFIELD, KERN COUNTY, CALIFORNIA

PROJECT DATA

GENERAL NOTES

NOTHING IN THE DRAWINGS AND/OR THE SPECIFICATIONS SHALL BE CONSIDERED TO PERMIT AN INSTALLATION THAT COULD BE IN VIOLATION OF ALL CODES, ORDINANCES, REGULATIONS, ETC.


ALTERNATES

- ALTERNATE 1 - DEDUCTIVE (-11,000.00)
ALTERNATE 2 - DEDUCTIVE (-24,000.00)
ALTERNATE 3 - DEDUCTIVE (-43,000.00)
ALTERNATE 4 - DEDUCTIVE (-61,000.00)
ALTERNATE 5 - DEDUCTIVE (-60,000.00)

SHEET INDEX

- ARCHITECTURAL
A-01 GENERAL BUILDING ANALYSIS
A-02 SITE PLAN
A-03 CANOPY BUILDING ANALYSIS

DESIGN TEAM
ARCHITECTURAL: SCARLLETTE INC.
MECHANICAL: MECHANICAL DESIGN CONCEPTS
PLUMBING/MECHANICAL: BAKERSFIELD, CA 93301

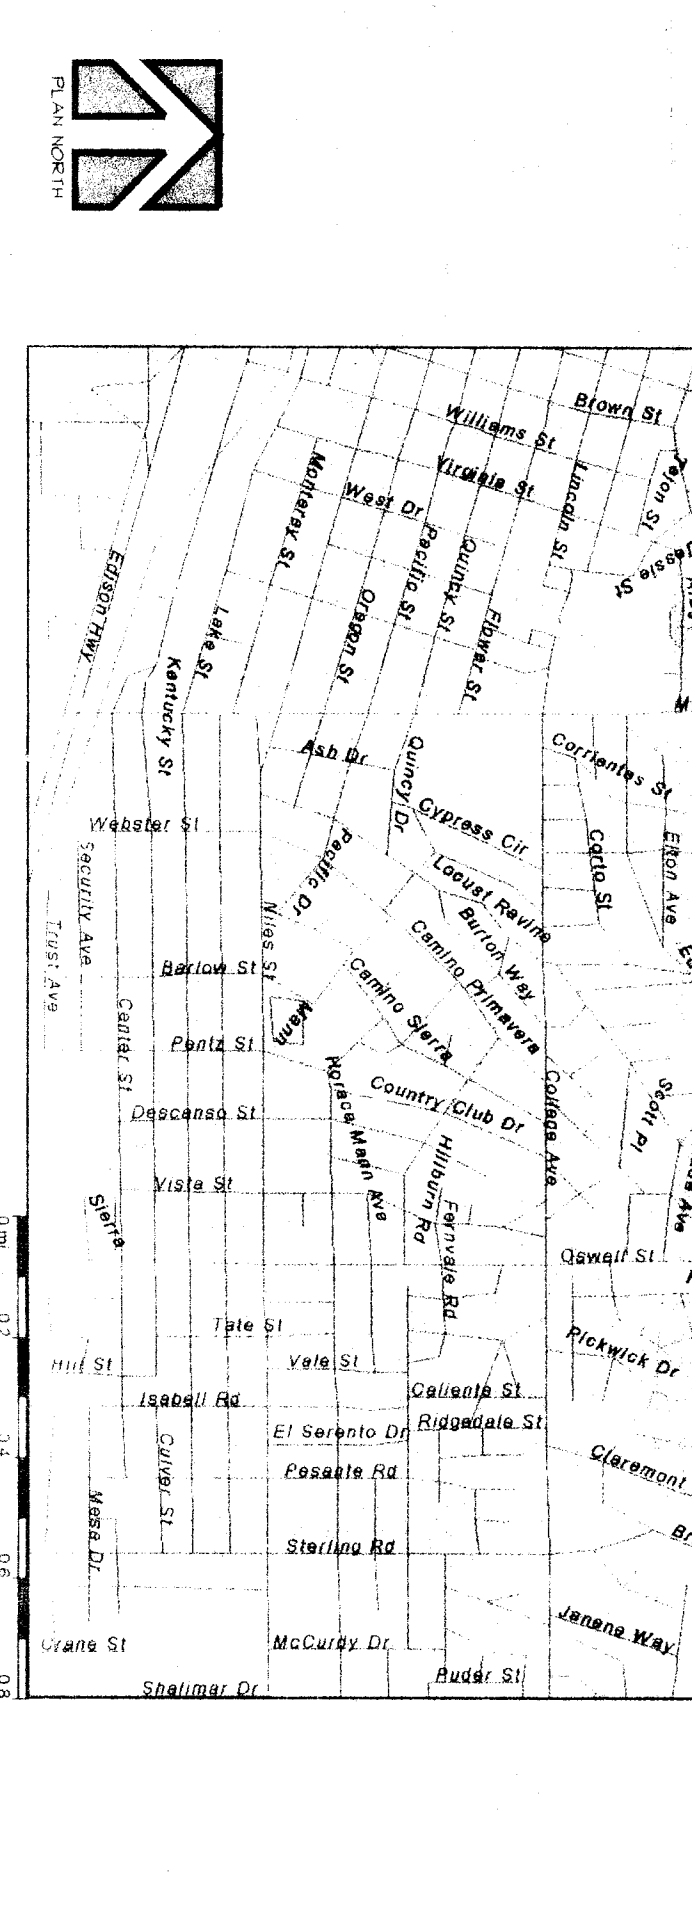

Check and verify all dimensions before proceeding with the work. Perform discrepancies and construction shall conform to the C.S.C.

MARK DATE REVISIONS
0.0

SCARLLETTE, INC. 1301 L Street BAKERSFIELD, CA 93301 (805) 537-1052

REGISTRATION STATEMENT OFFICE OF REGULATION SERVICES 09-10-2156 15-6 10/15/03

RUTH HARDING SCHOOL MODERNIZATION 3201 PICO AVE. FOR BAKERSFIELD CITY SCHOOL DISTRICT BAKERSFIELD, KERN COUNTY, CALIFORNIA