

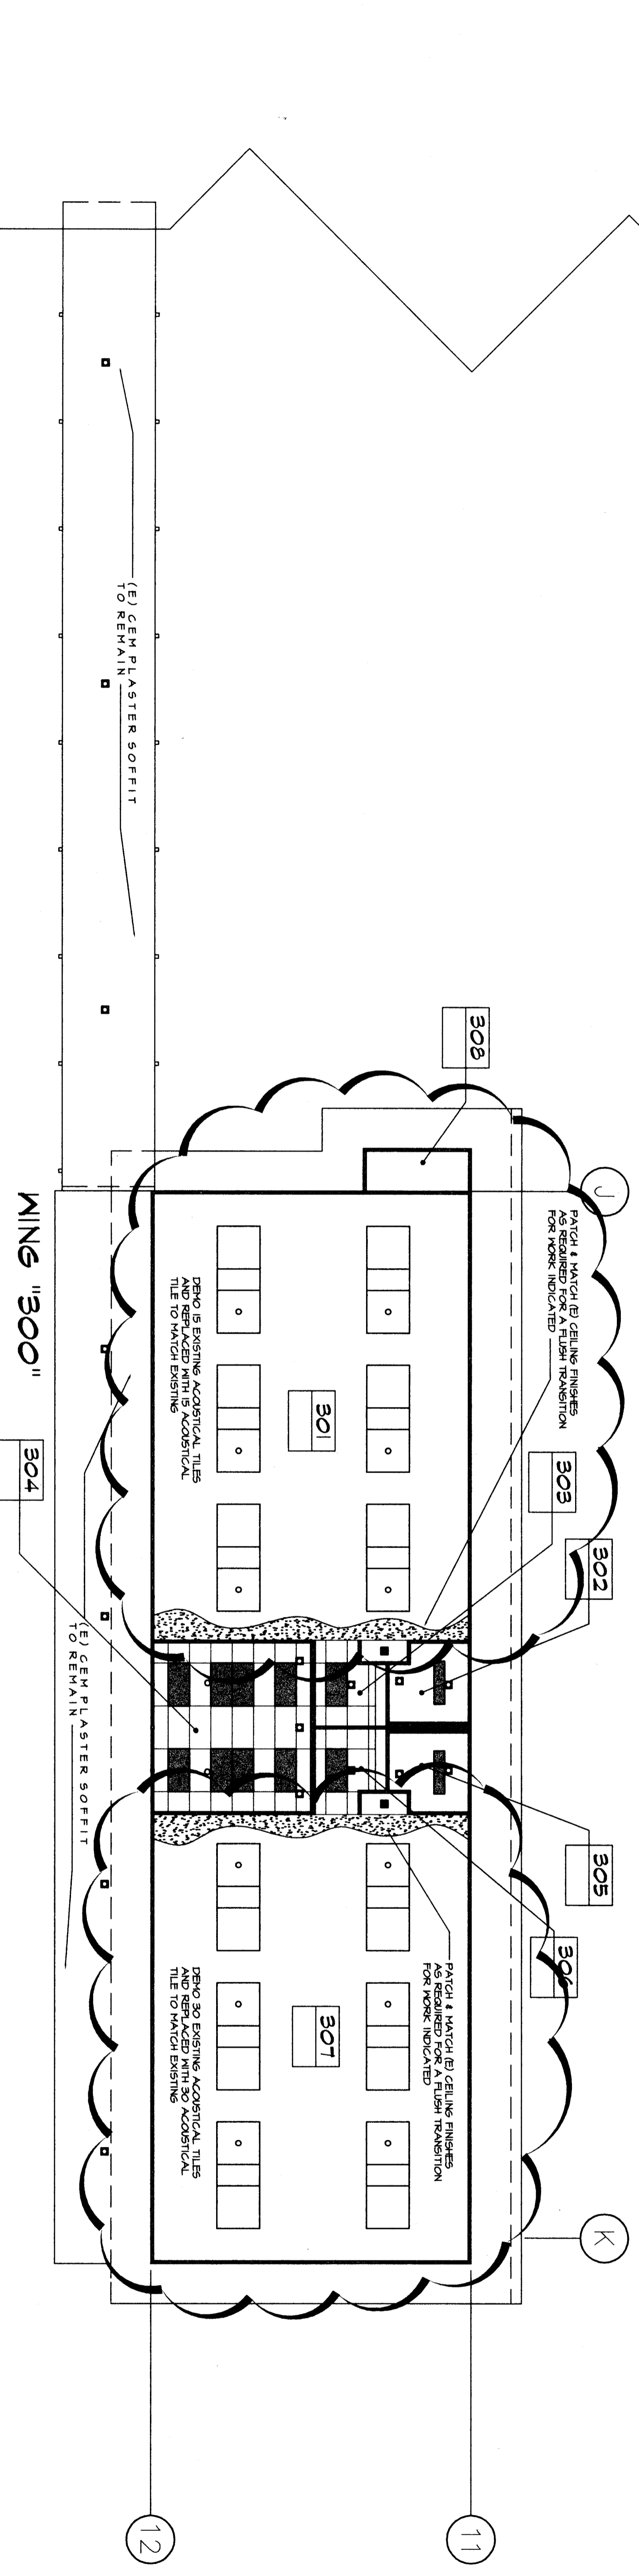
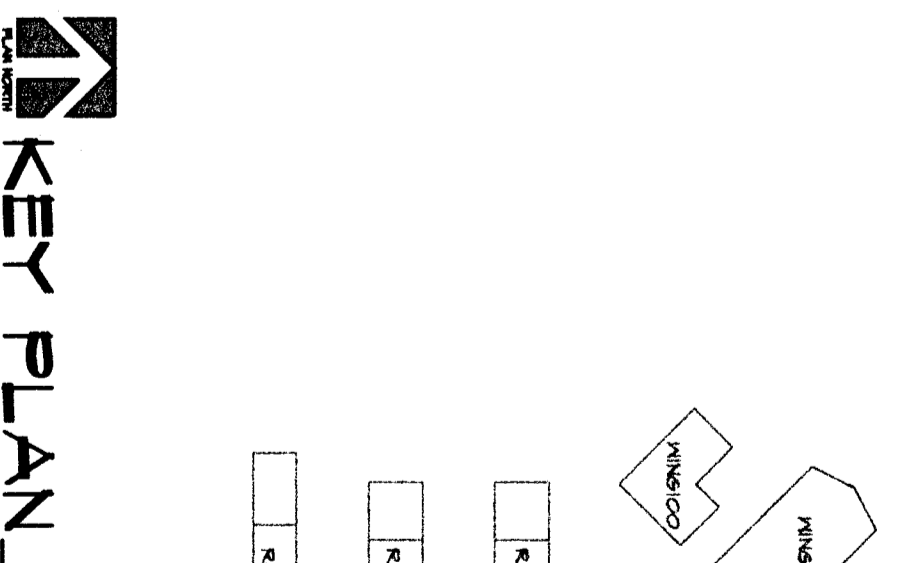


REFLECTED CEILING LEGEND

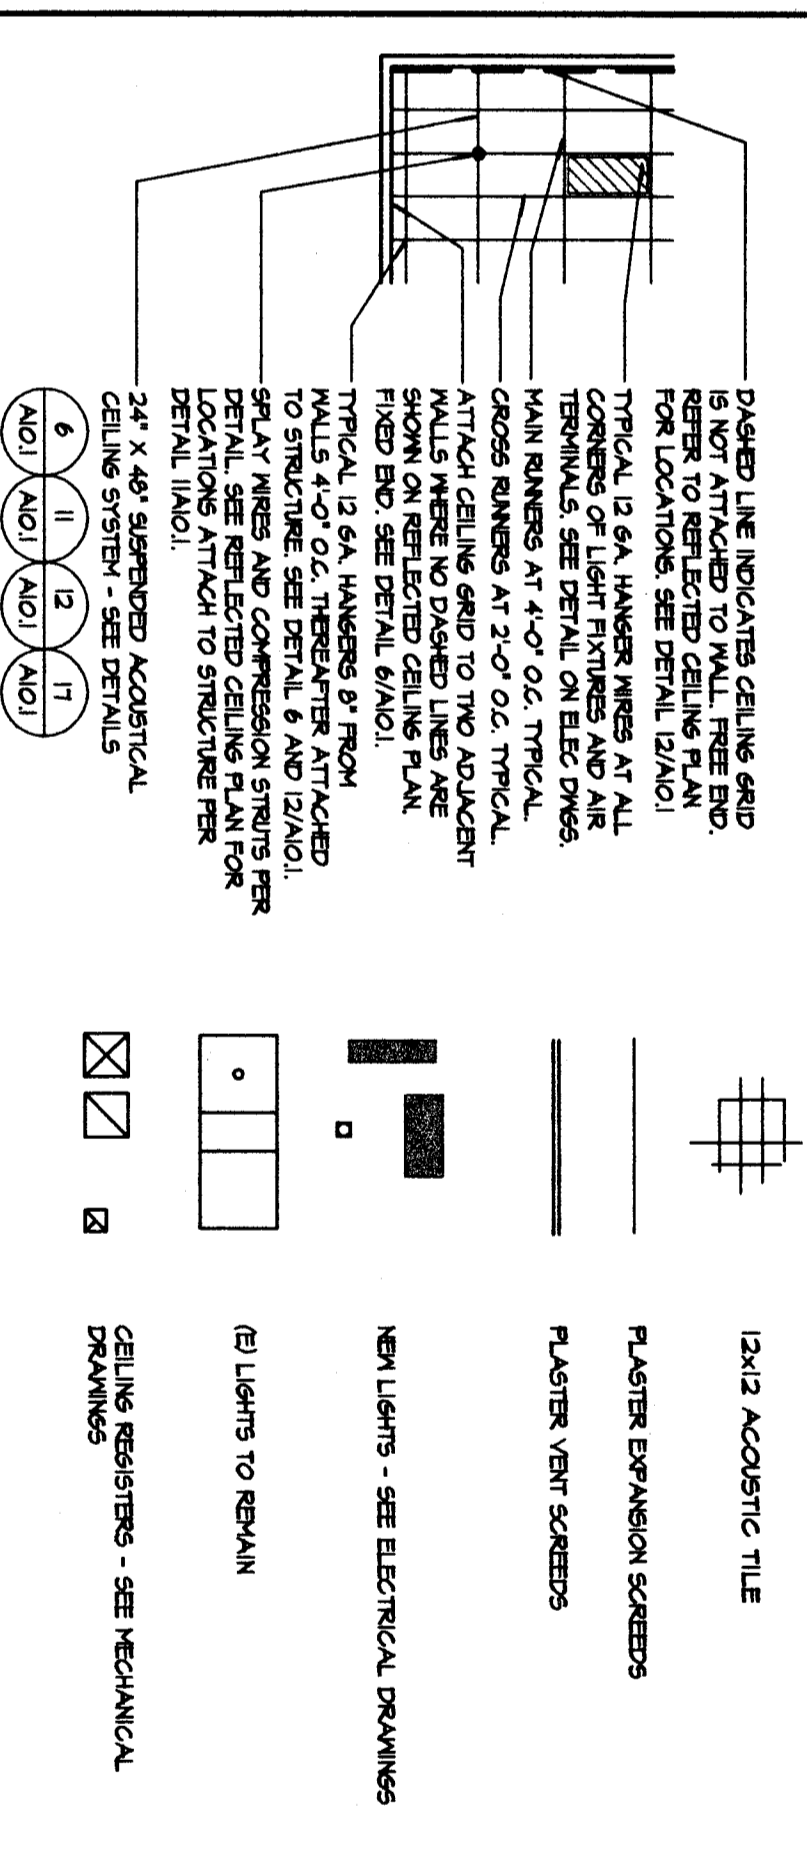

NOTE:
 REFER TO ELECTRICAL DRAWINGS FOR ADDITIONAL DETAIL AND REQUIREMENTS FOR THE LIGHTING. REFER TO THE ELECTRICAL DRAWINGS FOR THE LOCATION OF THE LIGHTING. REFER TO THE ELECTRICAL DRAWINGS FOR THE LOCATION OF THE LIGHTING. REFER TO THE ELECTRICAL DRAWINGS FOR THE LOCATION OF THE LIGHTING.

REFLECTED CEILING PLAN WING'S "300" AND "400"

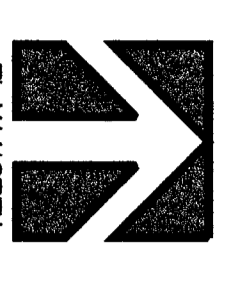

SCALE: 1/4" = 1'-0"

13. Refer to Drawings Sheet A4.1, Reflected Ceiling Plan, Wing 300/400.
 #101 #11 a. DELETE
 b. ADDS
 Sheet A4.1, in its entirety.
 Sheet A4.1, as attached to this addendum, (addendum drawing #9).

| MARK | DATE | REVISIONS |
|------|------|-----------|
| △ | | |
| △ | | |

CHECK AND VERIFY ALL DIMENSIONS BEFORE REPORTING TO THE ARCHITECT. ALL CONSTRUCTION SHALL CONFORM TO THE C.B.C.

RUTH HARDING SCHOOL
 MODERNIZATION
 3201 PICO AVE.
 FOR
 BAKERSFIELD CITY SCHOOL DISTRICT
 BAKERSFIELD, KERN COUNTY, CALIFORNIA

REGISTRATION STATE: CALIFORNIA
 DIV. OF THE STATE ARCHITECT
 OFFICE OF REGULATION SERVICES
 APR. 03-107156
 REG. 1548
 AC: NS SS
 DATE: 08/12/1992



101 L STREET
 BAKERSFIELD (A 93301)
 P.O. (661) 327-6322
 FAX: (661) 327-2339

STEPHEN J. COOPER, AIA
 ARCHITECT

ADDENDUM #01
RUTH HARDING SCHOOL
 MODERNIZATION
 BAKERSFIELD CITY SCHOOL DISTRICT
 BAKERSFIELD, CALIFORNIA

REFLECTED CEILING PLAN

JOB NO. 957.1
 DRAWN: BRENT
 CHECKED: J
 DATE: 08/19/03

4.1
 14 OF 31 SHEETS