



BUILDING 'C' AND BUILDING 'D' ELECTRICAL DEMOLITION PLAN


SCALE: 1/8" = 1'-0"

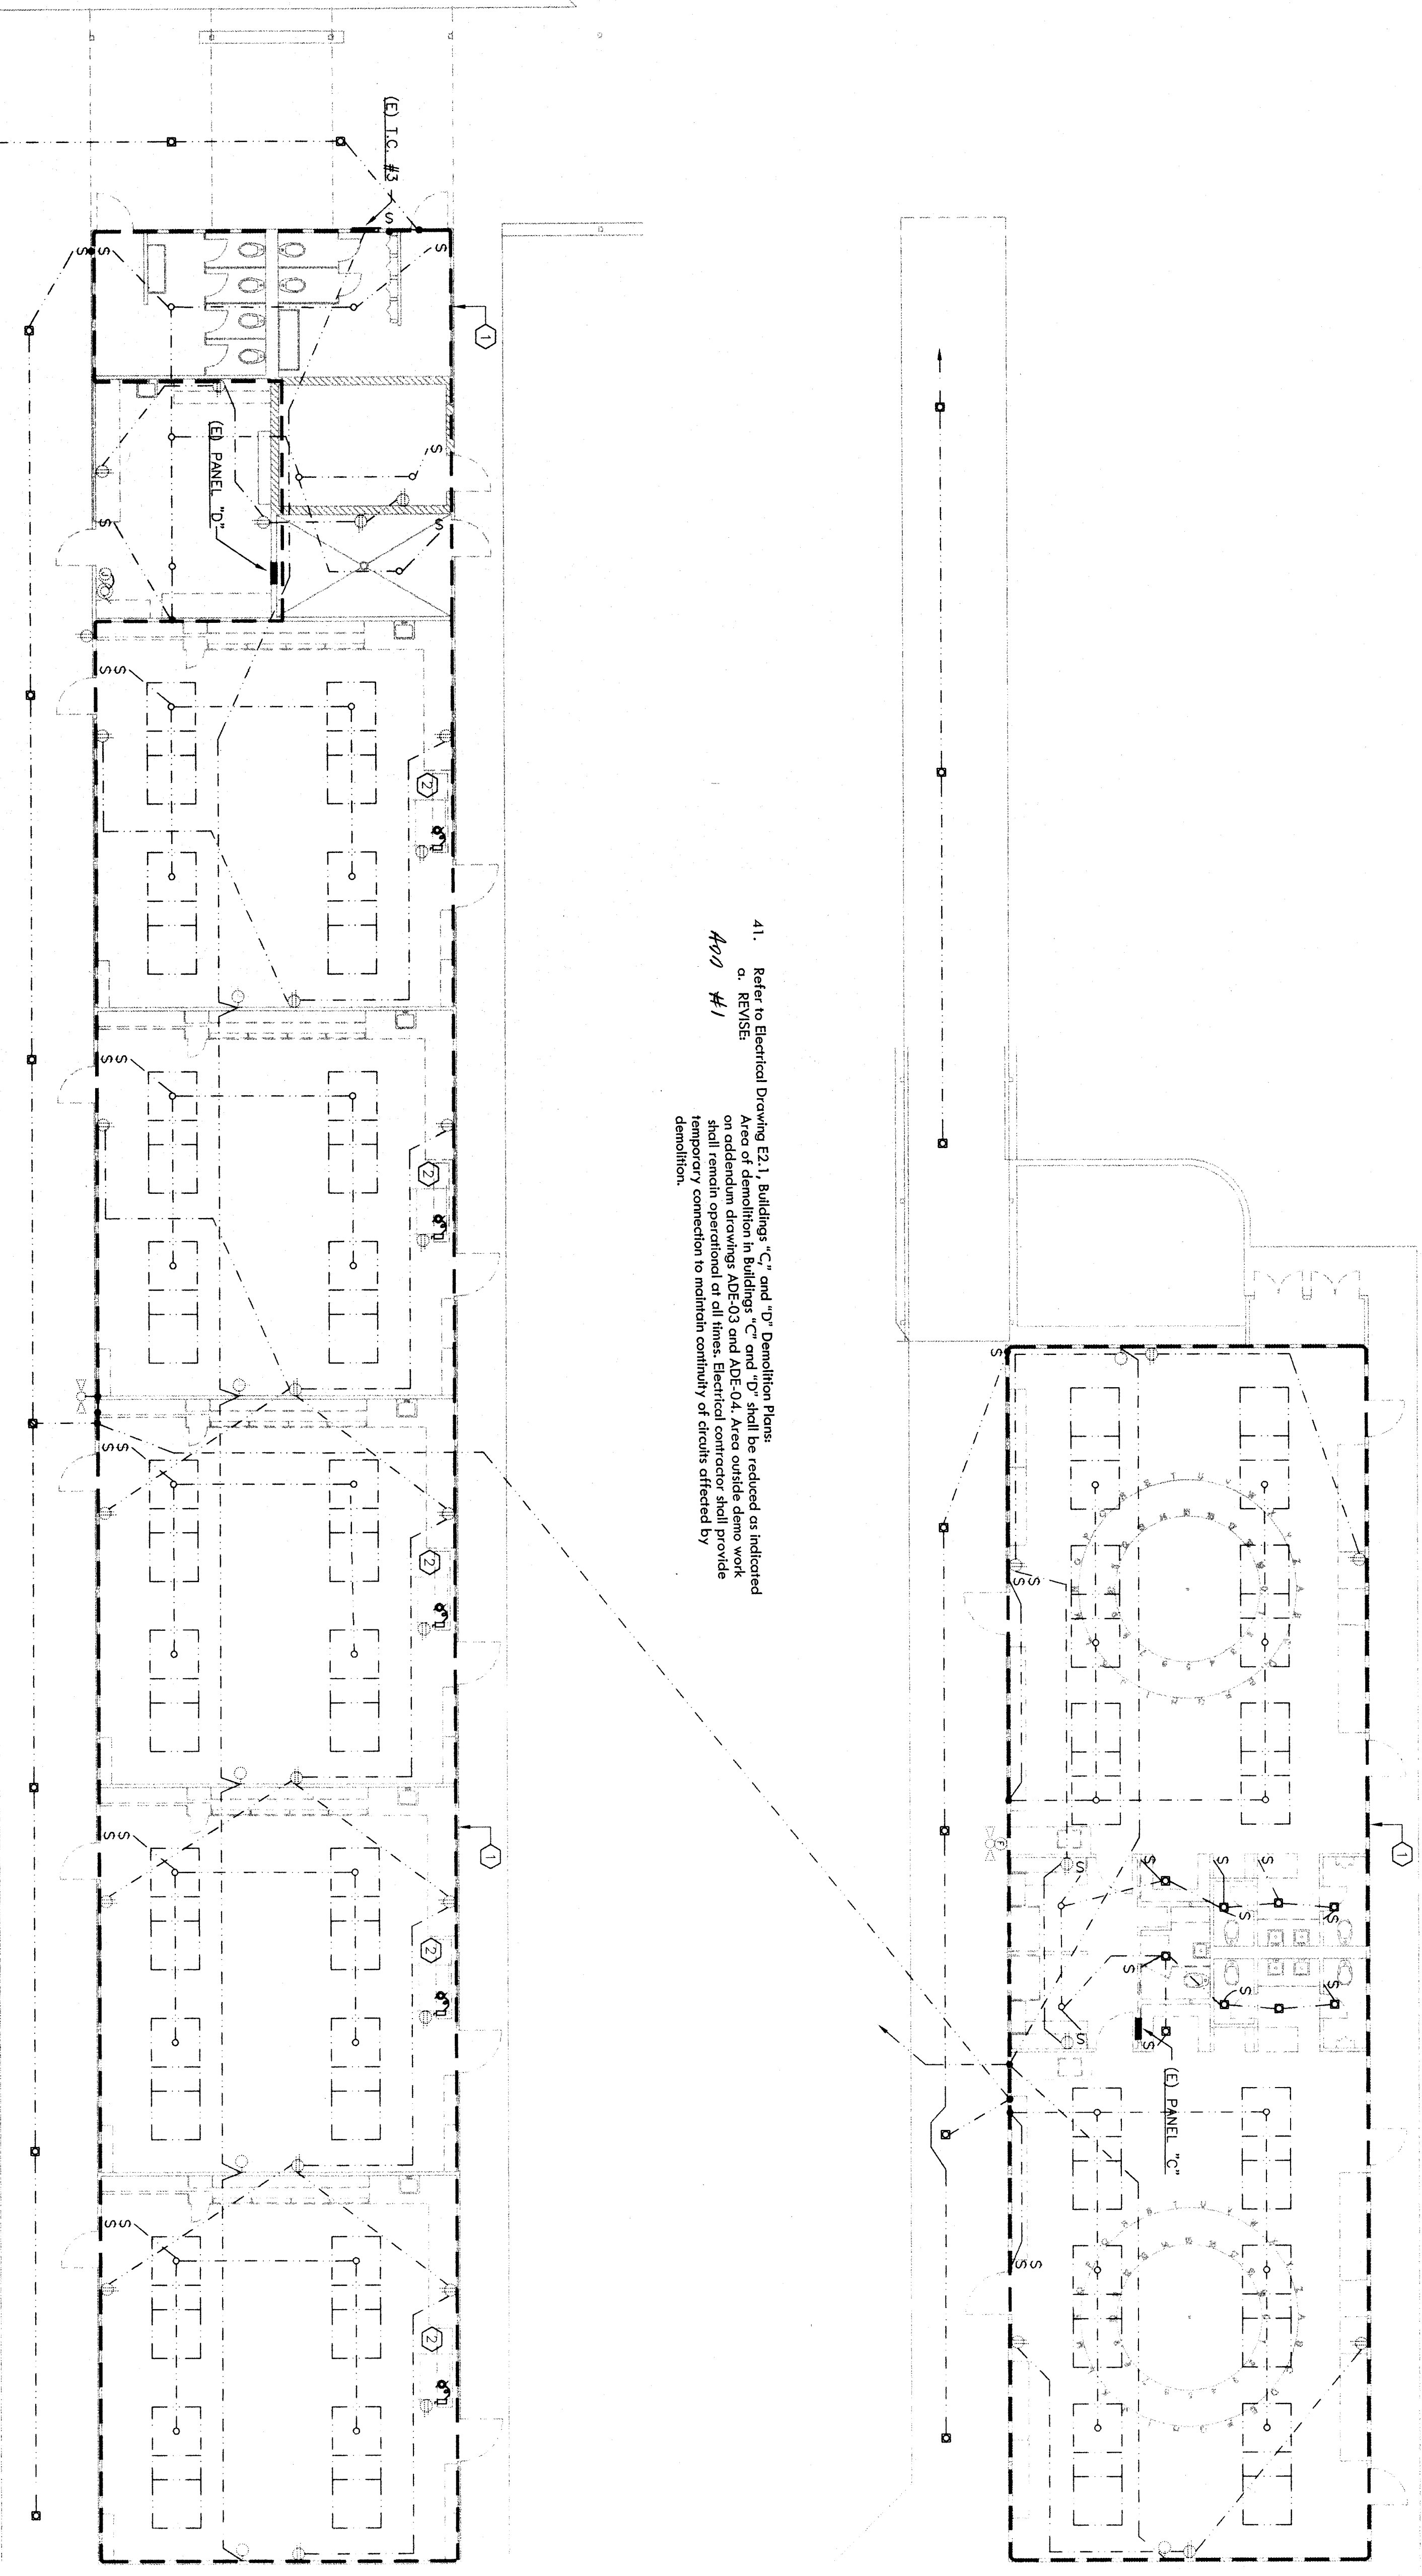

41. Refer to Electrical Drawing E-2.1, Buildings 'C' and 'D' Demolition Plan.
 a. REVISE
 Area of demo drawing ADE-03 and ADE-04. Area outside demo work shall remain operational at all times. Electrical contractor shall provide temporary connection to maintain continuity of circuits affected by demolition.

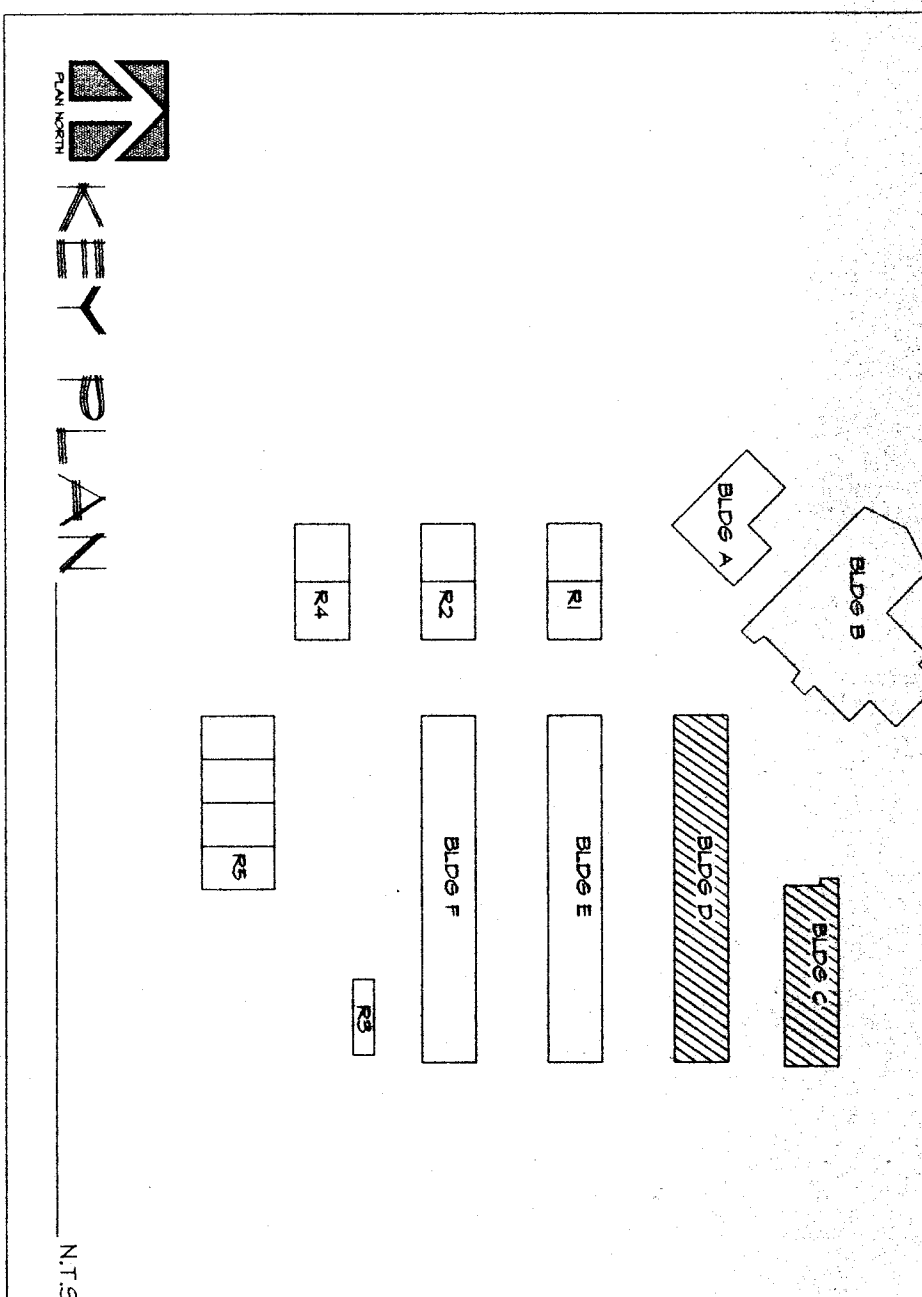

- REFERENCE NOTES**
- 1. EXISTING FIXTURES TO BE REMOVED ALONG WITH ANY CONDUIT, CONDUCTIONS AND BOXES NOT BEING REUSED.
 - 2. EXISTING A/C UNIT & DUPLEX OUTLET ON ROOF TO REMAIN. RECONNECT (E) DUPLEX AS REQUIRED.

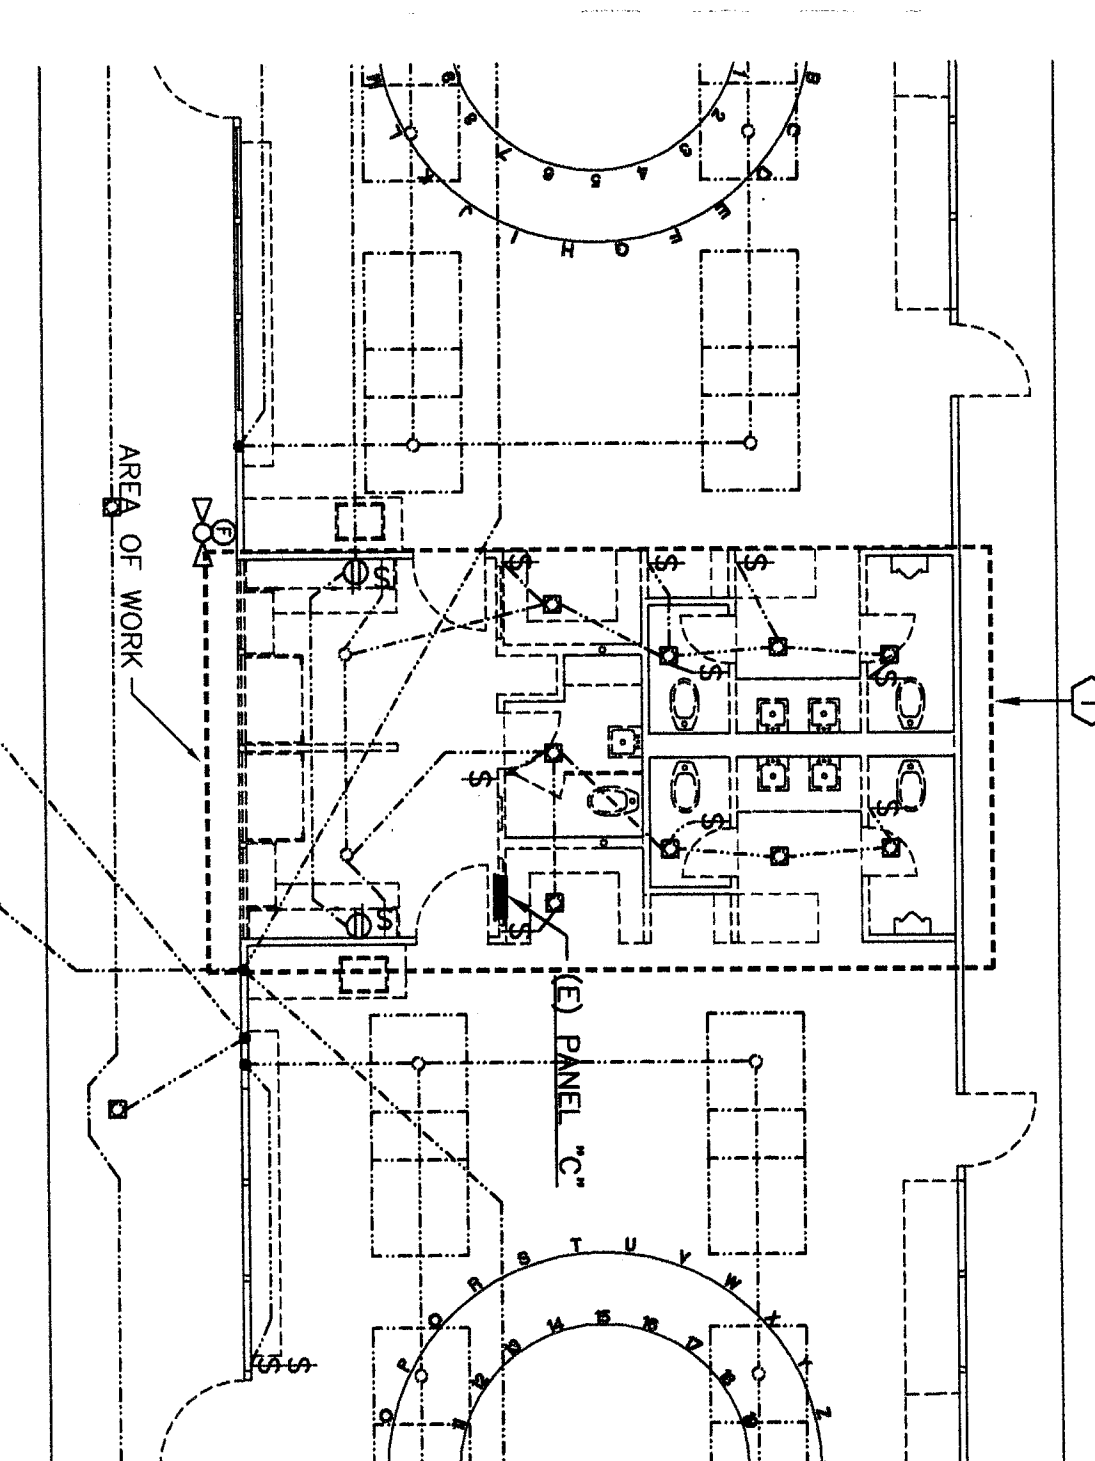

BUILDING 'C'
PARTIAL LIGHTING PLAN
REFER TO SHEET E-2.1
 SCALE: 1/8" = 1'-0"

ADDENDUM #01
 RUTH HARDING SCHOOL
 MODERNIZATION
 BAKERSFIELD, KERN COUNTY, CALIFORNIA

NO.	DATE	DESCRIPTION
001	07/20/13	ISSUED FOR PERMITS
002	08/15/13	REVISED PER COMMENTS
003	08/29/13	REVISED PER COMMENTS
004	09/11/13	REVISED PER COMMENTS
005	09/11/13	REVISED PER COMMENTS
006	09/11/13	REVISED PER COMMENTS
100	09/11/13	REVISED PER COMMENTS

REGISTERED PROFESSIONAL ENGINEER
 No. 5101
 08/29/02
 ELECTRICAL
 STATE OF CALIFORNIA

REGISTERED PROFESSIONAL ENGINEER
 No. 5101
 08/29/02
 ELECTRICAL
 STATE OF CALIFORNIA

NO.	DATE	DESCRIPTION
001	07/20/13	ISSUED FOR PERMITS
002	08/15/13	REVISED PER COMMENTS
003	08/29/13	REVISED PER COMMENTS
004	09/11/13	REVISED PER COMMENTS
005	09/11/13	REVISED PER COMMENTS
006	09/11/13	REVISED PER COMMENTS
100	09/11/13	REVISED PER COMMENTS

**RUTH HARDING SCHOOL
 MODERNIZATION
 3201 PICO ST.
 FOR
 BAKERSFIELD CITY SCHOOL DISTRICT
 BAKERSFIELD, KERN COUNTY, CALIFORNIA**

REGISTERED PROFESSIONAL ENGINEER
 No. 5101
 08/29/02
 ELECTRICAL
 STATE OF CALIFORNIA

REGISTERED PROFESSIONAL ENGINEER
 No. 5101
 08/29/02
 ELECTRICAL
 STATE OF CALIFORNIA

REGISTERED PROFESSIONAL ENGINEER
 No. 5101
 08/29/02
 ELECTRICAL
 STATE OF CALIFORNIA

SCARF HOLDINGS
 11 BOY ST. SUITE 200
 BAKERSFIELD, CA 93311
 (805) 837-0185