


BUILDING 'e'
PARTIAL LIGHTING PLAN SCALE: 1/8" = 1'-0"
REFER TO SHEET E-2.2

ADDENDUM #01	
RUTH HARDING SCHOOL MODERNIZATION	
BAKERFIELD CITY SCHOOL DISTRICT BAKERFIELD, KERN COUNTY, CALIFORNIA	
DATE	07/27/03
BY	ELB
PROJECT NO.	ADE-05

E. L. B. ARCHITECT
 200 S. W. 10TH ST.
 SUITE 200
 BAKERSFIELD, CA 93307
 TEL: 805/338-2222 FAX: 805/338-2222
 C:\Drawings\2003\07-27-03\98-227 Lighting\Mod/011-05K.dwg, 9/9/2003 10:27:54 AM, AutoCAD Release 1998, 08/18/03

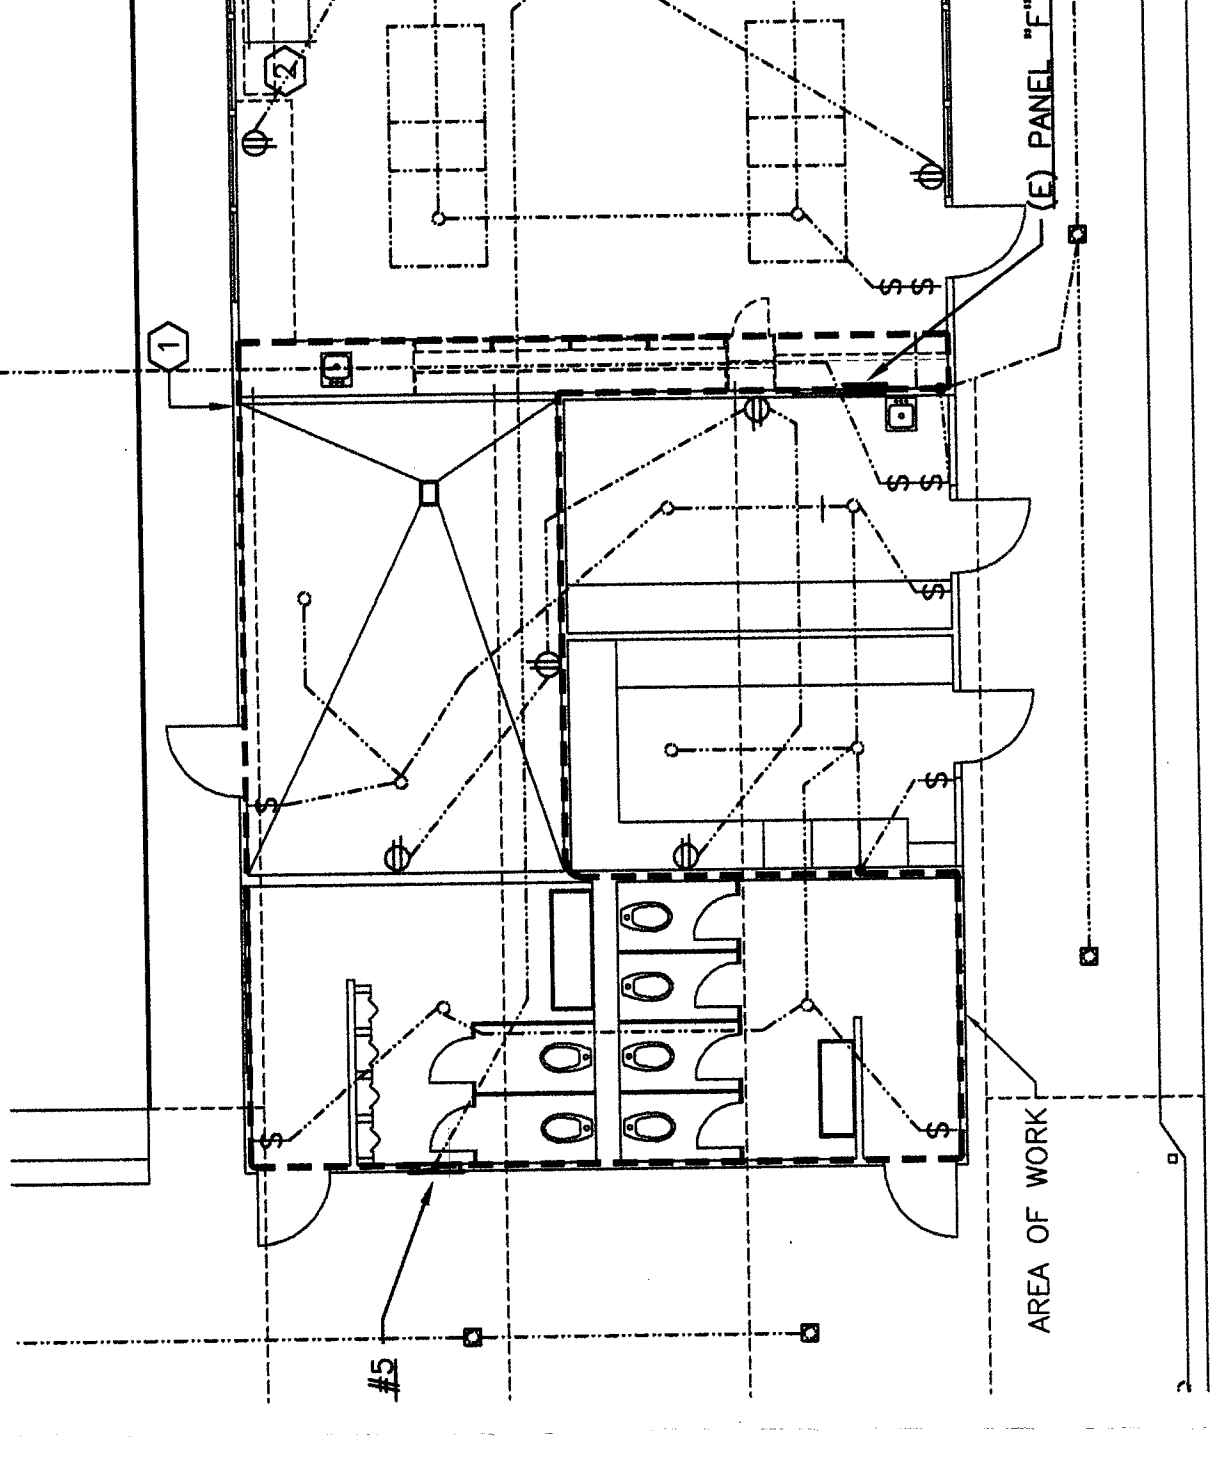

BUILDING 'f'
PARTIAL LIGHTING PLAN SCALE: 1/8" = 1'-0"
REFER TO SHEET E-2.2

ADDENDUM #01	
RUTH HARDING SCHOOL MODERNIZATION	
BAKERFIELD CITY SCHOOL DISTRICT BAKERFIELD, KERN COUNTY, CALIFORNIA	
DATE	07/27/03
BY	ELB
PROJECT NO.	ADE-06

E. L. B. ARCHITECT
 200 S. W. 10TH ST.
 SUITE 200
 BAKERSFIELD, CA 93307
 TEL: 805/338-2222 FAX: 805/338-2222
 C:\Drawings\2003\07-27-03\98-227 Lighting\Mod/011-05K.dwg, 9/9/2003 10:28:39 AM, AutoCAD Release 1998, 08/18/03