




Users: 1/18/2018 12:00:00 AM (1/18/2018 12:00:00 AM) 1/18/2018 12:00:00 AM (1/18/2018 12:00:00 AM) 1/18/2018 12:00:00 AM (1/18/2018 12:00:00 AM)

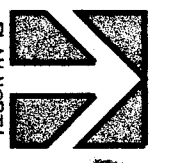

BUILDING 'E' AND BUILDING 'F' POWER PLAN

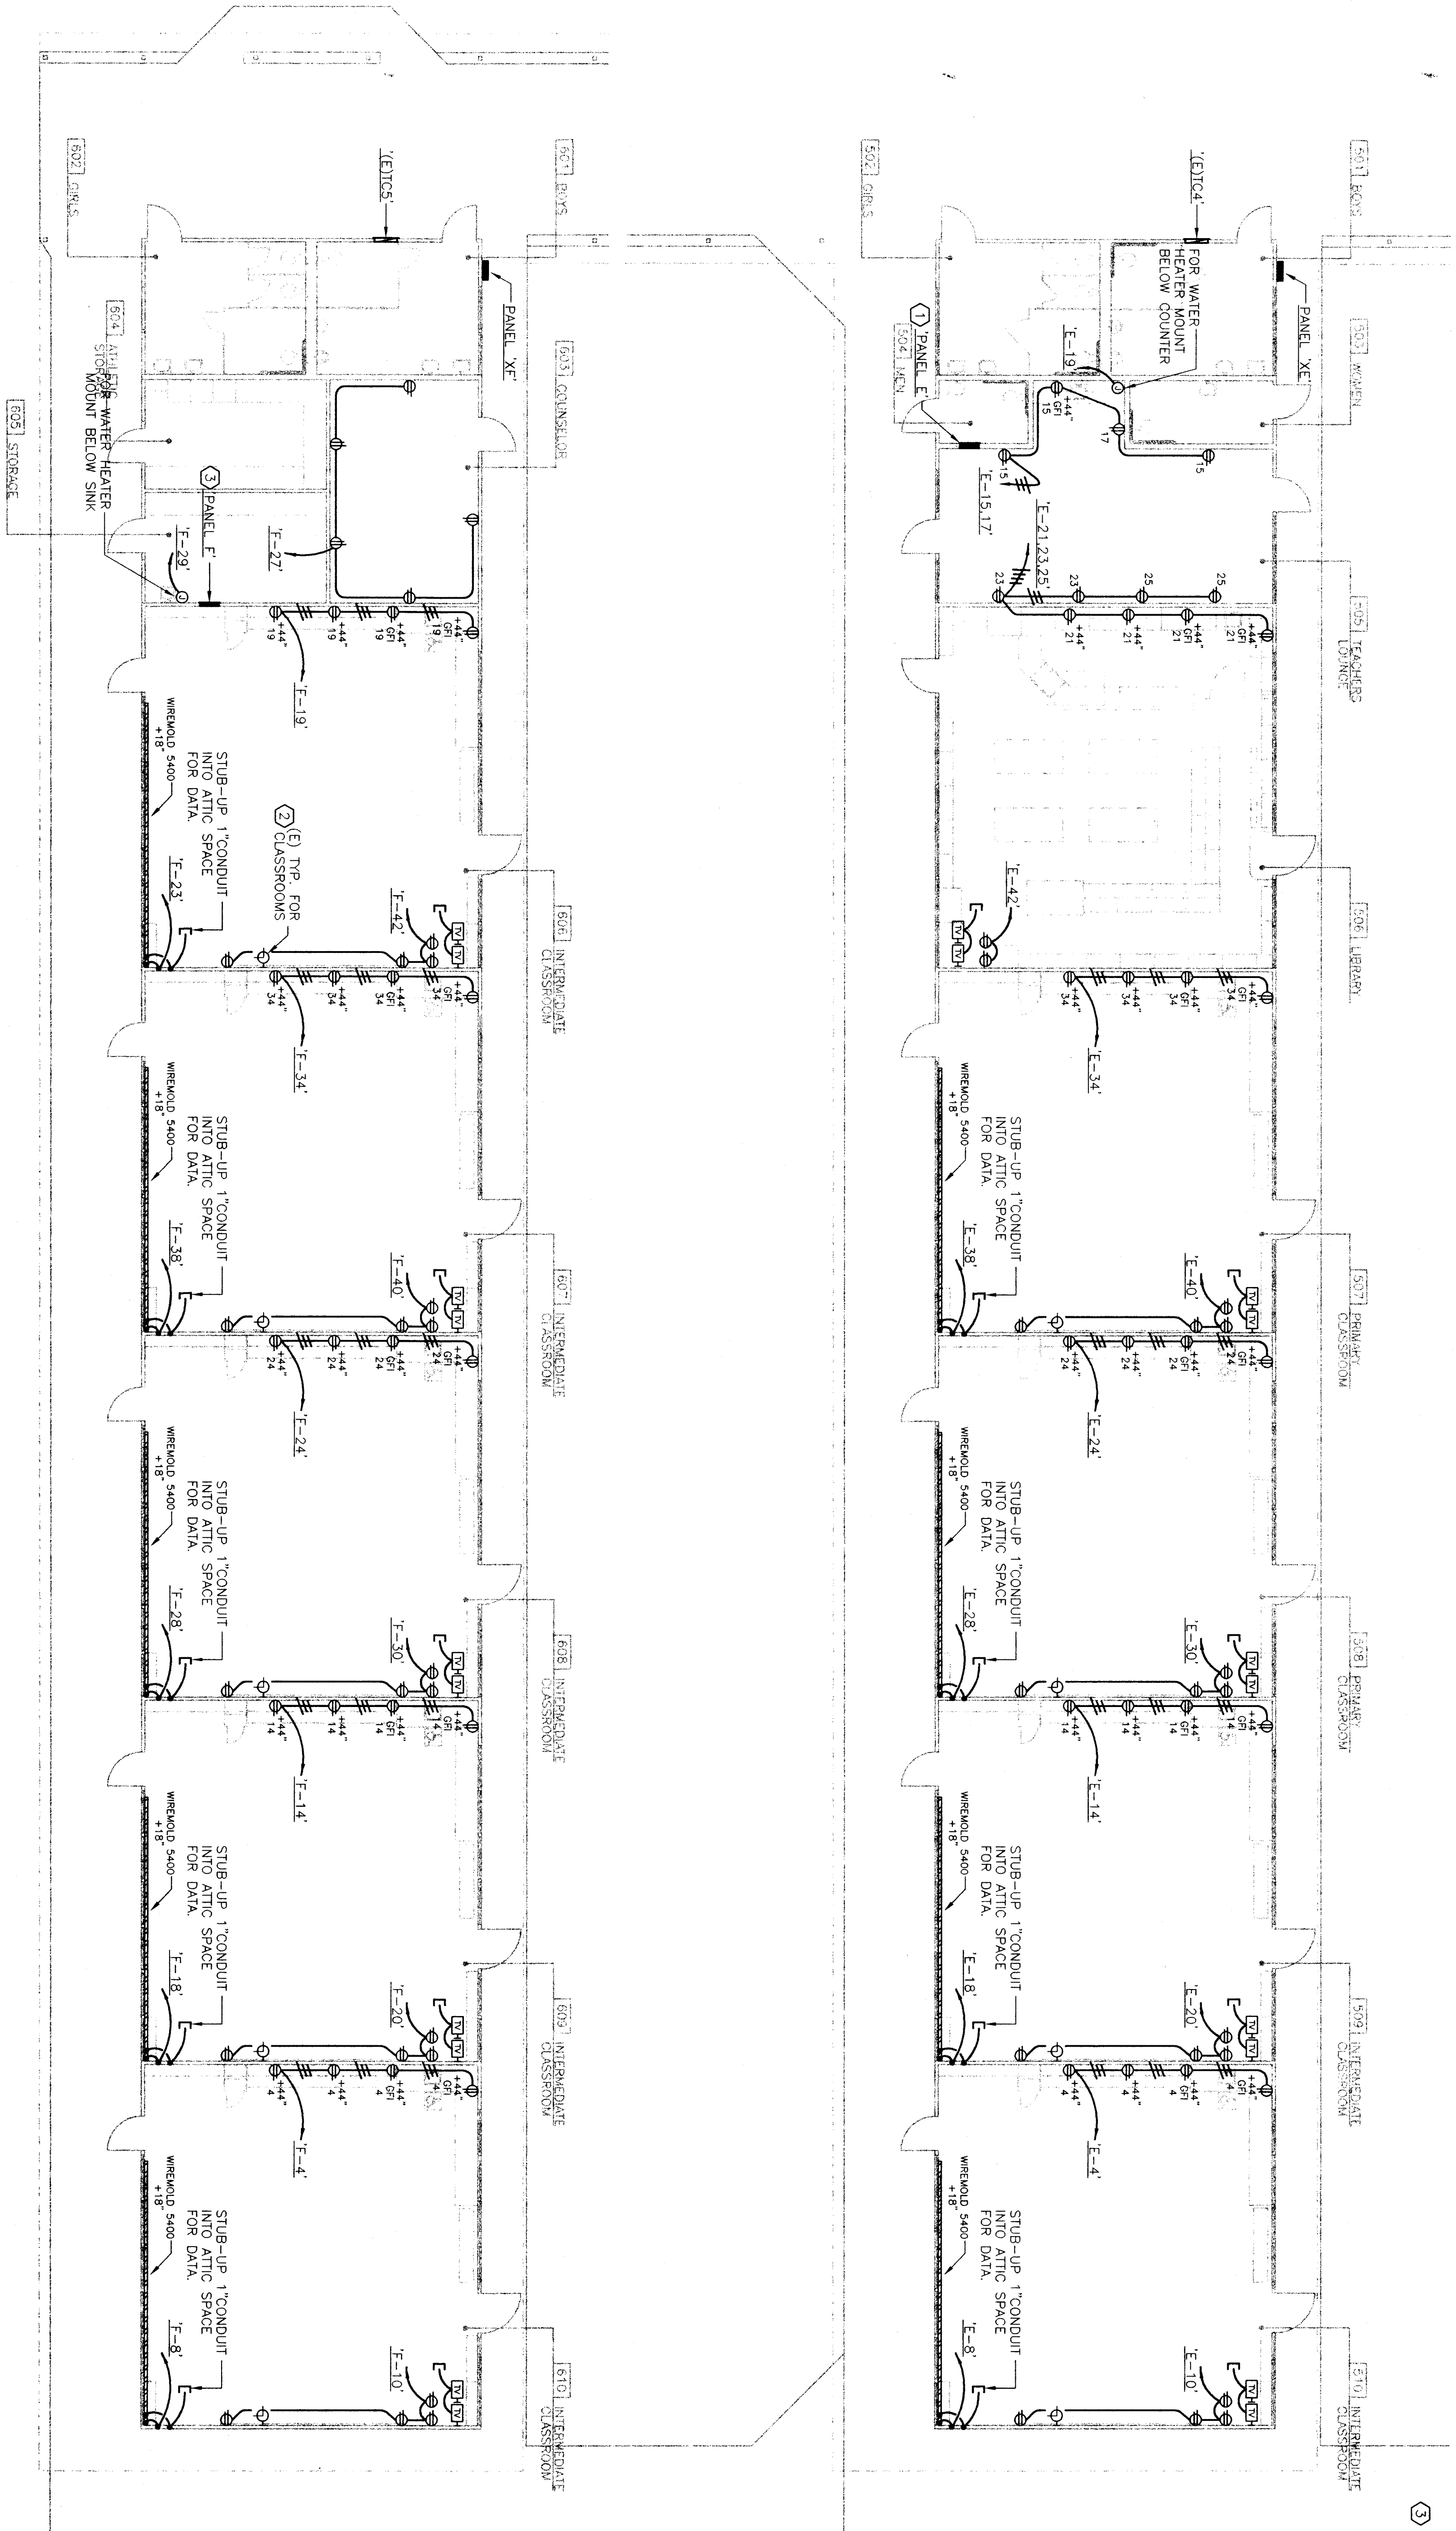

KEY PLAN

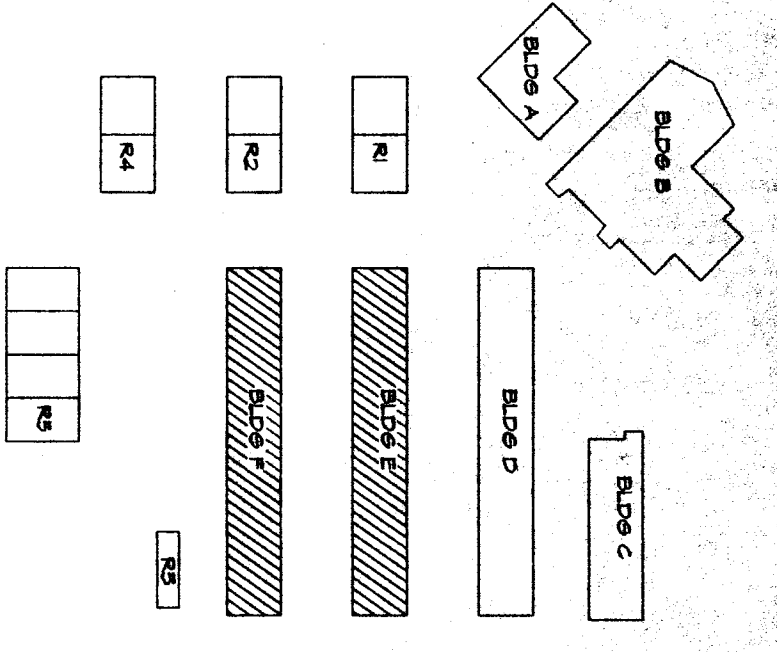


REFERENCE NOTES

- ① REPLACE (E) PANEL W/NEW 120/208V-3P-4W 200A 42 CKS/INSTALL 175/3 MAIN CB CUT & PATCH
- ② INTERCEPT AND EXTEND (E) CONDUIT/CONDUCTORS TO NEW LOCATION OF CLOCK @ 8'-0" A.F.F. AND CONNECT AS REQUIRED.
- ③ REPLACE (E) PANEL W/NEW 120/208V-3P-4W 225A 42 CKS/INSTALL 225/3 MAIN CB CUT & PATCH
- ④ WALLS AS REQUIRED. SEE SINGLE LINE DIAGRAM

48. Refer to Electrical Drawing E-4.2, Buildings 'E' and 'F' Power Plan. Scope of electrical work has been reduced. Refer to revised Electrical Drawing E-4.2, as attached to this addendum.

SCALE: 1/8" = 1'-0"

SCA
rchitect, Inc
 1301 L Street
 Bakersfield, CA 93301
 (805) 337-1532

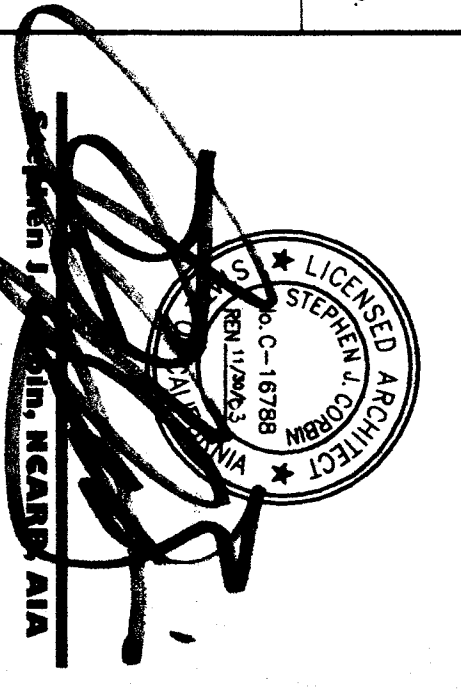

REGISTERED PROFESSIONAL ENGINEER
 JAMES W. GRAHAM
 LICENSE NO. 47962
 STATE OF CALIFORNIA
 465 W. FERRIS AVE. SUITE 108
 BAKERSFIELD, CA 93310
 (805) 432-4490 / (805) 432-4494 fax
 James W. Graham, Electrical Engineer
 E.E. #5101

REGISTRATION STAMP
 DIV. OF THE STATE ARCHITECTS
 AND ENGINEERS
 LICENSE NO. 0378256
 EXPIRES 12-31-18
 AC: NS: SS

**RUTH HARDING SCHOOL
 MODERNIZATION**
 3201 PICO ST.
 FOR
BAKERSFIELD CITY SCHOOL DISTRICT
 BAKERSFIELD, KERN COUNTY, CALIFORNIA

**BLDG. 'E' & 'F'
 POWER PLAN**

**CHECK AND VERIFY ALL DIMENSIONS
 TO THE ARCHITECT'S ORIGINAL
 WORK. REPORT DISCREPANCIES
 TO THE ARCHITECT. ALL
 DIMENSIONS SHALL COMPLY
 TO THE C.S.C.**

MARK	DATE	REVISIONS
△		
△		
△		
△		
△		

967
 DRAWN BY: CA
 CHECKED BY: CA
 DATE: 09-08-03

4.2
 OF 4 SHEETS

