

SCA Architect, Inc
 1201 L Street
 Bakersfield, CA 93301
 (805) 337-1692

James W. Gordon
 REGISTERED PROFESSIONAL ENGINEER
 No. 5101
 EXPIRES 09/30/02
 LICENSED UNDER THE
 PROFESSIONAL ENGINEERING
 ACT OF 1927
 STATE OF CALIFORNIA
 CIVIL ENGINEERING

INTERPRETIVE ENGINEERS
 63 HALETHRU 008
 466 W. Fairbrook Ave., Suite 106
 Fresno, California 93711
 (209) 432-4800 / (209) 432-4814 fax
 James W. Gordon, Licensed Engineer
 E.E. #4101

REGISTERED ENGINEER
 DIV. OF THE STATE ARCHITECTS
 OFFICE OF REGULATION SERVICES
 APRIL 03-02/2156
 FILE 15-4-6
 DATE: FLS SS

**RUTH HARDING SCHOOL
 MODERNIZATION**
 3201 PICO ST.
 FOR
BAKERSFIELD CITY SCHOOL DISTRICT
 BAKERSFIELD, KERN COUNTY, CALIFORNIA


**BUILDING
 300' & 400'
 FIRE ALARM
 PLAN**

CHECK AND VERIFY ALL DIMENSIONS
 BEFORE PROCEEDING WITH THE
 CONSTRUCTION. ALL
 CONSTRUCTION SHALL CONFORM
 TO THE C.M.C.



MARK	DATE	REVISIONS
△	8-6-03	ENTIRE SHEET
△		
△		

FOR NO. **967**
 DRAWN: **CA**
 CHECKED: **DPG**
 DATE: **04-27-08**

E
 5.3
 of SHEETS

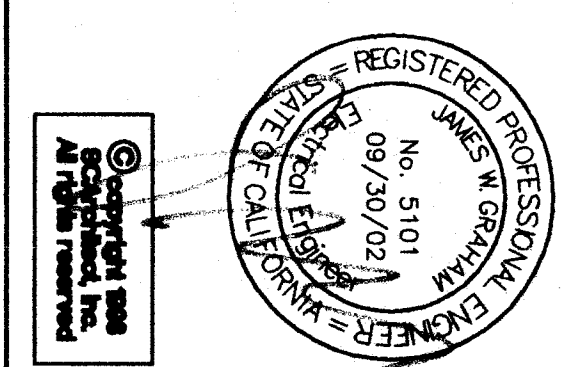

BUILDING 300' AND BUILDING 400' FIRE ALARM PLAN

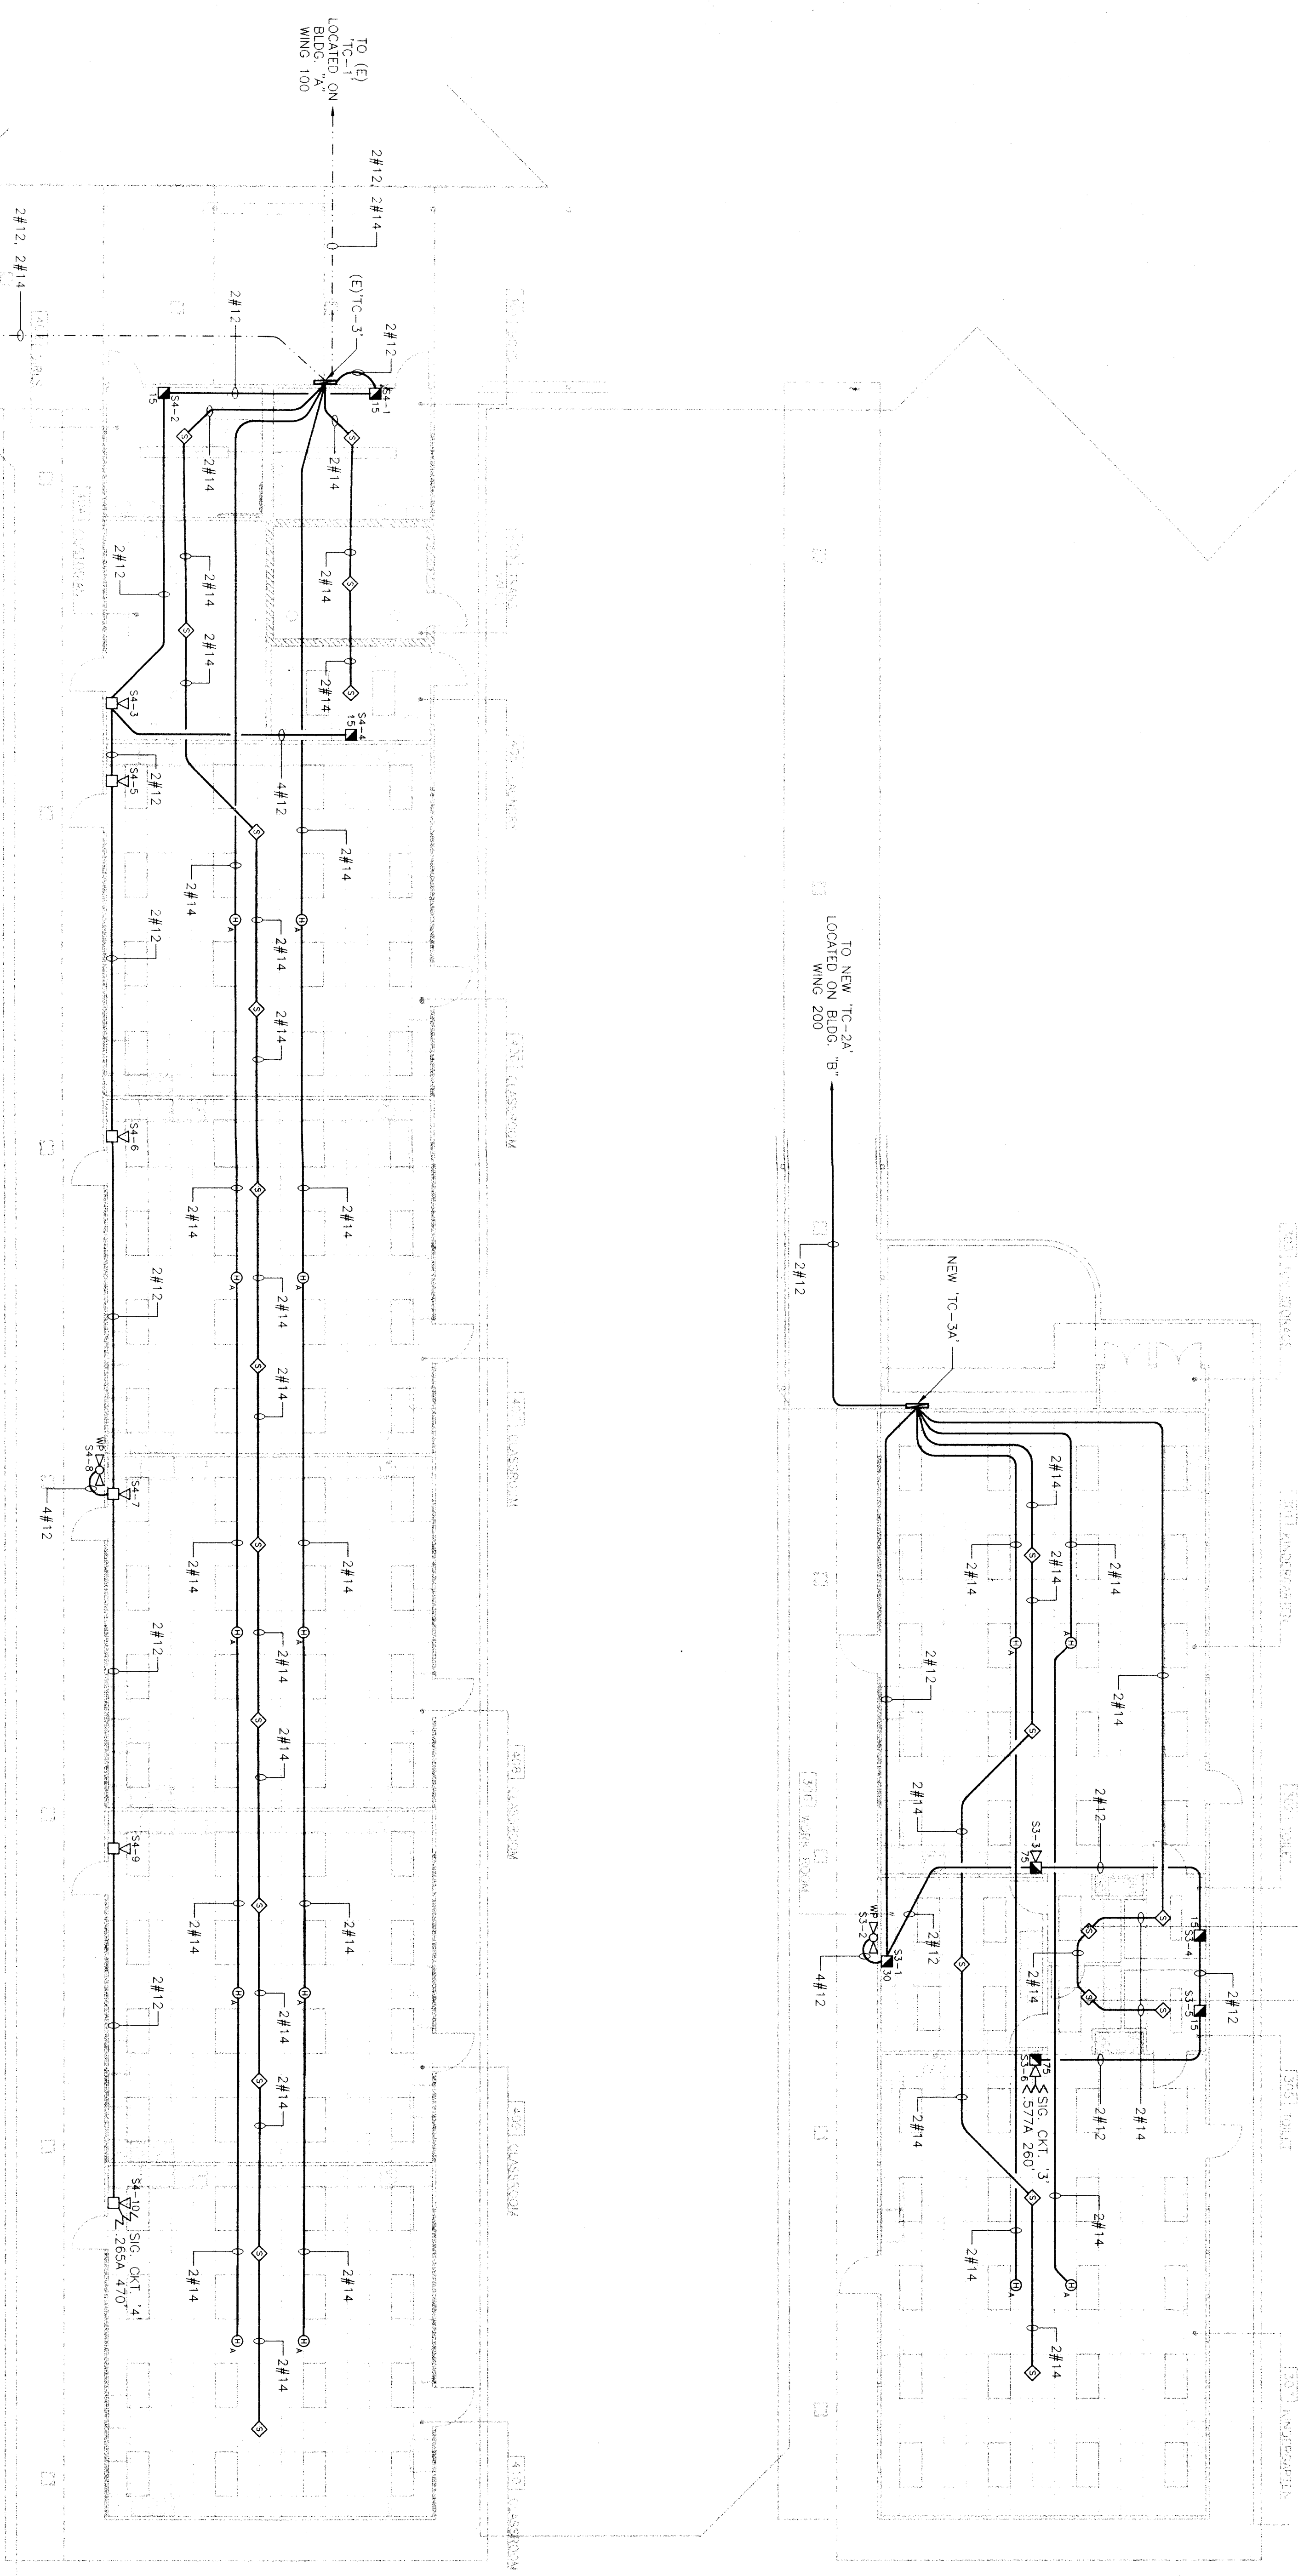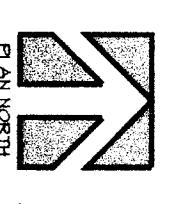

TO (E) TC-4
 LOCATED ON BLDG. 'E'
 WING 500

SCALE: 1/8" = 1'-0"