



SC00176666.dwg (1/28/2010 11:21:17 AM) 1:400 (1/28/2010 11:21:17 AM) 1:400 (1/28/2010 11:21:17 AM) 1:400

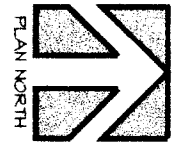


BUILDING '500' AND BUILDING '600' FIRE ALARM PLAN


SCALE: 1/8" = 1'-0"

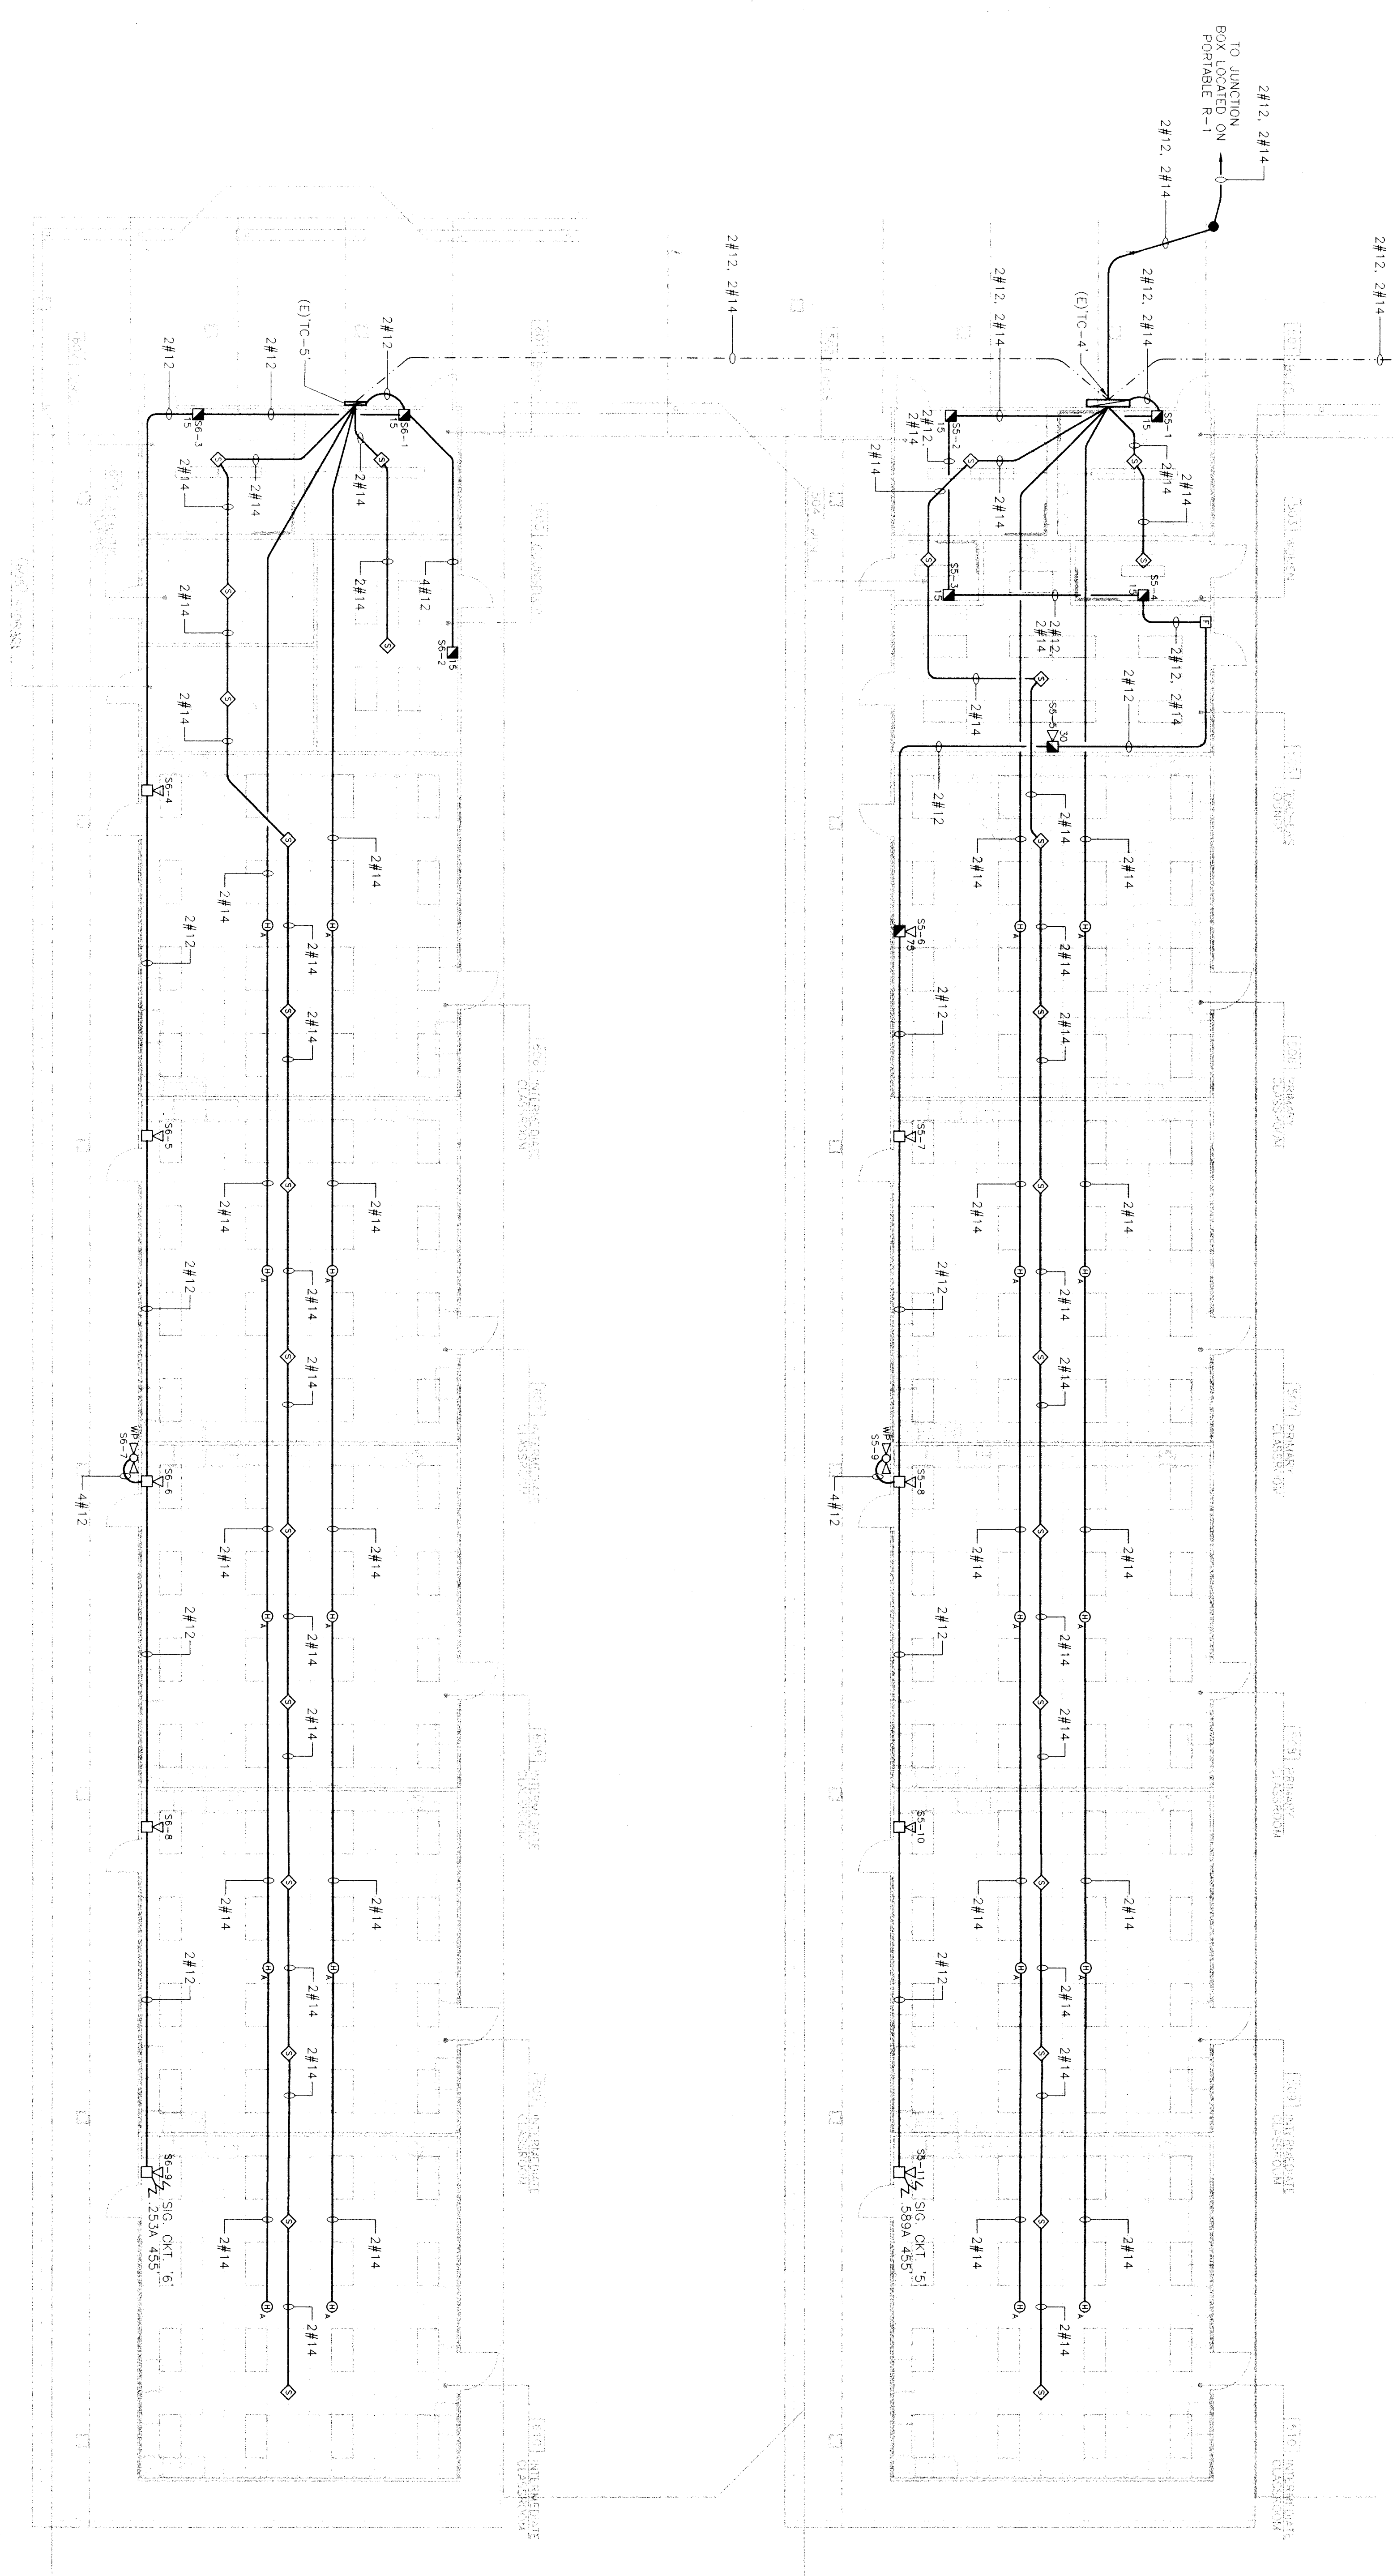

KEY PLAN

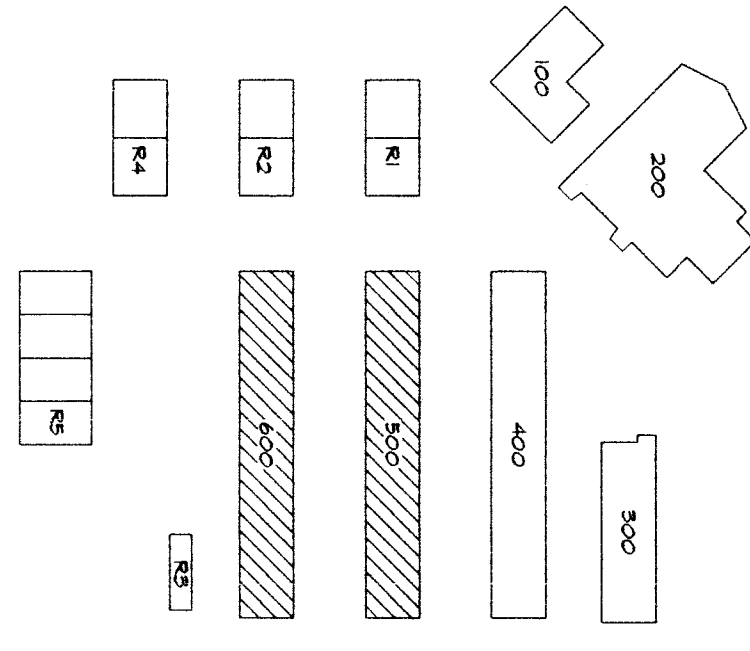

N.T.S.

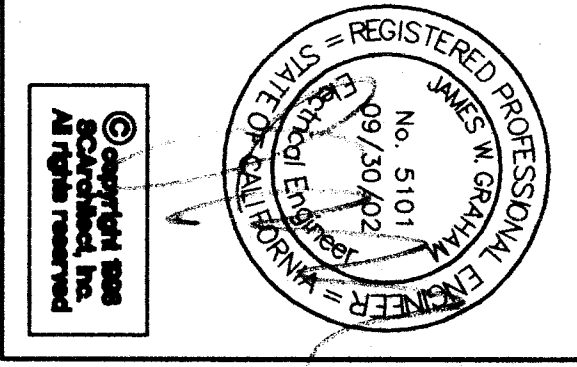

JOB NO. 907
 DRAWN: CA
 CHECKED: DFG
 DATE: 04-27-09

E
 5.4
 OF SHEETS


MARK	DATE	REVISIONS
△	8-6-03	ENTIRE SHEET
△		
△		
△		

BUILDING "500" & "600" FIRE ALARM PLAN

RUTH HARDING SCHOOL MODERNIZATION
3201 PICO ST.
FOR BAKERSFIELD CITY SCHOOL DISTRICT
 BAKERSFIELD, KERN COUNTY, CALIFORNIA

DIVISION OF CONSTRUCTION
 OFFICE OF REGULATION SERVICES
 FILE 57-6
 DATE 11-5-09

INTERSTATE ENGINEERS
 ESTABLISHED 1988
 4665 W. Foothill Ave., Suite 106
 Fresno, California 93711
 (209) 432-2400 / (209) 432-2444 fax
 James W. Gorman, Mechanical Engineer
 E.E. #5101

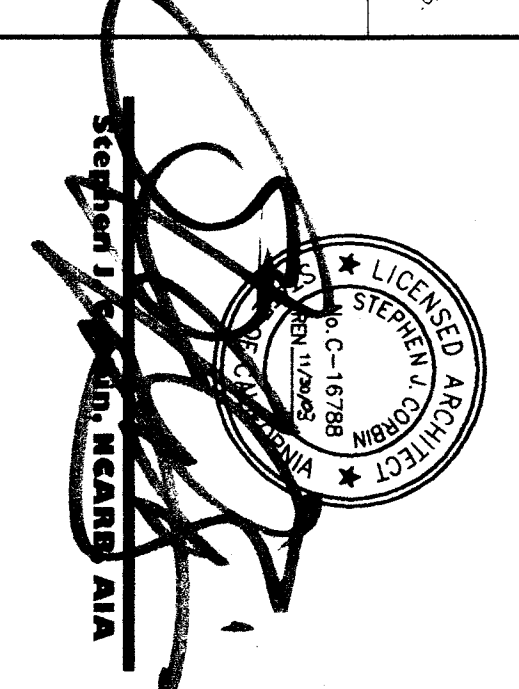

SCA Architect, Inc
 3301 S. STATE ST. #301
 BAKERSFIELD, CA 93301
 (805) 377-1631