


SCArchitect, Inc
 1301 L Street
 Bakersfield, CA 93301
 (805) 327-1637

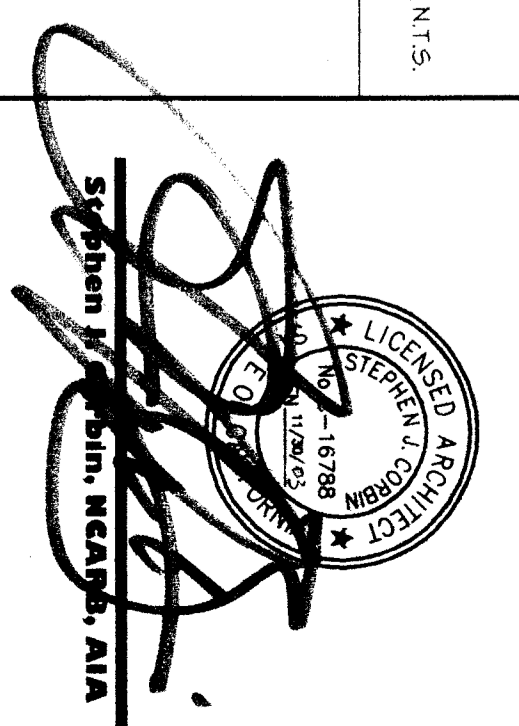

OPERABLE FIRE EXITS
 444 W. FORD COCKE AVE #400
 BAKERSFIELD, CA 93311
 (805) 432-4500 / (209) 432-4874 FAX
 James W. Gordon, Electrical Engineer
 E.E. #5101

REGISTRATION STAMP
 DIV. OF THE STATE ARCHITECT
 JOHN W. GORDON
 LICENSE NO. 5101
 EXPIRES 12/31/2025
 TEL: 874/6
 FAX: 874/6
 STATE: CA
 CITY: BAKERSFIELD

**RUTH HARDING SCHOOL
 MODERNIZATION**
 3201 PICO ST.
 FOR
BAKERSFIELD CITY SCHOOL DISTRICT
 BAKERSFIELD, KERN COUNTY, CALIFORNIA


**PORTABLES
 "R-1", "R-2", "R-3",
 "R-4" AND "R-5"
 FIRE ALARM PLAN**

CHECK AND VERIFY ALL DIMENSIONS
 BEFORE CONSTRUCTION.
 WORK, REPORT DISCREPANCIES
 TO THE ARCHITECT. ALL
 DIMENSIONS SHALL CONFORM
 TO THE C.C.P.

MARK	DATE	REVISIONS
△	8-6-03	ENTIRE SHEET
△		
△		

JOB NO. **967**
 DRAWN: **CA**
 CHECKED: **DA**
 DATE: **04-27-00**

5.5
 OF SHEETS

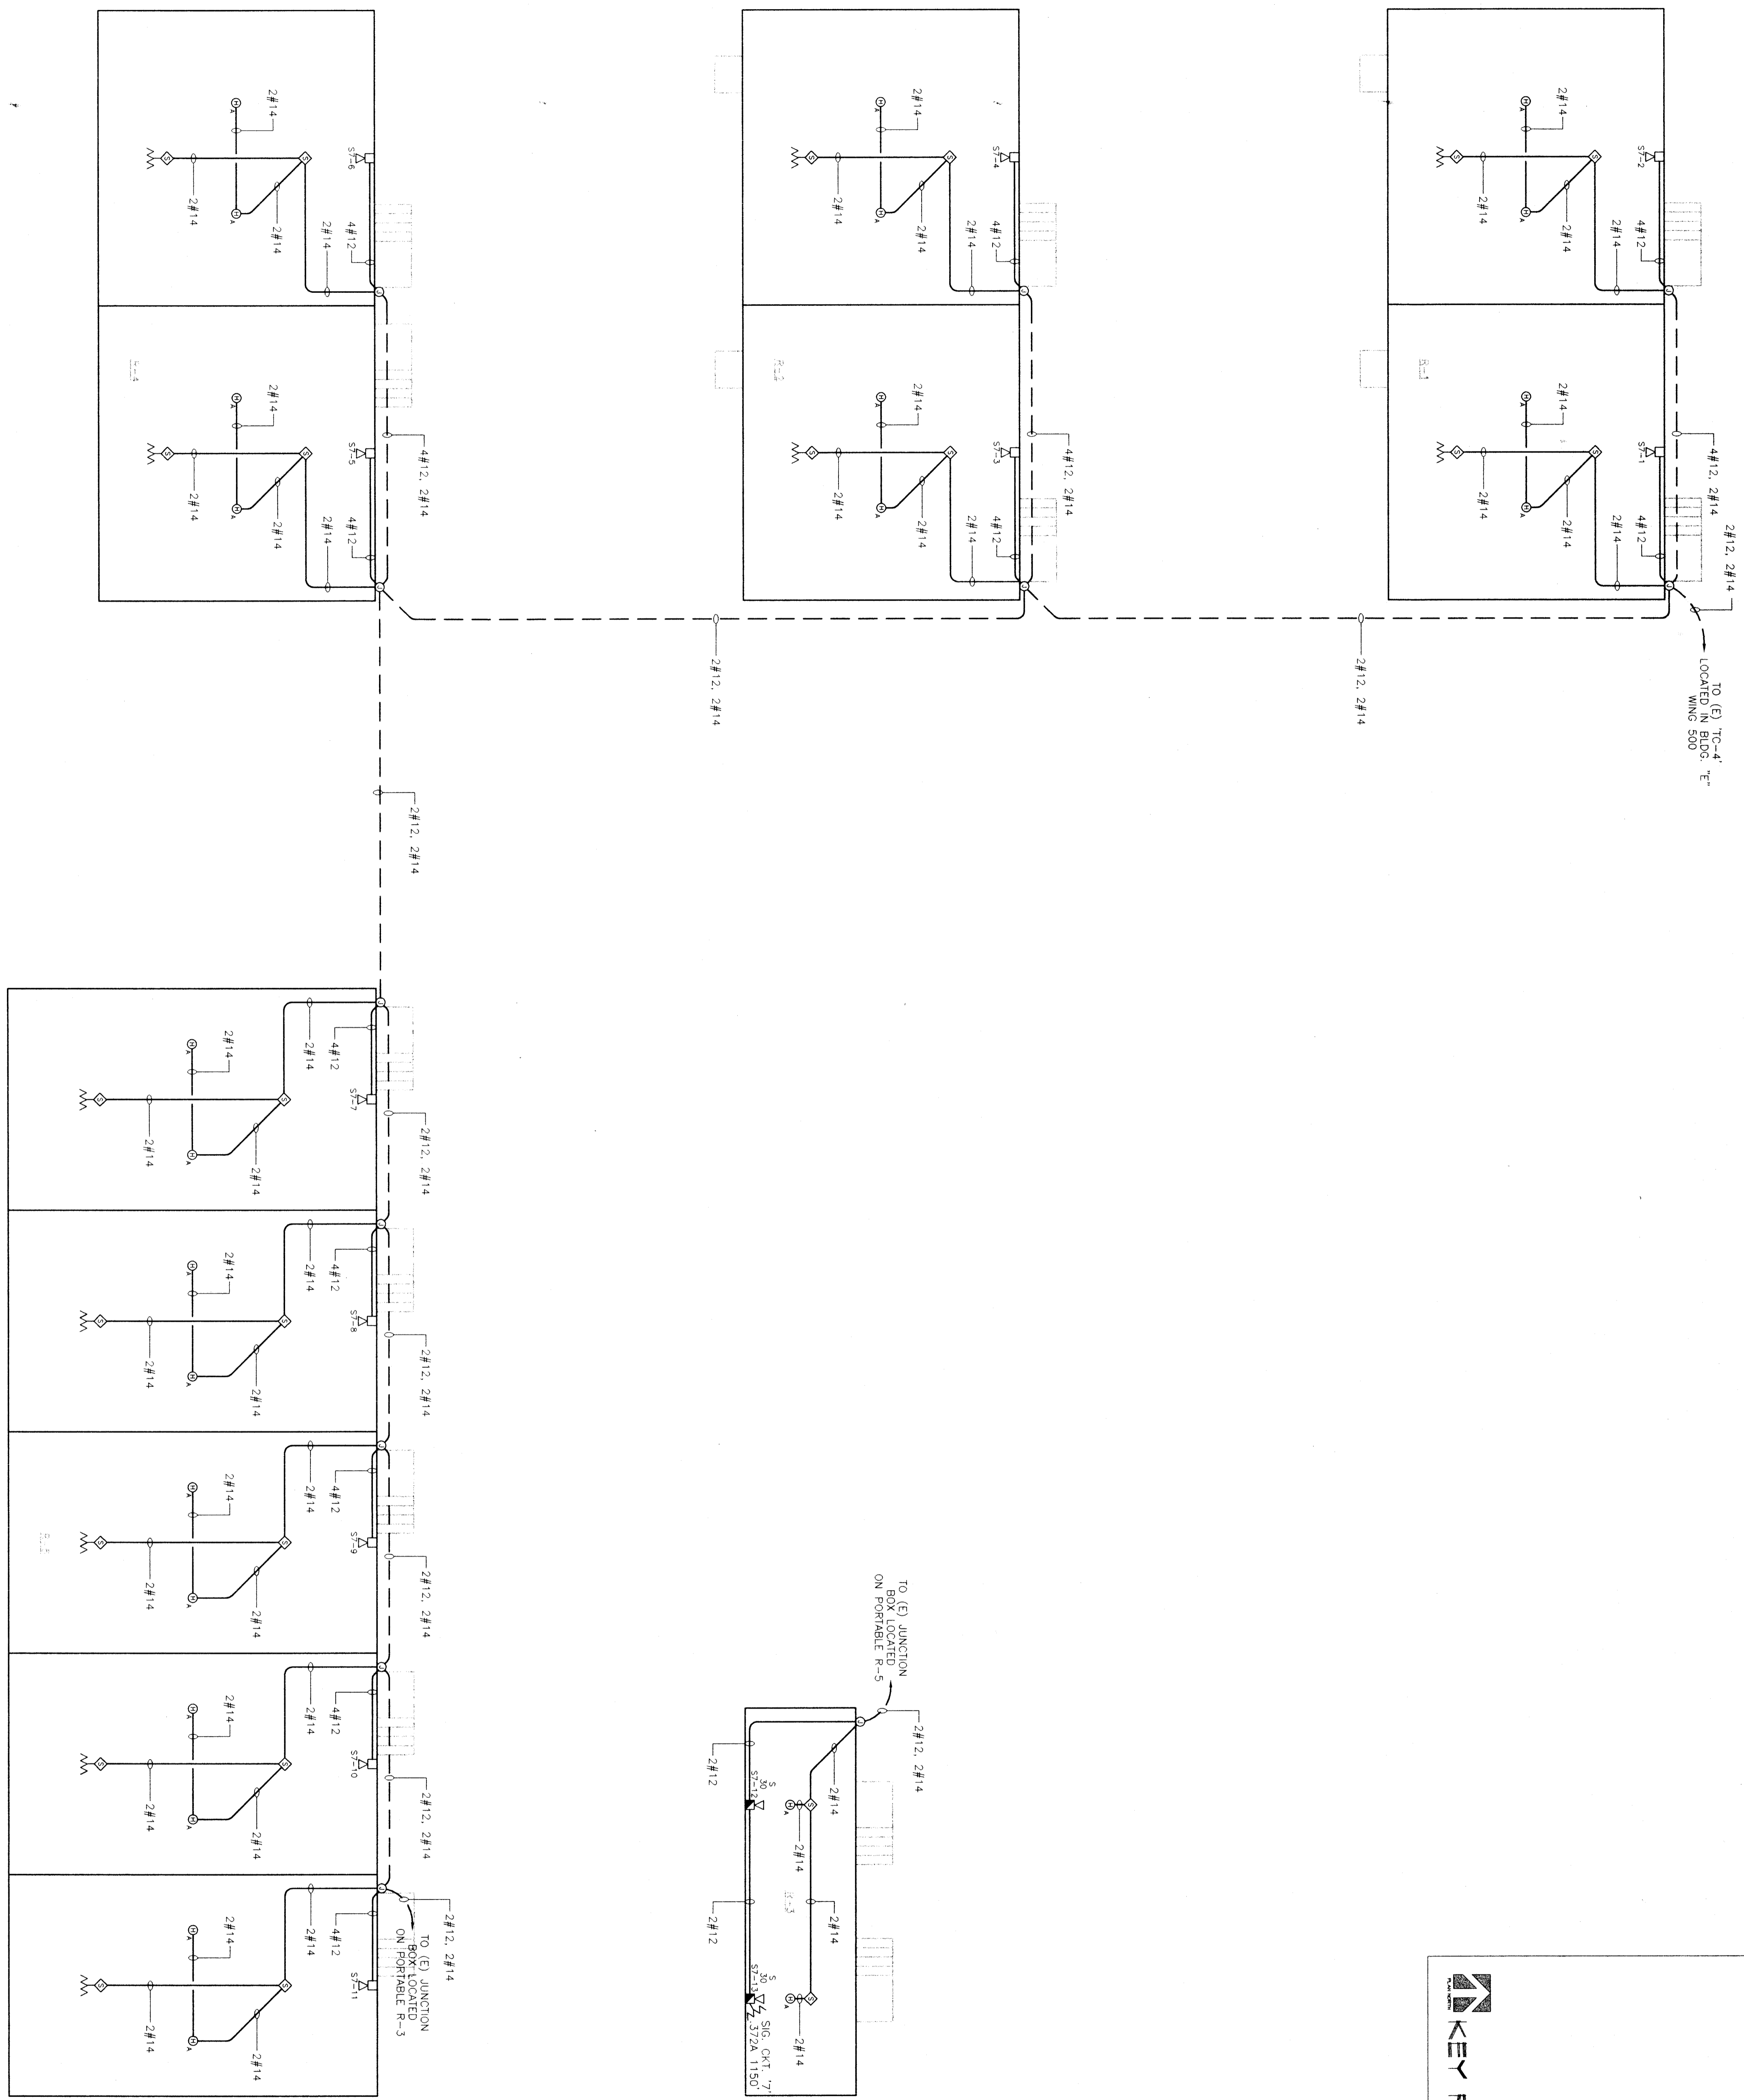

PORTABLES "R-1", "R-2", "R-3", "R-4" AND "R-5" FIRE ALARM PLAN

SCALE: 1/8" = 1'-0"

