


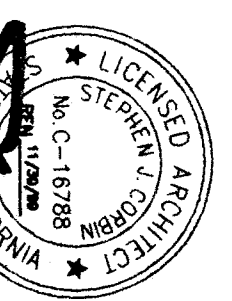

SCA Architect, Inc.
1301 L Street
Bakersfield, CA 93301
(805) 327-1632



MDC
MECHANICAL DESIGN CONCEPTS
MECHANICAL DESIGN CONCEPTS
1400 S. STATE ST. SUITE 200
BAKERSFIELD, CA 93305
TEL: 805.327.1632
FAX: 805.327.1632
PLOTTED 4/21/99

MECHANICAL DESIGN CONCEPTS
MECHANICAL DESIGN CONCEPTS
1400 S. STATE ST. SUITE 200
BAKERSFIELD, CA 93305
TEL: 805.327.1632
FAX: 805.327.1632
PLOTTED 4/21/99

REGISTRATION STAMP
DIV. OF THE STATE ARCHITECT
EXPIRES 03-10-2016
MDC
DATE: APR 11 1999

**RUTH HARDING SCHOOL
MODERNIZATION
3201 PICO ST.
FOR
BAKERSFIELD CITY SCHOOL DISTRICT
BAKERSFIELD, KERN COUNTY, CALIFORNIA**





**WING-300
MECHANICAL
DEMOLITION,
AND
FLOOR PLANS**

CHECK AND VERIFY ALL DIMENSIONS
BEFORE PROCEEDING WITH THE
WORK. REPORT DISCREPANCIES
TO THE ARCHITECT. ALL
CONSTRUCTION SHALL CONFORM
TO THE C.S.C.


MARK	DATE	REVISIONS
△		
△		
△		
△		

JOB NO.
957
DRAWN BY
S.K.
CHECKED BY
MDC
DATE:
4/21/99



M
3.2
5 OF 9 SHEETS

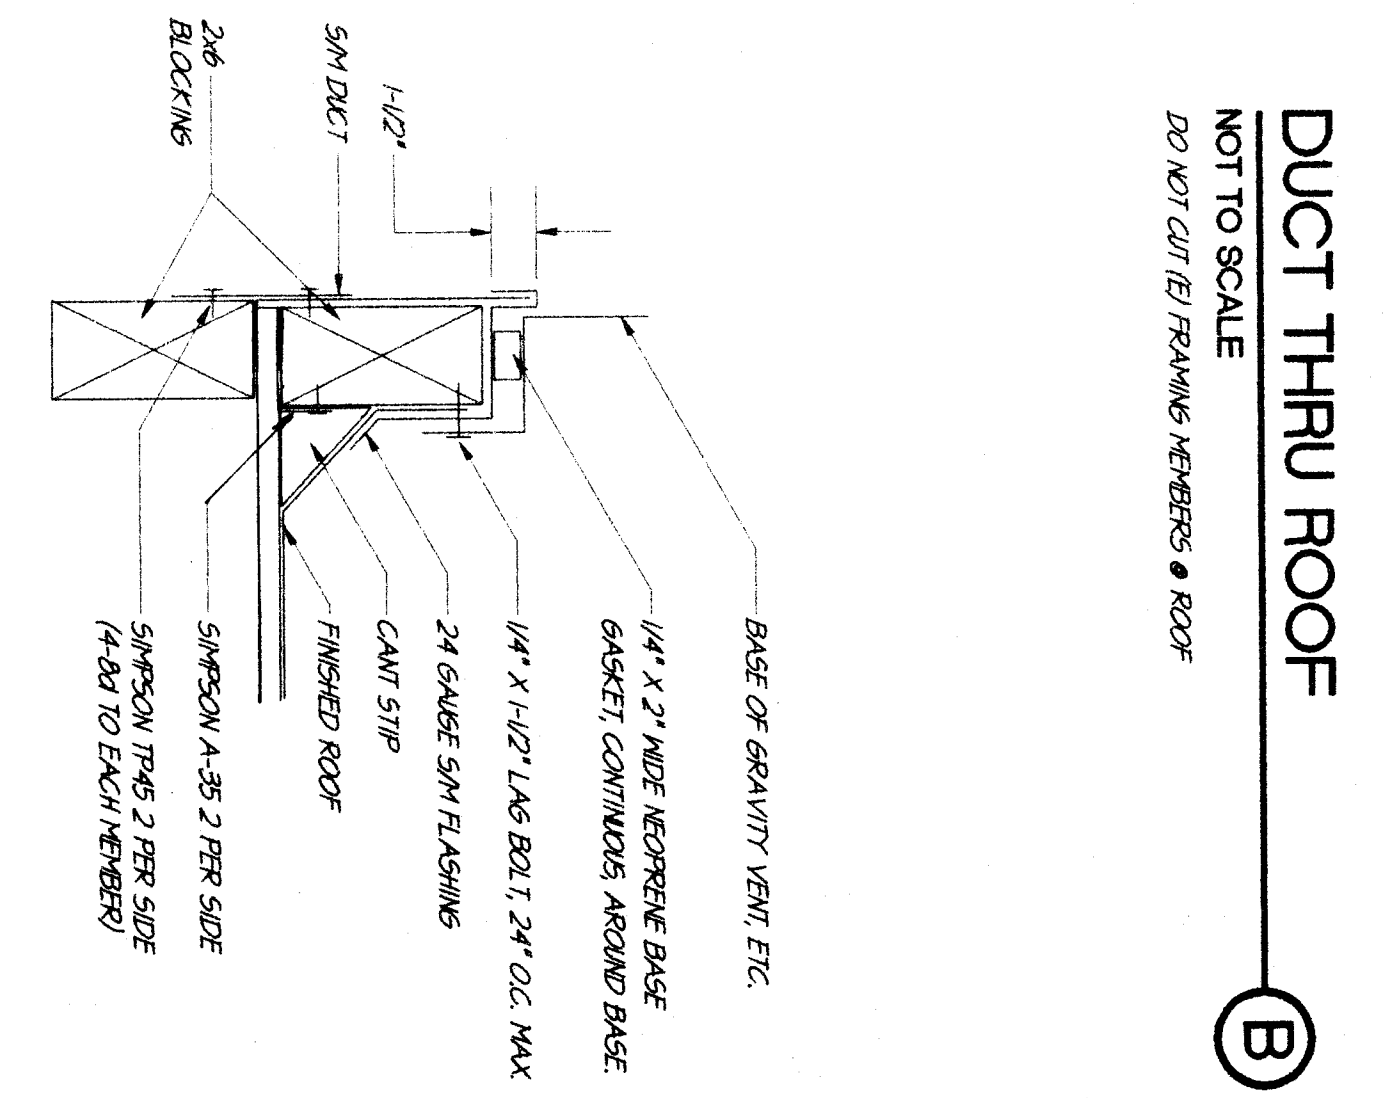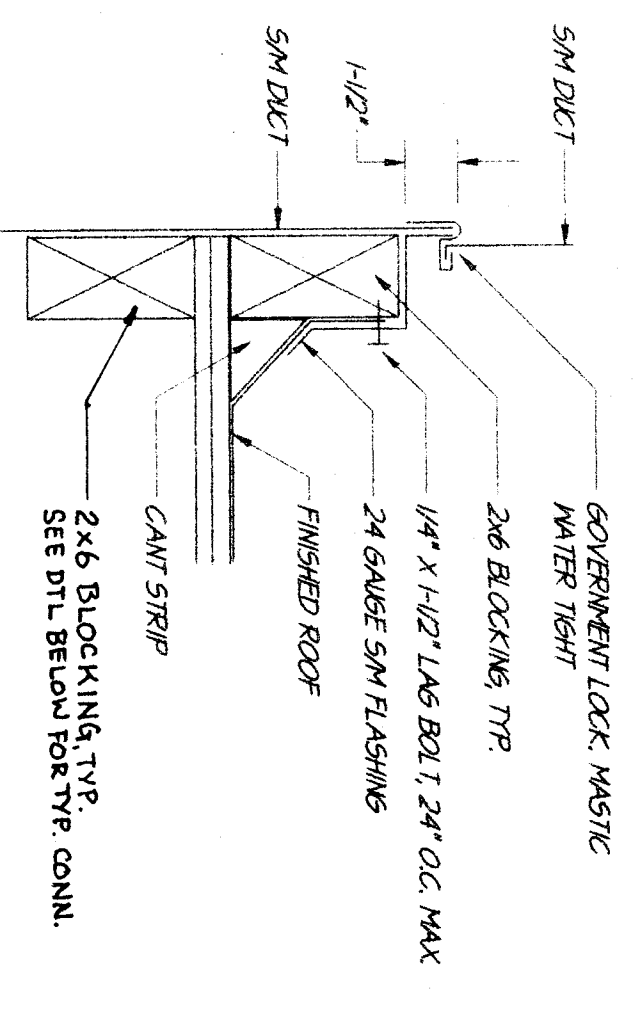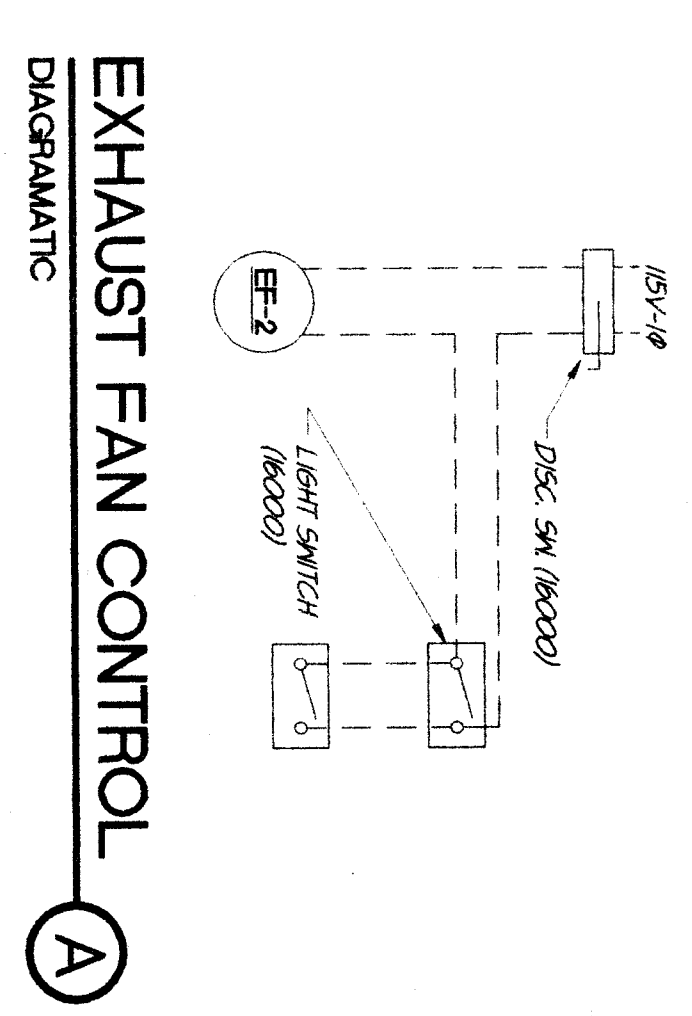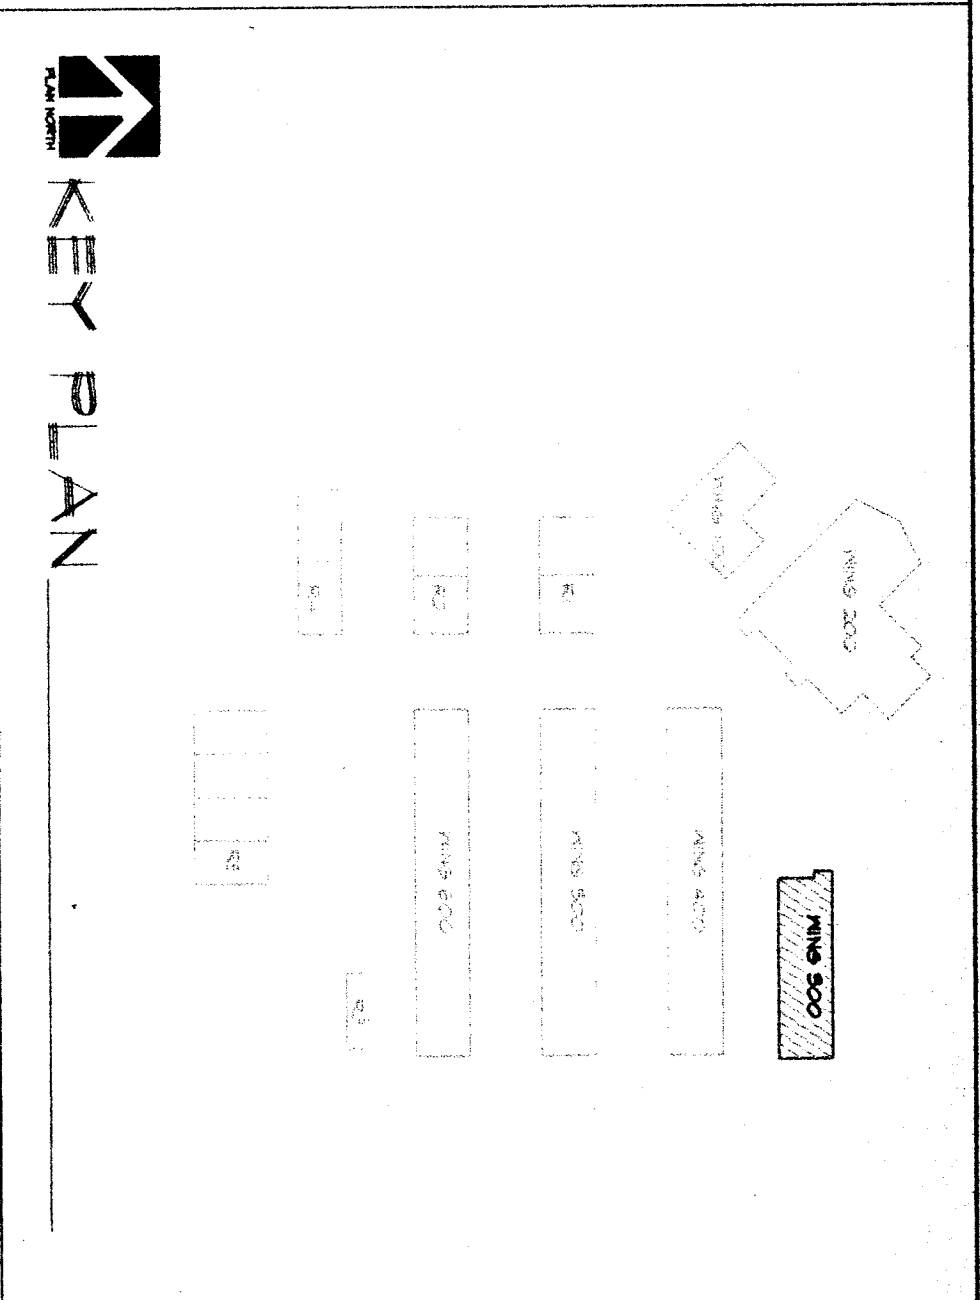

NORTH
MECHANICAL DEMOLITION FLOOR PLAN (WING-300)
SCALE 1/4"=1'-0"

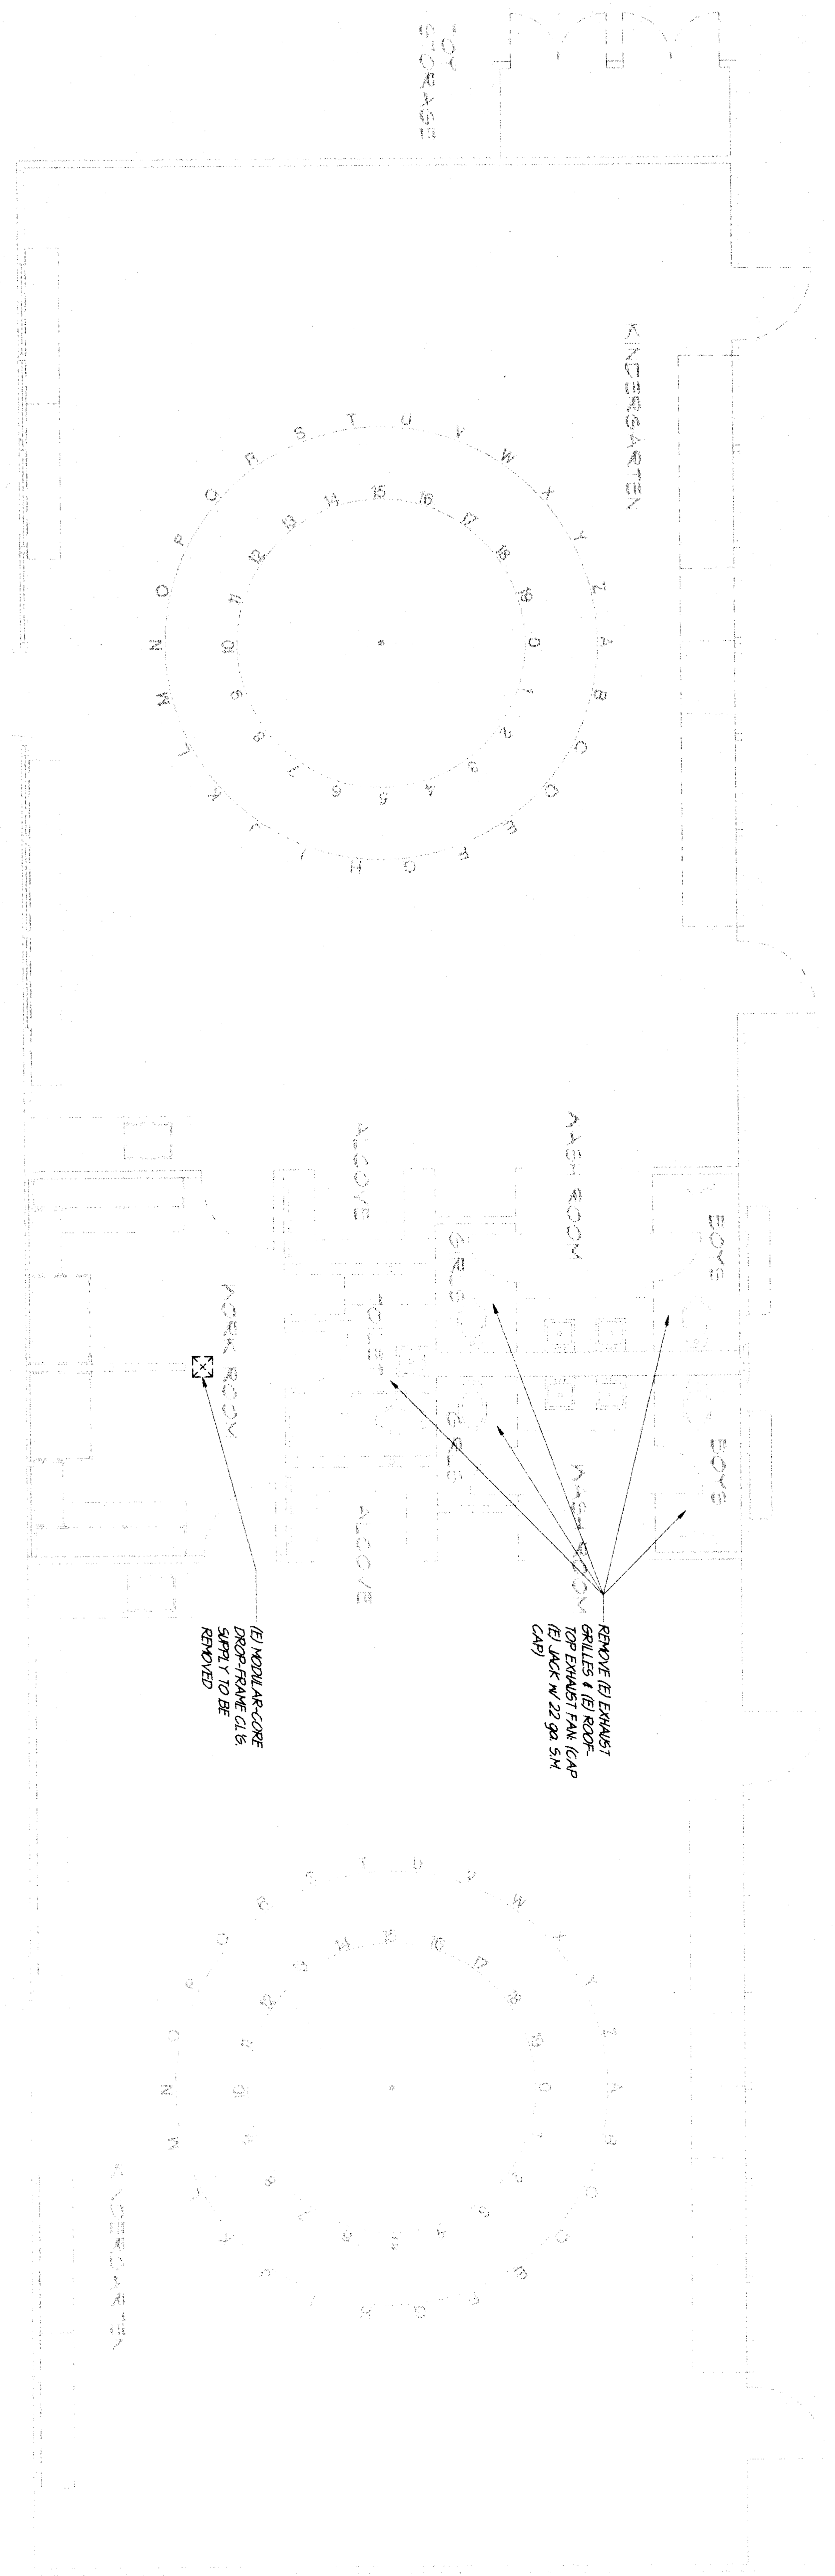

NORTH
MECHANICAL FLOOR PLAN (WING-300)
SCALE 1/4"=1'-0"

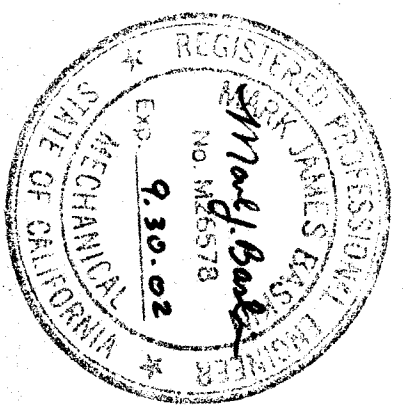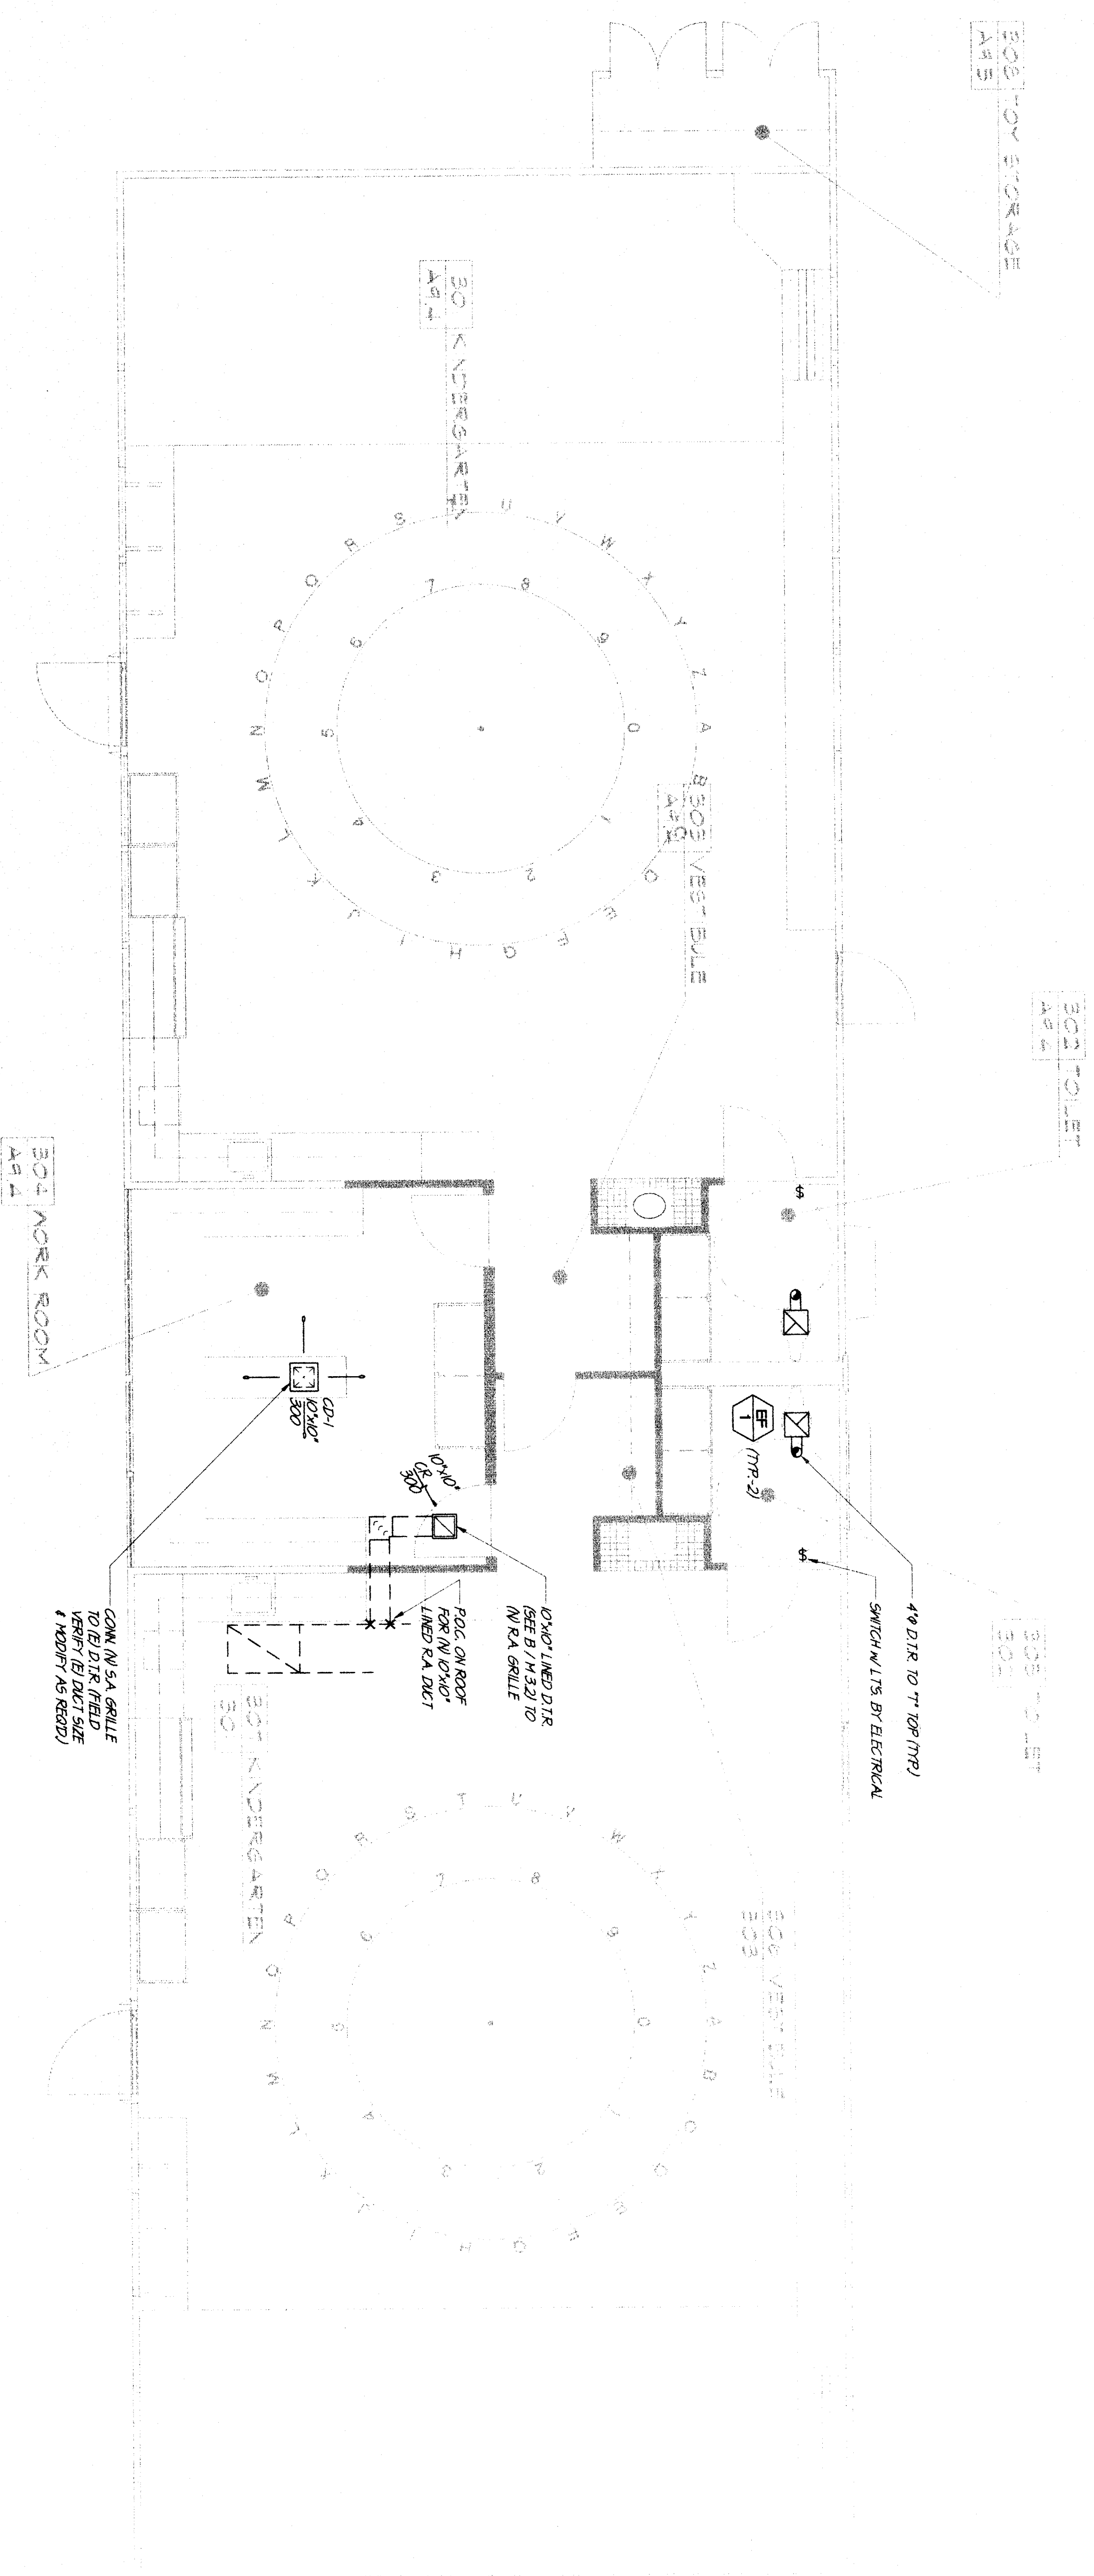

REGISTRATION STAMP
DIV. OF THE STATE ARCHITECT
EXPIRES 03-10-2016
MDC
DATE: APR 11 1999