

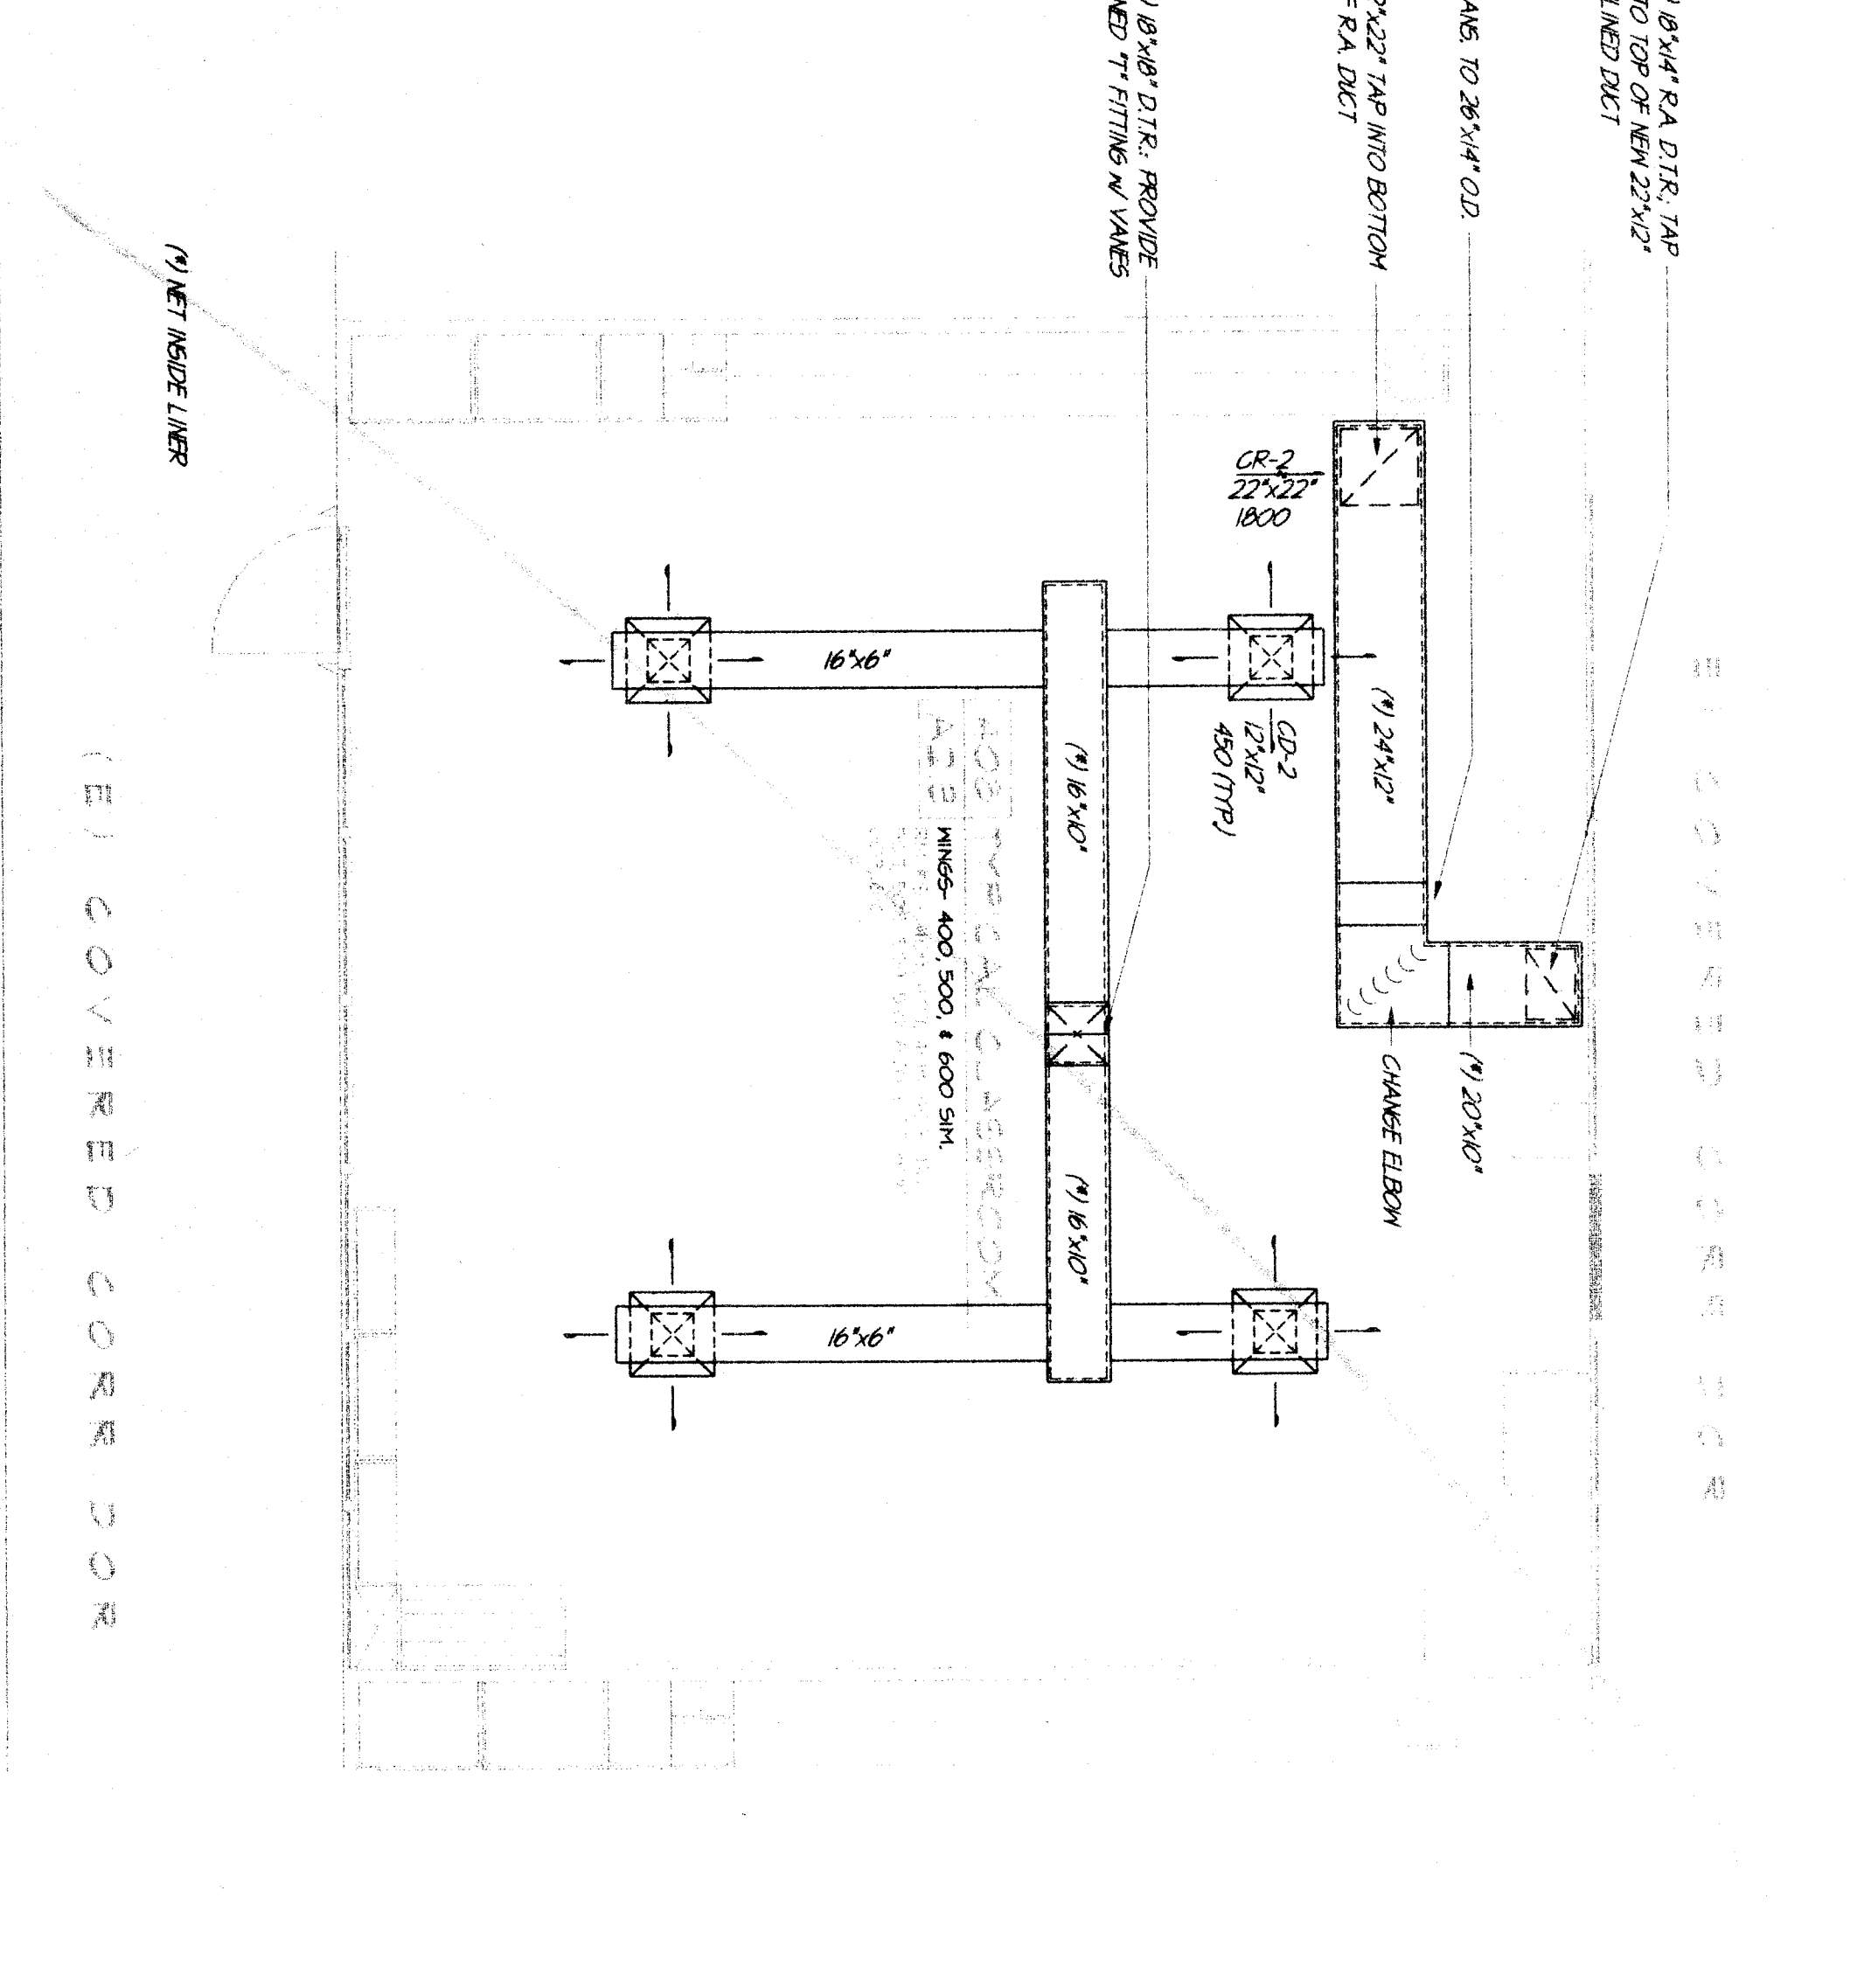
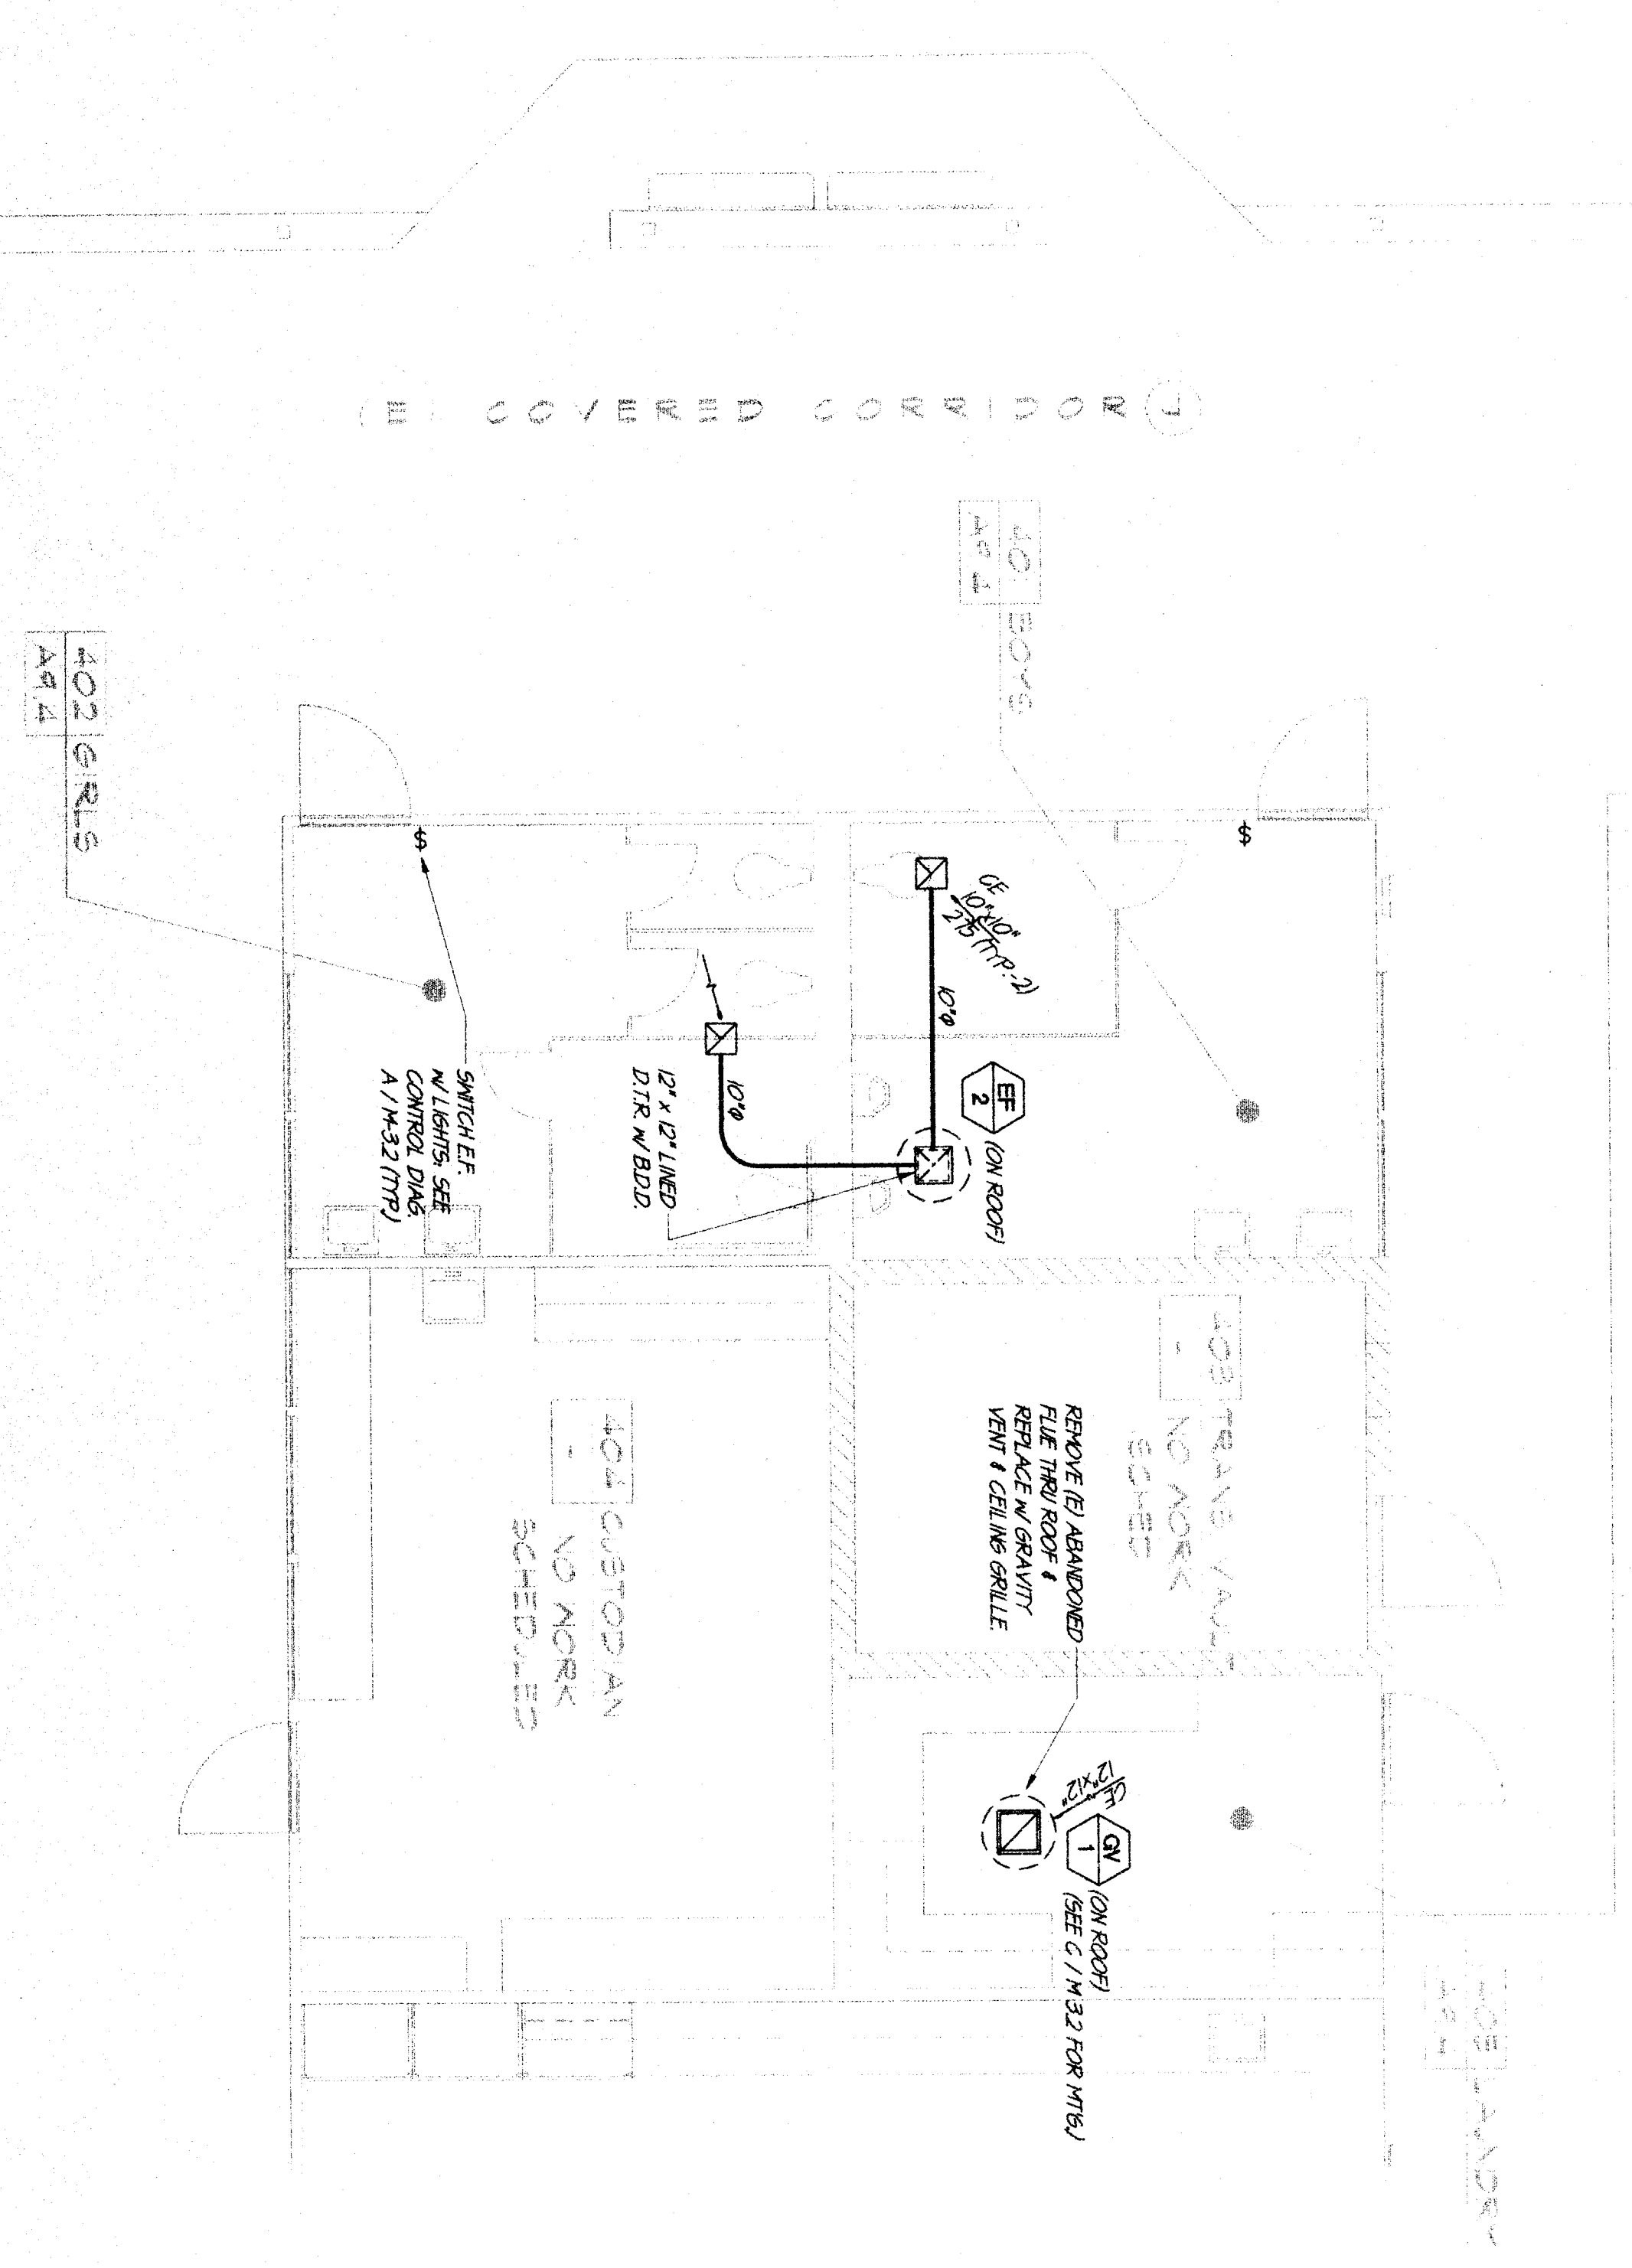


NORTH
MECHANICAL DEMOLITION FLOOR PLAN (WING-400)
SCALE 1/4"=1'-0"

NORTH
MECHANICAL DEMOLITION FLOOR PLAN (CLASSROOMS IN WINGS 400, 500, + 600)
SCALE 1/4"=1'-0"

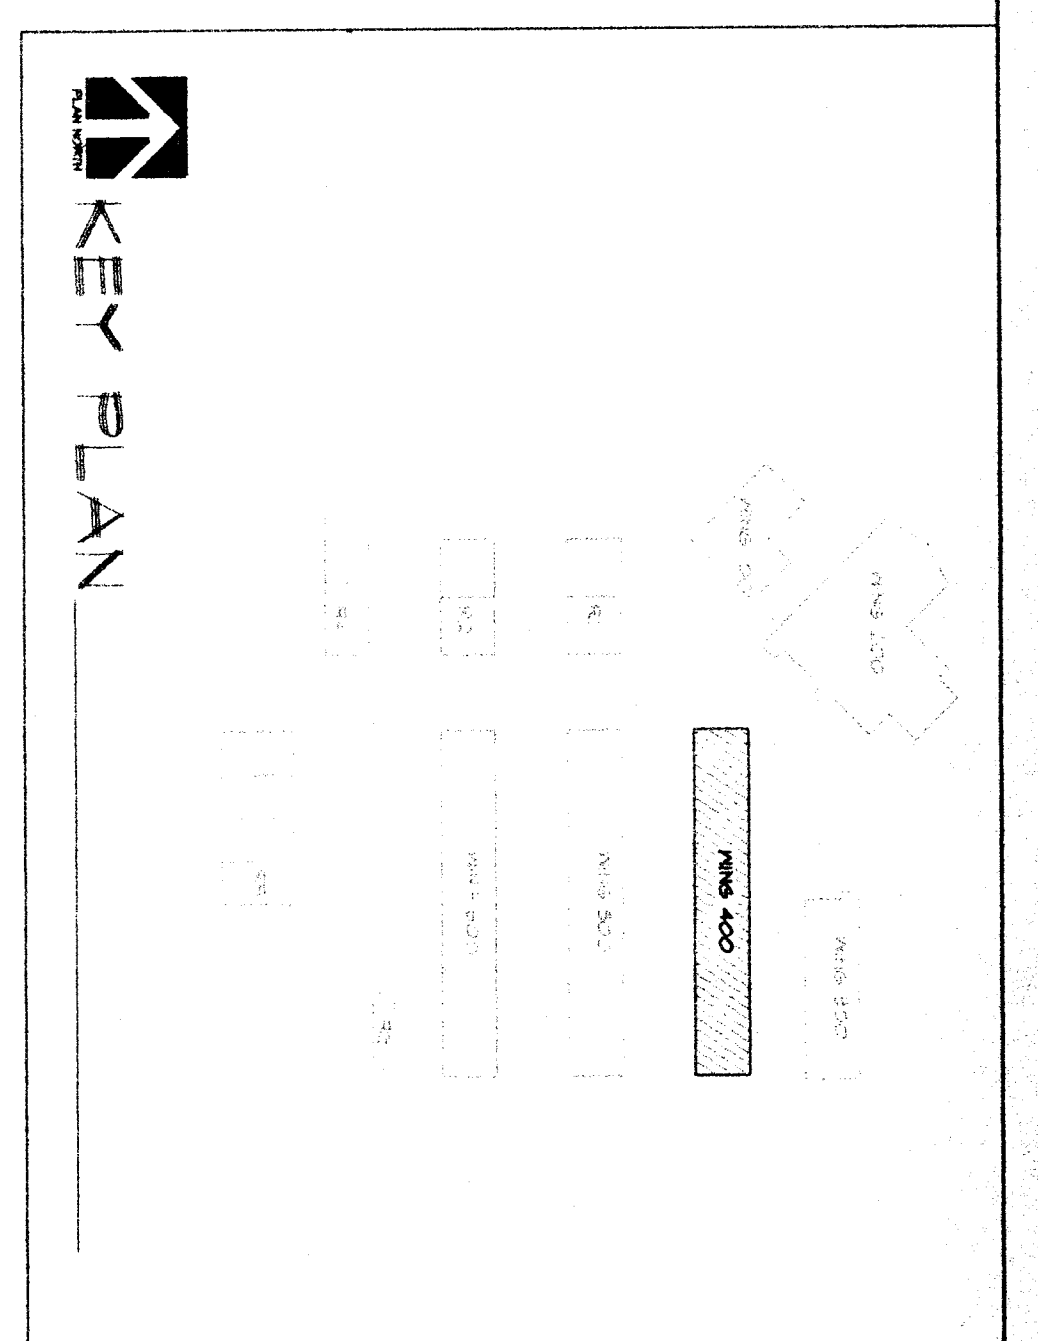

35. Refer to Drawing Sheet A3.3, Part of Plans, C and D in their entirety.

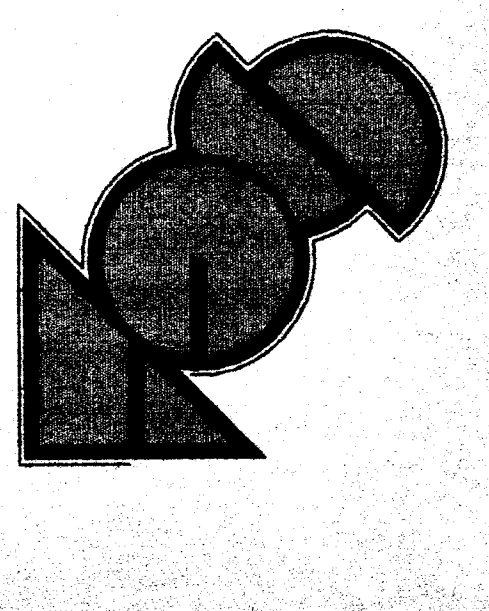

SCA Architect, Inc.
1301 L Street
Bakersfield, CA 93301
(805) 337-1632



#8906
MDC
MECHANICAL DESIGN CONCERNS
MECHANICAL ENGINEERING SERVICES
1400 20th St. Bldg. 200
Bakersfield, CA 93310
Tel: 805 338-1000
FAX: 805 338-1000
PLOTTED 4/21/99

REGISTRATION STATE
DIV. OF THE STATE ARCHITECT
OFFICE OF REGULATION SERVICES
APR. 03 1992 156
REL. 15-6
DATE: APR 13 1999
MDC

**RUTH HARDING SCHOOL
MODERNIZATION**
3201 PICO ST.
FOR
BAKERSFIELD CITY SCHOOL DISTRICT
BAKERSFIELD, KERN COUNTY, CALIFORNIA

**WING - 400
MECHANICAL,
DEMOLITION,
AND
FLOOR PLANS**
WINGS 400, 500,
& 600 CLASSROOM
MECHANICAL PLANS


CHECK AND VERIFY ALL DIMENSIONS
BEFORE PROCEEDING WITH THE
WORK. REPORT DISCREPANCIES
TO THE ARCHITECT. ALL
CONSTRUCTION SHALL CONFORM
TO THE C.S.D.

MARK	DATE	REVISIONS
△		
△		
△		
△		

JOB NO. 957
DRAWN BY SA
CHECKED BY SA
DATE: 4/21/99

3.3

4 OF 5 SHEETS

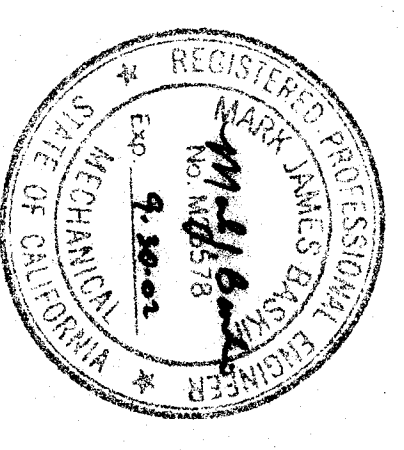

NORTH
MECHANICAL FLOOR PLAN (WING-400)
SCALE 1/4"=1'-0"

NORTH
MECHANICAL FLOOR PLAN (CLASSROOMS IN WINGS 400, 500, + 600)
SCALE 1/4"=1'-0"