




NORTH
SCALE 1/4"=1'-0"
MECHANICAL DEMOLITION FLOOR PLAN (WING-500)

(A)

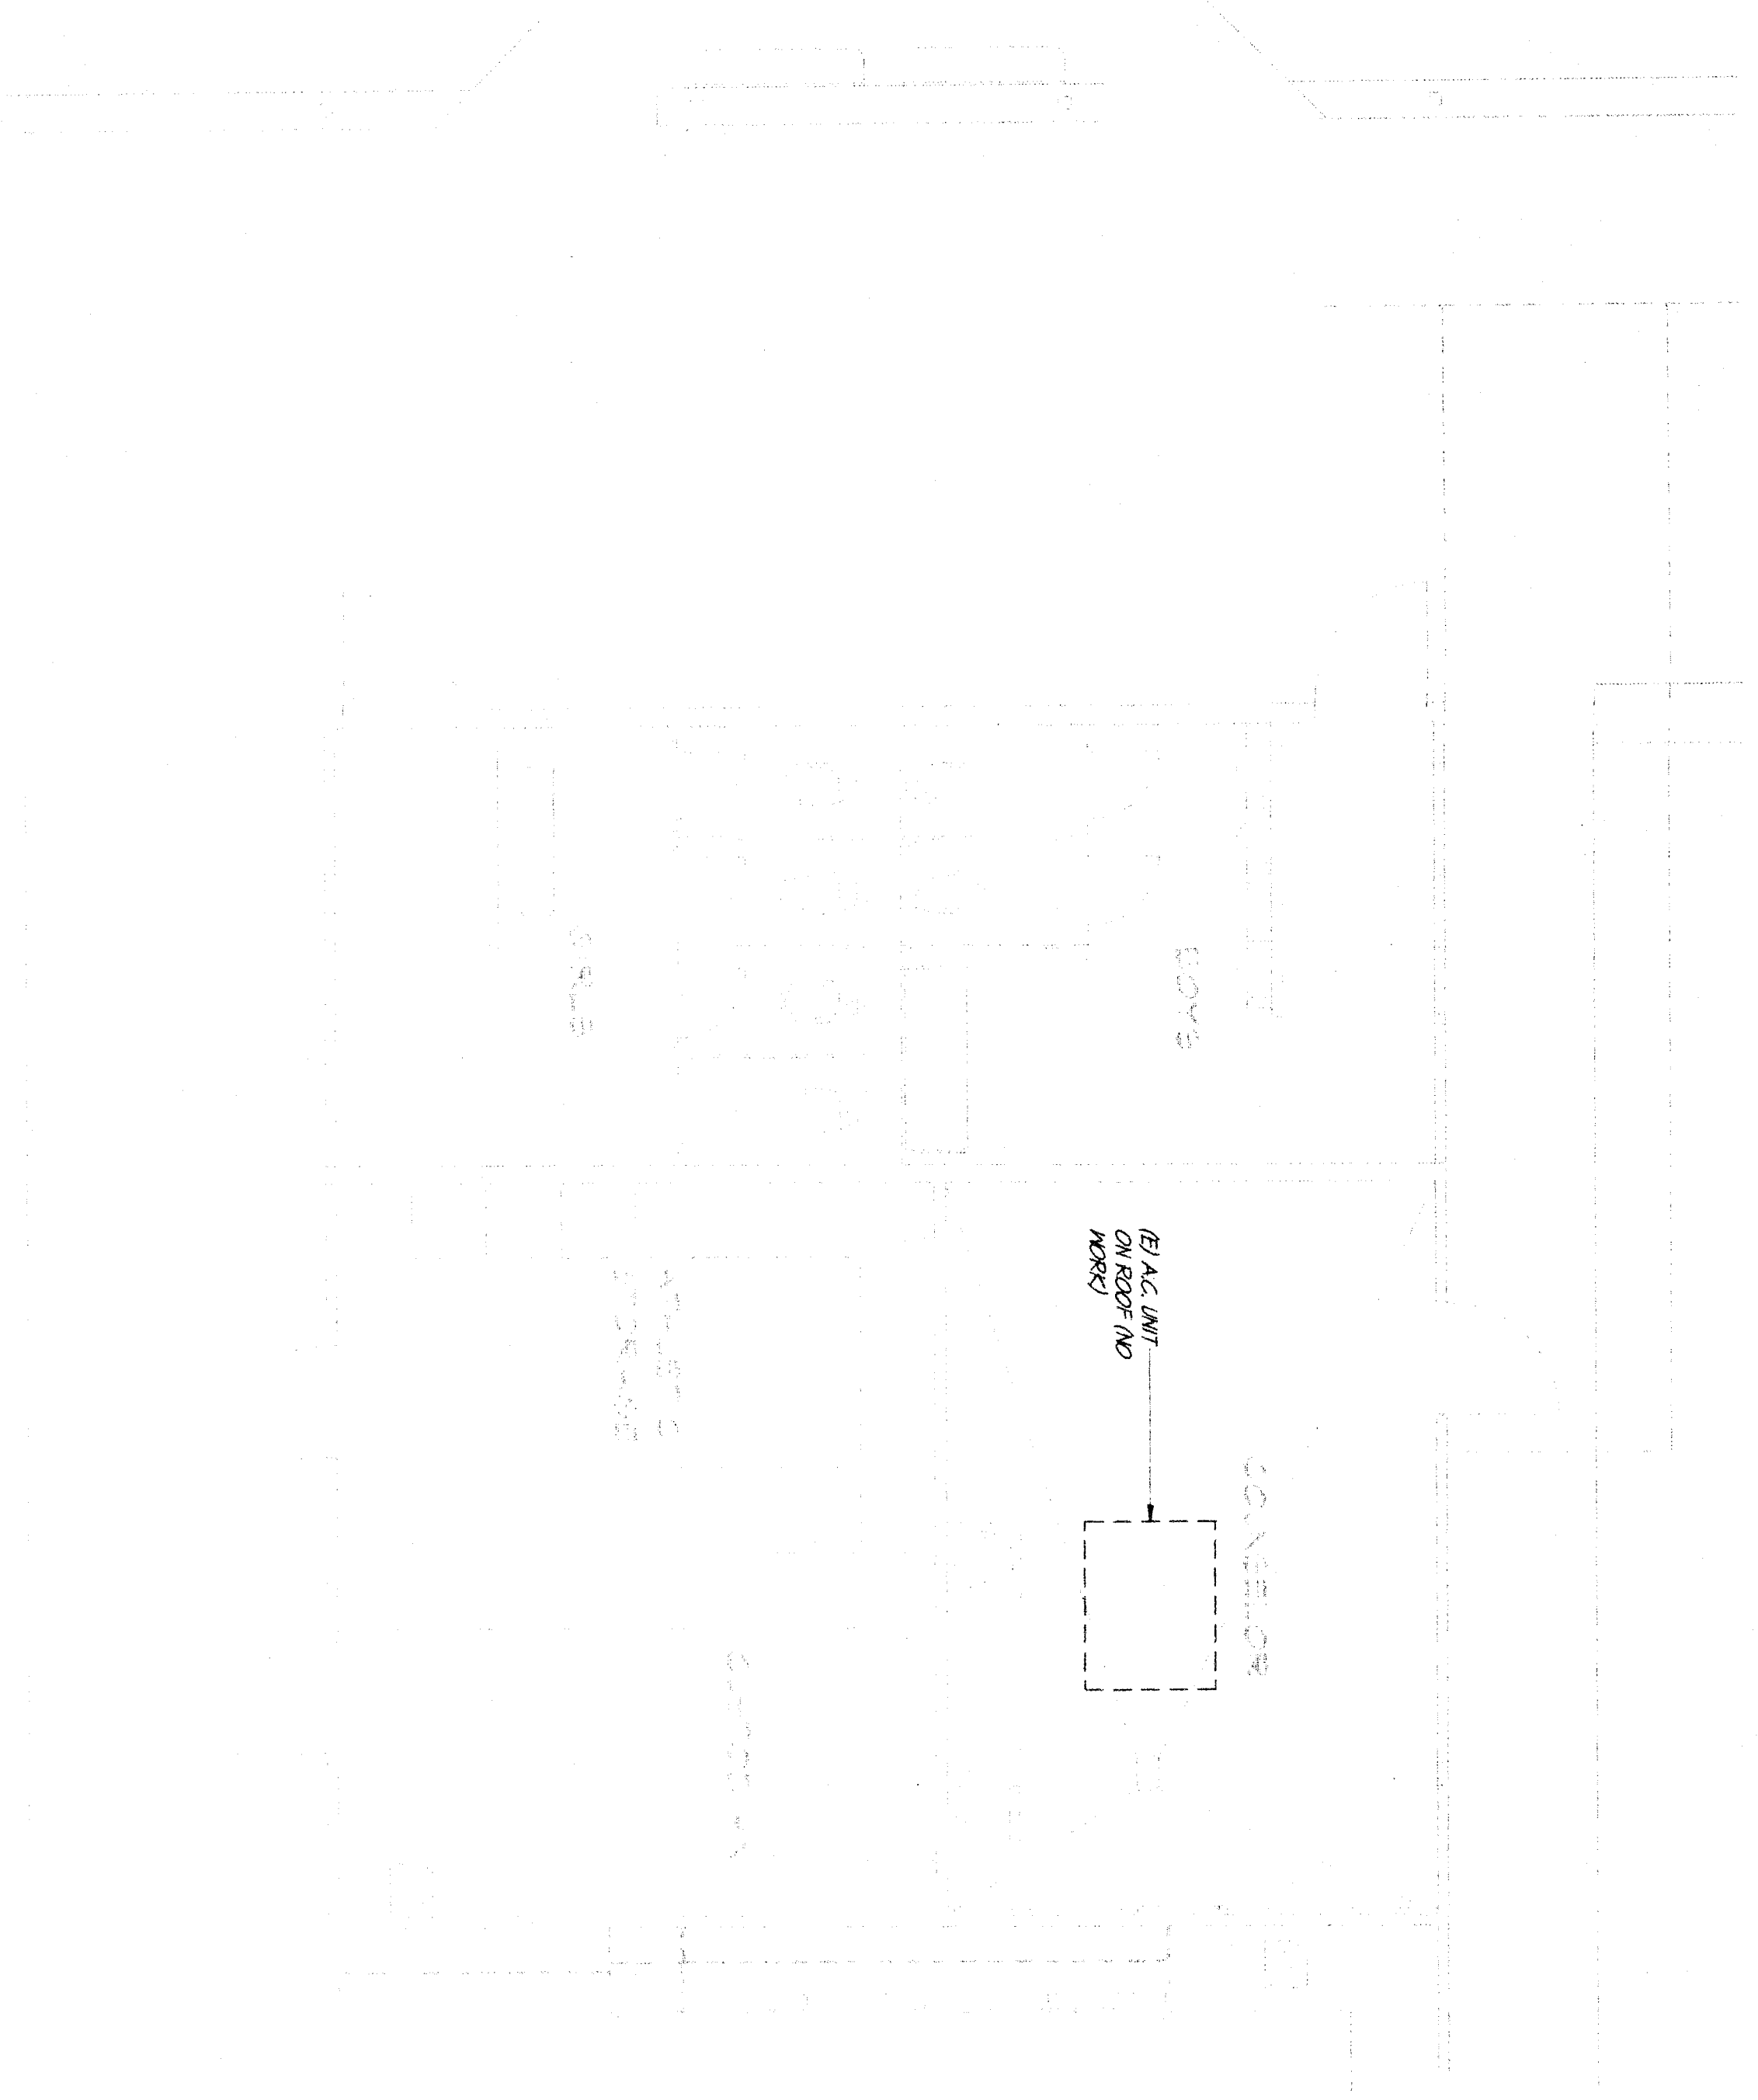


NORTH
SCALE 1/4"=1'-0"
MECHANICAL DEMOLITION FLOOR PLAN (WING-600)

(C)

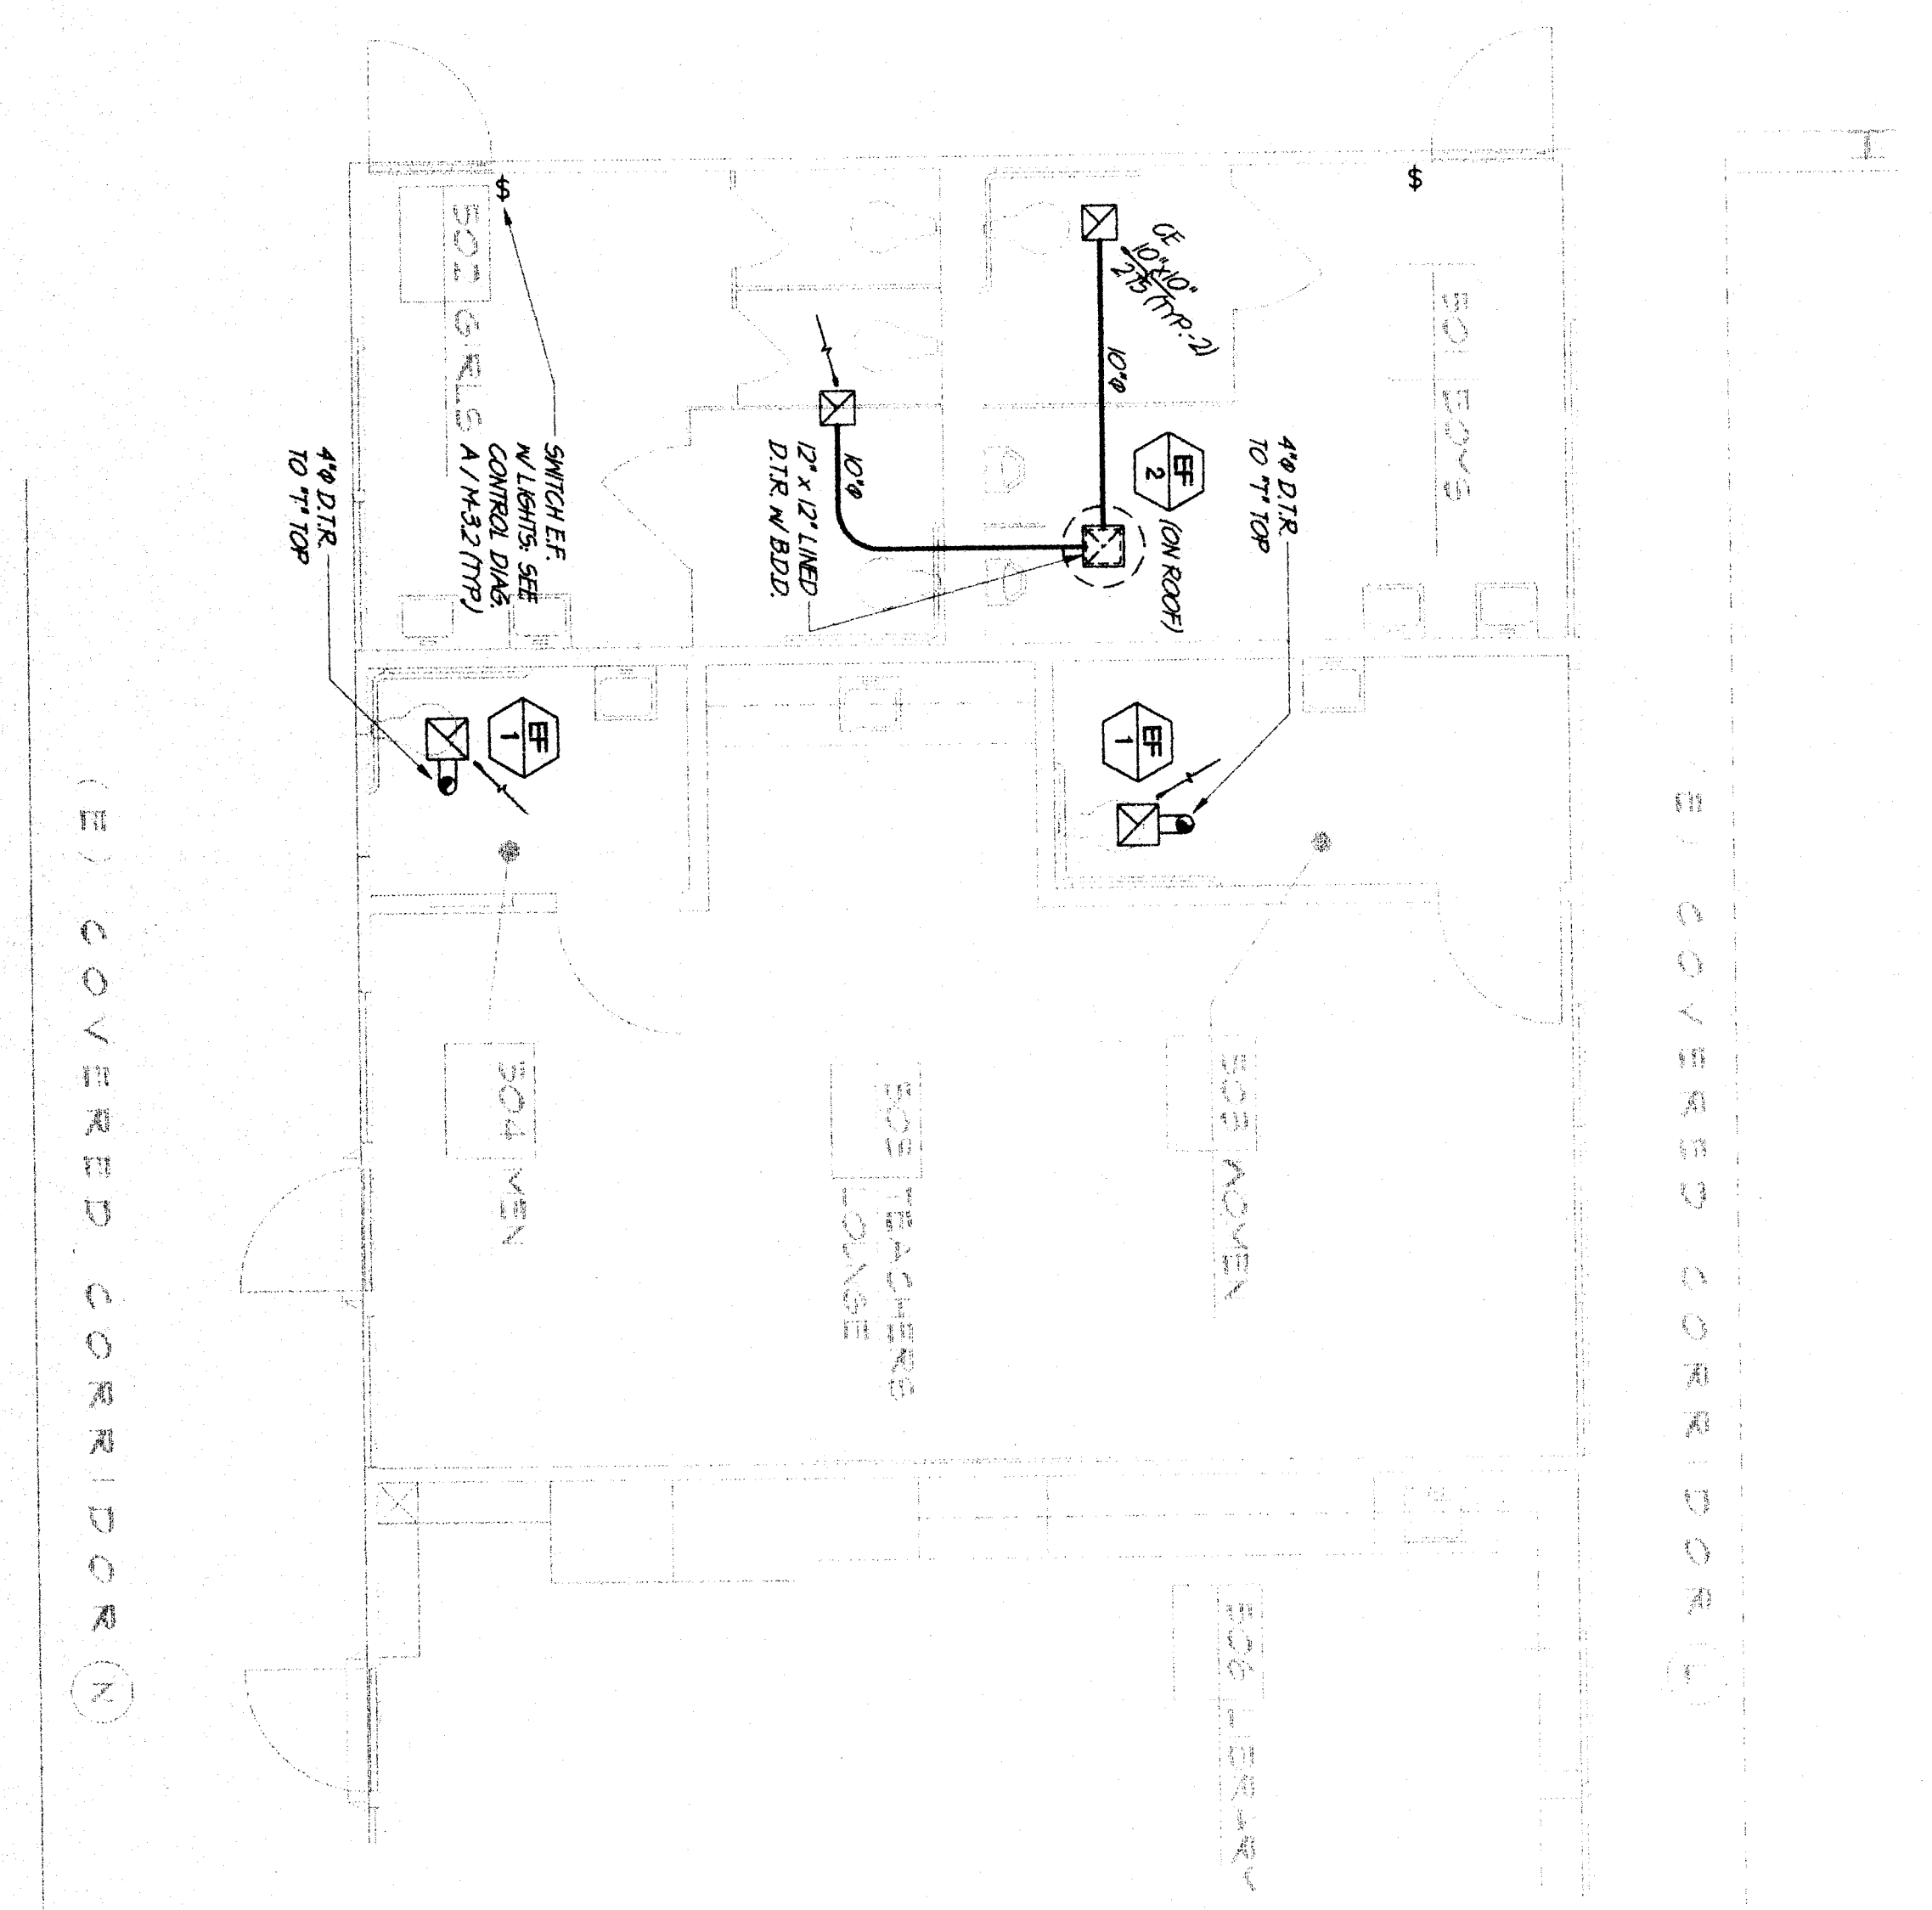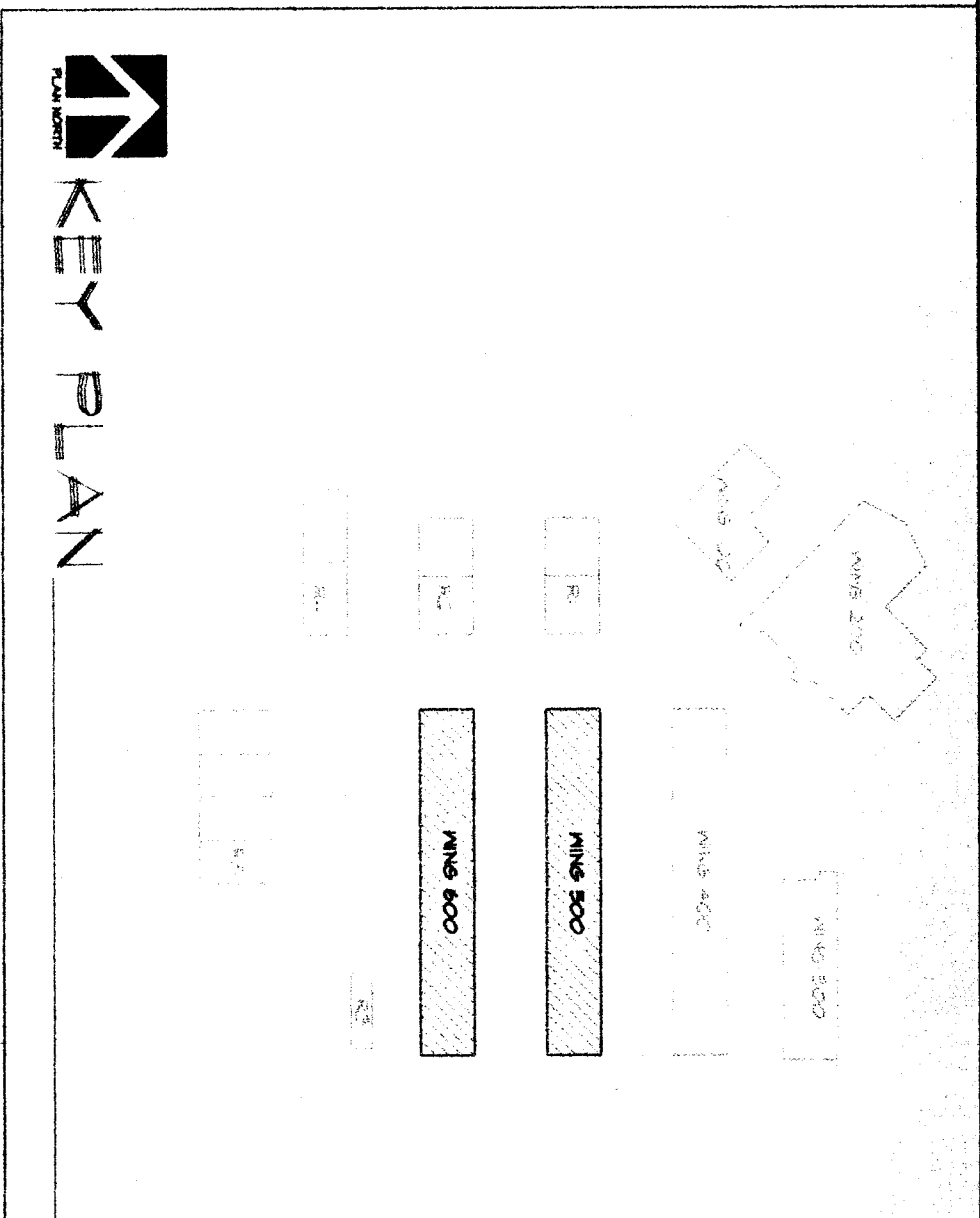


NORTH
SCALE 1/4"=1'-0"
MECHANICAL FLOOR PLAN (WING-500)

(B)

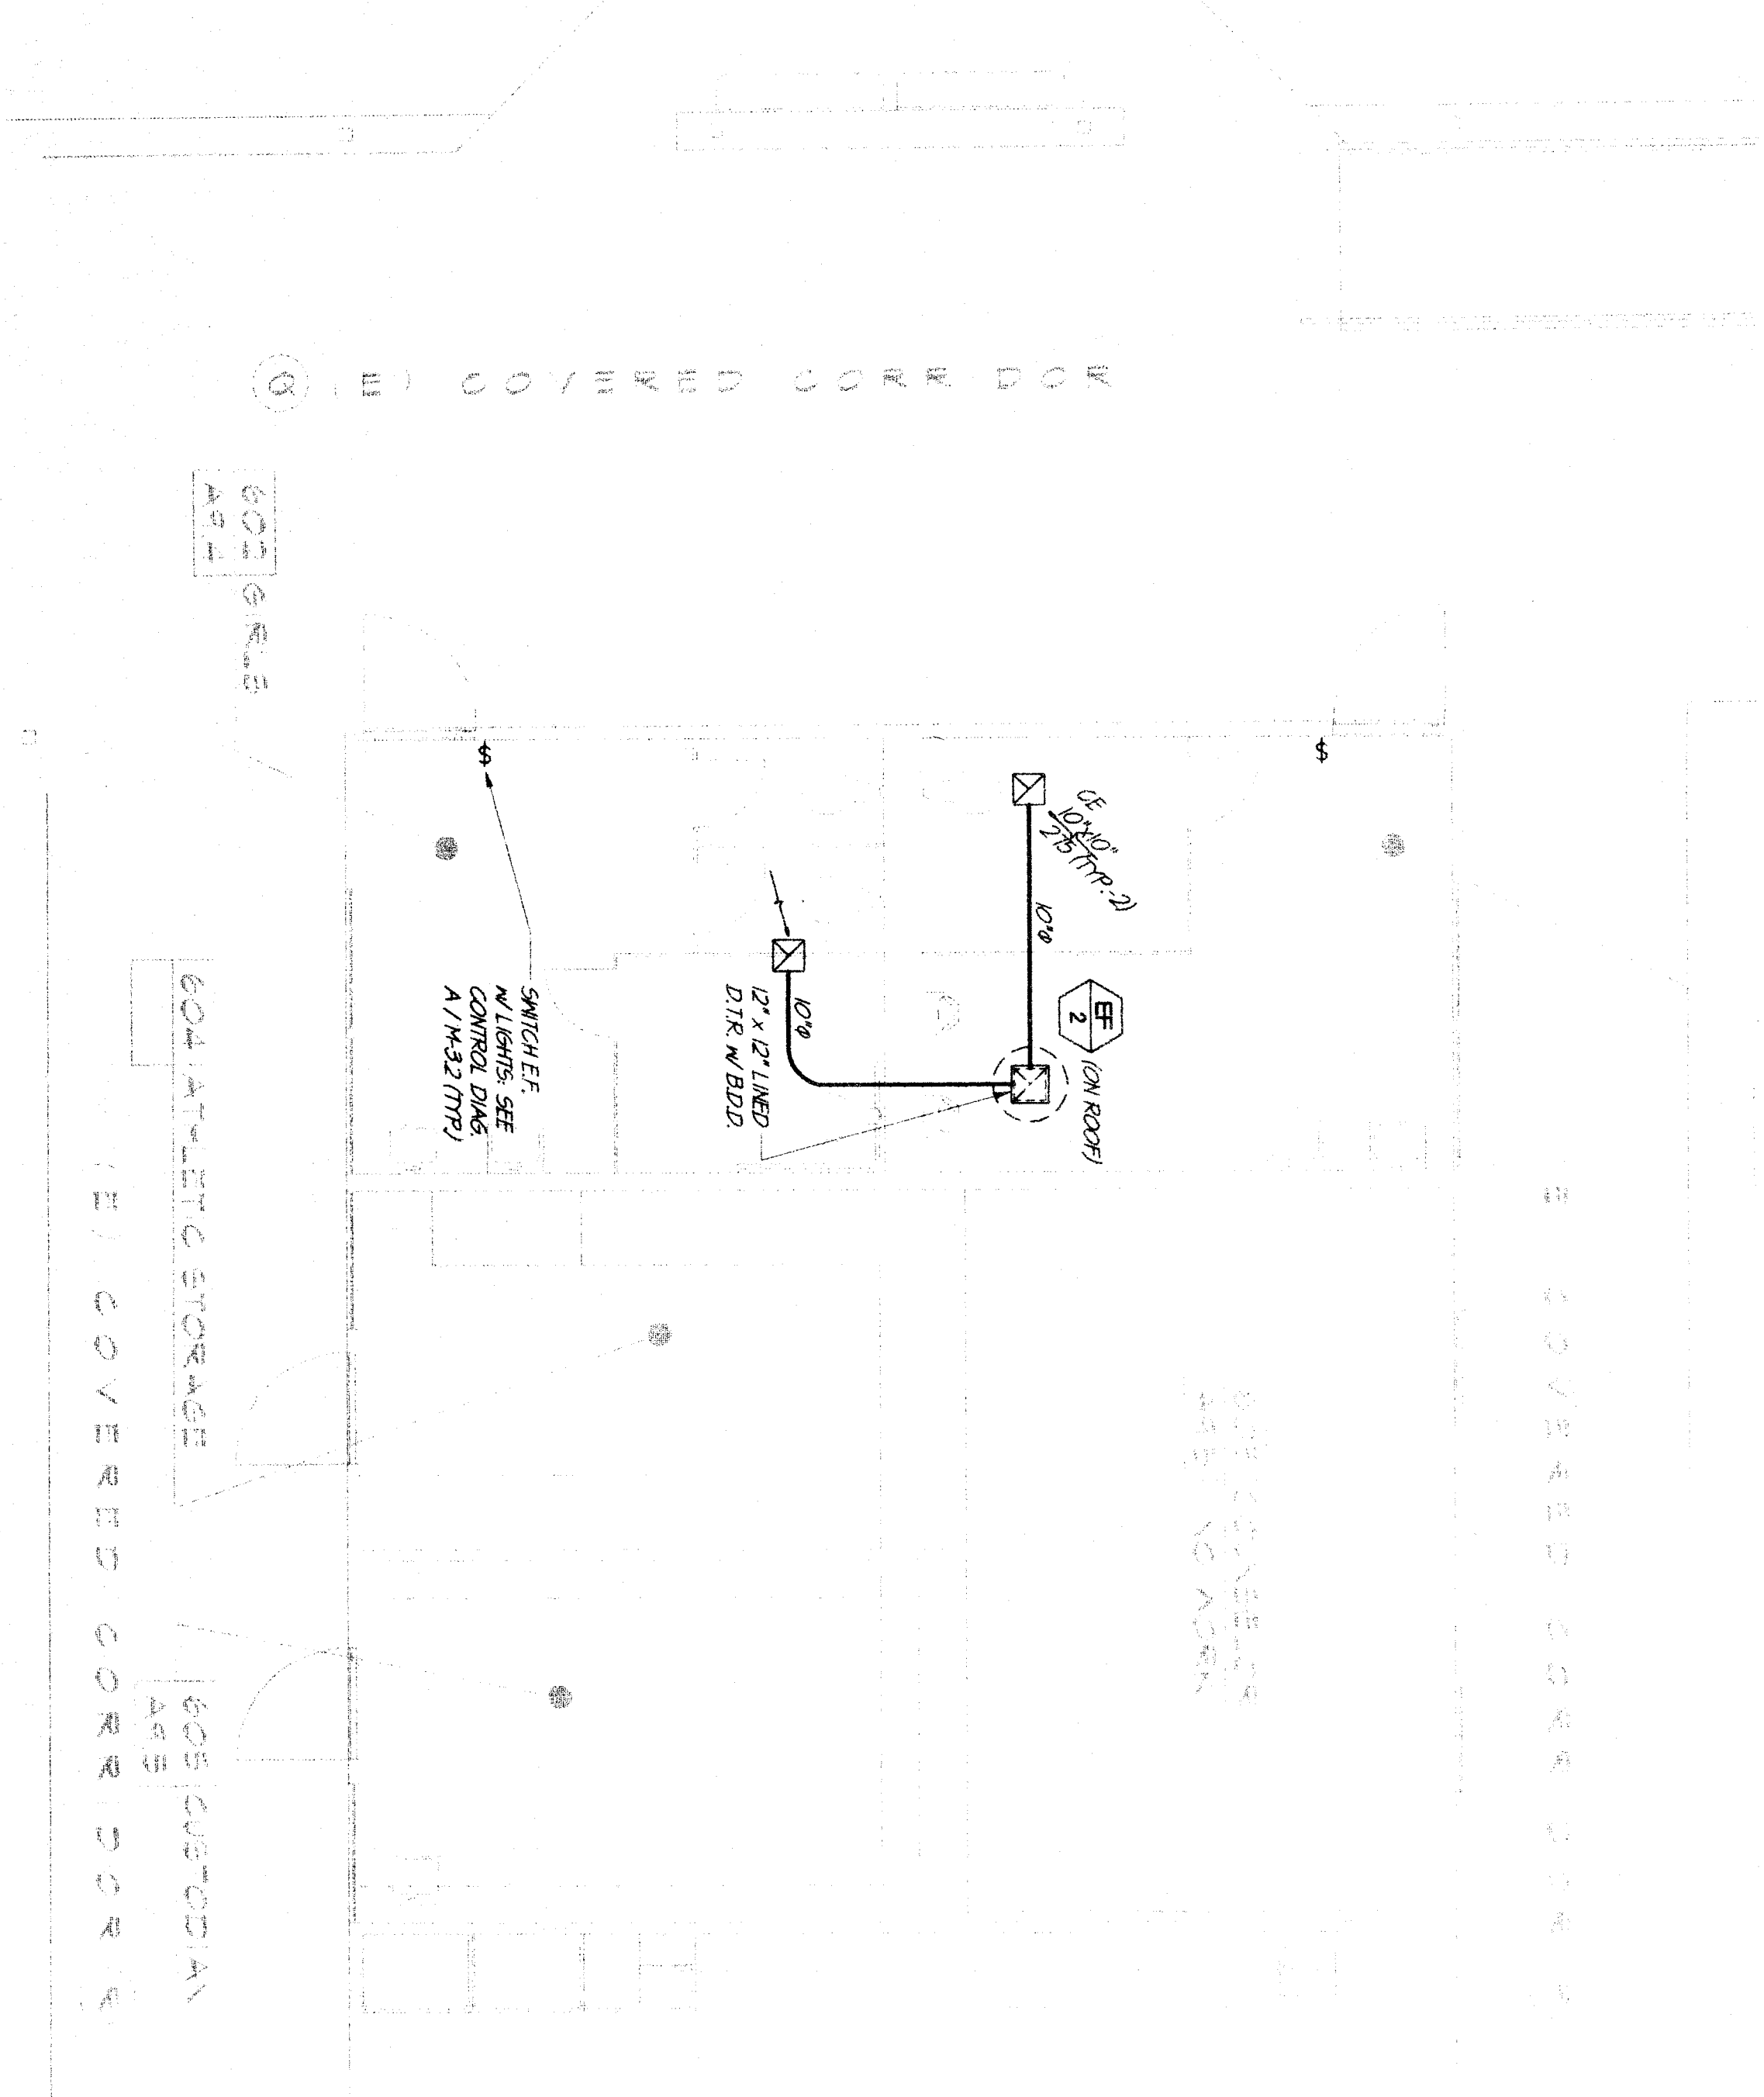

NORTH
SCALE 1/4"=1'-0"
MECHANICAL FLOOR PLAN (WING-600)

(D)

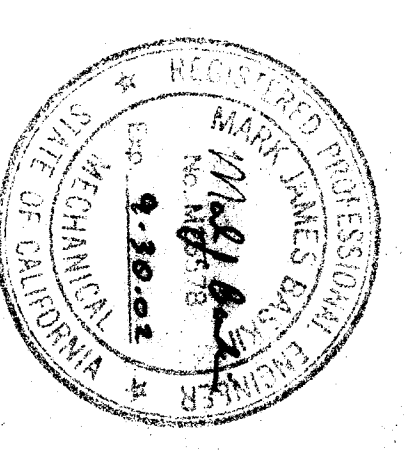

SCA
SCArchitect, Inc.
 1301 L Street
 Bakersfield, CA 93301
 (805) 327-1632

[Handwritten Signature]

#9906
MDC
 MECHANICAL DESIGN CONCEPTS
 1000 W. BROADWAY
 BAKERSFIELD, CA 93301
 TEL: 805-327-1632 FAX: 805-327-1632
 PLOTTED 4/21/99

REGISTRATION STAMP
 DIV. OF THE STATE ARCHITECTS
 OFFICIAL ARCHITECT
 LICENSE: DS-102164
 FILE: 15-9
 EXPIRES: 12/31/99
 NAME: RUTH HARDING SCHOOL

**RUTH HARDING SCHOOL
 MODERNIZATION**
 3201 PICO ST.
 FOR
 BAKERSFIELD CITY SCHOOL DISTRICT
 BAKERSFIELD, KERN COUNTY, CALIFORNIA

**WINGS - 500 / 600
 MECHANICAL,
 DEMOLITION,
 AND
 FLOOR PLAN**

CHECK AND VERIFY ALL DIMENSIONS
 BEFORE PROCEEDING WITH THE
 WORK. REPORT DISCREPANCIES
 TO THE ARCHITECT. ALL
 CONSTRUCTION SHALL CONFORM
 TO THE C.S.D.

MARK	DATE	REVISIONS
△		
△		
△		
△		
△		

JOB NO.
957
 DRAWN:
S.A.
 CHECKED:
DATE:
4/21/99

M
34
 5 OF 5 SHEETS