


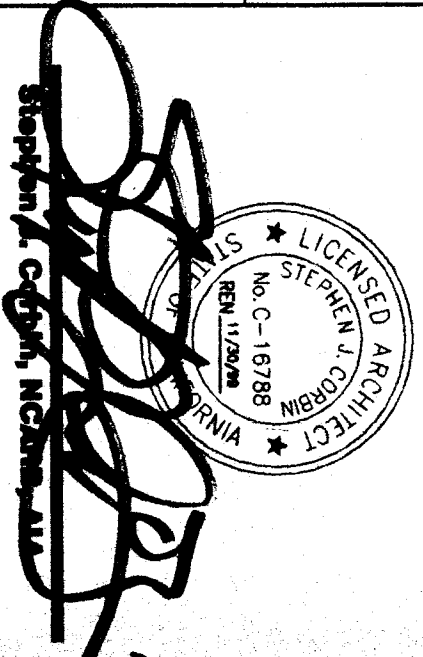

**SCA Architect, Inc.**  
 1301 L Street  
 Bakersfield, CA 93301  
 (805) 337-1632



**MDC**  
 #9906  
**MECHANICAL DESIGN CONCEPTS**  
 1500 S. BAKER STREET  
 BAKERSFIELD, CA 93301  
 TEL: 805.338.2200 FAX: 805.338.2200  
 PLOTTED 4/21/99

REGISTRATION STATE  
 DIV. OF THE STATE ARCHITECT  
 ARCHITECT  
 LICENSE NO. 156  
 EXPIRES 12/31/00  
 NAME: **STEPHEN A. CON**




**RUTH HARDING SCHOOL  
 MODERNIZATION**  
 3201 PICO ST.  
 FOR  
**BAKERSFIELD CITY SCHOOL DISTRICT**  
 BAKERSFIELD, KERN COUNTY, CALIFORNIA

**WING-100  
 PLUMBING  
 DEMOLITION  
 AND  
 FLOOR PLANS**

CHECK AND VERIFY ALL DIMENSIONS  
 BEFORE PROCEEDING WITH THE  
 WORK. REPORT DISCREPANCIES  
 TO THE ARCHITECT. ALL  
 CONSTRUCTION SHALL CONFORM  
 TO THE CBS.


MARK	DATE	REVISIONS
△		
△		
△		
△		

JOB NO.  
957  
 DRAWN BY  
P  
 CHECKED BY  
P  
 DATE  
3.0  
 2 OF 6 SHEETS

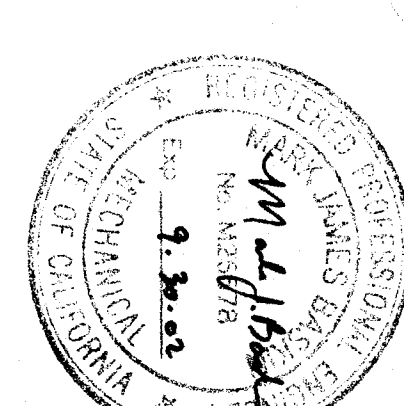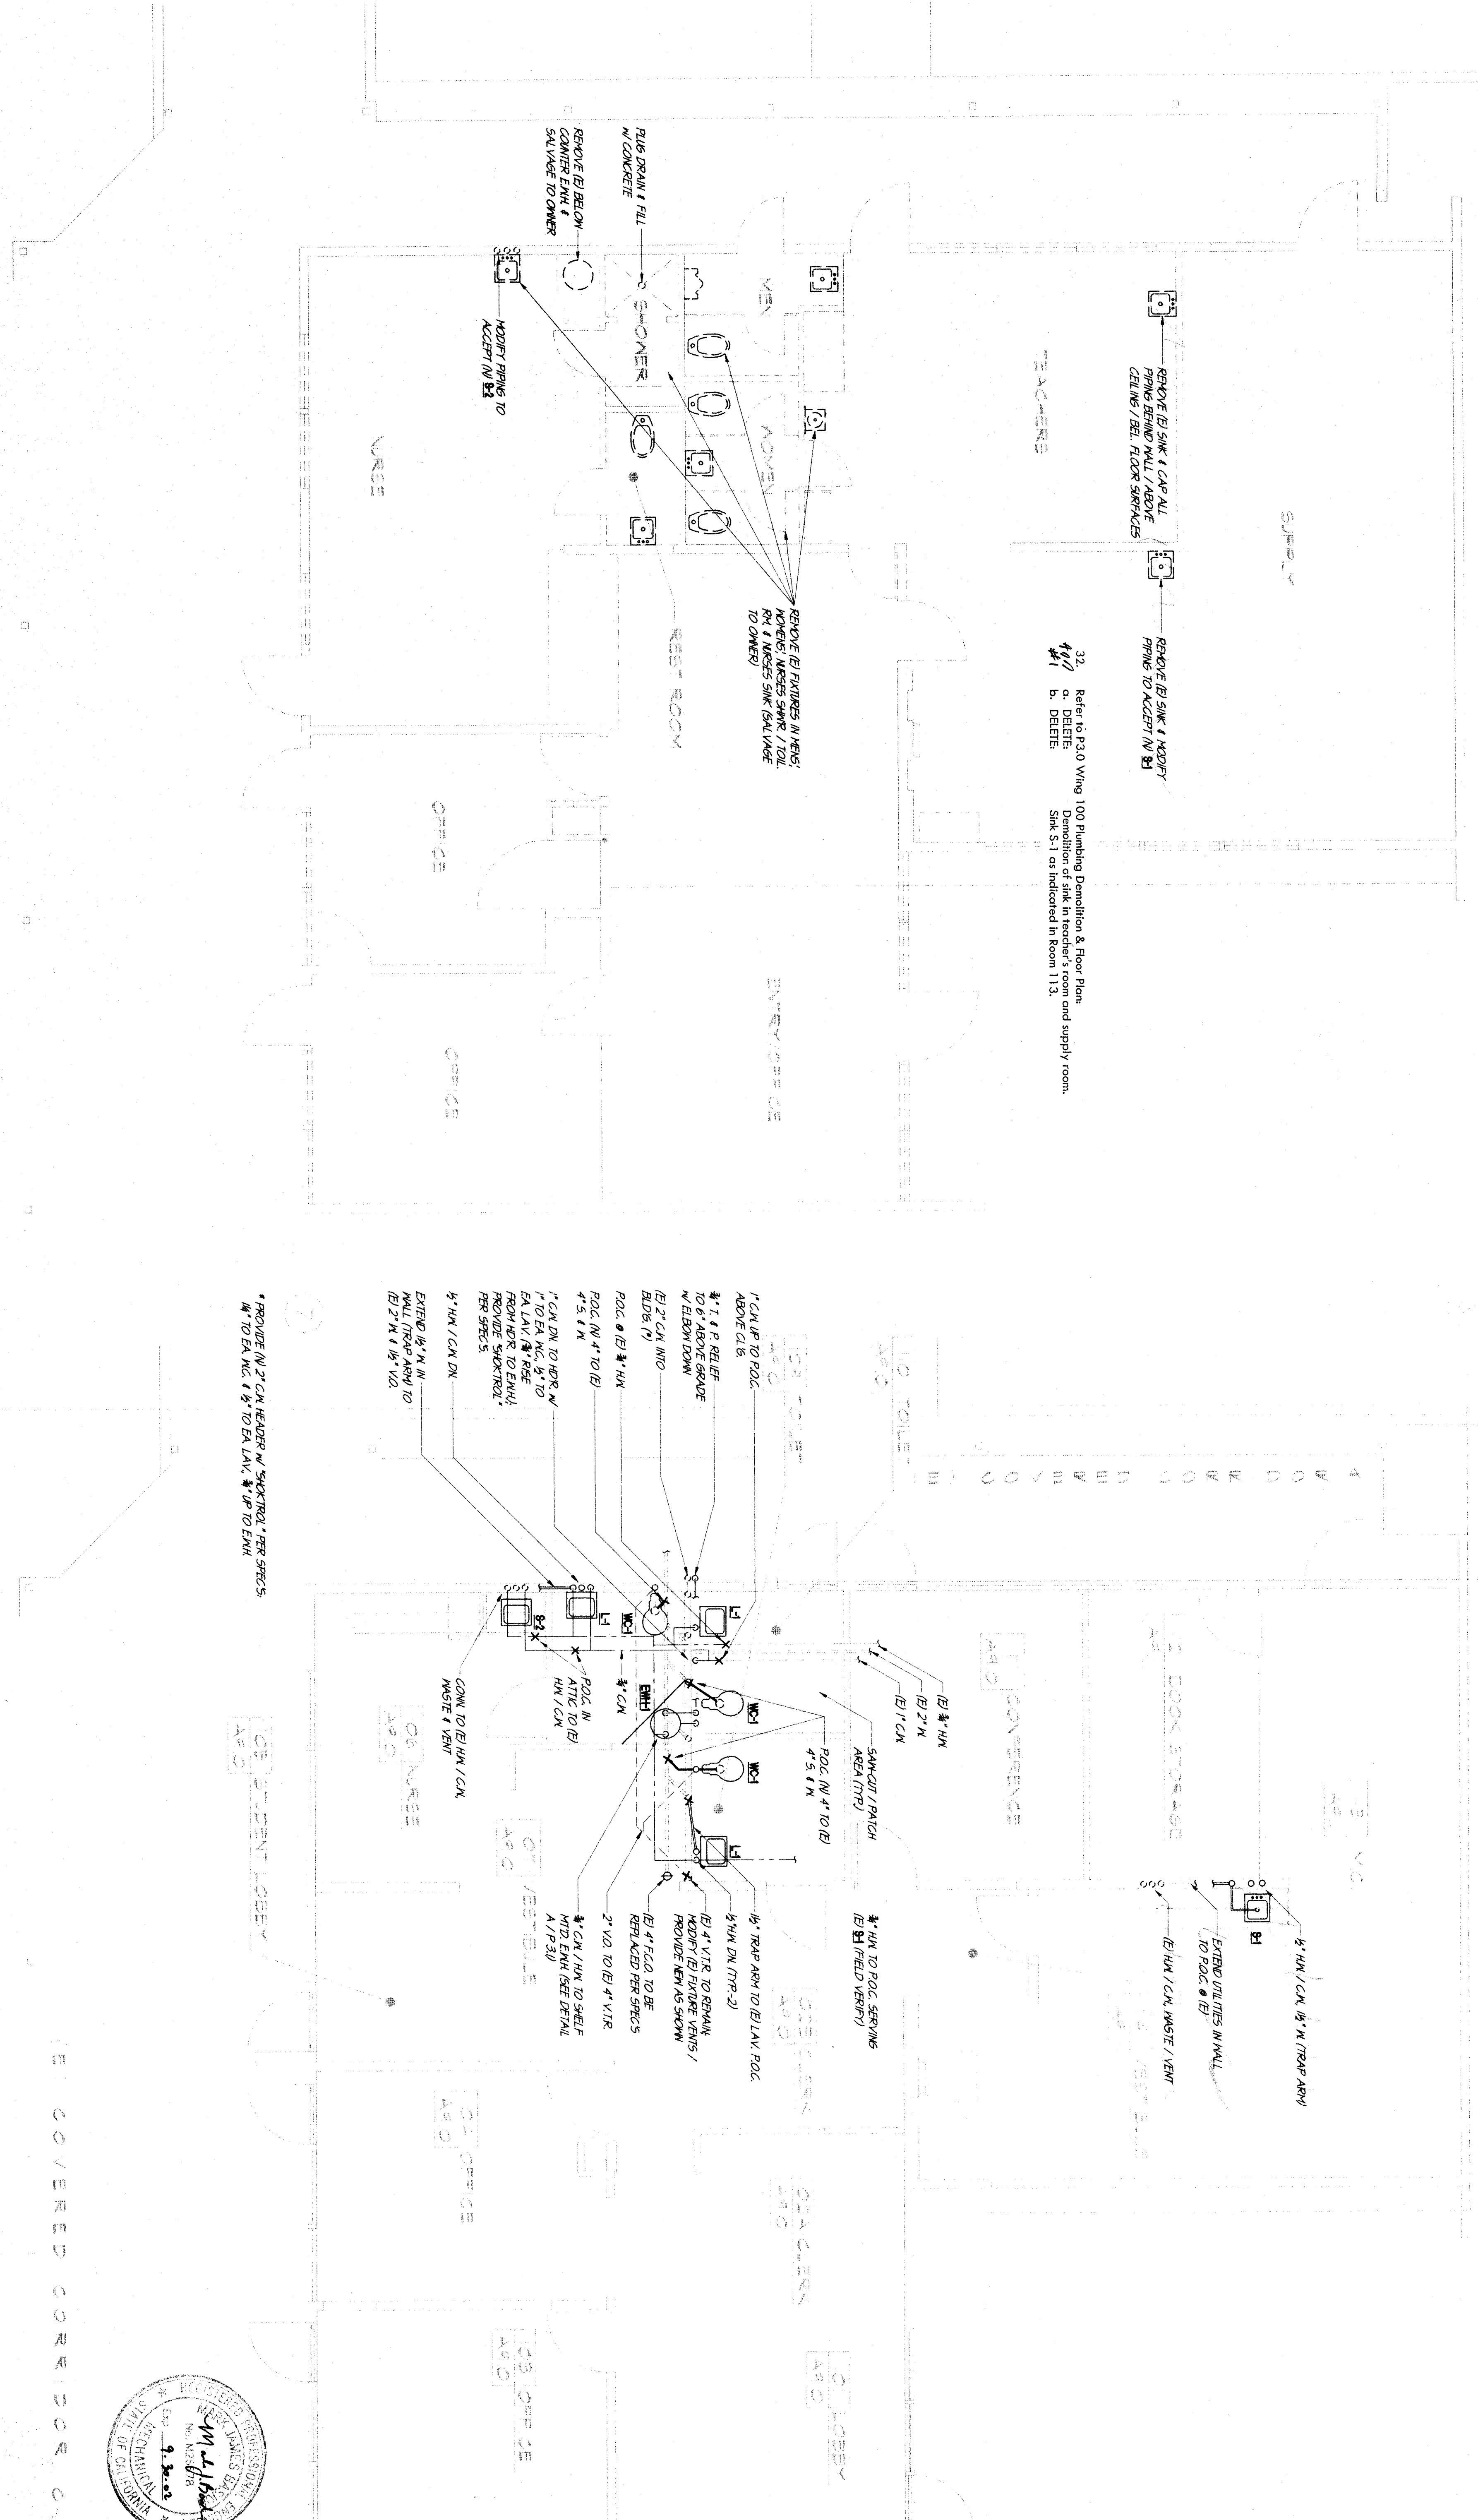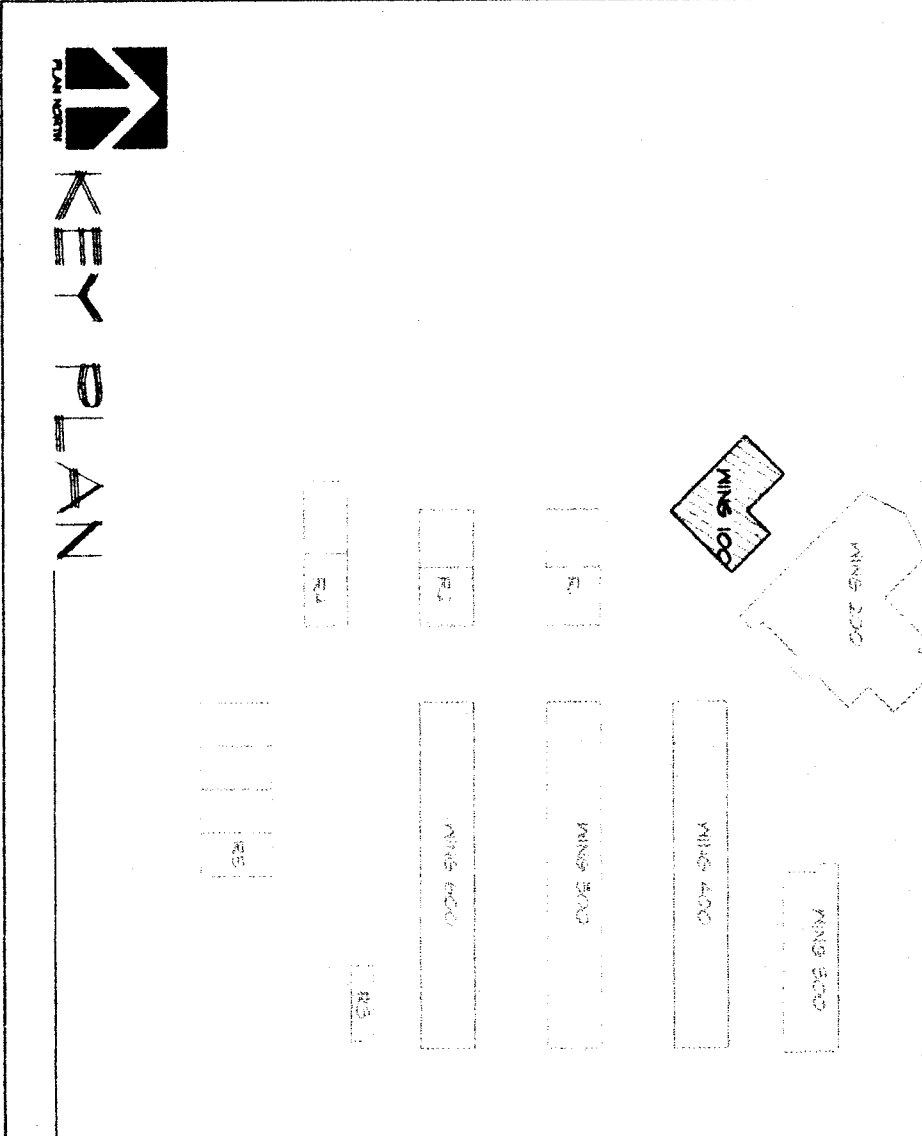

DEMO. PLUMBING PLAN (WING-100)  
 SCALE 1/4"=1'-0"

(A)

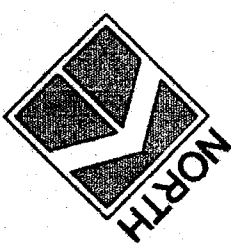

PLUMBING PLAN (WING-100)  
 SCALE 1/4"=1'-0"

(B)