




NORTH  
**DEMO PLUMBING PLAN (WING-300)**  
 SCALE 1/4"=1'-0"

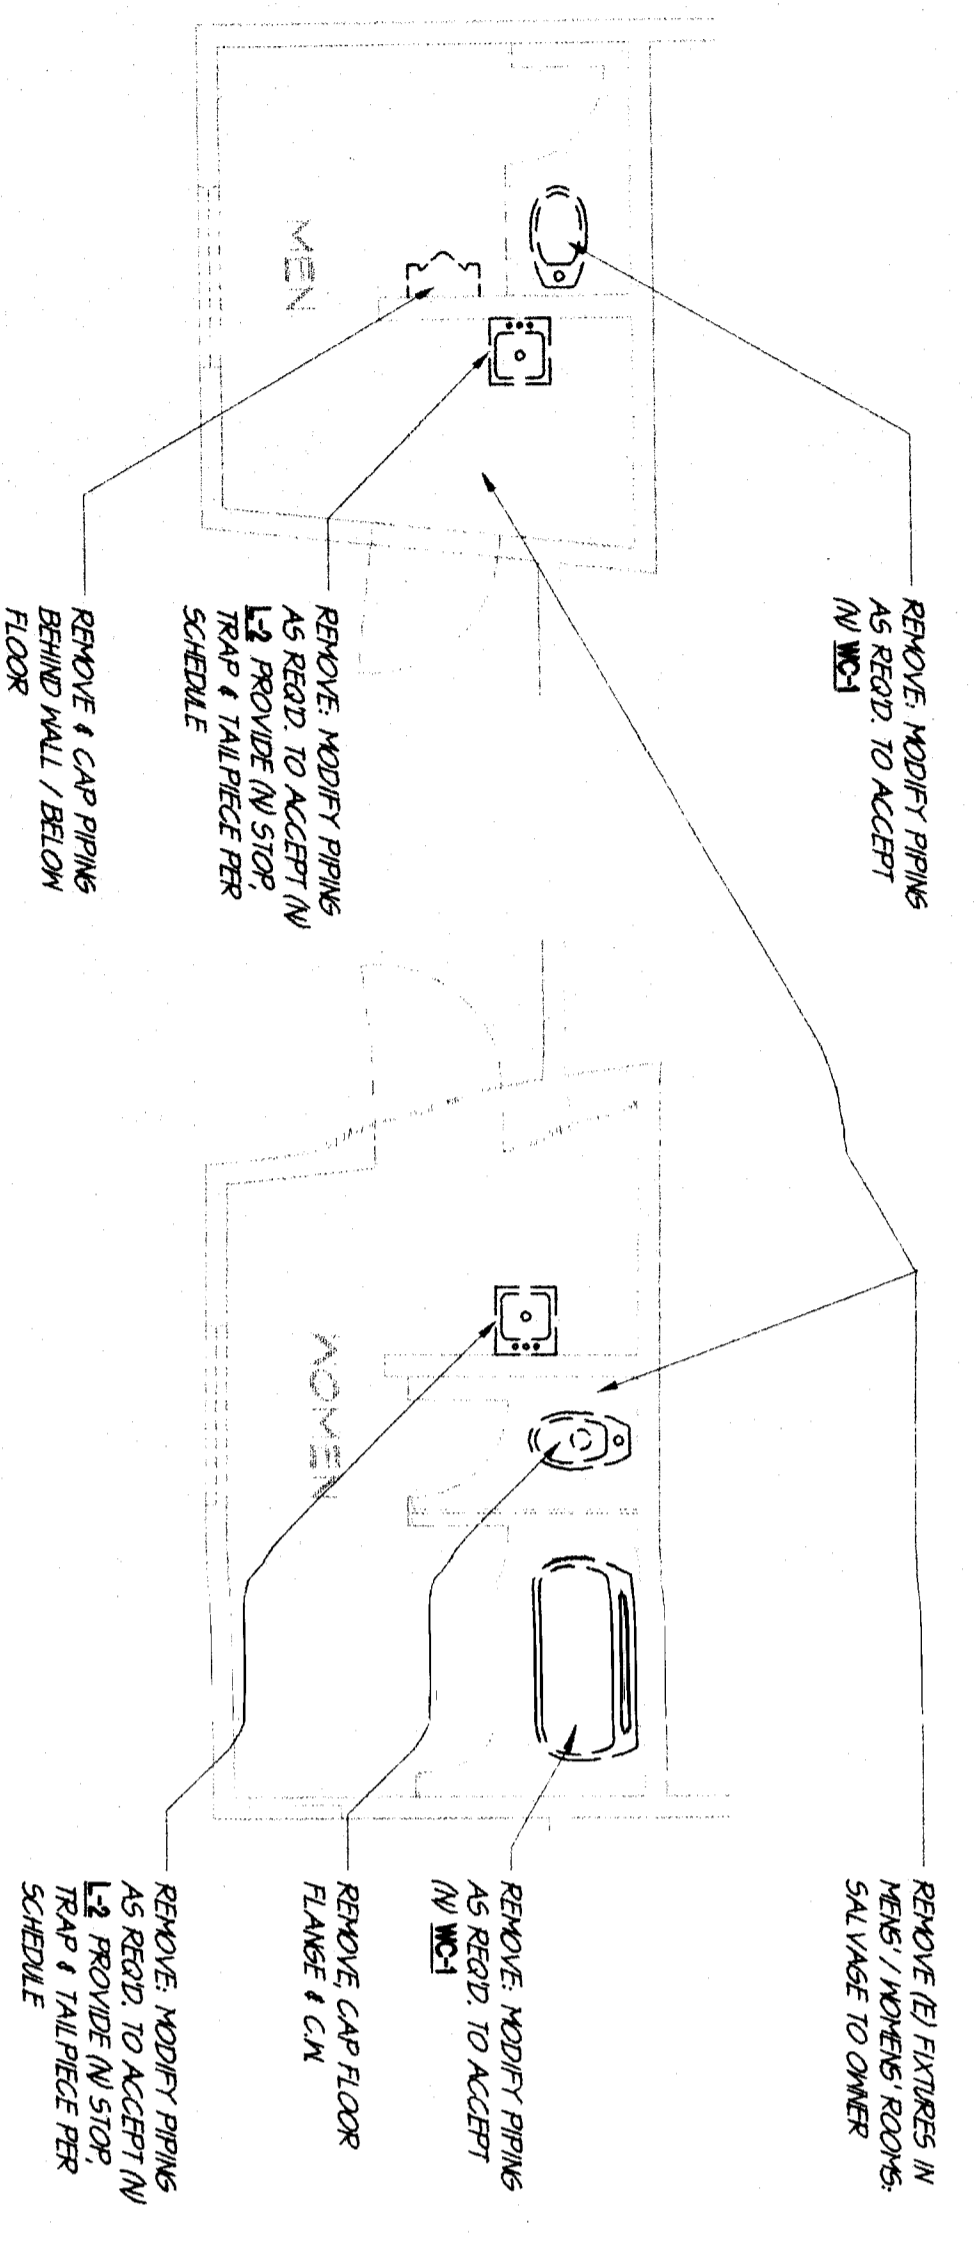

NORTH  
**DEMO PLUMBING PLAN (WING-200)**  
 SCALE 1/4"=1'-0"

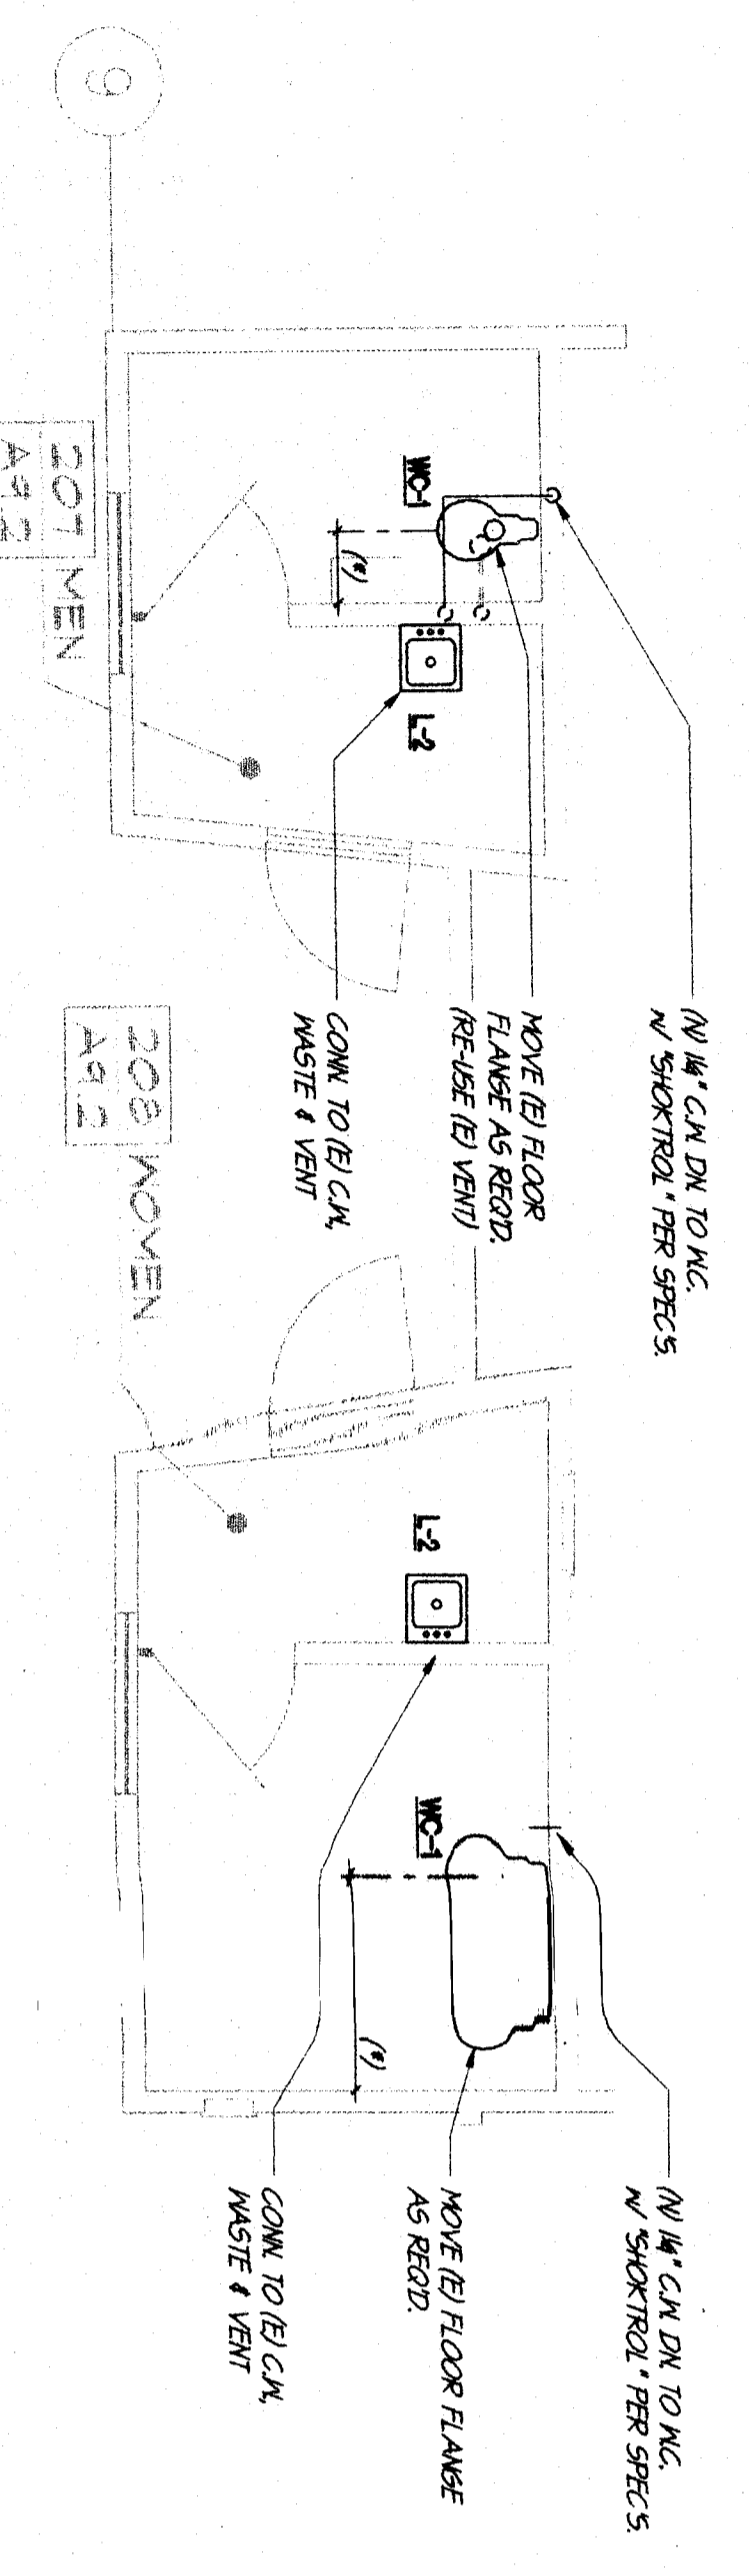

NORTH  
**PLUMBING PLAN (WING-200)**  
 SCALE 1/4"=1'-0"

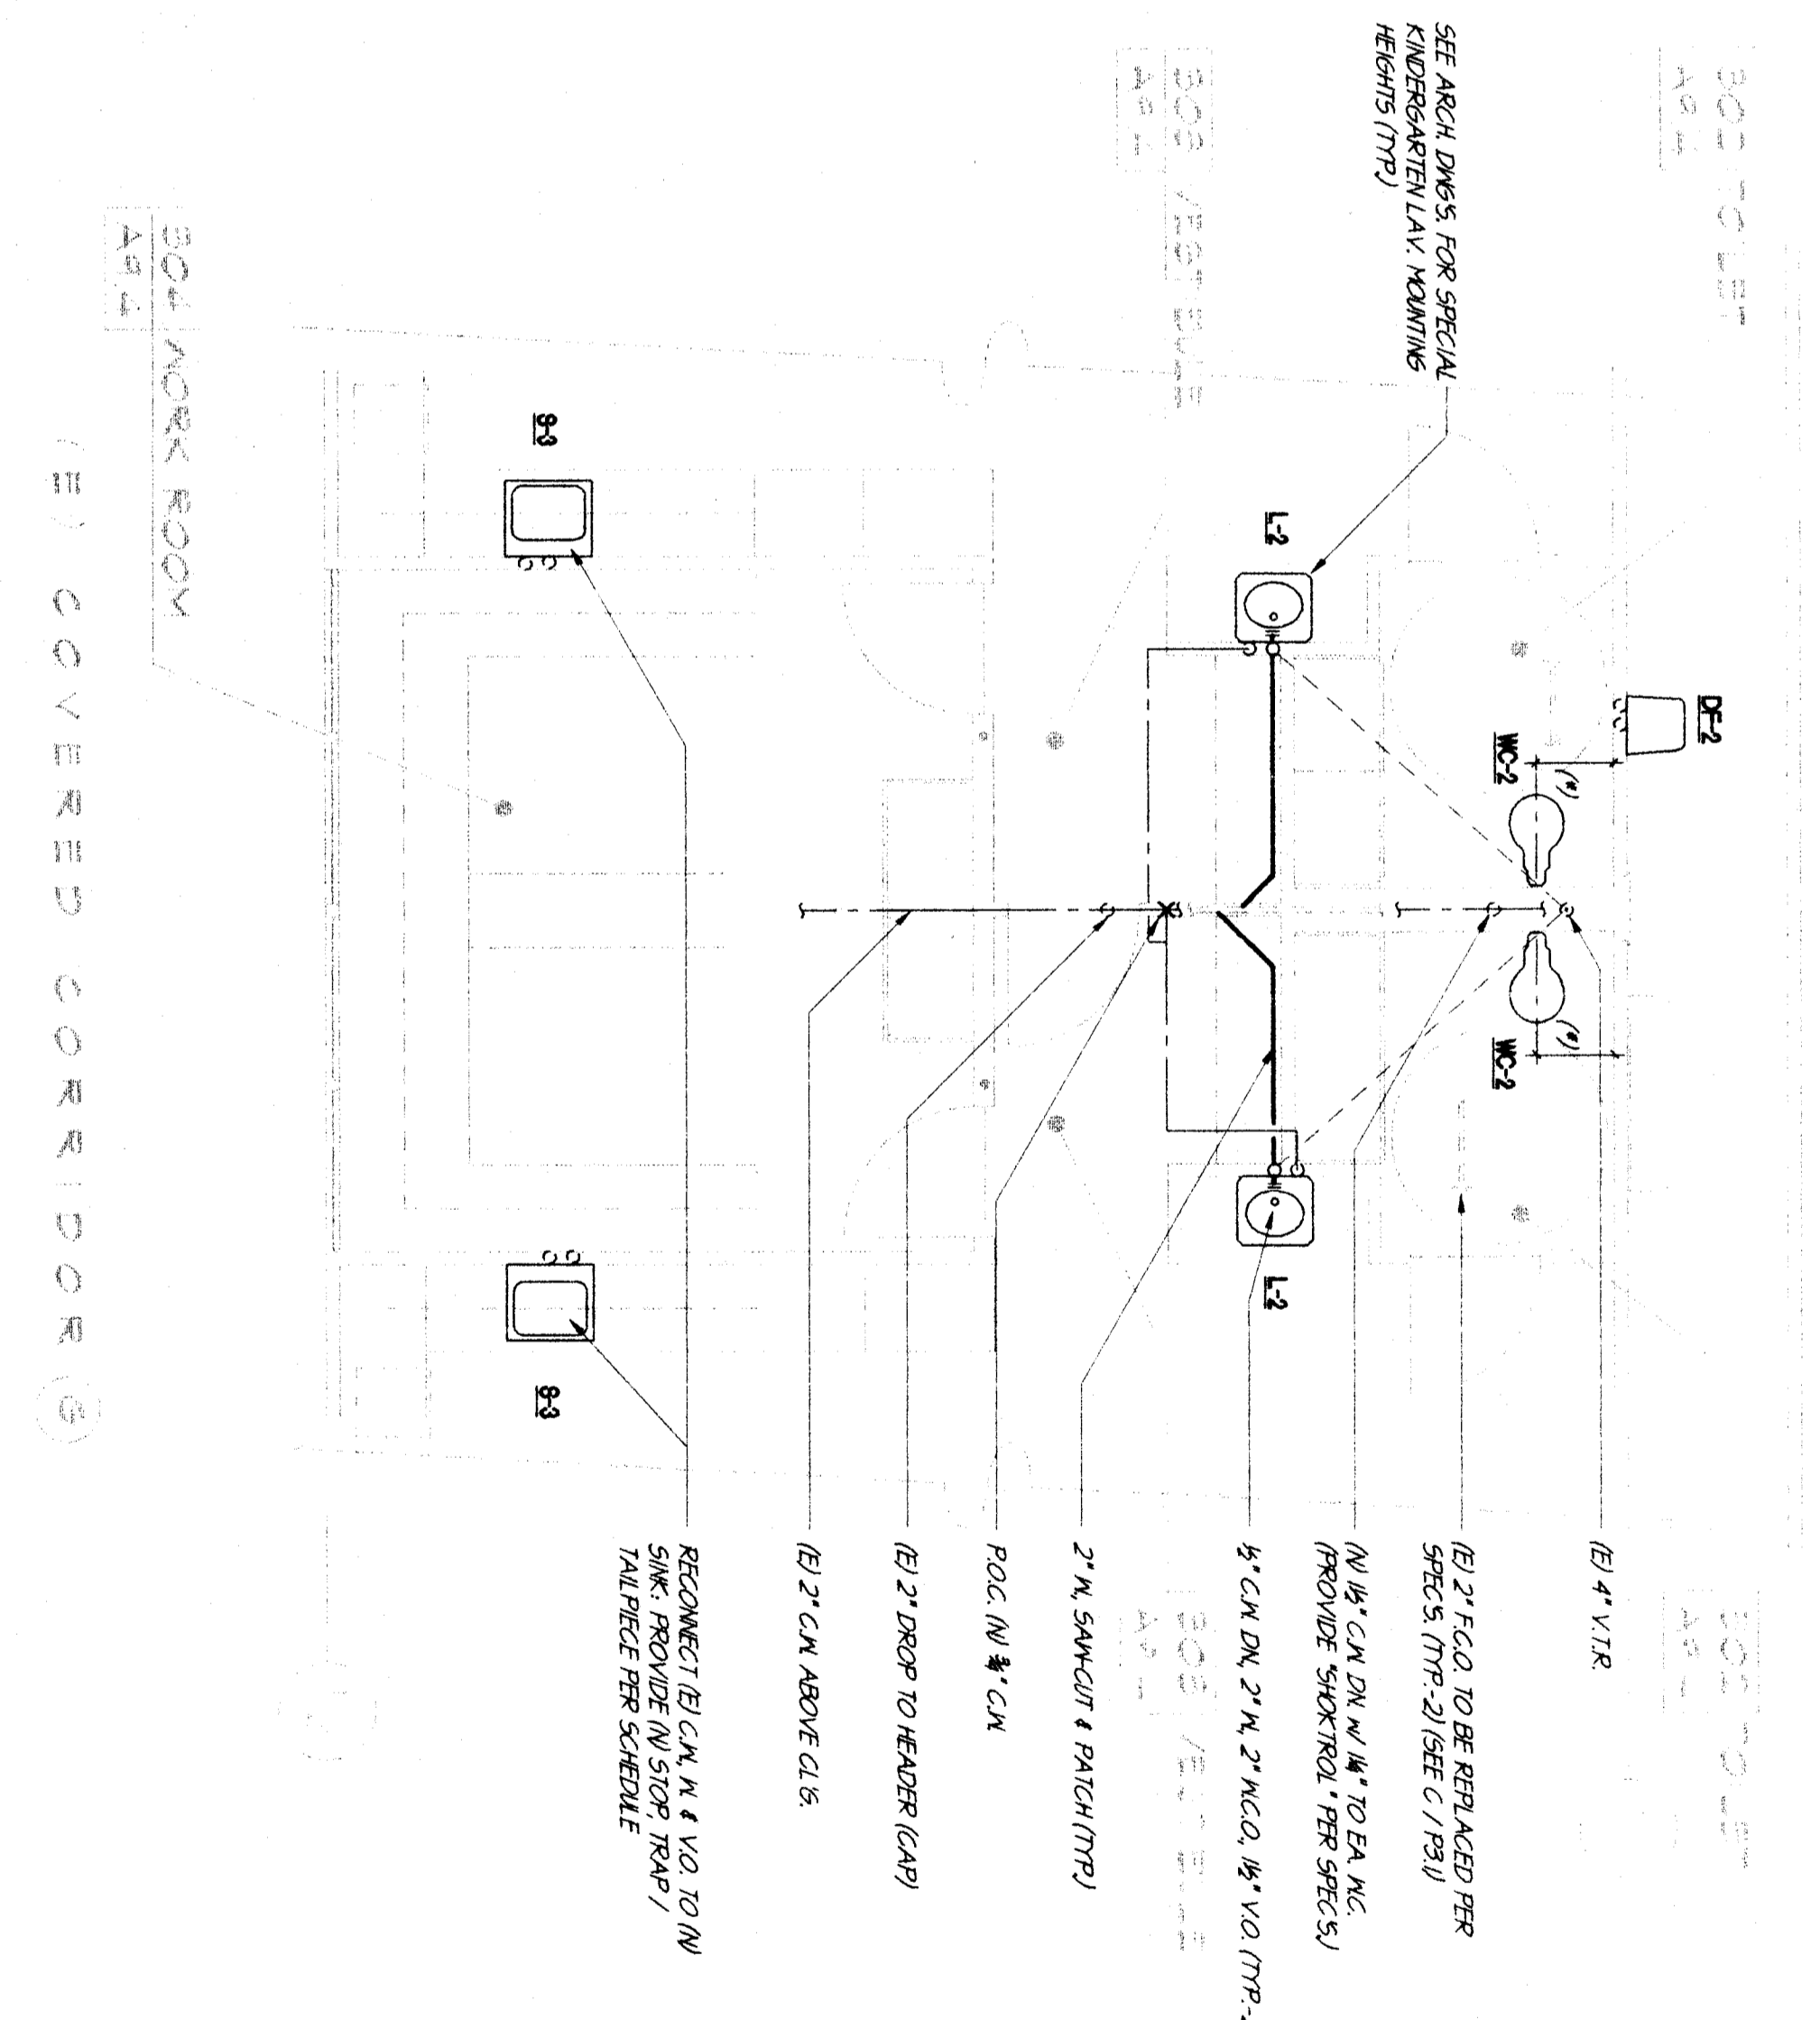

NORTH  
**PLUMBING PLAN (WING-300)**  
 SCALE 1/4"=1'-0"

**SCA**  
**Architect, Inc.**  
 1301 L Street  
 Bakersfield, CA 93301  
 (805) 327-1632



#906  
**MDC**  
**MECHANICAL DESIGN CONCEPTS**  
 MECHANICAL ENGINEERING SERVICES  
 247 North Avenue, Bakersfield, California 93301  
 PLOTTED 4/21/1999

GENERATION STAMP  
 DIV. OF REGULATION SERVICES  
 APR. 03 10:21:56  
 FILE 15-6  
 AC 22X 15X 15X  
 DATE: MAR 13 1999

**RUTH HARDING SCHOOL  
 MODERNIZATION**  
 3201 PICO ST.  
 FOR  
**BAKERSFIELD CITY SCHOOL DISTRICT**  
 BAKERSFIELD, KERN COUNTY, CALIFORNIA

**WINGS 200 / 300  
 PLUMBING  
 AND  
 DEMOLITION  
 FLOOR PLANS**

CHECK AND VERIFY ALL DIMENSIONS  
 BEFORE PROCEEDING WITH THE  
 WORK. REPORT DISCREPANCIES  
 IMMEDIATELY TO THE ARCHITECT.  
 CONTRACTOR SHALL CONFORM  
 TO THE C.E.C.

MARK	DATE	REVISIONS
△		
△		
△		
△		

JOB NO. 957  
 DRAWN: S.A.  
 CHECKED:  
 DATE: 4/21/99  
**P**  
**3.2**  
 4 OF 6 SHEETS

