



NORTH
DEMO. PLUMBING PLAN (WING-500)
 SCALE 1/4"=1'-0"

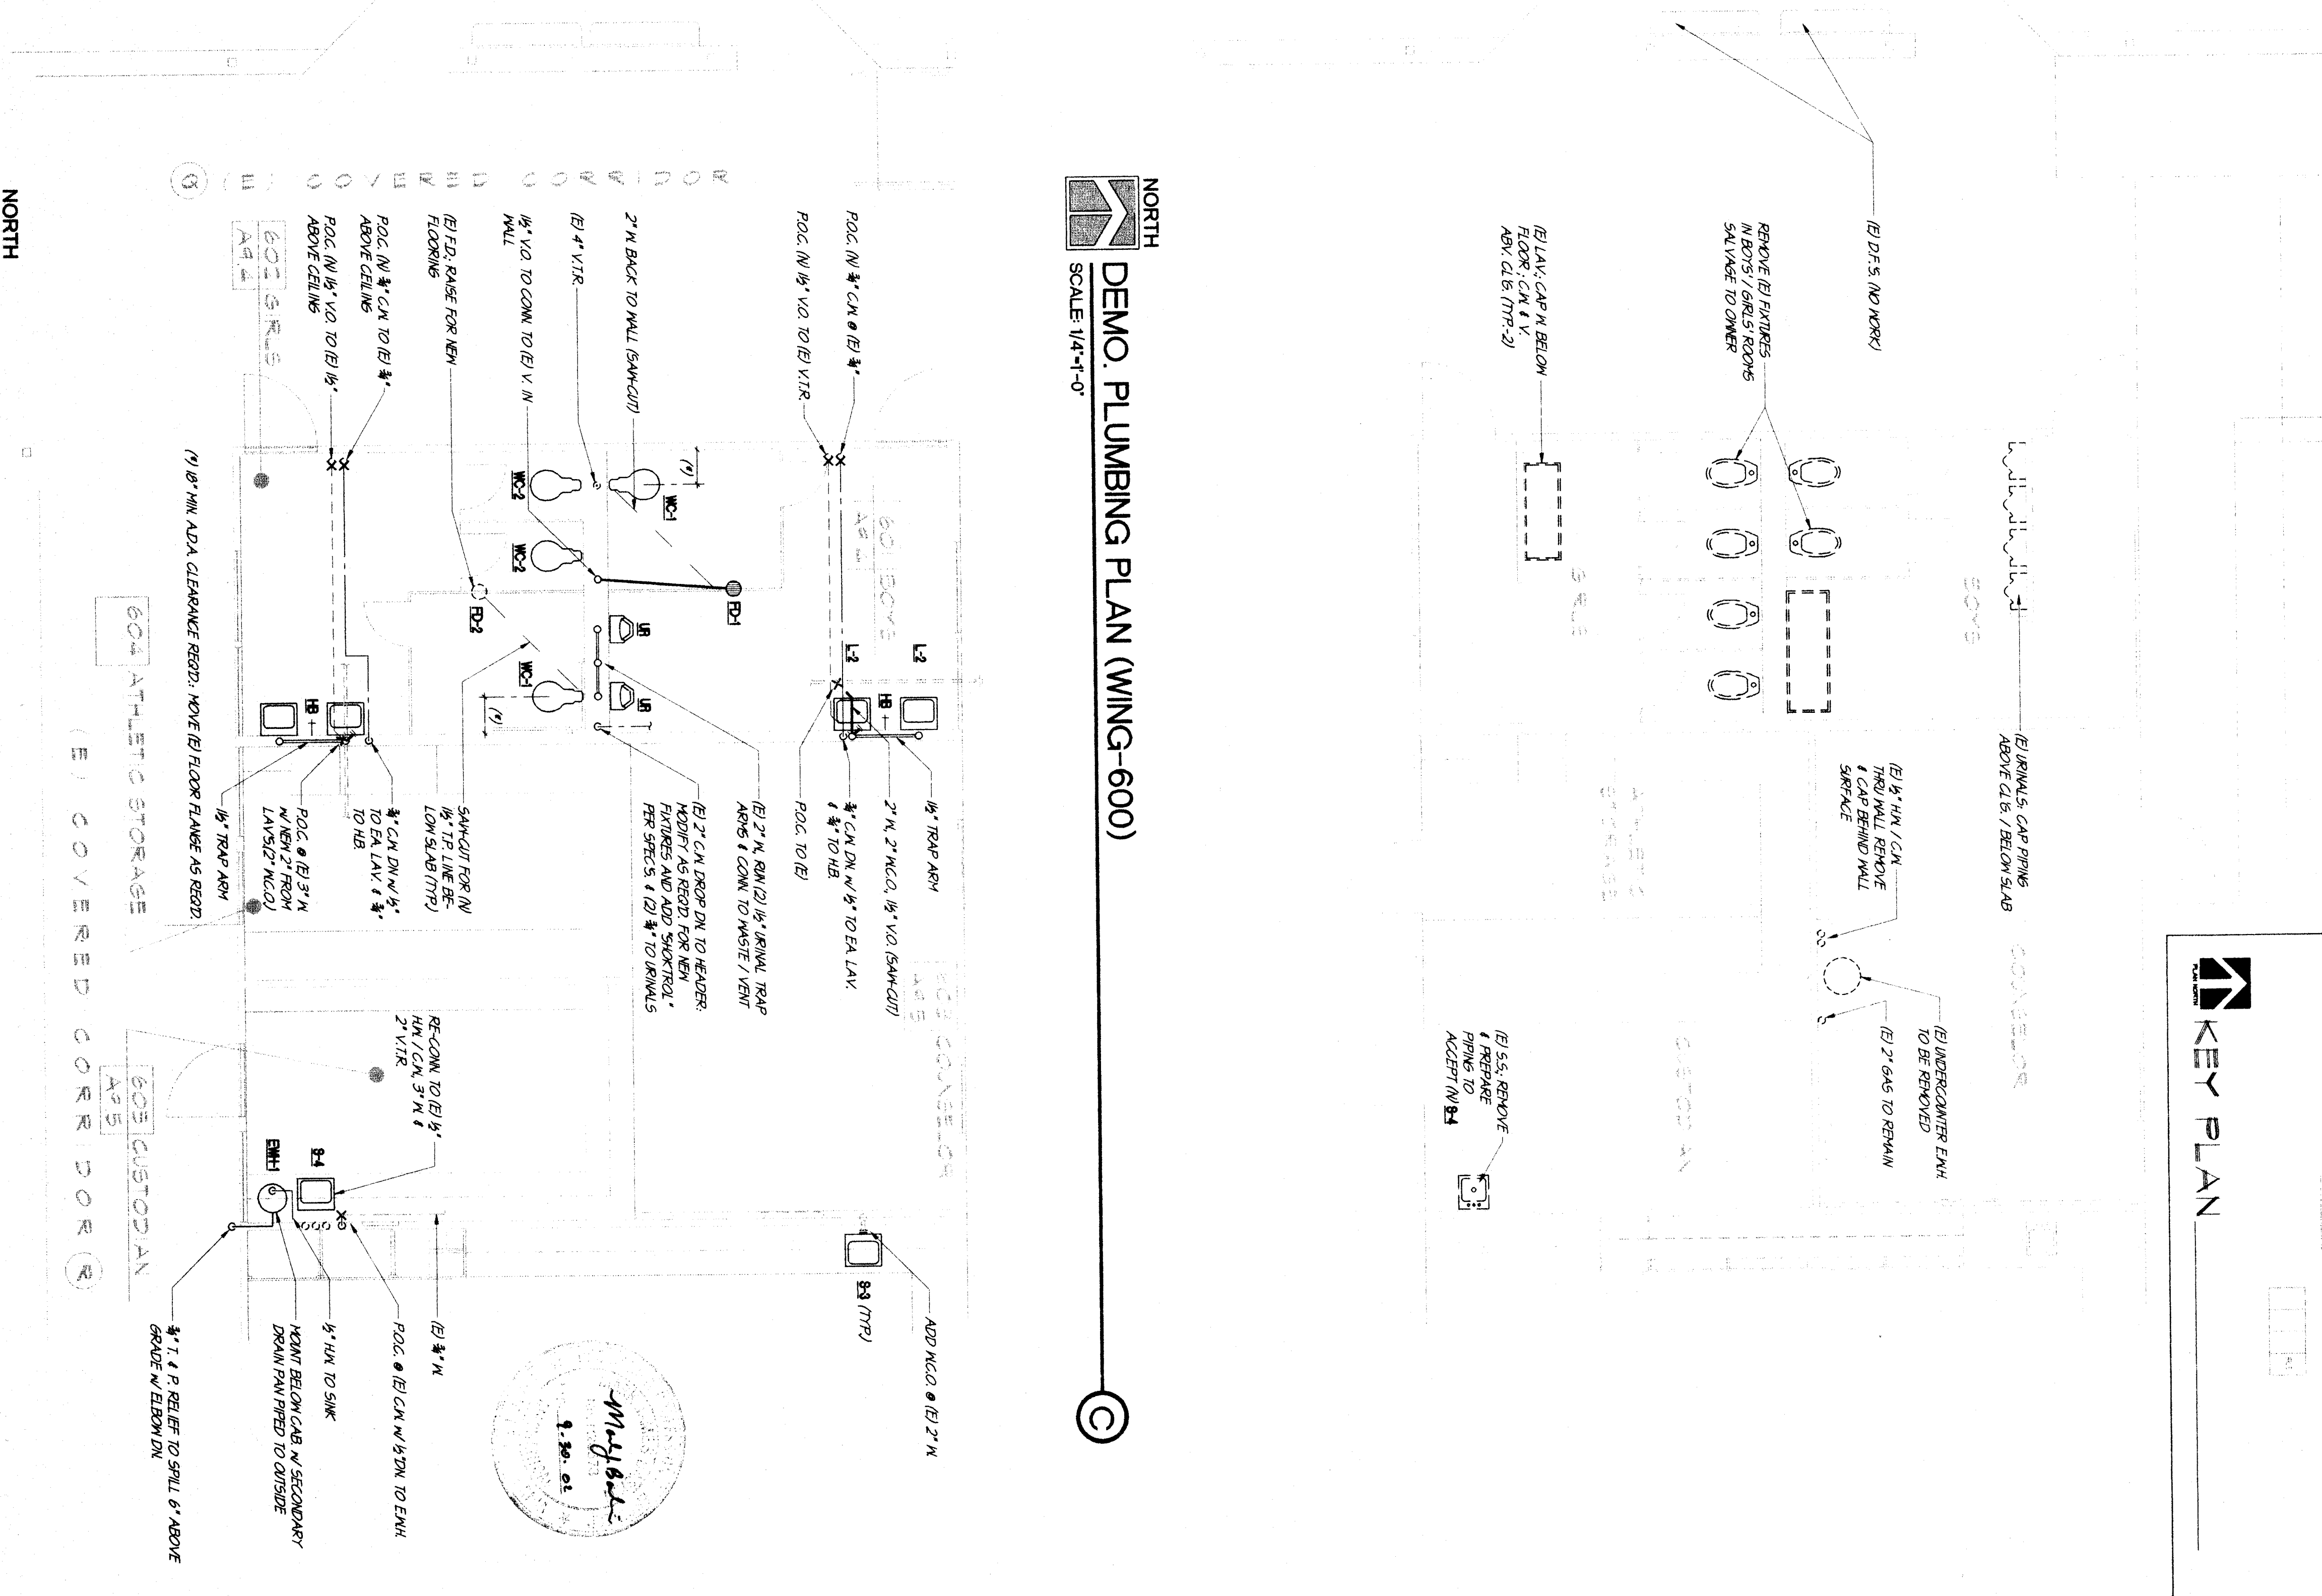

NORTH
DEMO. PLUMBING PLAN (WING-600)
 SCALE 1/4"=1'-0"

KEY PLAN

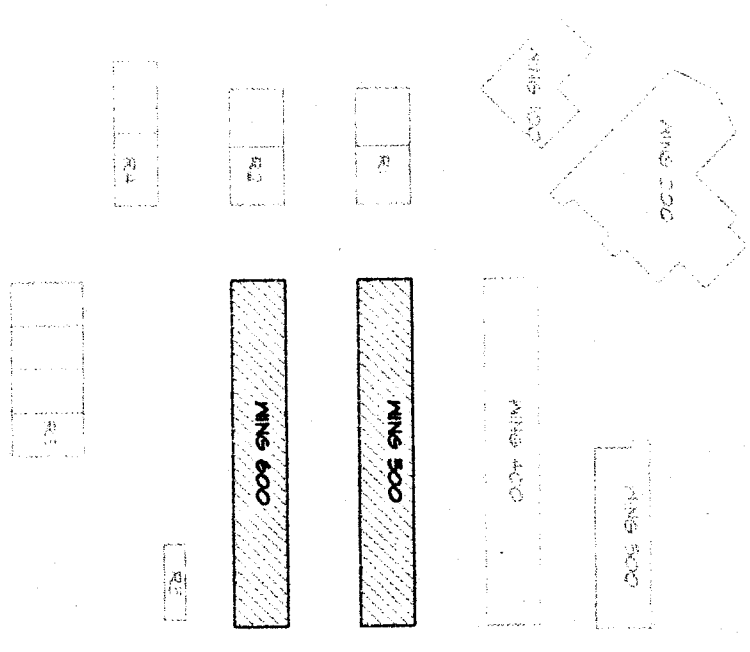

SCArlitect Inc.
 1301 L Street
 Bakersfield, CA 93301
 (805) 327-1622

MDC
 MECHANICAL DESIGN CONCERNS
 MECHANICAL ENGINEERING SERVICES
 49906
 PLOTTED 4/21/99

REGISTRATION BOARD
 DIV. OF THE STATE ARCHITECT
 OFFICE OF REGULATION SERVICES
 APR. 03 1031 156
 FILE 15-6
 DATE 4/23/99

**RUTH HARDING SCHOOL
 MODERNIZATION**
 3201 PICO ST.
 FOR
BAKERSFIELD CITY SCHOOL DISTRICT
 BAKERSFIELD, KERN COUNTY, CALIFORNIA

**WINGS- 500 / 600
 PLUMBING
 DEMOLITION
 AND
 FLOOR PLANS**

CHECK AND VERIFY ALL DIMENSIONS
 WORK REPORT DISCREPANCIES
 TO THE ARCHITECT. ALL
 CONSTRUCTION SHALL CONFORM
 TO THE C.B.S.

MARK	DATE	REVISIONS
△		
△		
△		
△		

JOB NO.
 957
 DRAWN:
 3.4
 CHECKED:
 DATE:
 6 OF 6 SHEETS