


SCA Architect, Inc.
 1301 L Street
 Bakersfield, CA 93301
 (805) 227-1832

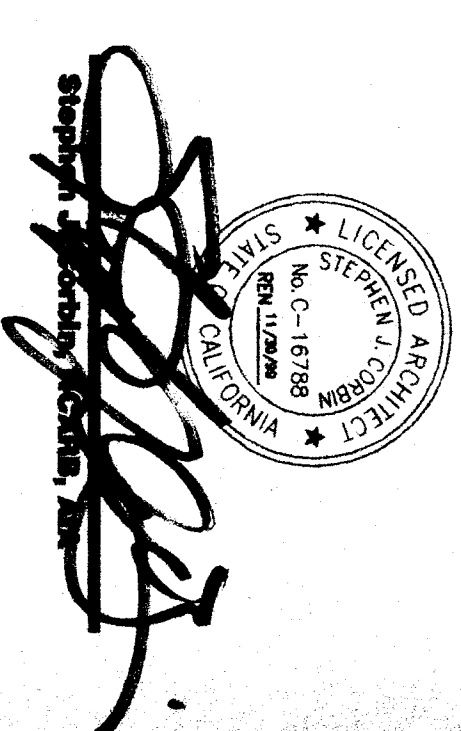

49306
MDC
 MECHANICAL DESIGN CONCEPTS
 MECHANICAL ENGINEERING SERVICES
 11000 BROADWAY, SUITE 200
 BAKERSFIELD, CALIFORNIA 93311
 PLOTTED 4/21/99






REGISTRATION STATE
 DIV. OF THE STATE ARCHITECT
 OFFICE OF REGULATION SERVICES
 FILE 15-6
 APR 03 10 21 54
 DATE 4/21/99

**RUTH HARDING SCHOOL
 MODERNIZATION**
 3201 PICO ST.
 FOR
BAKERSFIELD CITY SCHOOL DISTRICT
 BAKERSFIELD, KERN COUNTY, CALIFORNIA

**WING-100
 MECHANICAL
 DEMOLITION
 AND
 FLOOR PLANS**

CHECK AND VERIFY ALL DIMENSIONS
 WORK REPORT DISCREPANCIES
 TO THE ARCHITECT. ALL
 CONSTRUCTION SHALL CONFORM
 TO THE C.A.B.

MARK	DATE	REVISIONS

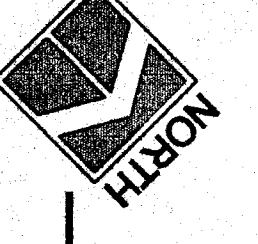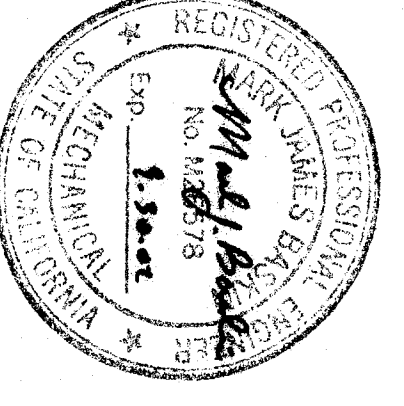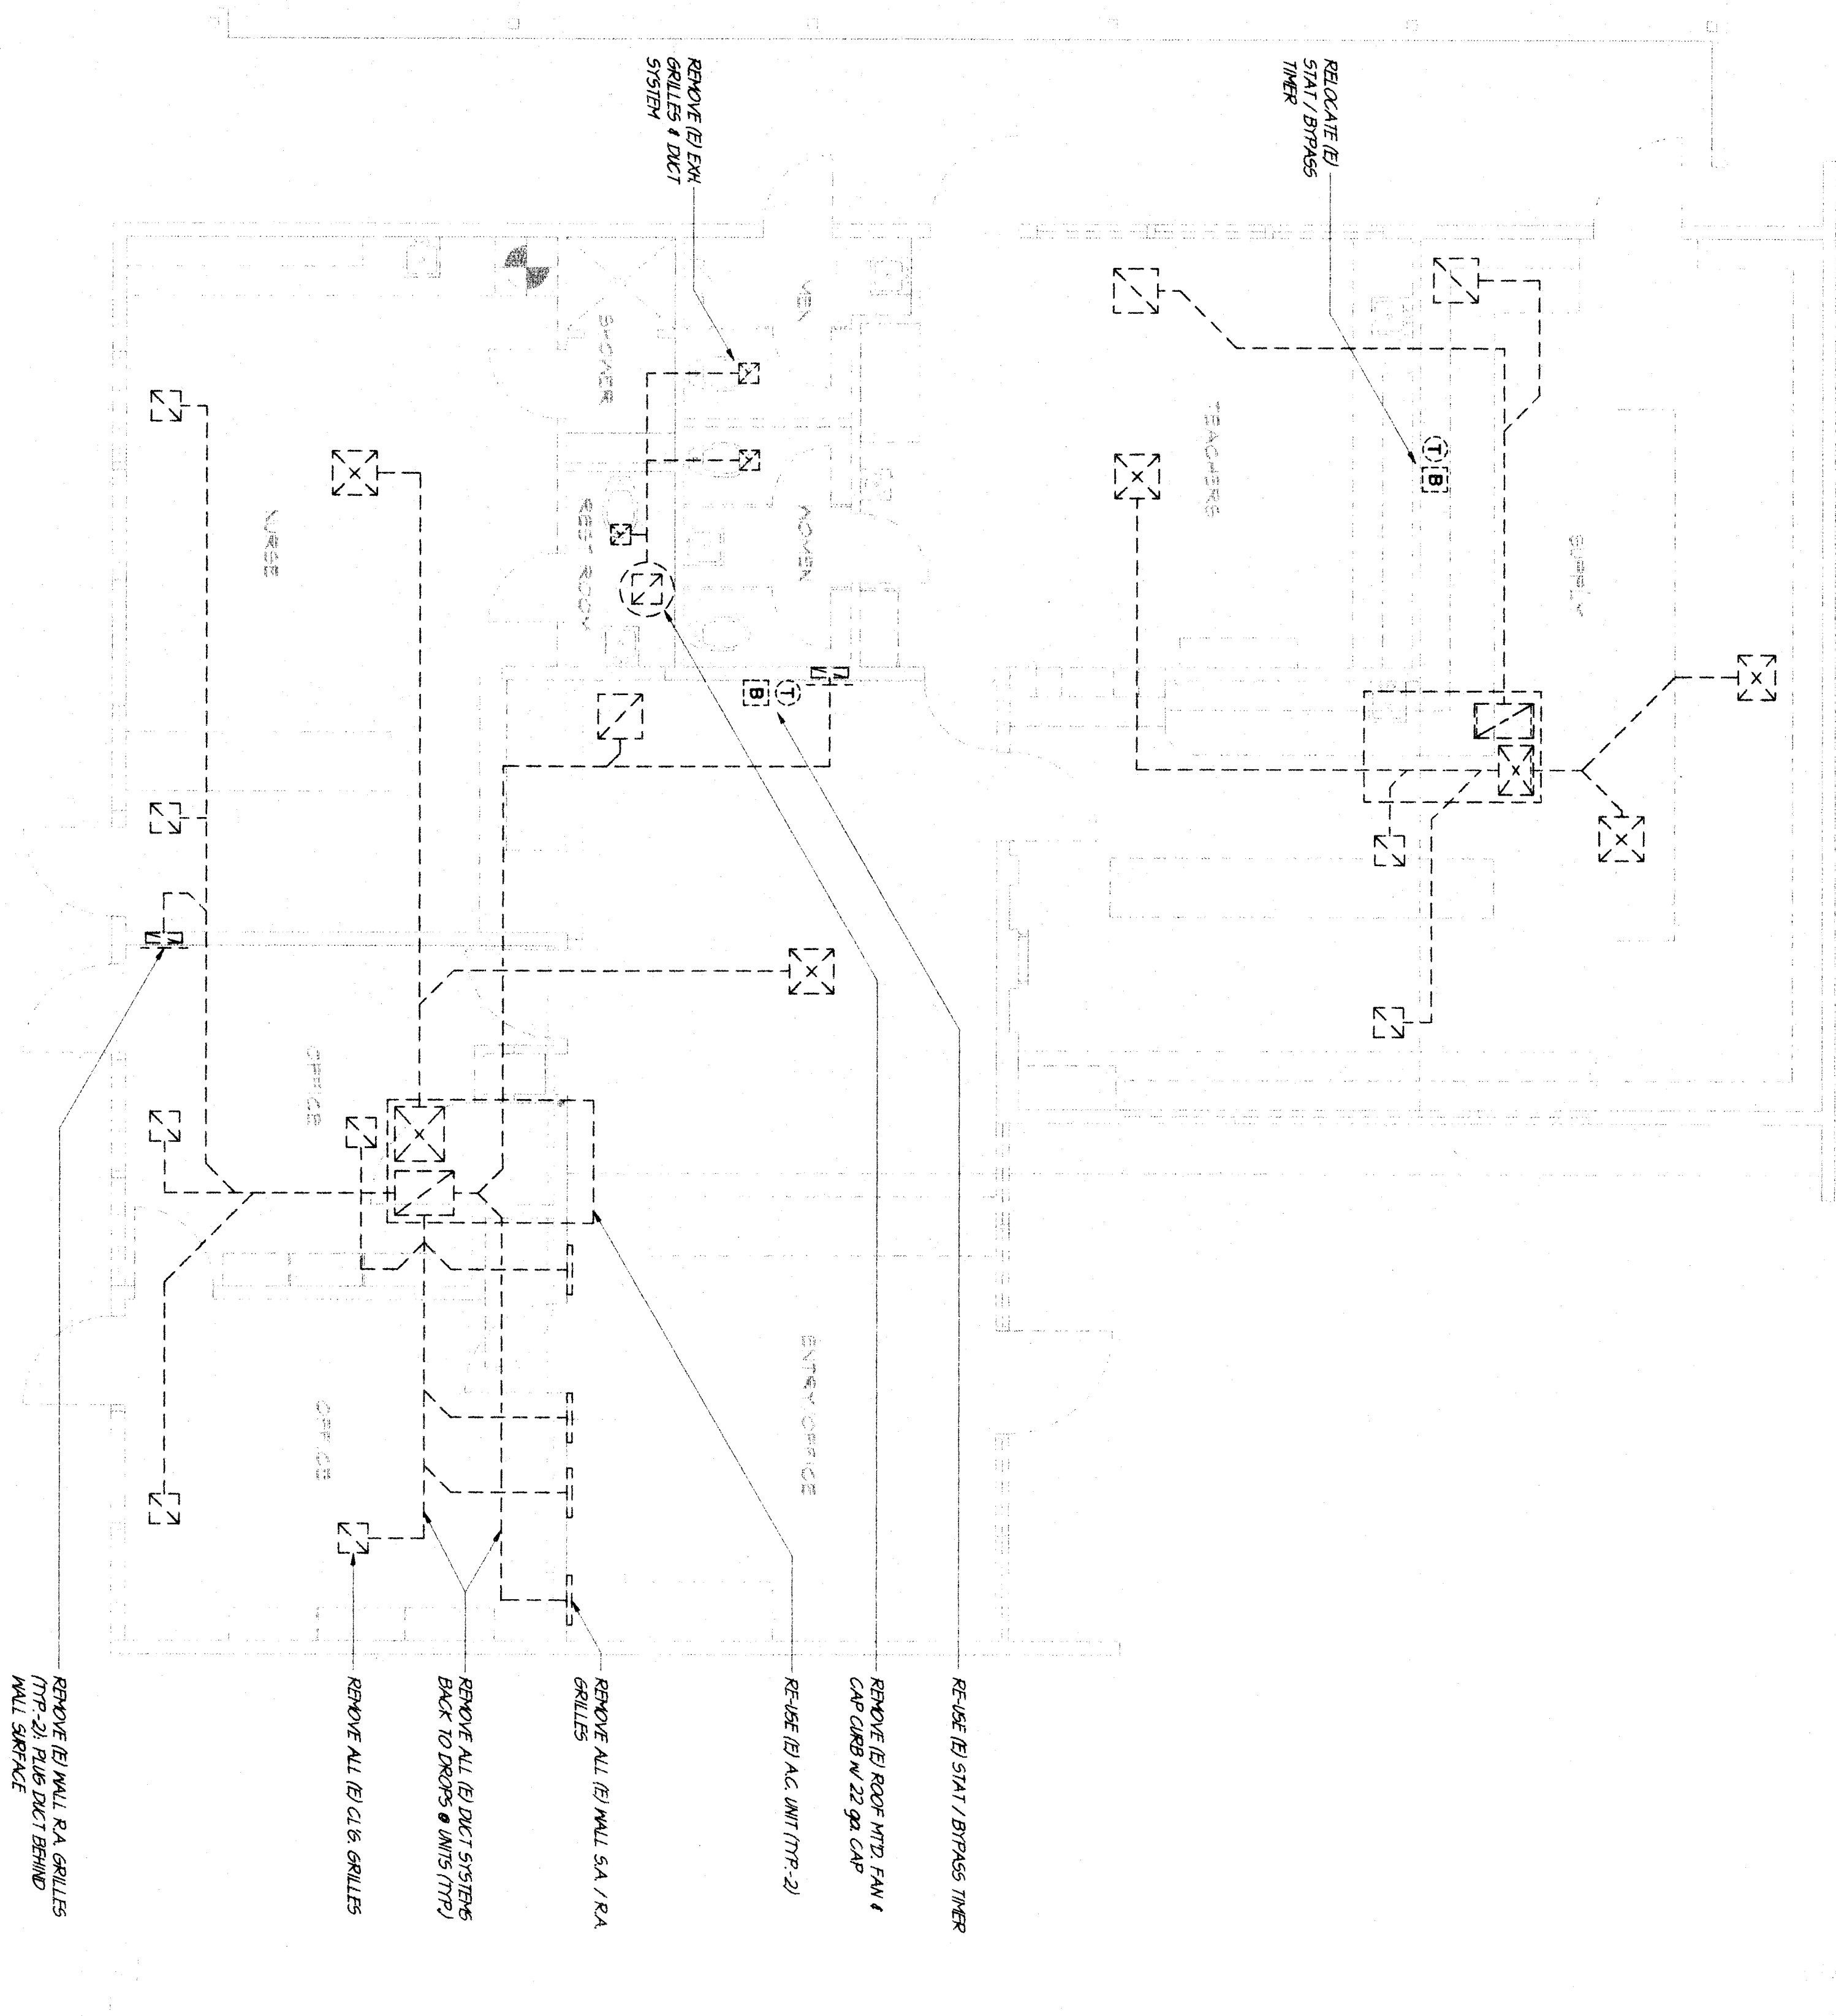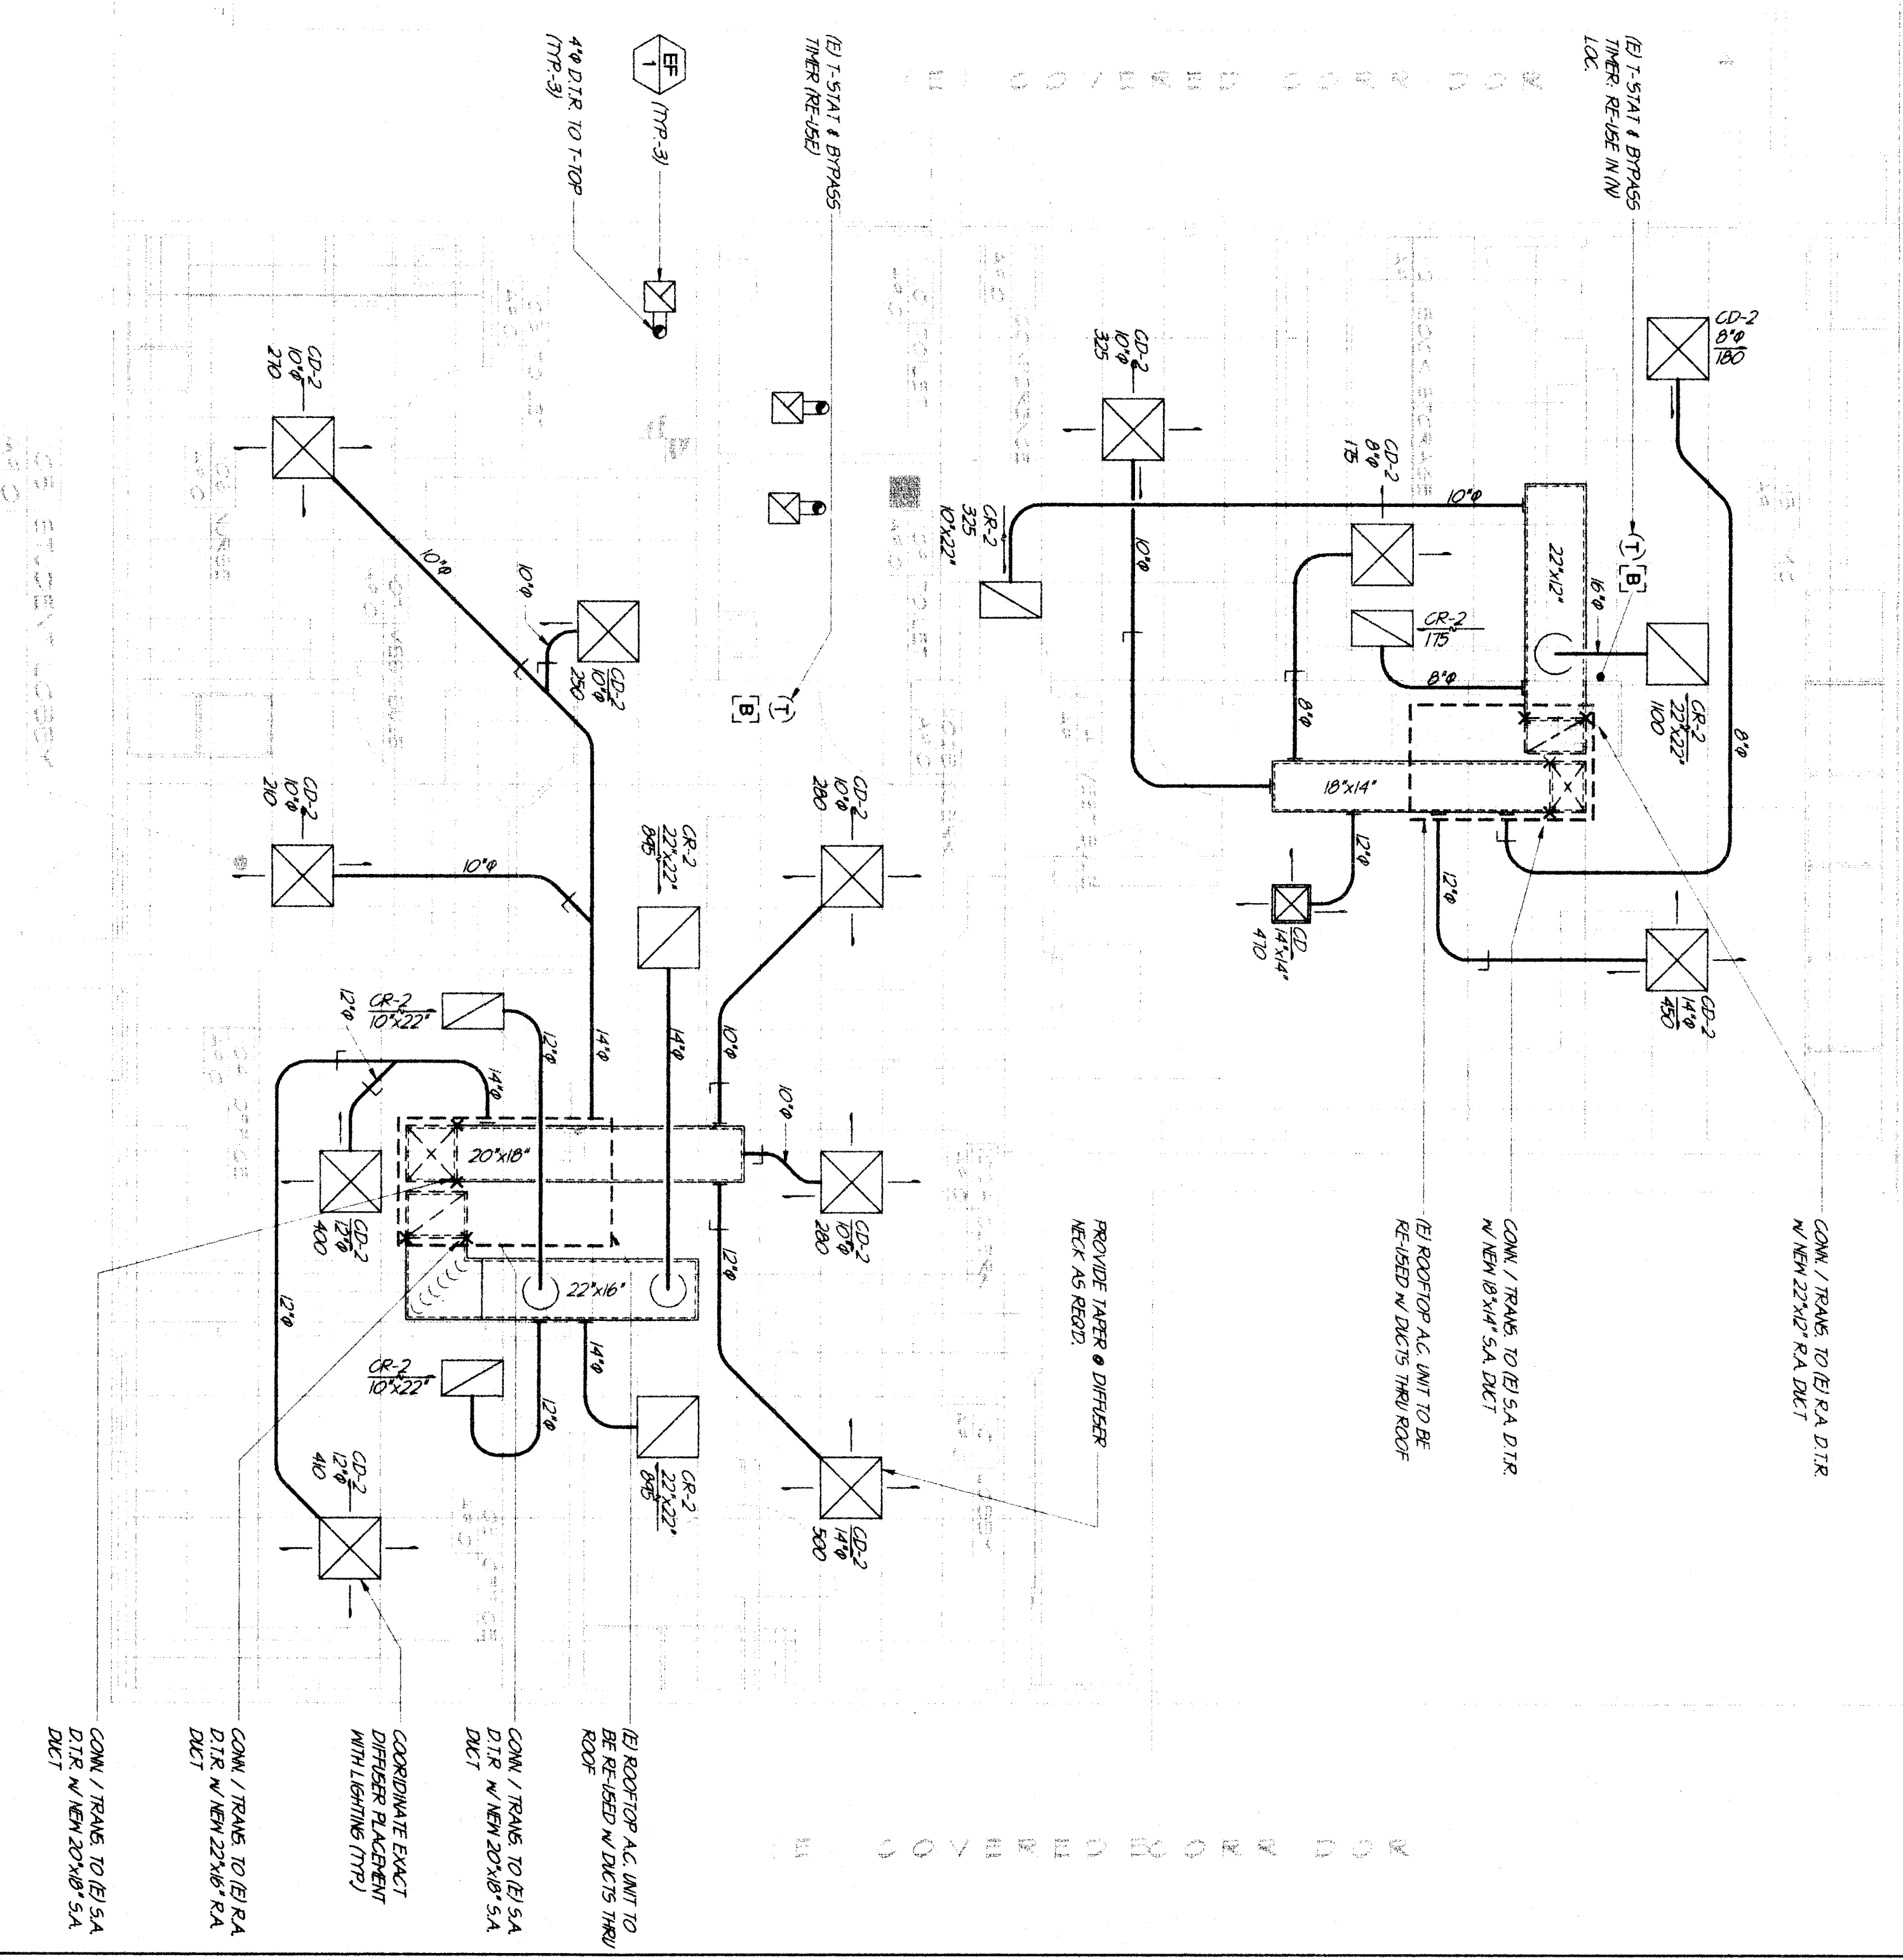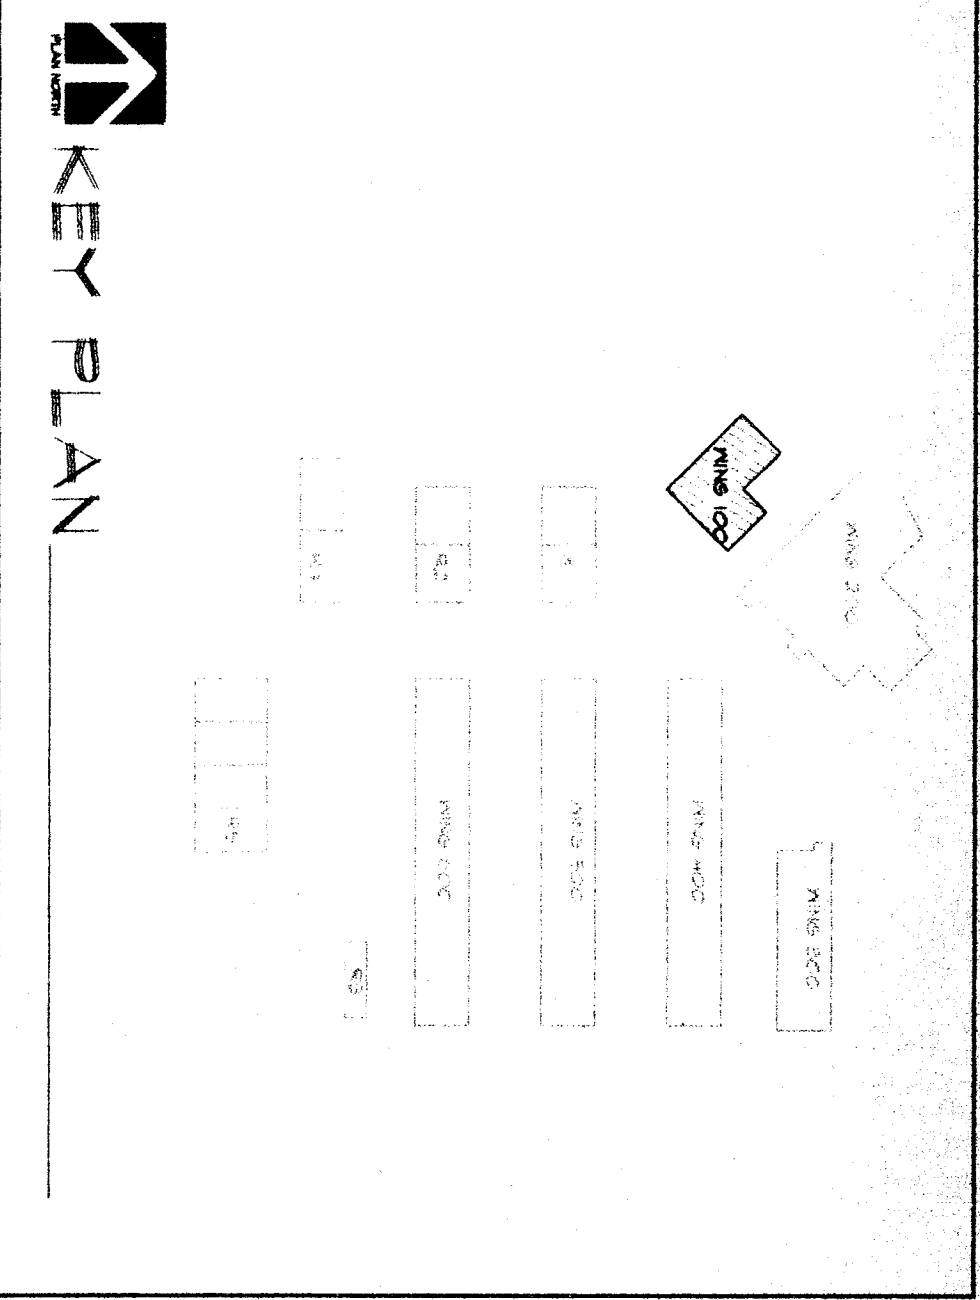

MECHANICAL DEMOLITION FLOOR PLAN (WING-100)
 SCALE 1/4"=1'-0"

(A)



MECHANICAL FLOOR PLAN (WING-100)
 SCALE 1/4"=1'-0"

(B)

1017