
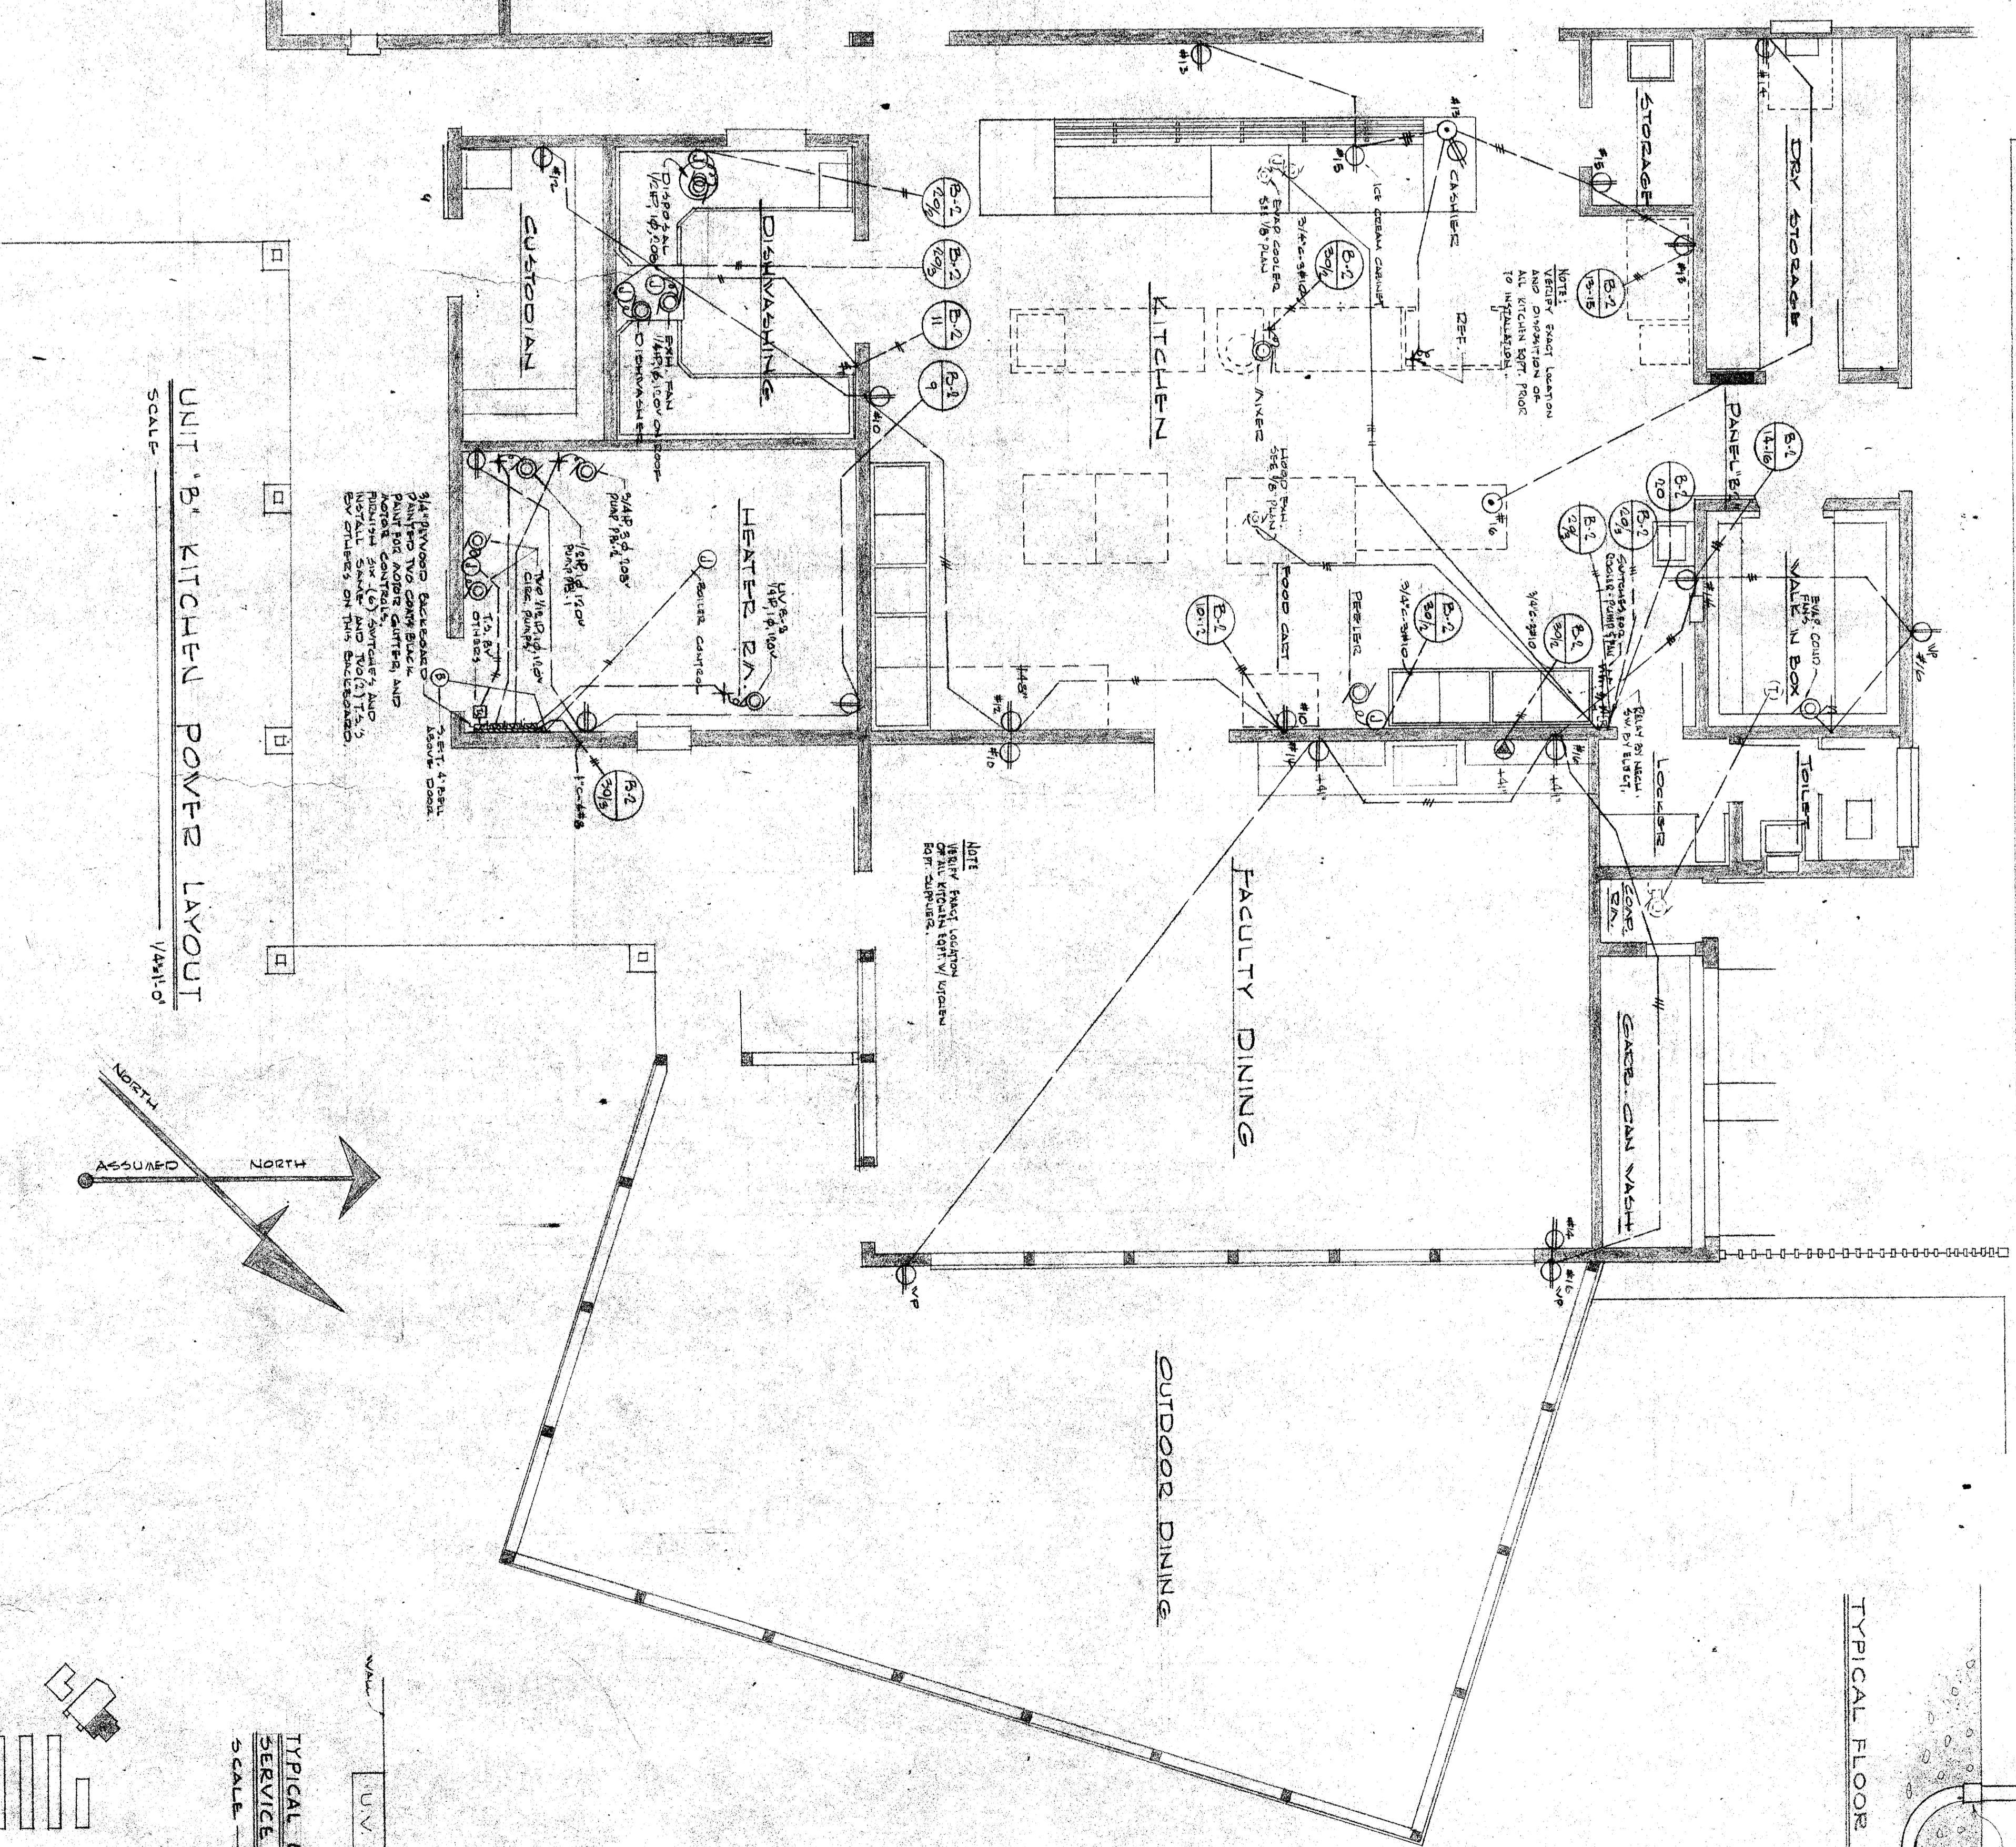
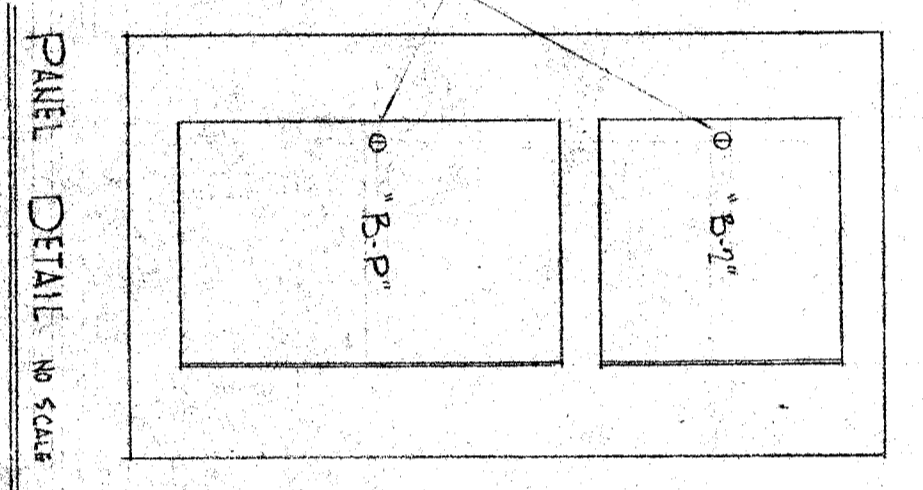


LINE DIAGRAM of PANEL 'B-1' and 'B-2'


PANEL-B-2				TYPE 1 250 AMP PANEL - 480V/208V	
LT	BREAKER SIZE	LOAD	W/ WATTS	DESCRIPTION	
1	20	1400	54	WATTS	
2	20	1400	54	WATTS	
3	20	1400	54	WATTS	
4	20	1400	54	WATTS	
5	20	1400	54	WATTS	
6	20	1400	54	WATTS	
7	20	1400	54	WATTS	
8	20	1400	54	WATTS	
9	20	1400	54	WATTS	
10	20	1400	54	WATTS	
11	20	1400	54	WATTS	
12	20	1400	54	WATTS	
13	20	1400	54	WATTS	
14	20	1400	54	WATTS	
15	20	1400	54	WATTS	
16	20	1400	54	WATTS	
17	20	1400	54	WATTS	
18	20	1400	54	WATTS	
19	20	1400	54	WATTS	
20	20	1400	54	WATTS	
21	20	1400	54	WATTS	
22	20	1400	54	WATTS	
TOTALS				112.8	104.8

PANEL 'A-1'				TYPE 1 250 AMP PANEL - 480V/208V	
LT	BREAKER SIZE	LOAD	W/ WATTS	DESCRIPTION	
1	30	1400	54	WATTS	
2	30	1400	54	WATTS	
3	30	1400	54	WATTS	
4	30	1400	54	WATTS	
5	30	1400	54	WATTS	
6	30	1400	54	WATTS	
7	30	1400	54	WATTS	
8	30	1400	54	WATTS	
9	30	1400	54	WATTS	
10	30	1400	54	WATTS	
11	30	1400	54	WATTS	
12	30	1400	54	WATTS	
13	30	1400	54	WATTS	
14	30	1400	54	WATTS	
15	30	1400	54	WATTS	
16	30	1400	54	WATTS	
17	30	1400	54	WATTS	
18	30	1400	54	WATTS	
19	30	1400	54	WATTS	
20	30	1400	54	WATTS	
21	30	1400	54	WATTS	
22	30	1400	54	WATTS	
TOTALS				1600	10100

DETAIL NITELITE TERM CABINET SCALE 5" = 1'-0"

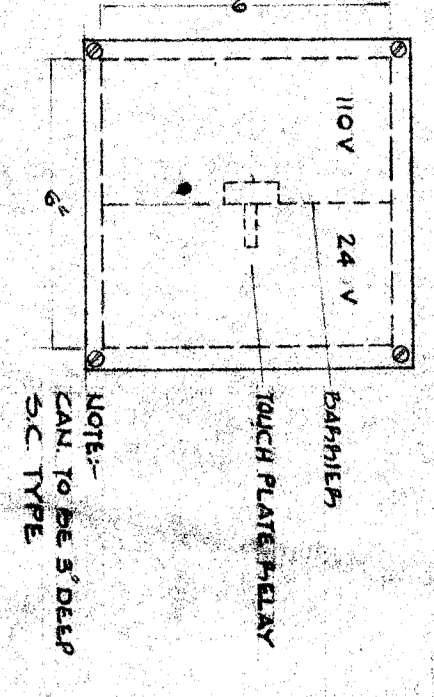

UNIT 'B' KITCHEN POWER LAYOUT SCALE 1/4" = 1'-0"

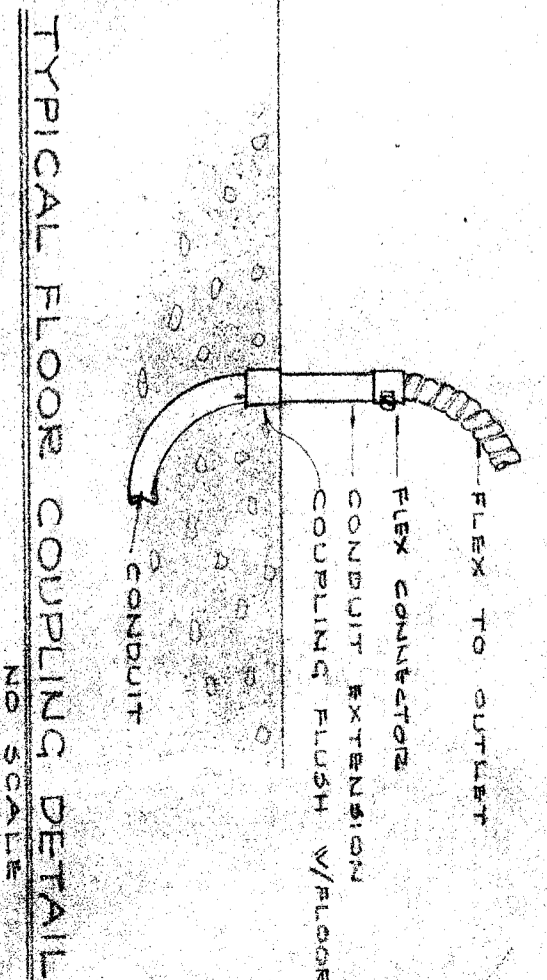

TYPICAL FLOOR COUPLING DETAIL NO SCALE

TYPICAL UNIT VENTILATOR SERVICE LOCATION SCALE 1/4" = 1'-0"

STATE OF CALIFORNIA DEPARTMENT OF PUBLIC WORKS  
 DIVISION OF ARCHITECTURE  
 1722 S. ANGELES AVENUE, LOS ANGELES, CALIFORNIA 90033  
 PROJECT: PICO STREET SCHOOL, 2411 H STREET, DAKESFIELD, CALIFORNIA  
 ARCHITECT: ERNEST L. MCCOY A.I.A. ARCHITECT, 2411 H STREET, DAKESFIELD, CALIFORNIA  
 DATE: JUN 8 - 1988  
 SHEET NO. E-3 OF 5 SHEETS

CHECK AND VERIFY ALL DIMENSIONS AND CONDITIONS AT JOB SITE BEFORE PROCEEDING WITH THE WORK. REPORT ANY DISCREPANCIES TO THE ARCHITECT.

APPROVED: [Signature] DATE: [ ]  
 PICO STREET SCHOOL  
 2411 H STREET, DAKESFIELD, CALIFORNIA  
 ERNEST L. MCCOY A.I.A. ARCHITECT  
 2411 H STREET, DAKESFIELD, CALIFORNIA  
 JOB NO. [ ]  
 DRAWN BY: [ ]  
 CHECKED BY: [ ]  
 DATE: [ ]