



FLOOR PLAN UNIT 'E'

NOTE:
See Transmittal Section
for notes on this set.

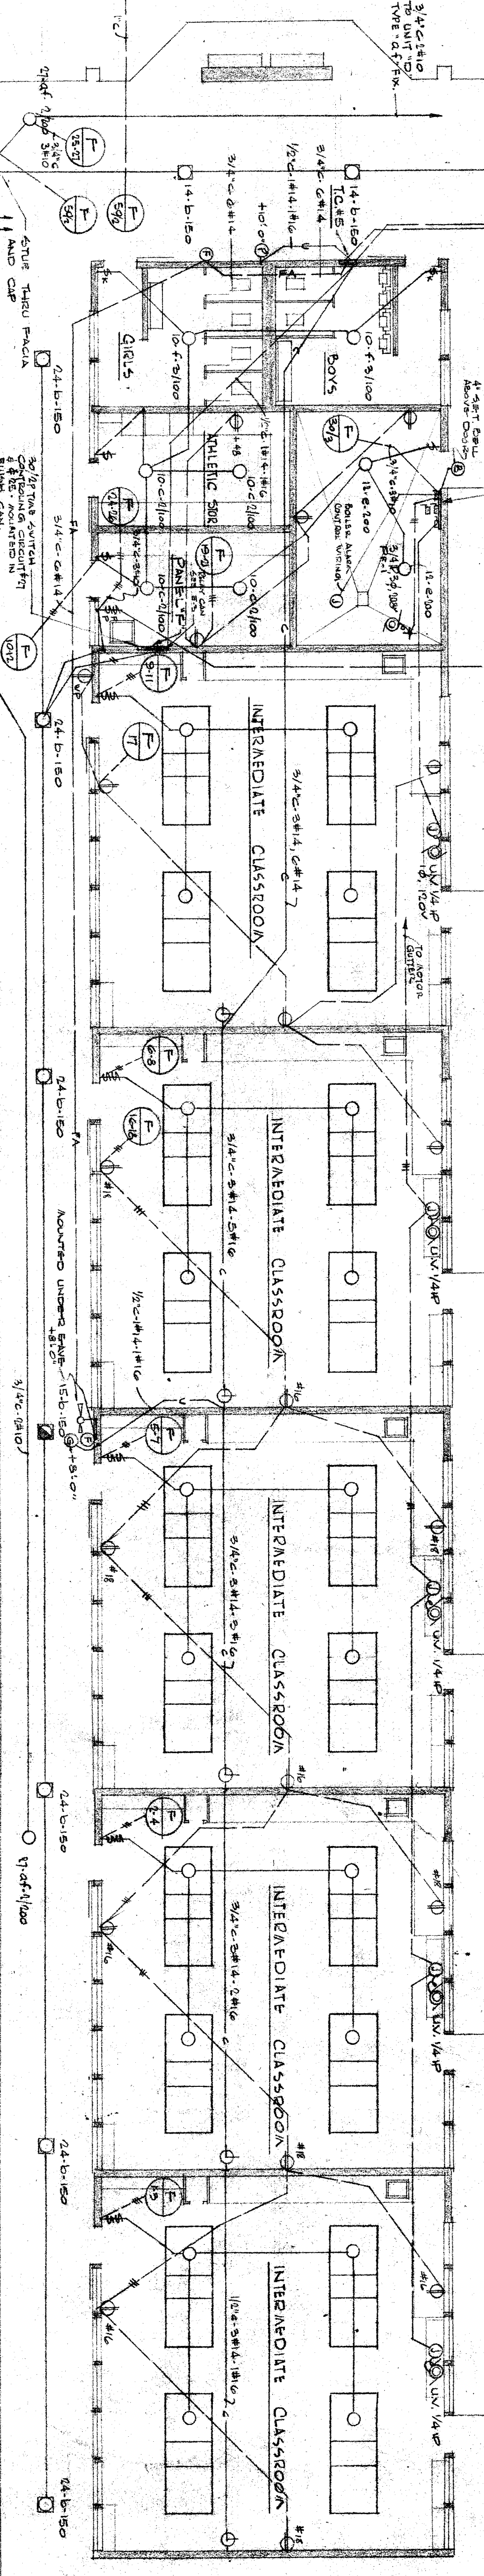


FLOOR PLAN UNIT 'F'

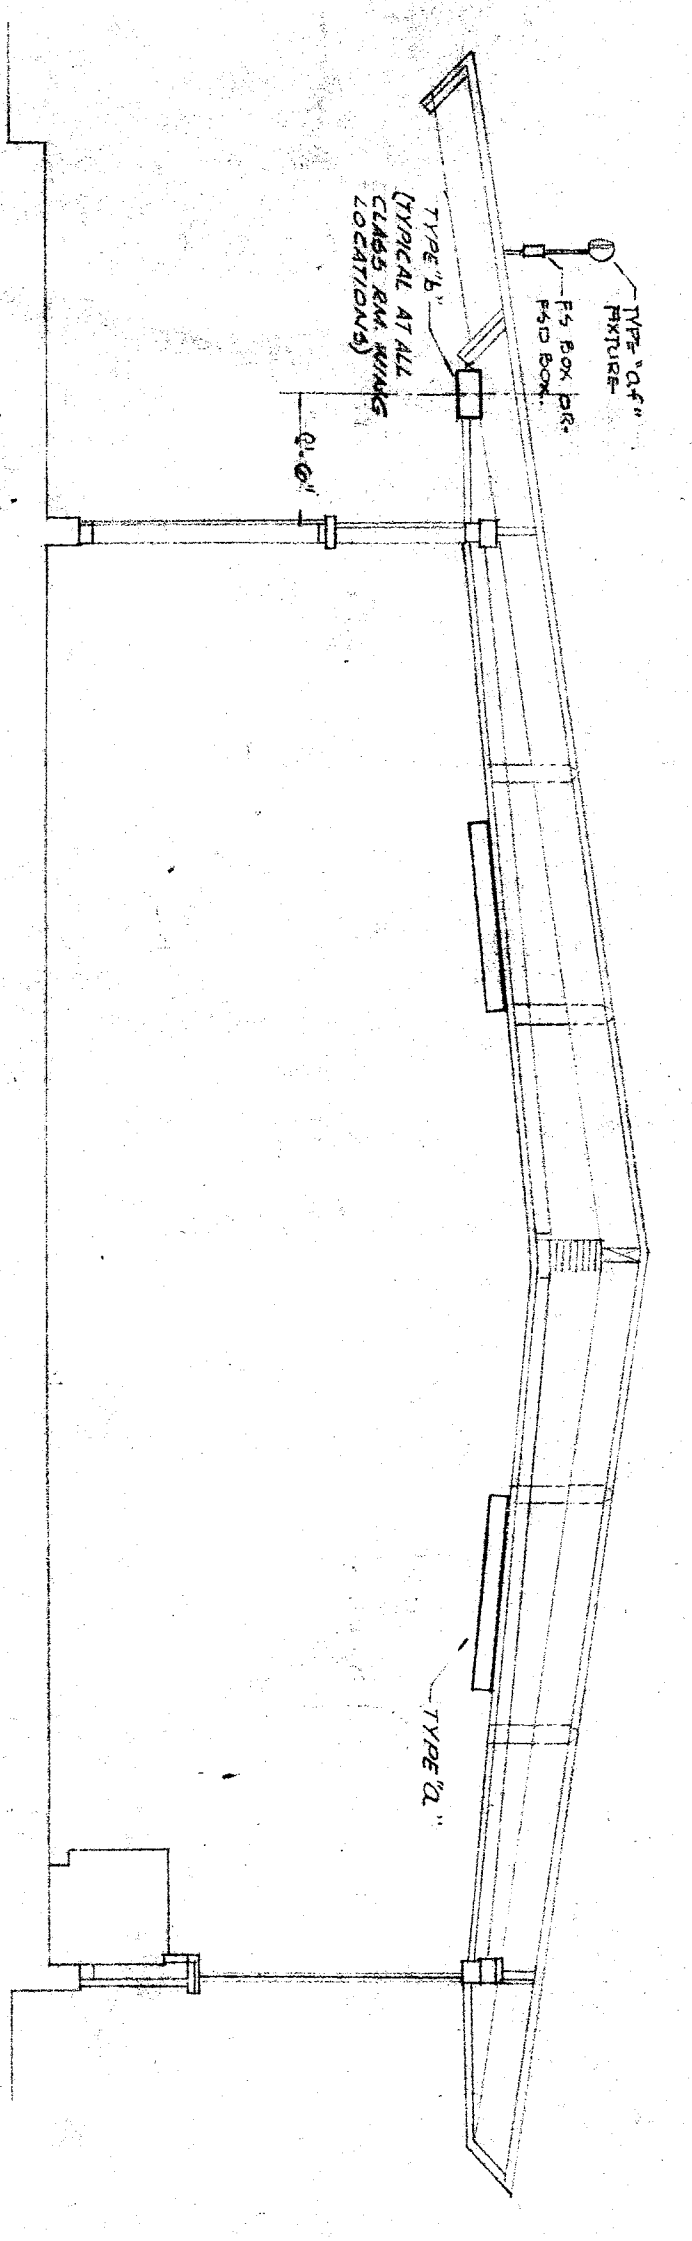

SECTION THROUGH TYPICAL CLASS ROOM
SCALE: 1/4" = 1'-0"

PANEL 'E'				TYPE - N
CT	BREAKER	LOAD IN WATTS		120/208Y
NO.	SIZE	POLE	Ø A Ø B Ø C	DESCRIP
1	20	1	1000	lights
2	20	1	1000	lights
3	20	1	1000	lights
4	20	1	1000	lights
5	20	1	1000	lights
6	20	1	1000	lights
7	20	1	1000	lights
8	20	1	1000	lights
9	20	1	1000	lights
10	20	1	1000	lights
11	20	1	1000	lights
12	20	1	1000	lights
13	20	1	1000	lights
14	20	1	1000	lights
15	20	1	1000	lights
16	20	1	1000	lights
17	20	1	1000	lights
18	20	1	1000	lights
19	20	1	1000	lights
20	20	1	1000	lights
21	20	1	1000	lights
22	20	1	1000	lights
23	20	1	1000	lights
24	20	1	1000	lights
25	20	1	1000	lights
26	20	1	1000	lights
27	20	1	1000	lights
28	20	1	1000	lights
29	20	1	1000	lights
30	20	1	1000	lights
31	20	1	1000	lights
32	20	1	1000	lights
33	20	1	1000	lights
34	20	1	1000	lights
35	20	1	1000	lights
36	20	1	1000	lights
37	20	1	1000	lights
38	20	1	1000	lights
39	20	1	1000	lights
40	20	1	1000	lights
41	20	1	1000	lights
42	20	1	1000	lights
43	20	1	1000	lights
44	20	1	1000	lights
45	20	1	1000	lights
46	20	1	1000	lights
47	20	1	1000	lights
48	20	1	1000	lights
49	20	1	1000	lights
50	20	1	1000	lights
TOTAL			14300	14300

PANEL 'F'				TYPE - NUB-AB
CT	BREAKER	LOAD IN WATTS		120/208Y 3 Ø 4 WIRE
NO.	SIZE	POLE	Ø A Ø B Ø C	DESCRIPTION
1	20	1	1000	lights
2	20	1	1000	lights
3	20	1	1000	lights
4	20	1	1000	lights
5	20	1	1000	lights
6	20	1	1000	lights
7	20	1	1000	lights
8	20	1	1000	lights
9	20	1	1000	lights
10	20	1	1000	lights
11	20	1	1000	lights
12	20	1	1000	lights
13	20	1	1000	lights
14	20	1	1000	lights
15	20	1	1000	lights
16	20	1	1000	lights
17	20	1	1000	lights
18	20	1	1000	lights
19	20	1	1000	lights
20	20	1	1000	lights
21	20	1	1000	lights
22	20	1	1000	lights
23	20	1	1000	lights
24	20	1	1000	lights
25	20	1	1000	lights
26	20	1	1000	lights
27	20	1	1000	lights
28	20	1	1000	lights
29	20	1	1000	lights
30	20	1	1000	lights
31	20	1	1000	lights
32	20	1	1000	lights
33	20	1	1000	lights
34	20	1	1000	lights
35	20	1	1000	lights
36	20	1	1000	lights
37	20	1	1000	lights
38	20	1	1000	lights
39	20	1	1000	lights
40	20	1	1000	lights
41	20	1	1000	lights
42	20	1	1000	lights
43	20	1	1000	lights
44	20	1	1000	lights
45	20	1	1000	lights
46	20	1	1000	lights
47	20	1	1000	lights
48	20	1	1000	lights
49	20	1	1000	lights
50	20	1	1000	lights
TOTAL			14300	14300

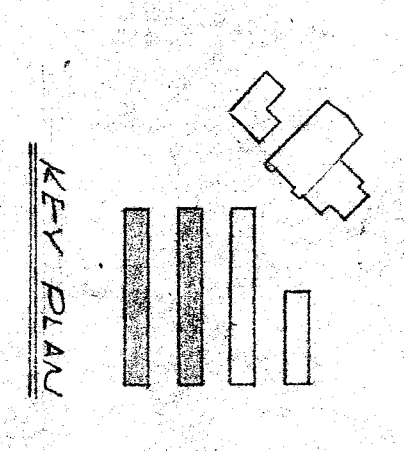

KEY PLAN

OFFICE OF SUPERINTENDENT OF SCHOOLS
STATE OF CALIFORNIA
DEPARTMENT OF PUBLIC WORKS
DIVISION OF ARCHITECTURE

APPROVED: [Signature]
DATE: [Date]

ERNEST L. MCCOY A. I. A. ARCHITECT
3811 N. STREET
BAKERSFIELD, CALIFORNIA

PICO STREET SCHOOL
PICO STREET AND EDWARDS AVE
BAKERSFIELD, CALIFORNIA