



RAY-HEATING PLAN #3
Scale 1/8" = 1'-0"

SCHEMATIC DIAGRAM - BOILER PIPING


DETAIL - HW PIPE & CONCRETE PIPE INSTALLATION

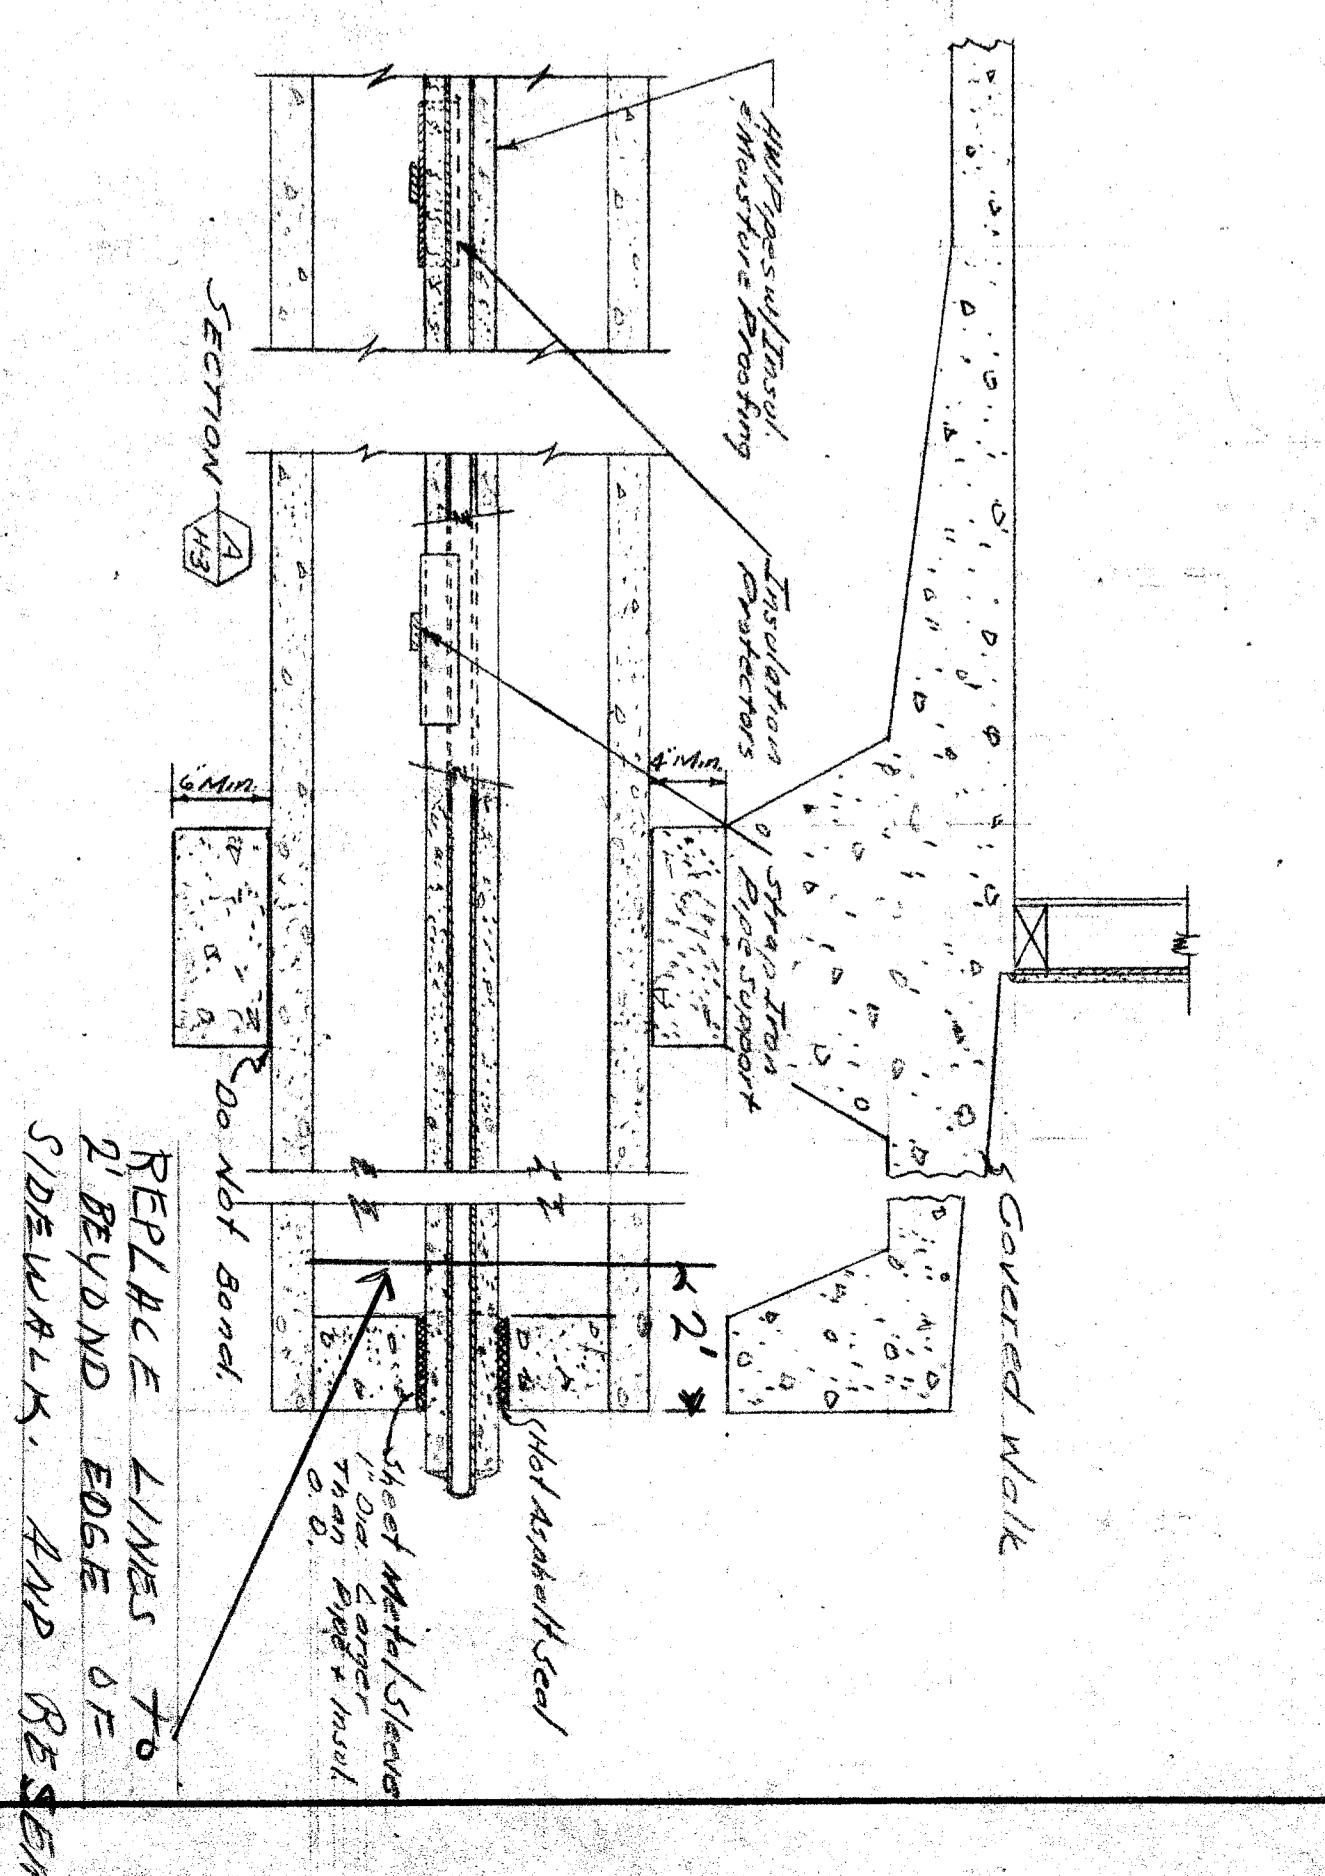


DETAIL - EXPANSION TANK SUSPENSION

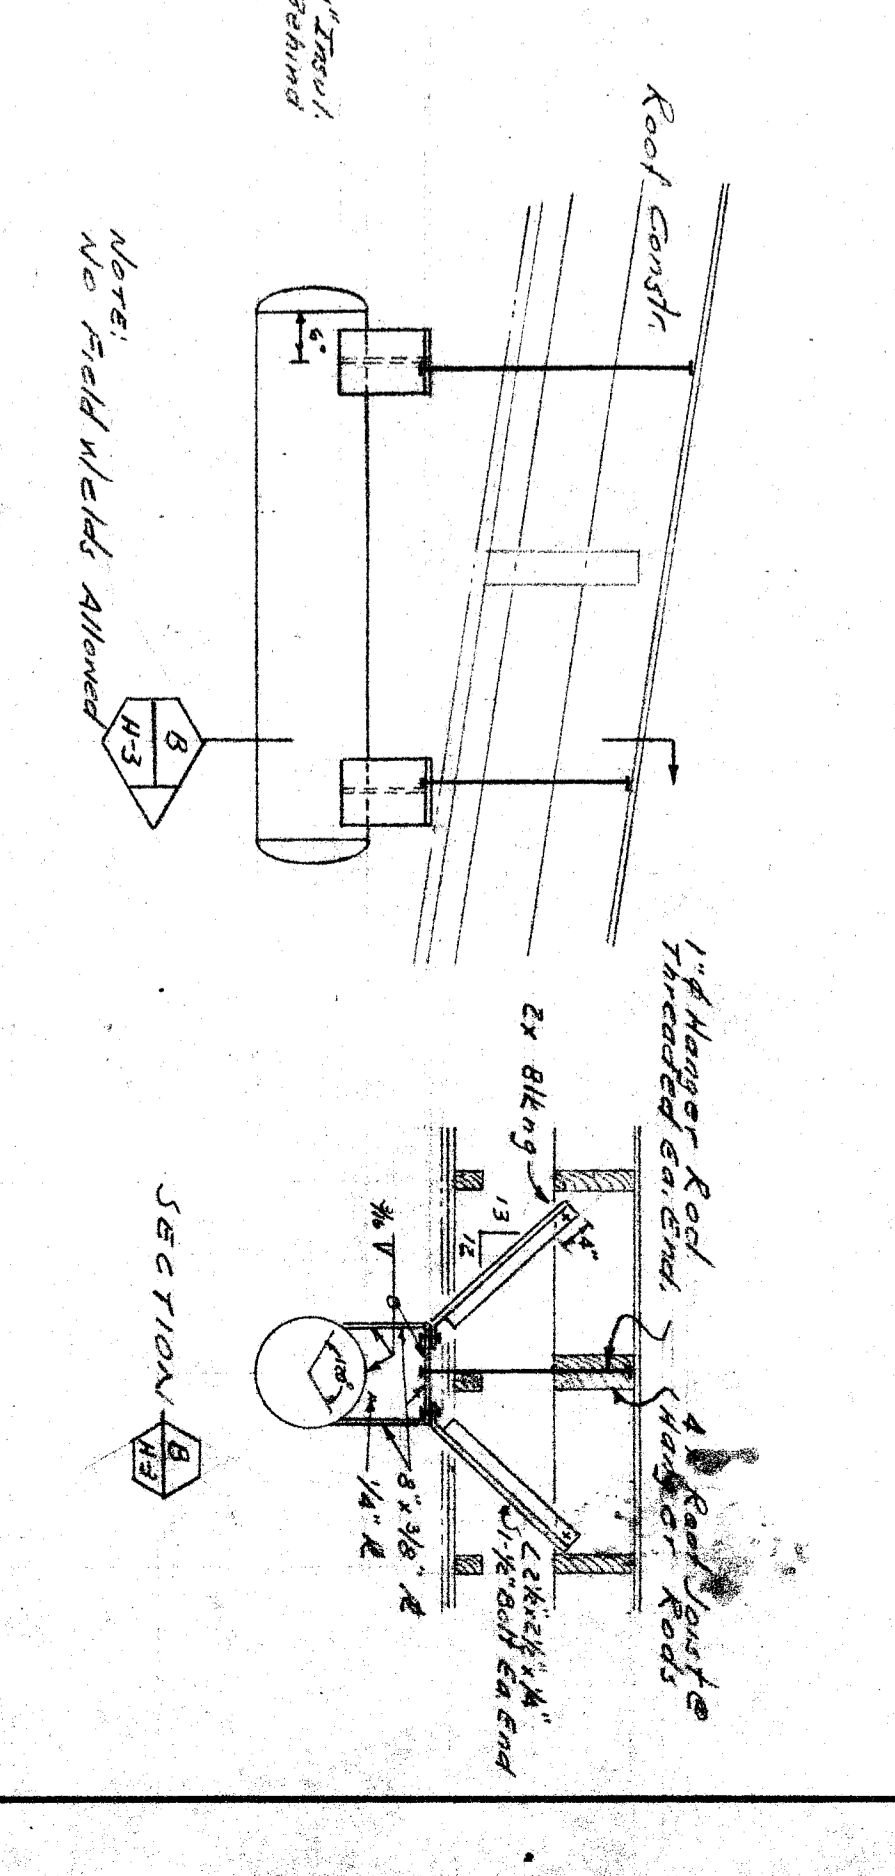


DETAIL - HWV INSTALLATION

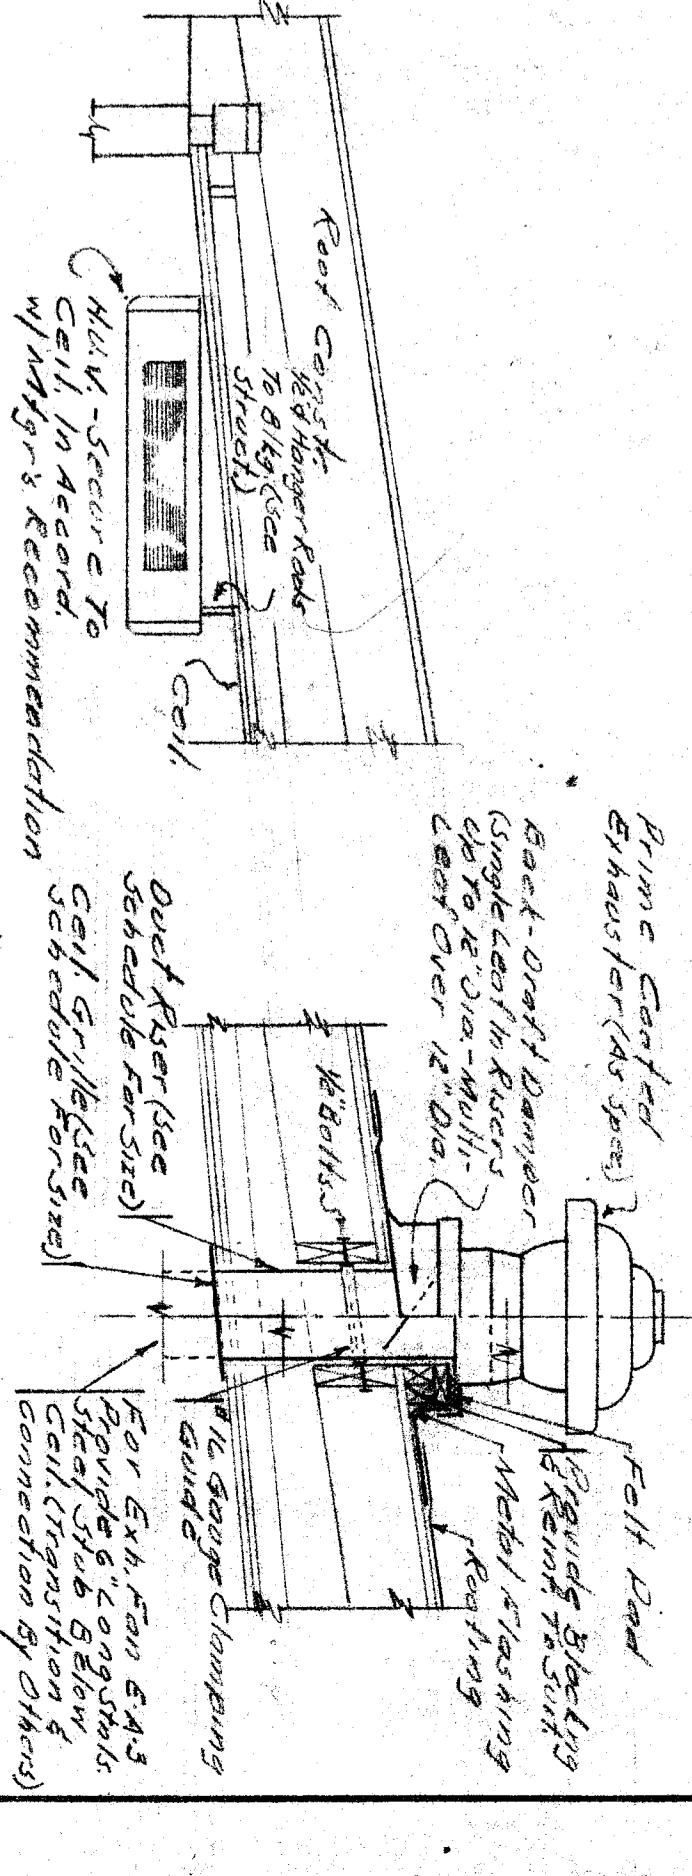

DETAIL - AIR WASHER INSTALLATION

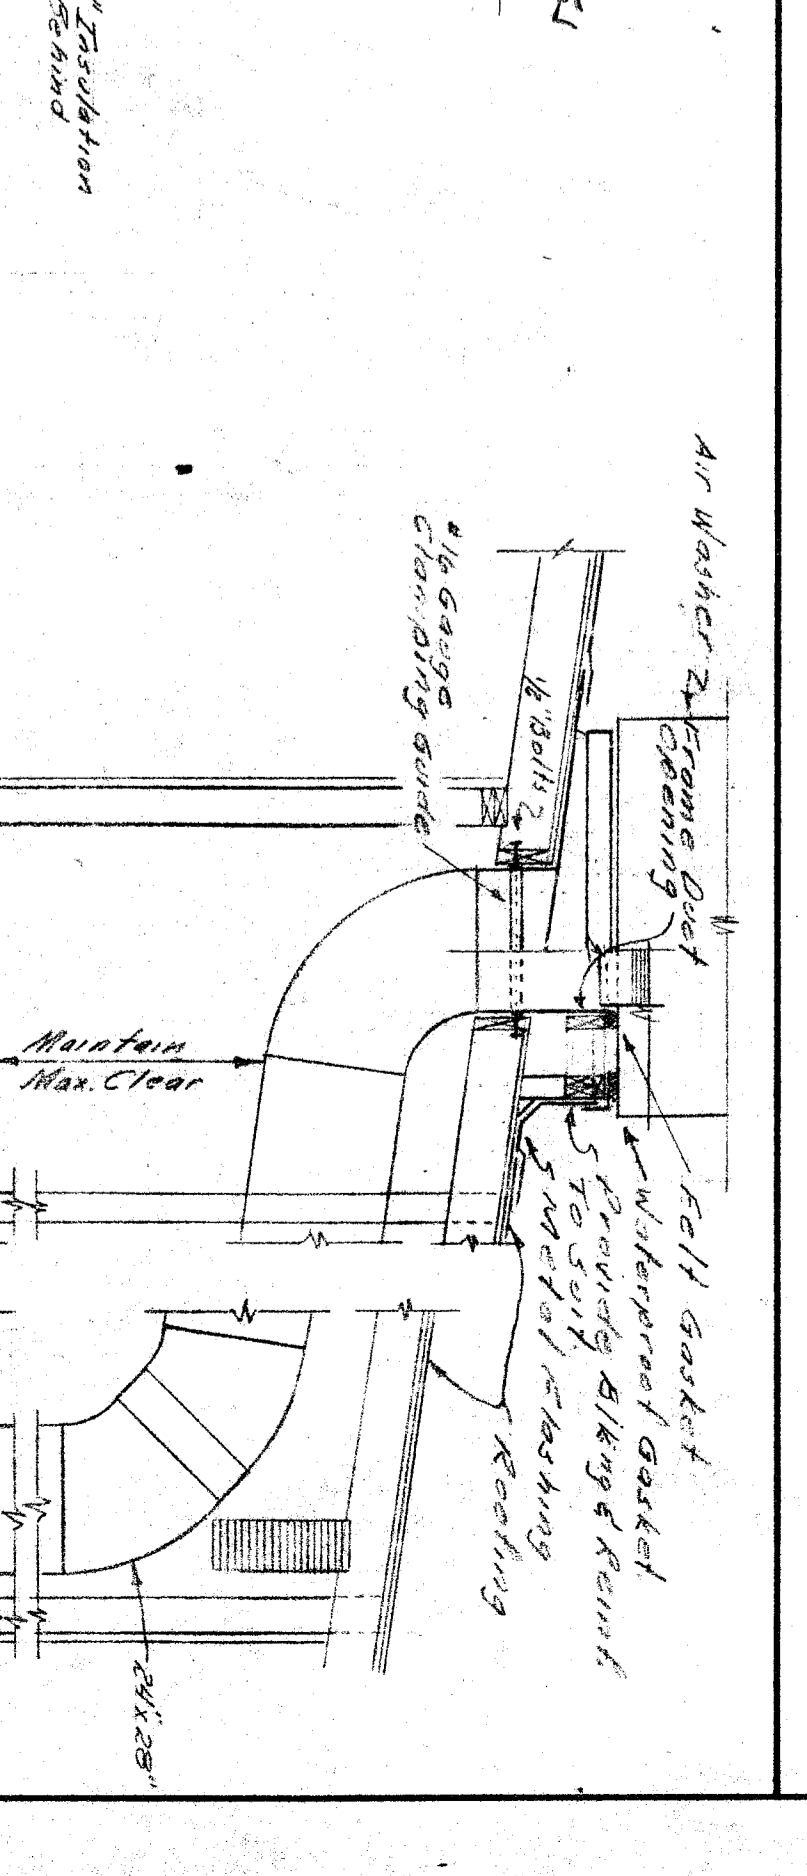

DETAIL - EXHAUST FAN

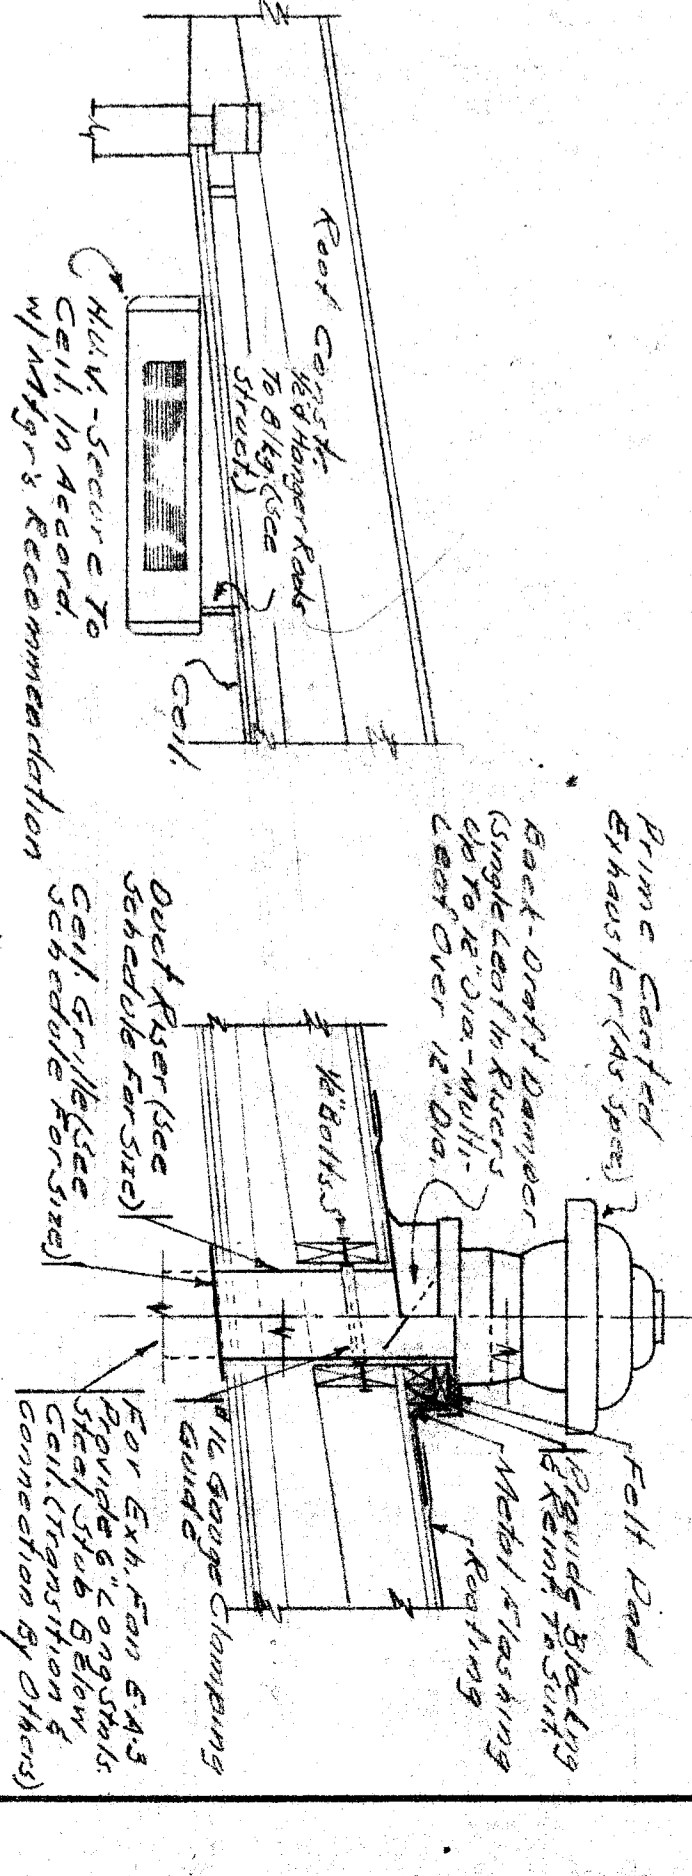

OFFICE OF SUPERINTENDENT OF SCHOOLS APPROVED _____ DATE _____	STATE OF CALIFORNIA DEPARTMENT OF PUBLIC WORKS DIVISION OF ARCHITECTURE 1732 1/2 APPROVED JUNE 18, 1958 DATE _____	BAKERSFIELD CITY SCHOOL DISTRICT BAKERSFIELD CALIFORNIA BOARD OF EDUCATION	APPROVED BY _____ BOARD OF SUPERVISORS CHECK AND VERIFY ALL DIMENSIONS AND CONDITIONS AT JOB SITE BEFORE PROCEEDING WITH THE WORK. REPORT ANY DISCREPANCIES TO THE ARCHITECT.	DATE _____ DRAWN _____ CHECKED _____	HOWARD F. McANDREWS CONSULTING ARCHITECTS 240 ARCADE BUILDING BAKERSFIELD, CALIFORNIA	JOB NO. _____ ARCHITECT ERNEST L. MCCOY A.I.A. 2411 N STREET BAKERSFIELD CALIFORNIA	HARDING SCHOOL #13 PICO STREET SCHOOL STREET AND EDWARDS AVE BAKERSFIELD CALIFORNIA	SHEET NO. _____ OF 2 SHEETS
---	---	--	---	--	--	---	--	--------------------------------