



UNIT F
 UNIT E
 PLUMBING PLAN
 Scale: 1/8" = 1'-0"

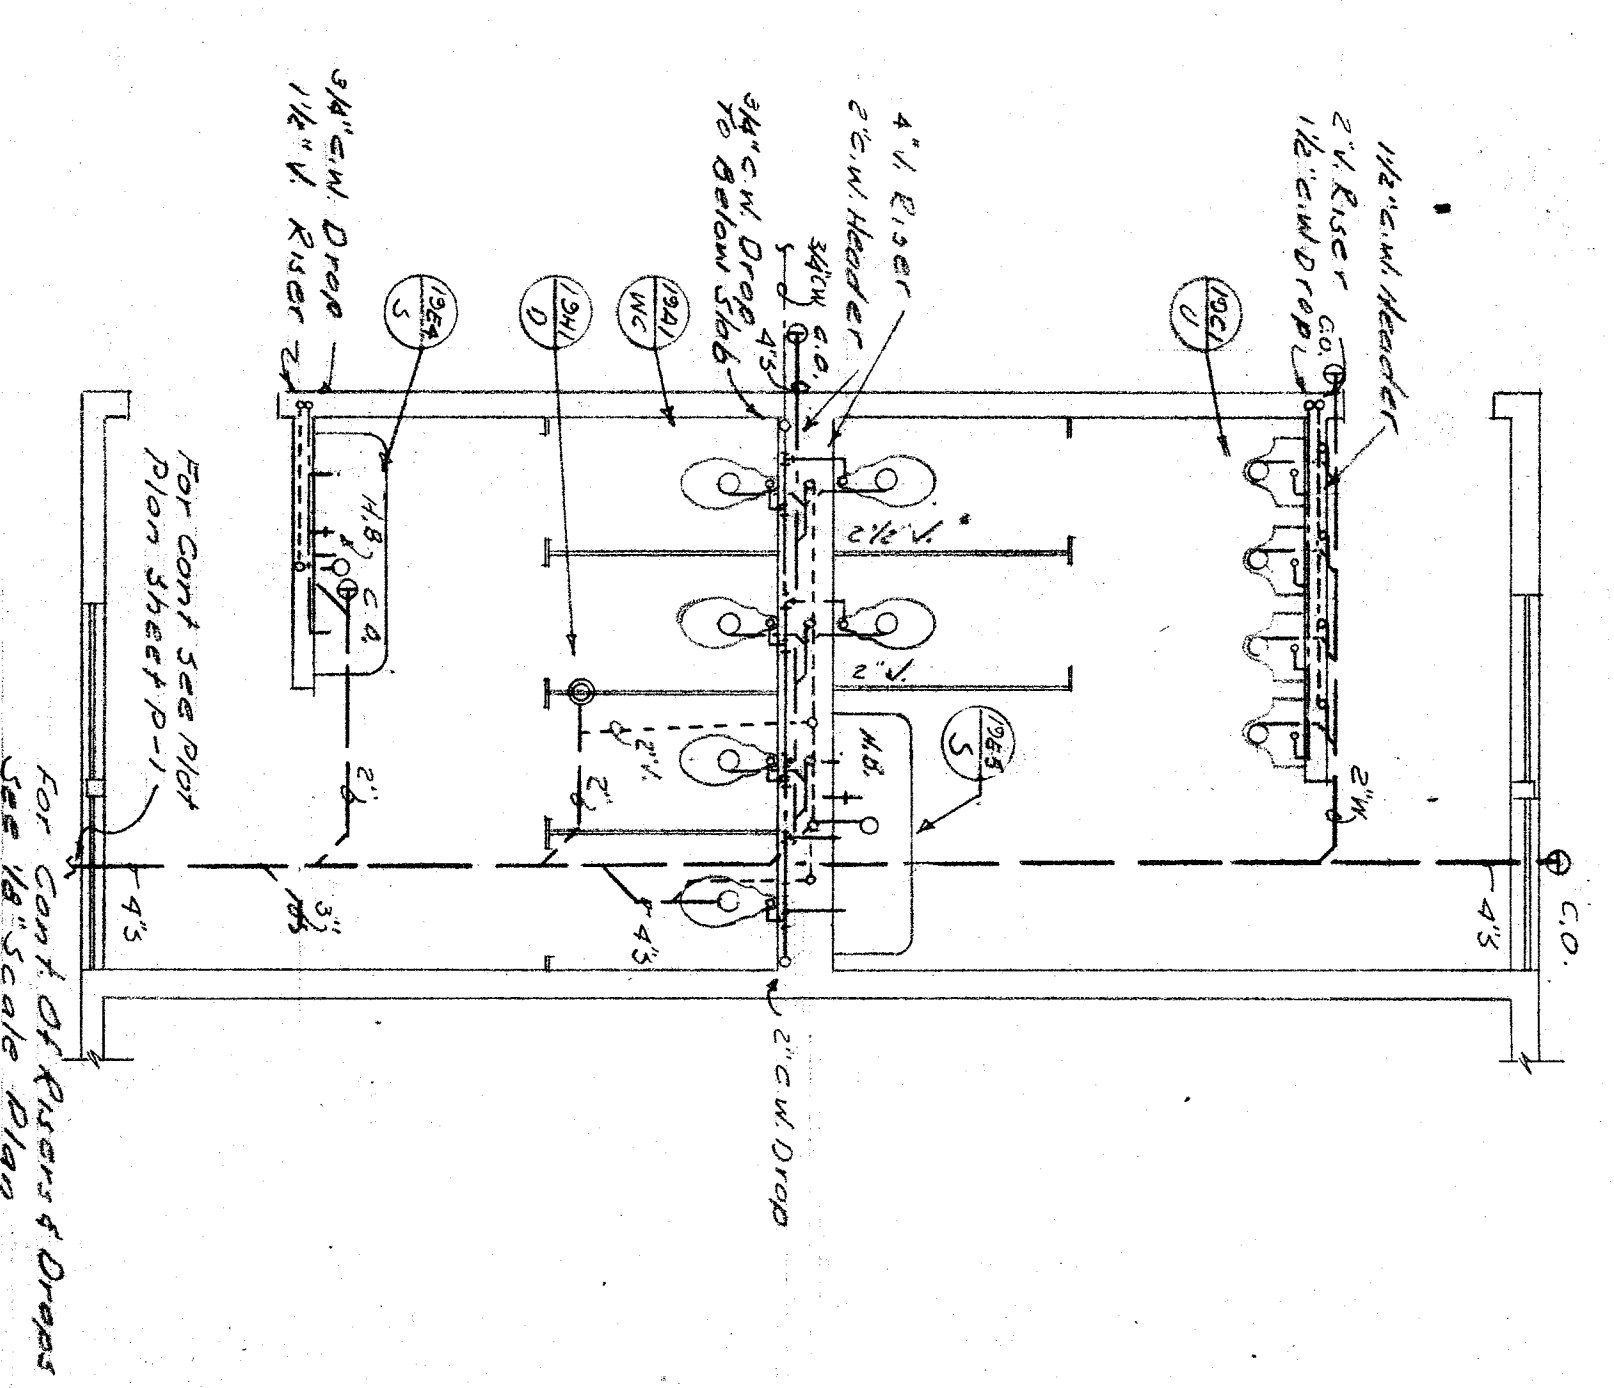

UNIT D.I.F. TOILET AREA PART PLAN
 Scale: 1/8" = 1'-0"

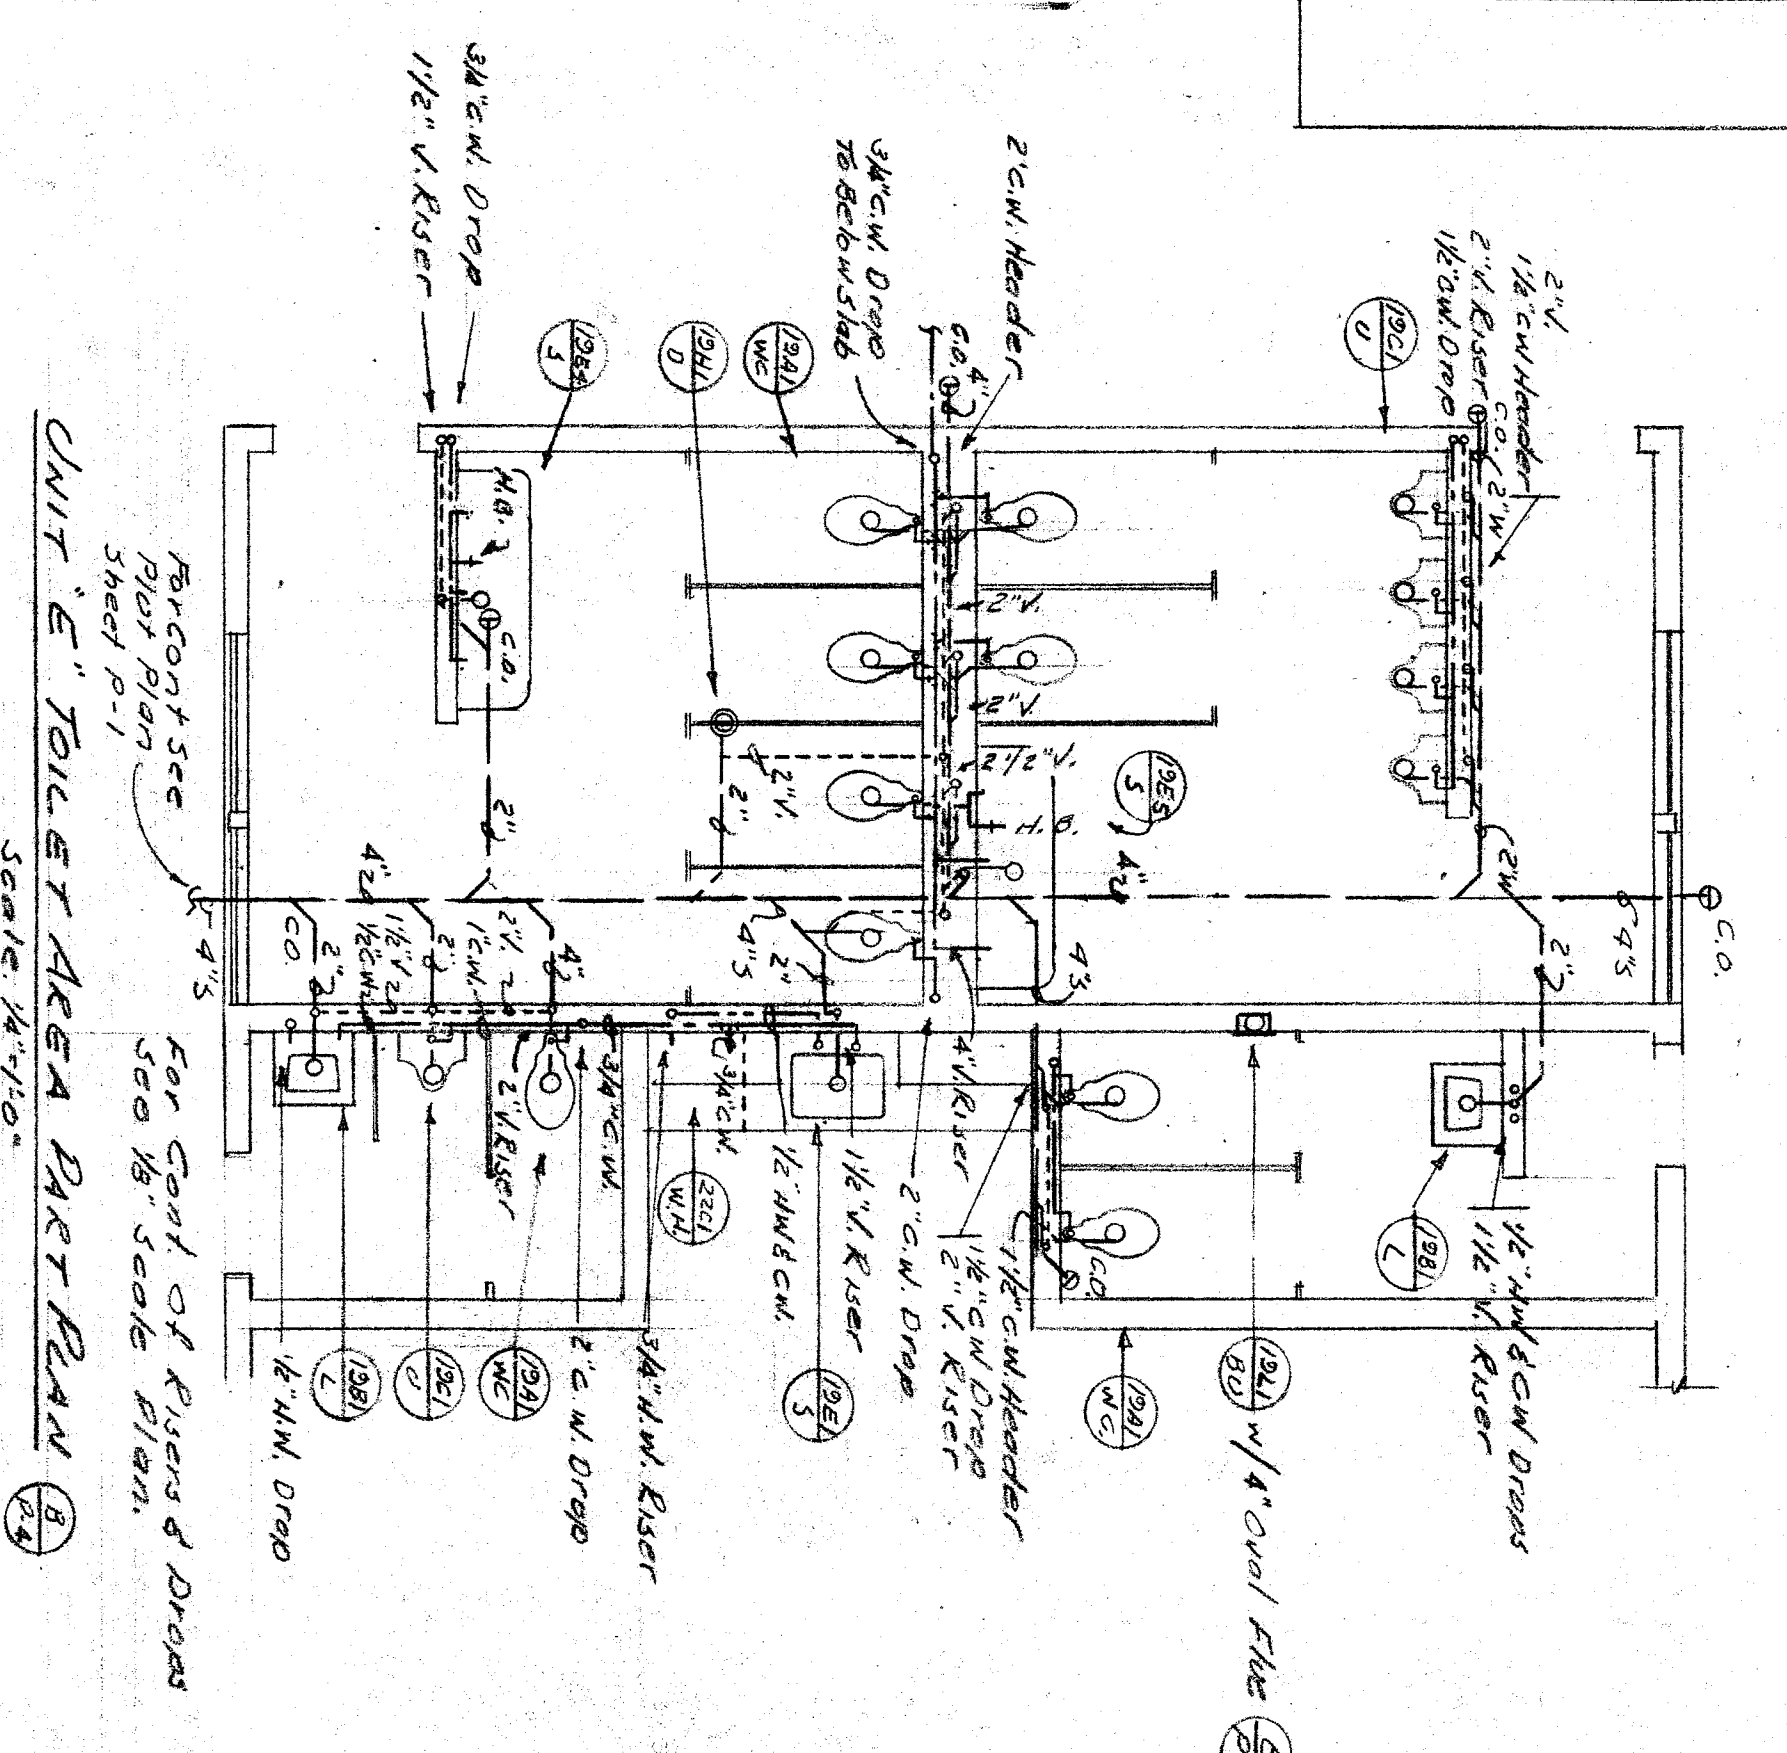

UNIT E TOILET AREA PART PLAN
 Scale: 1/8" = 1'-0"

PLUMBING PLAN, PART PLAN — UNITS E, F

OFFICE OF SUPERINTENDENT OF SCHOOLS STATE OF CALIFORNIA DEPARTMENT OF PUBLIC WORKS DIVISION OF ARCHITECTURE	STATE OF CALIFORNIA DEPARTMENT OF PUBLIC WORKS DIVISION OF ARCHITECTURE 17333 APPROVED JUN 6 - 1938 9	BAKERSFIELD CITY SCHOOL DISTRICT BAKERSFIELD CALIFORNIA BOARD OF EDUCATION	APPROVED BY DATE CHECK AND VERIFY ALL DIMENSIONS AND CONDITIONS AT JOB SITE BEFORE PROCEEDING WITH THE WORK. REPORT ANY DISCREPANCIES TO THE ARCHITECT.	HOWARD F. MACANDREWS CONSULTING ARCHITECTS 211 N. STREET BAKERSFIELD CALIFORNIA	ERNEST L. MCCOY, A.I.A. ARCHITECT 211 N. STREET BAKERSFIELD CALIFORNIA	PICO STREET SCHOOL 211 N. STREET BAKERSFIELD CALIFORNIA	SHEET NO. 10 OF 11 SHEETS
--	--	--	---	---	--	--	------------------------------