


KINDERGARTEN ELEVATION
SCALE 1/8" = 1'-0"

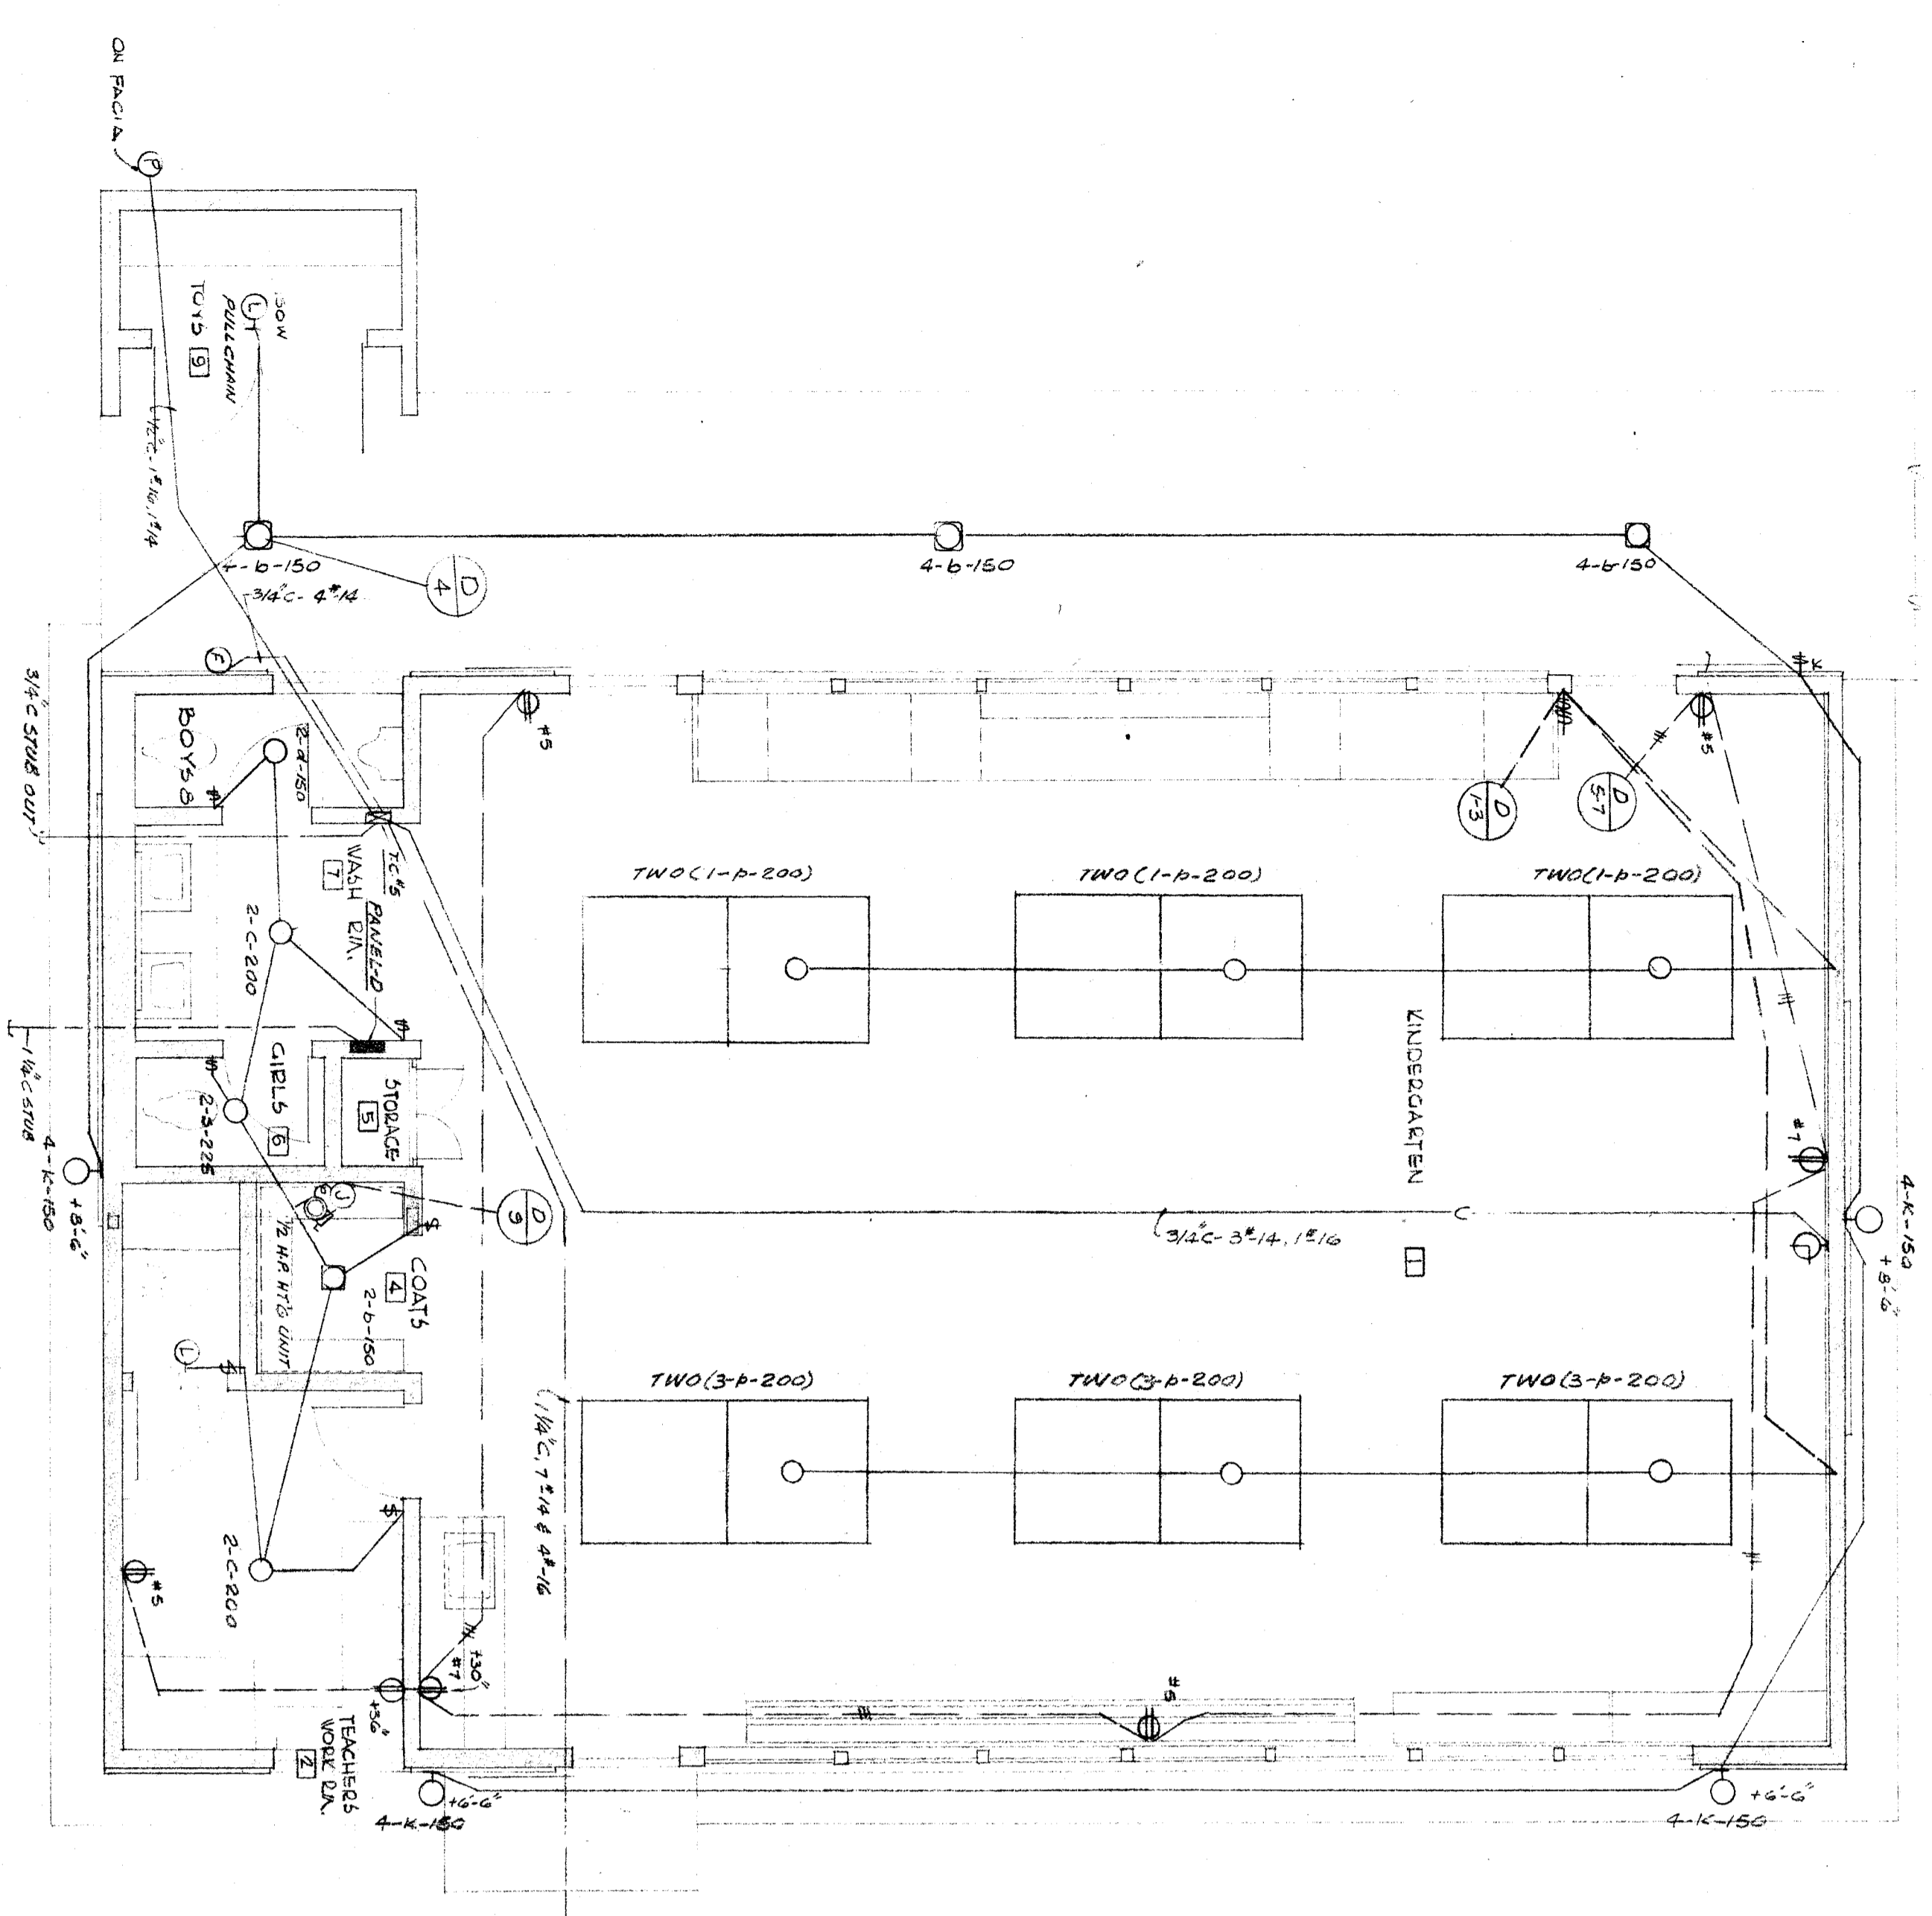

FLOOR PLAN UNIT A
SCALE 1/8" = 1'-0"

PANEL D SCHEDULE				SCALE 1/8" = 1'-0"	
CIRC NO	QTY	WATT	CIRC	REMARKS	
1	1200	200	LITERS		
2	1200	200	LITERS		
3	1200	200	LITERS		
100	1200	200	LITERS		
TOTAL	670	1500	5750		

KEY PLAN
SCALE 1/8" = 1'-0"

CHECK AND VERIFY ALL DIMENSIONS BEFORE PROCEEDING WITH THE WORK. REPORT ANY DISCREPANCIES TO THE ARCHITECT.

STATE OF CALIFORNIA - DEPARTMENT OF PUBLIC WORKS
 ARCHITECTURE DIVISION - DIVISION OF ARCHITECTURE
 PROJECT NO. 13-1323
 DATE 11/1/82
 DRAWN BY [Signature]
 CHECKED BY [Signature]
 DATE JUN 17 1983

APPROVED BY [Signature]
 BAKERSFIELD CITY SCHOOL DISTRICT
 DATE JUN 23 1983

EDWARD A. ANDERSON
 ELECTRICAL ENGINEER
 1000 W. 10TH ST.
 BAKERSFIELD, CALIF. 93311

ARCHITECTS
 SLACK AND PICKLE
 BAKERSFIELD
 CALIFORNIA

KINDERGARTEN BLDG. UNIT A
 LIGHTING POWER AND SIGNAL
 SECTION 35 SCHOOL
 BAKERSFIELD CITY SCHOOL DISTRICT
 BAKERSFIELD
 KERN COUNTY
 CALIFORNIA

2 of 5
 SHEET NUMBER