


WILLIS AVENUE

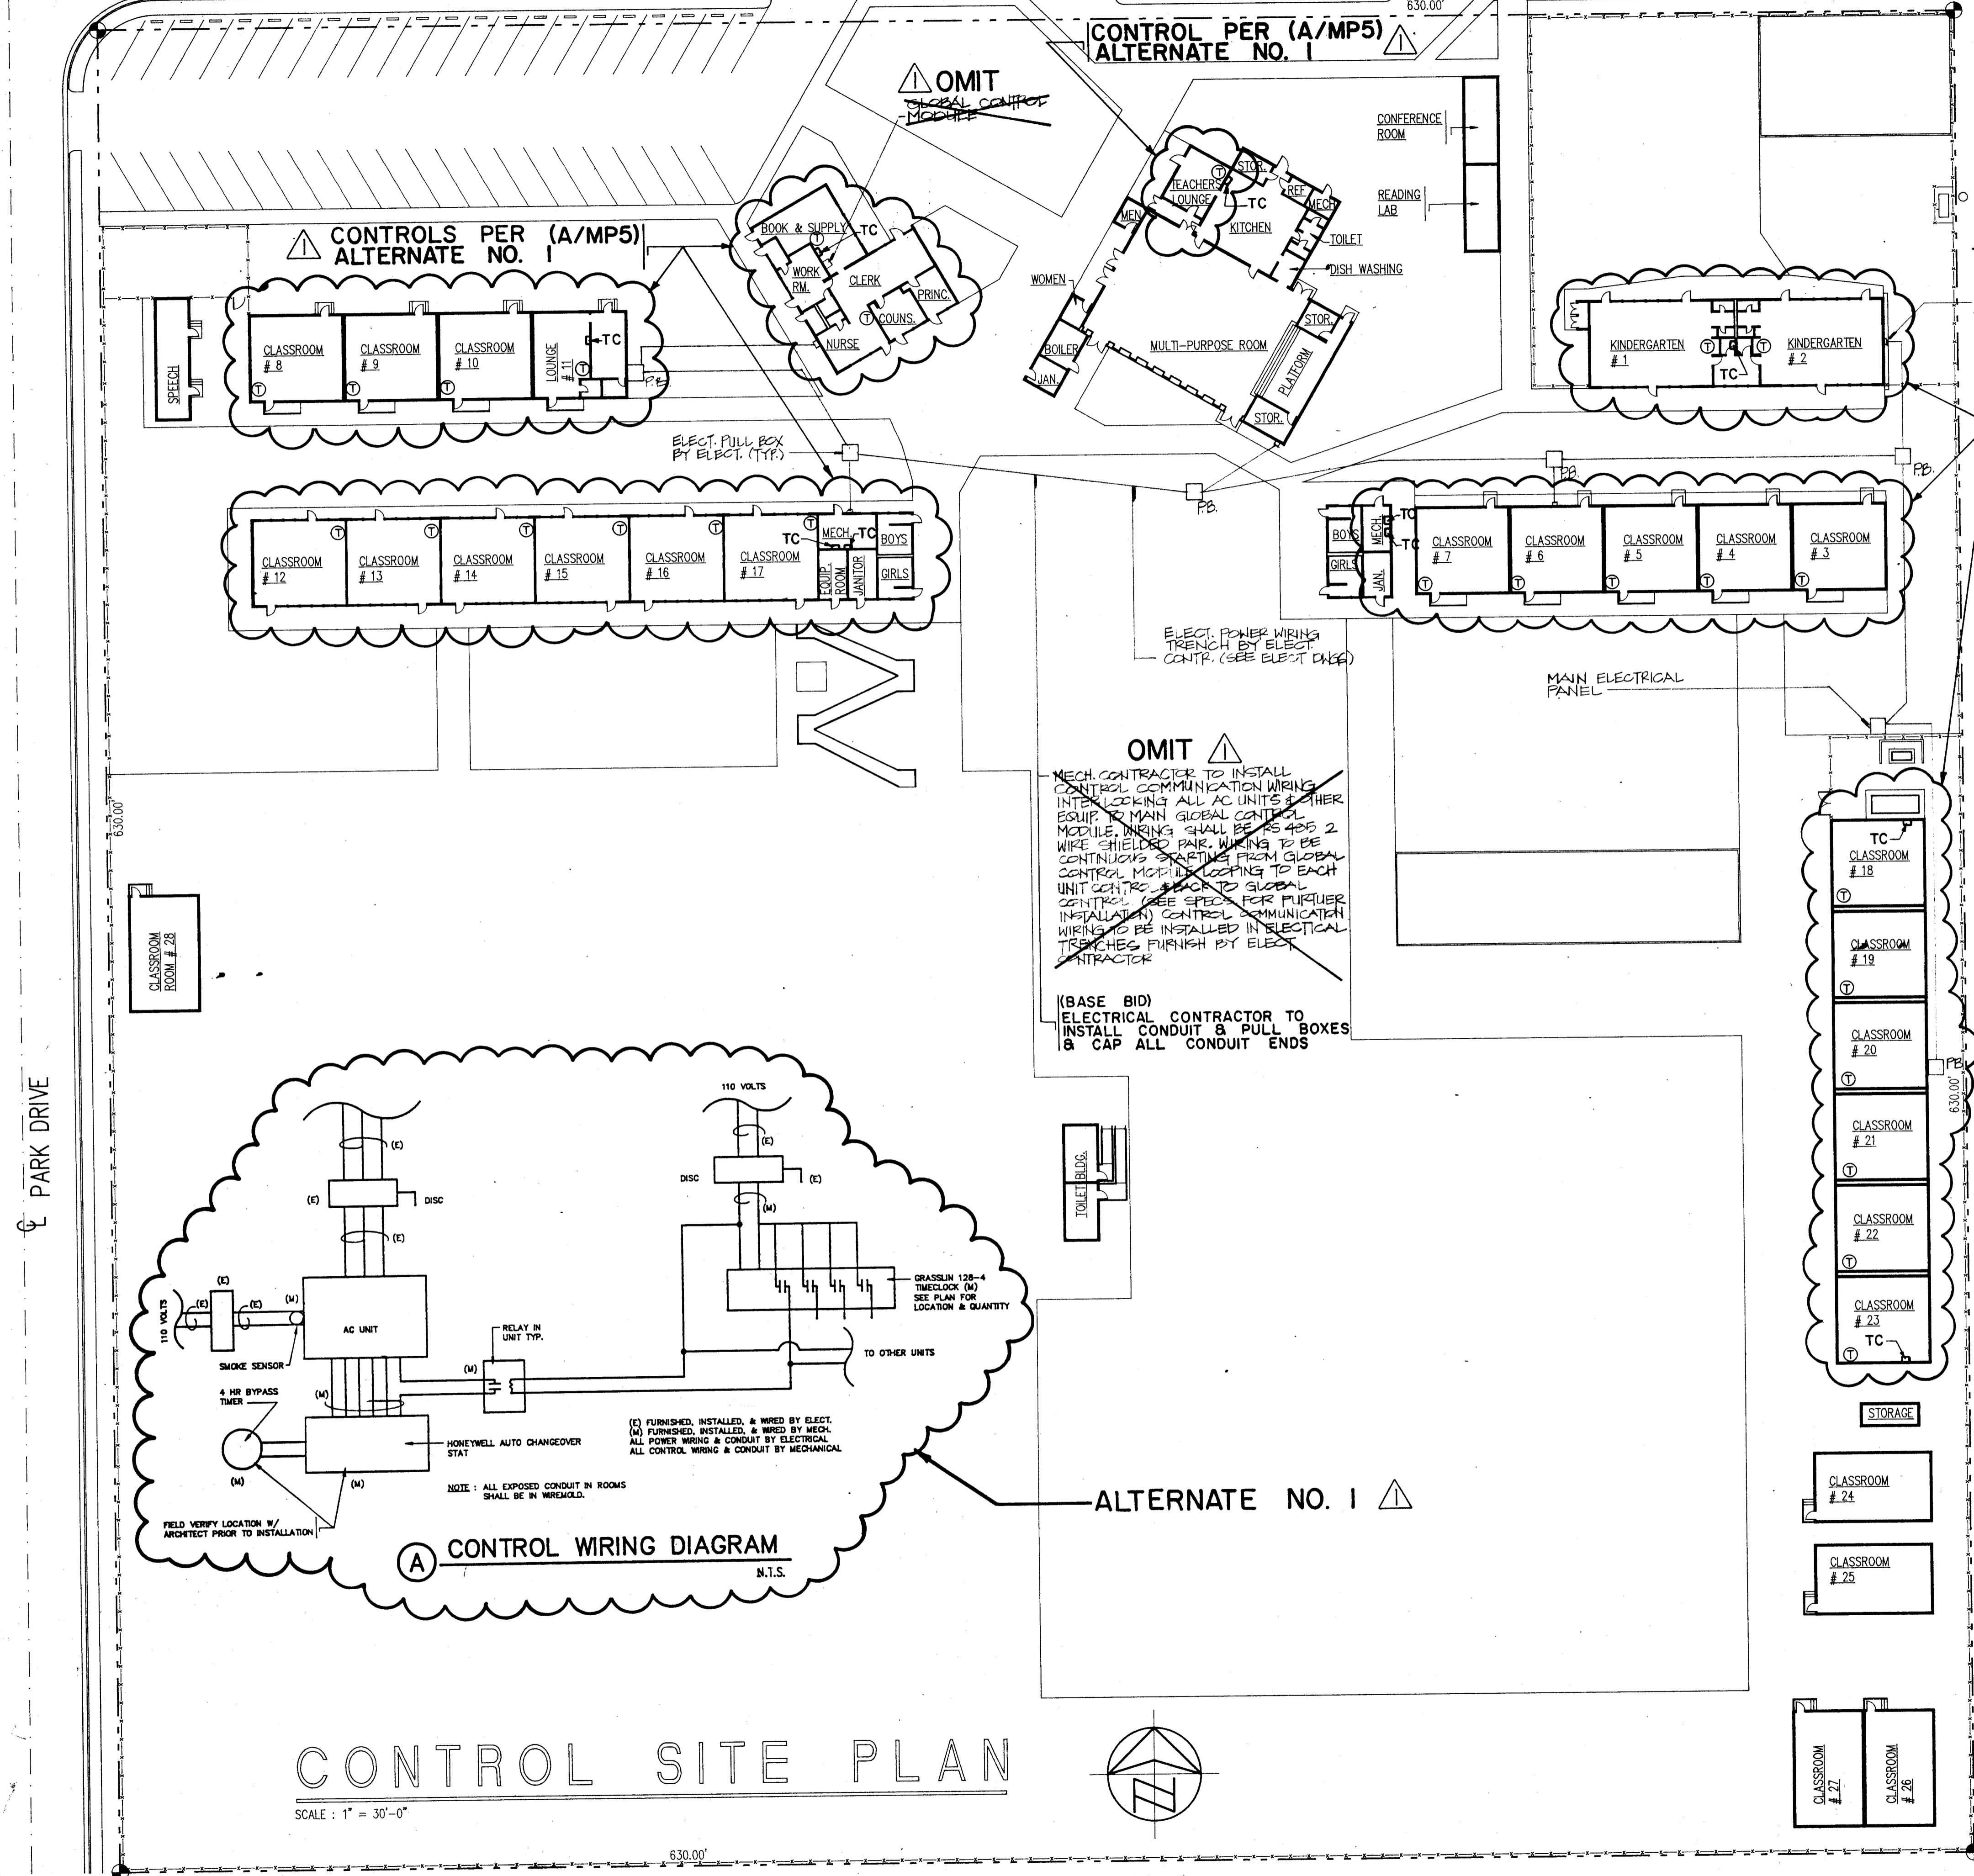


~~OMIT~~
CENTRAL COMMUNICATION WIRING TO RISE FROM BELOW FLOOR IN CONDUIT & EXTEND TO UNITS (TYP)

CONTROLS PER (A/MP5) ALTERNATE NO. 1


~~OMIT~~
MECH. CONTRACTOR TO INSTALL CONTROL COMMUNICATION WIRING INTERLOCKING ALL AC UNITS & OTHER EQUIP. TO MAIN GLOBAL CONTROL MODULE. WIRING SHALL BE AS 405 2 WIRE SHIELDED PAIR. WIRING TO BE CONTINUOUS & RATING FROM GLOBAL CONTROL MODULE TO EACH UNIT CENTER & BACK TO GLOBAL CONTROL. (SEE SPEC. FOR FURTHER INSTALLATION) CONTROL COMMUNICATION WIRING TO BE INSTALLED IN ELECTRICAL TRENCHES FURNISH BY ELECT. CONTRACTOR

(BASE BID) ELECTRICAL CONTRACTOR TO INSTALL CONDUIT & PULL BOXES & CAP ALL CONDUIT ENDS

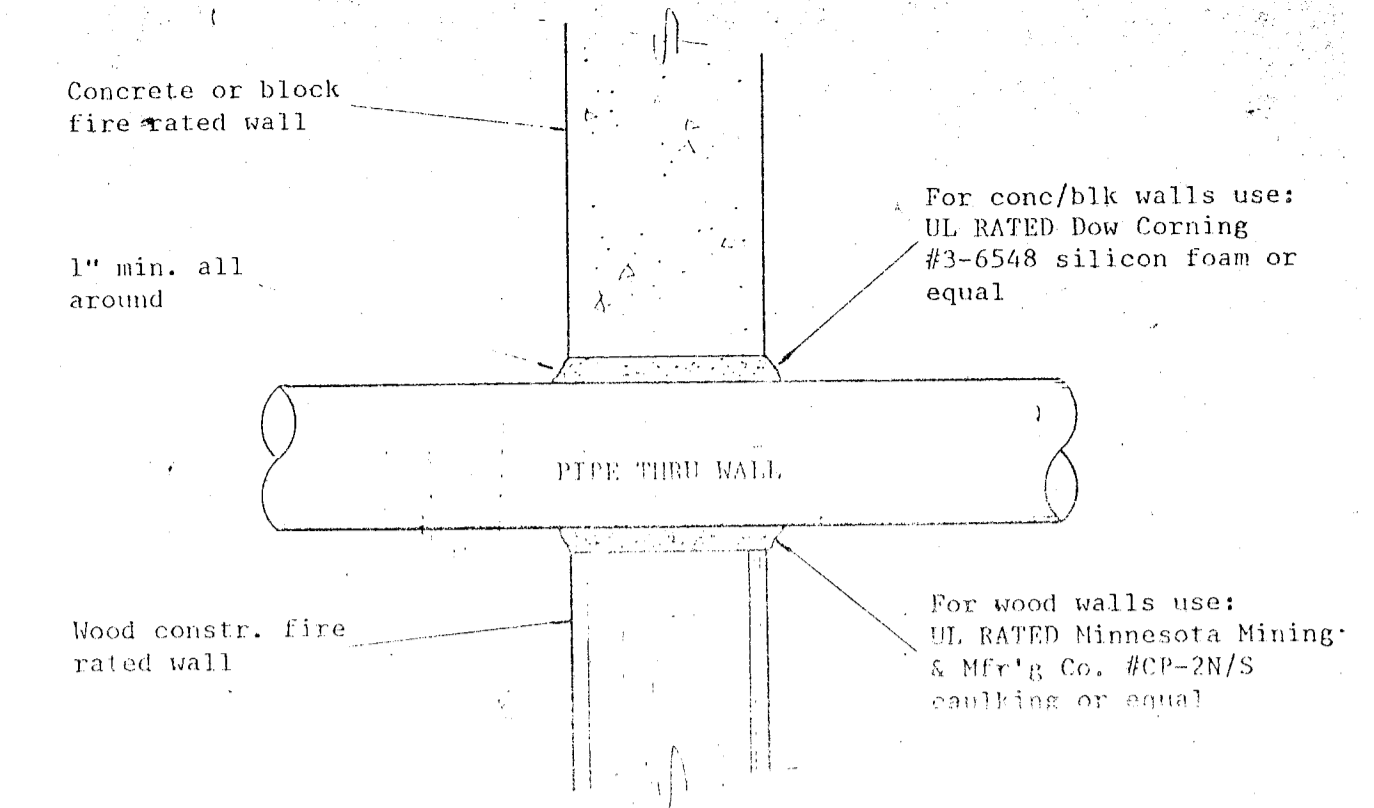


FIRE STOPPING REQUIREMENT
Penetrations thru rated walls and floors shall be sealed with a material capable of preventing the passage of flames and hot gasses when subjected to the requirements of the Test Standard specific for Fire Stops ASTM-E-814.

PIPE PENETRATION THRU WALL

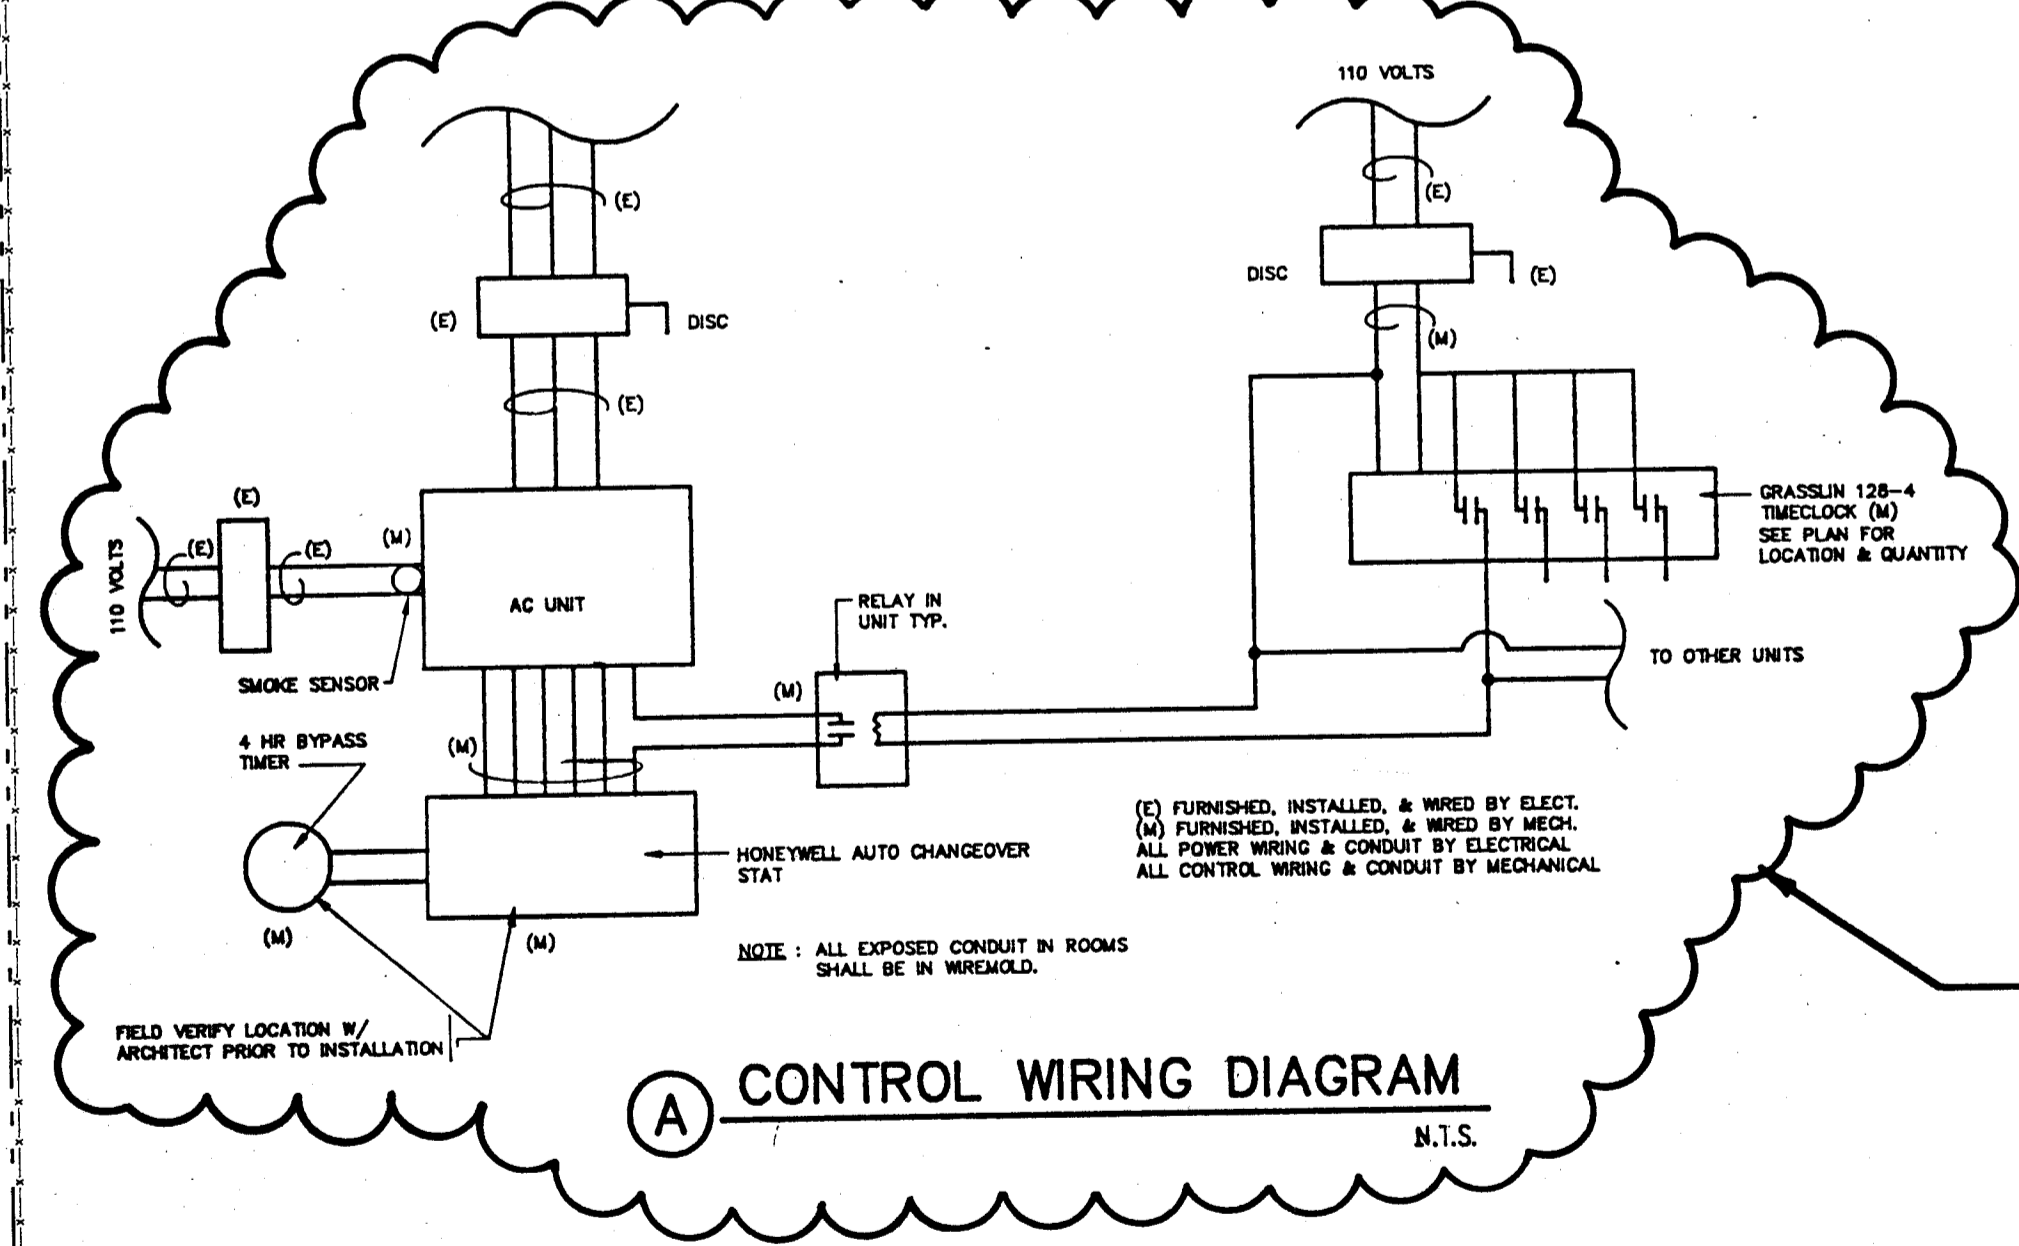


(A) CONTROL WIRING DIAGRAM
N.T.S.

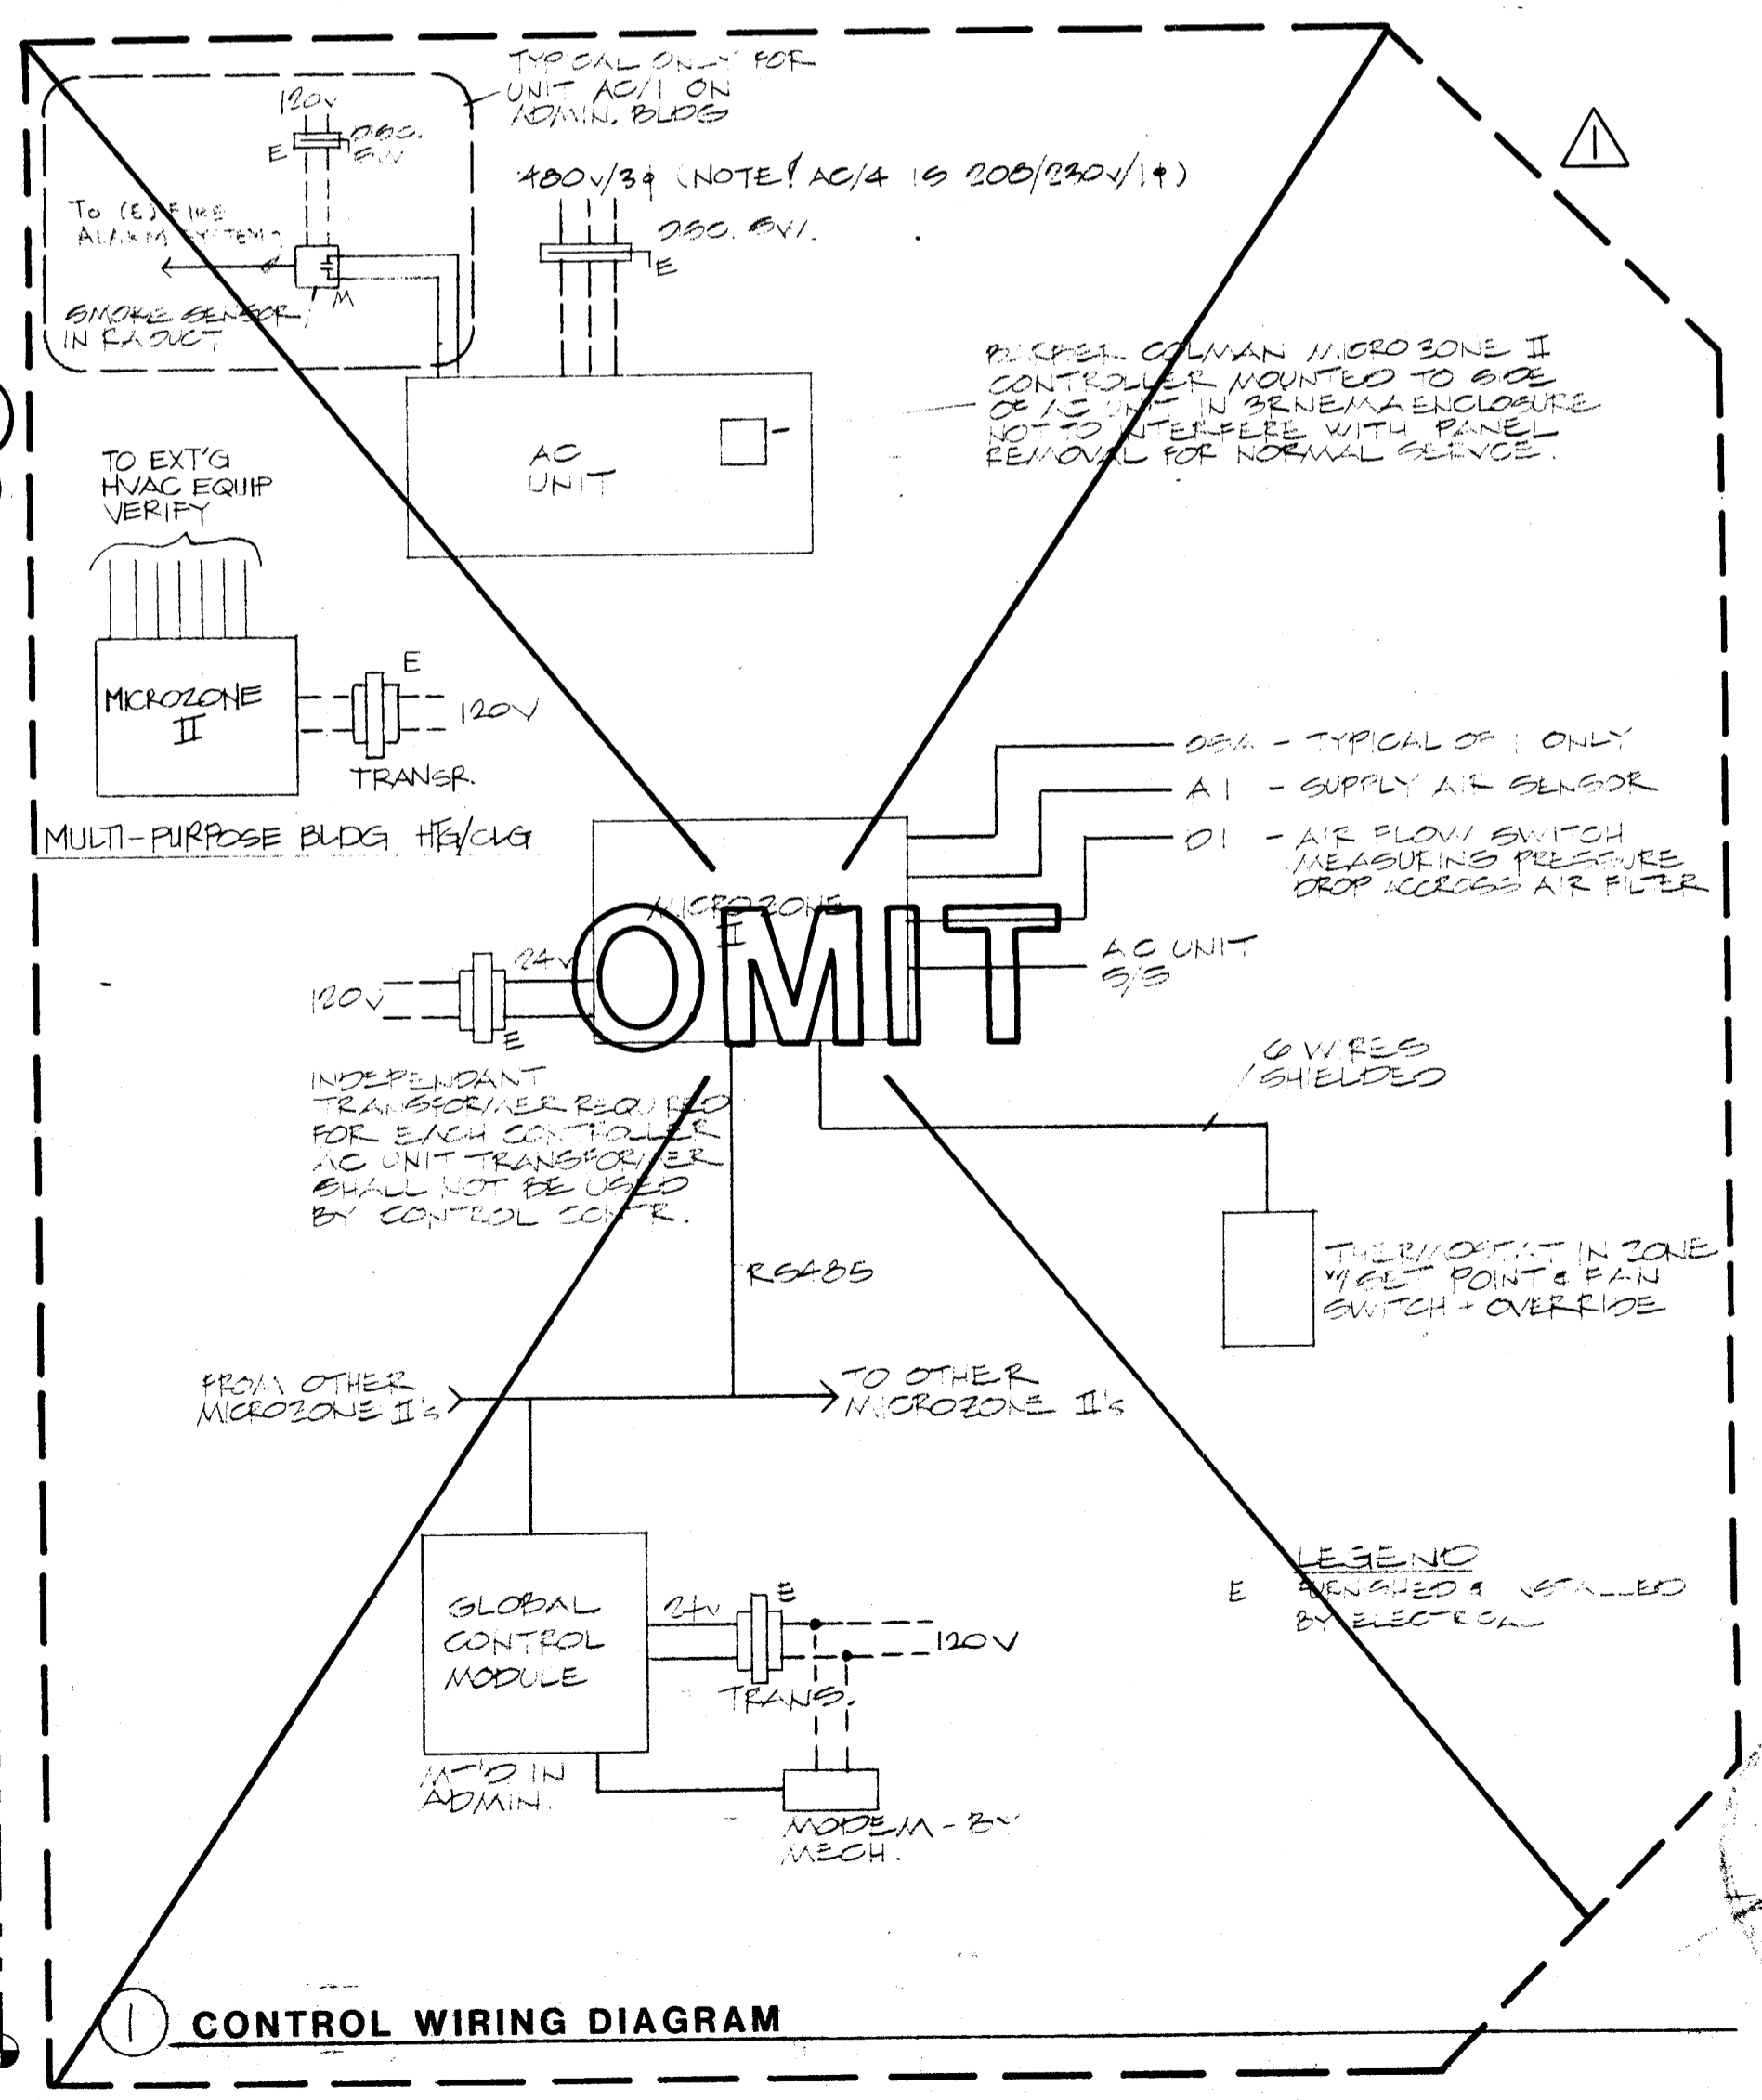

(B) CONTROL WIRING DIAGRAM

CONTROL SITE PLAN

SCALE: 1" = 30'-0"

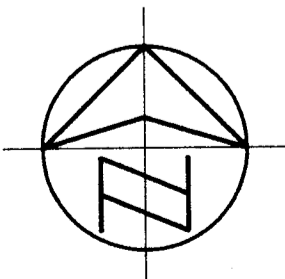

ADDENDUM		4-29-91	
NO.	REVISION	DATE	BY
FIRE MARSHAL			
O.S.A.			

Glenn Hartzell A.I.A.
 ARCHITECT
 26 "H" STREET, 93304
 P.O. BOX 2344, 93303, BAKERSFIELD, CALIFORNIA
 (805) 324-6416
 No. C-10298
 OCT 31 1991
 SHEET NO. ADI-1-MP5
 SHEET 5 OF 6
 DATE

BAKERSFIELD CITY SCHOOL DISTRICT
 BY RESOLUTION OF THE BOARD OF TRUSTEES
 APPROVED:

DATE DRAWN G.S.

(AIR CONDITIONING)
 HORT SCHOOL
 BAKERSFIELD CITY SCHOOL DISTRICT
 2301 PARK DRIVE, BAKERSFIELD, CALIFORNIA

JOB NO. 142
 SHEET NO. ADI-1-MP5
 SHEET 5 OF 6