




BUILDING "A" DEMOLITION PLAN

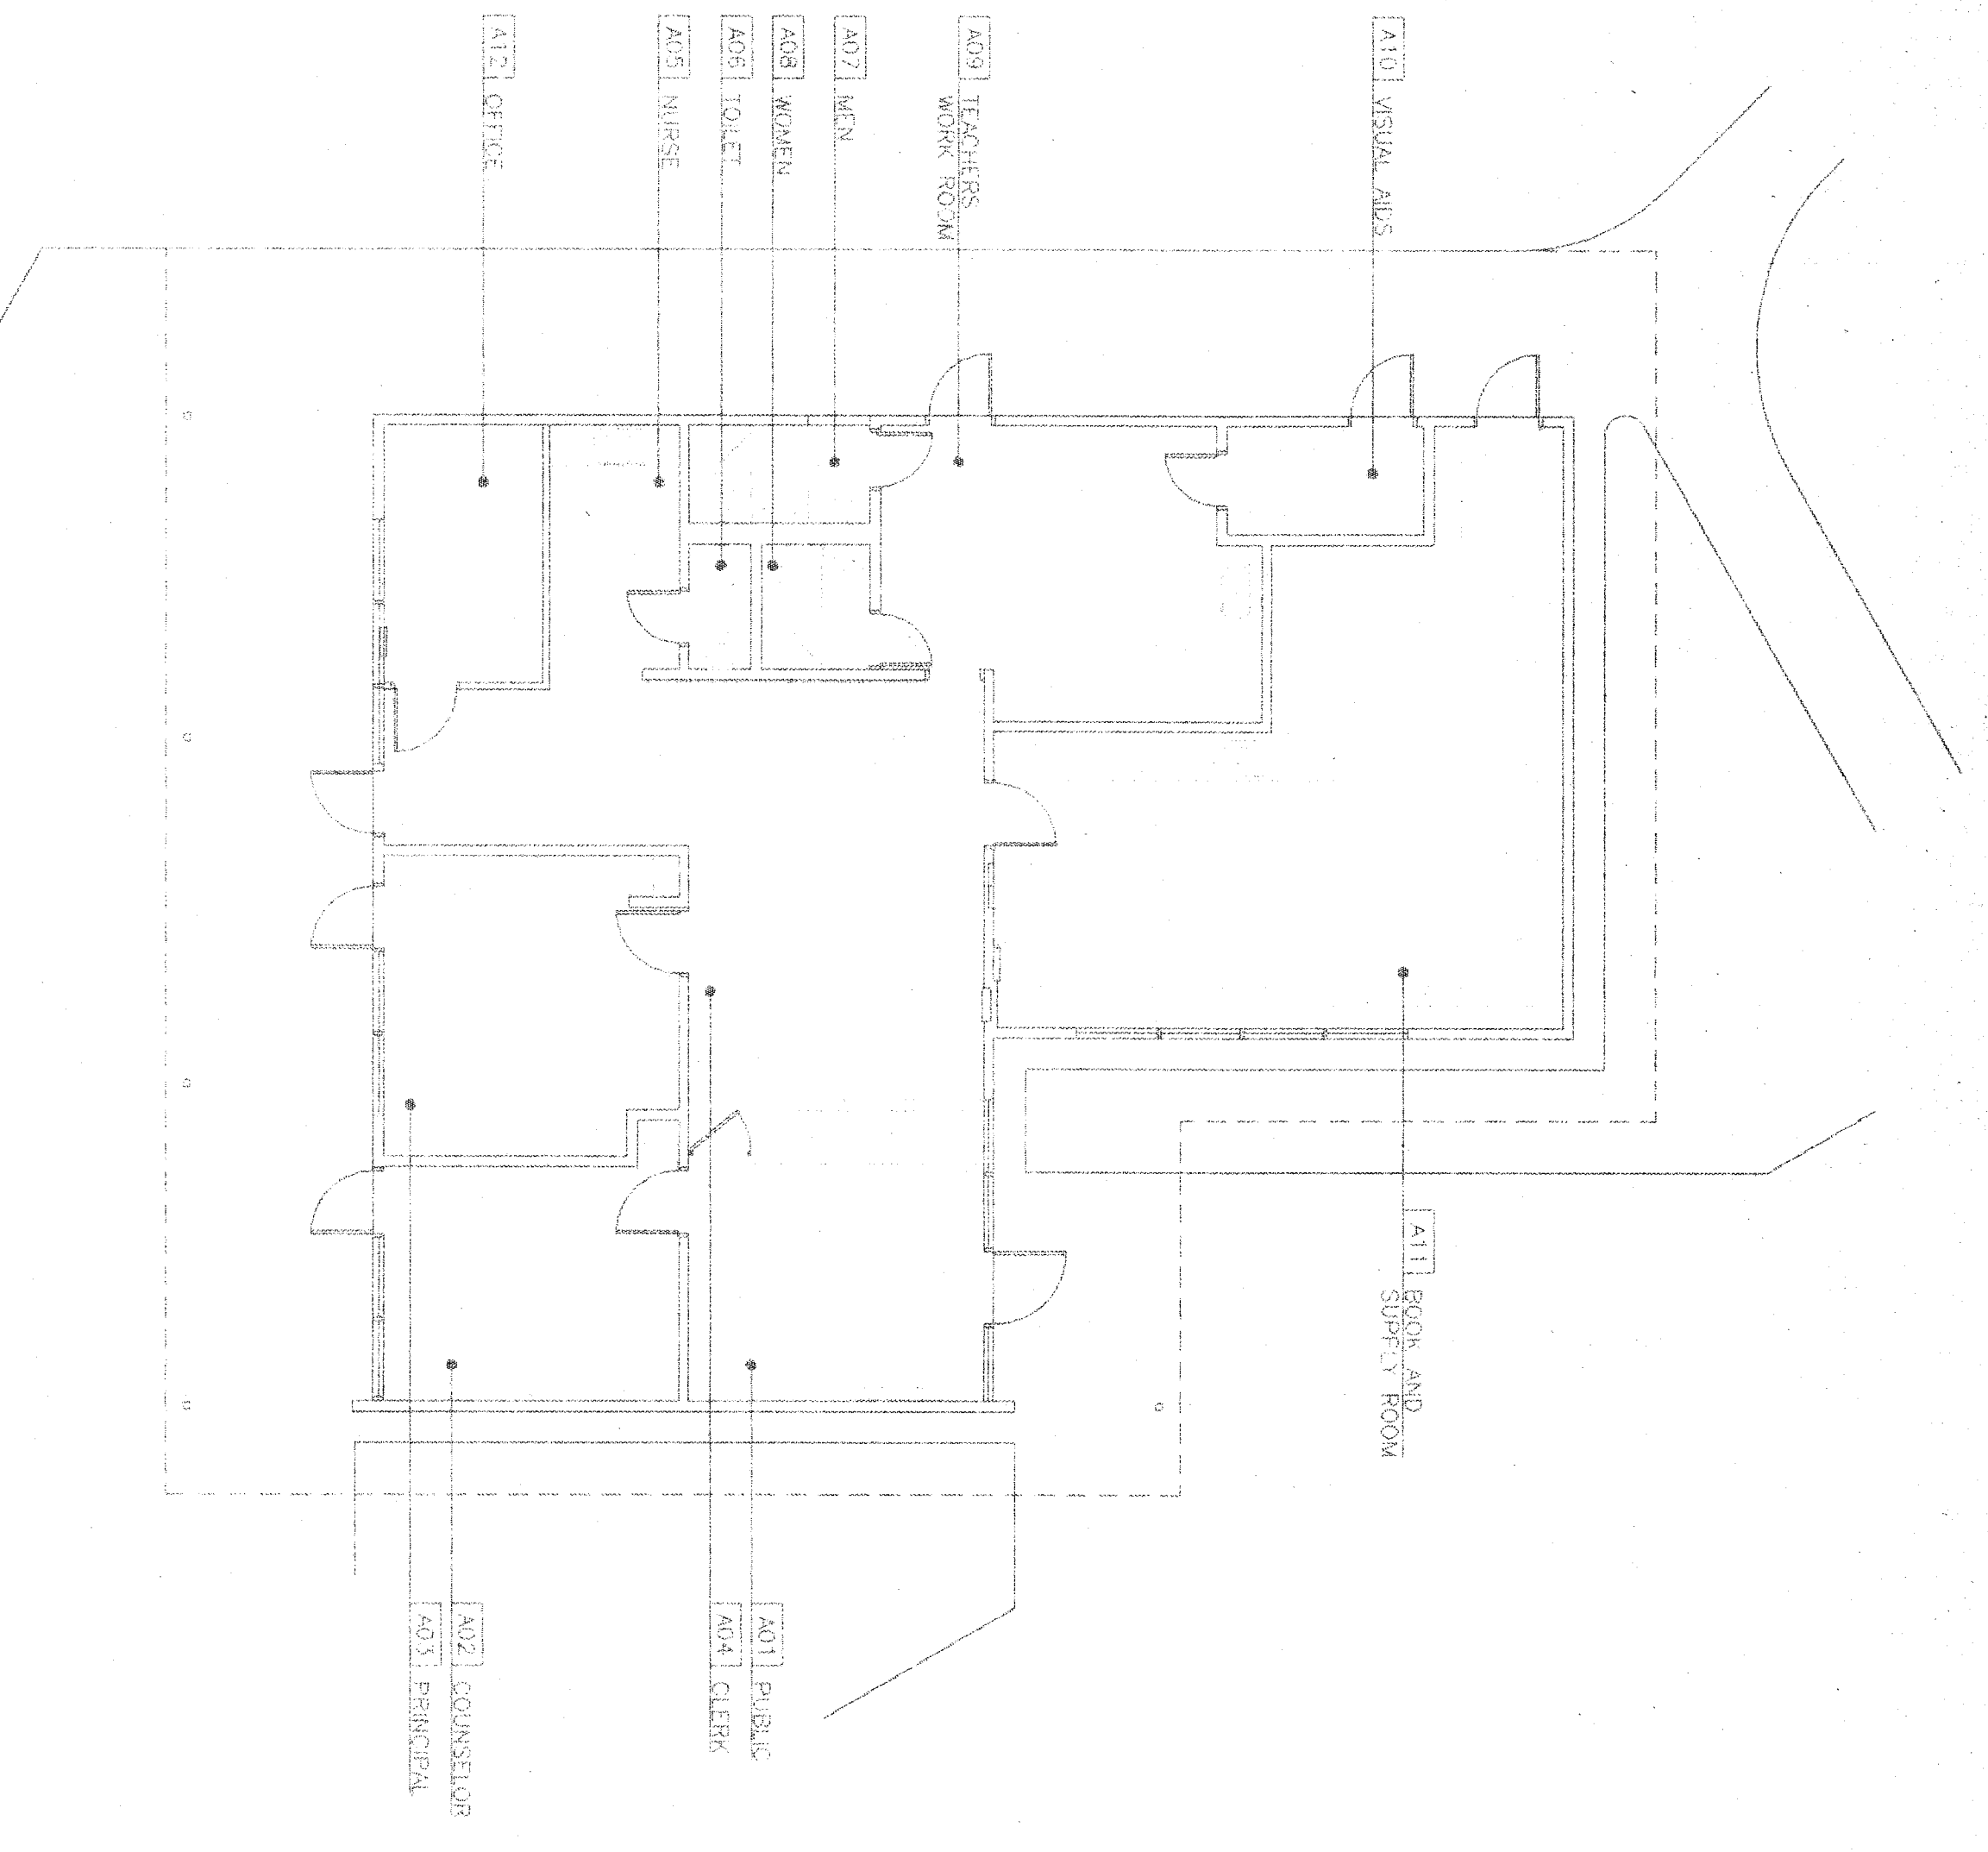

BUILDING "A" POWER/SIGNAL PLAN

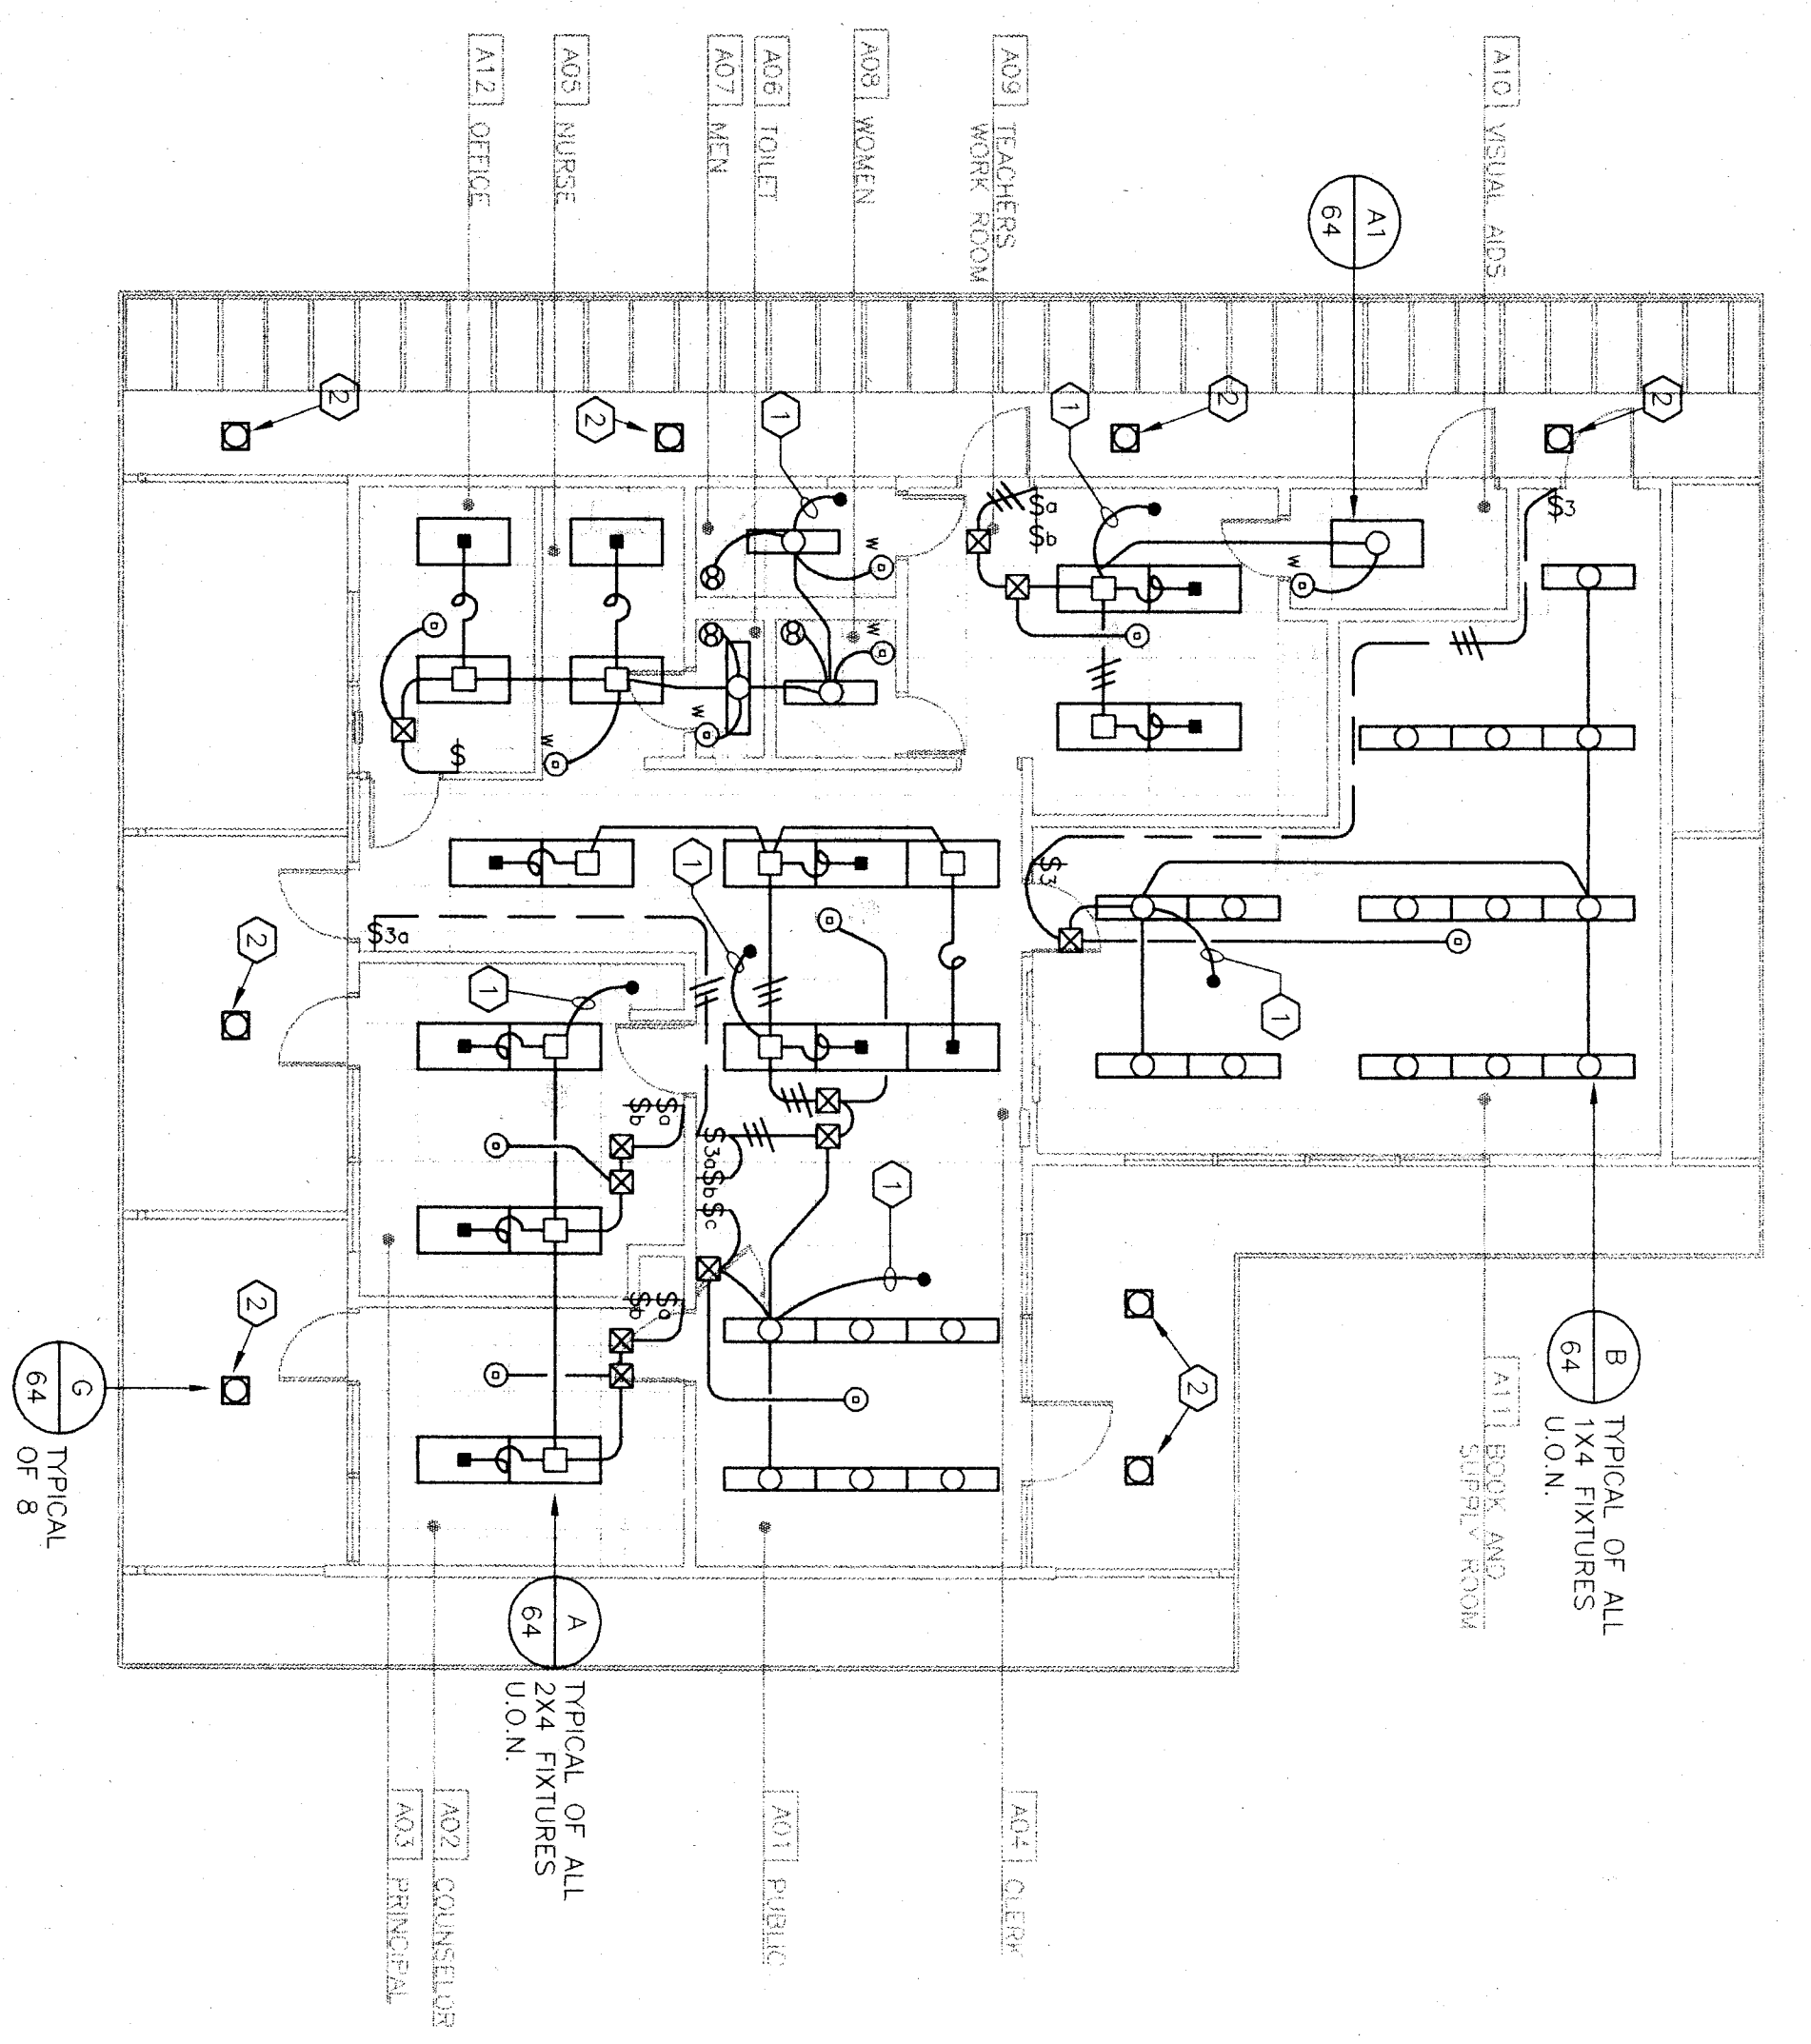


BUILDING "A" LIGHTING PLAN

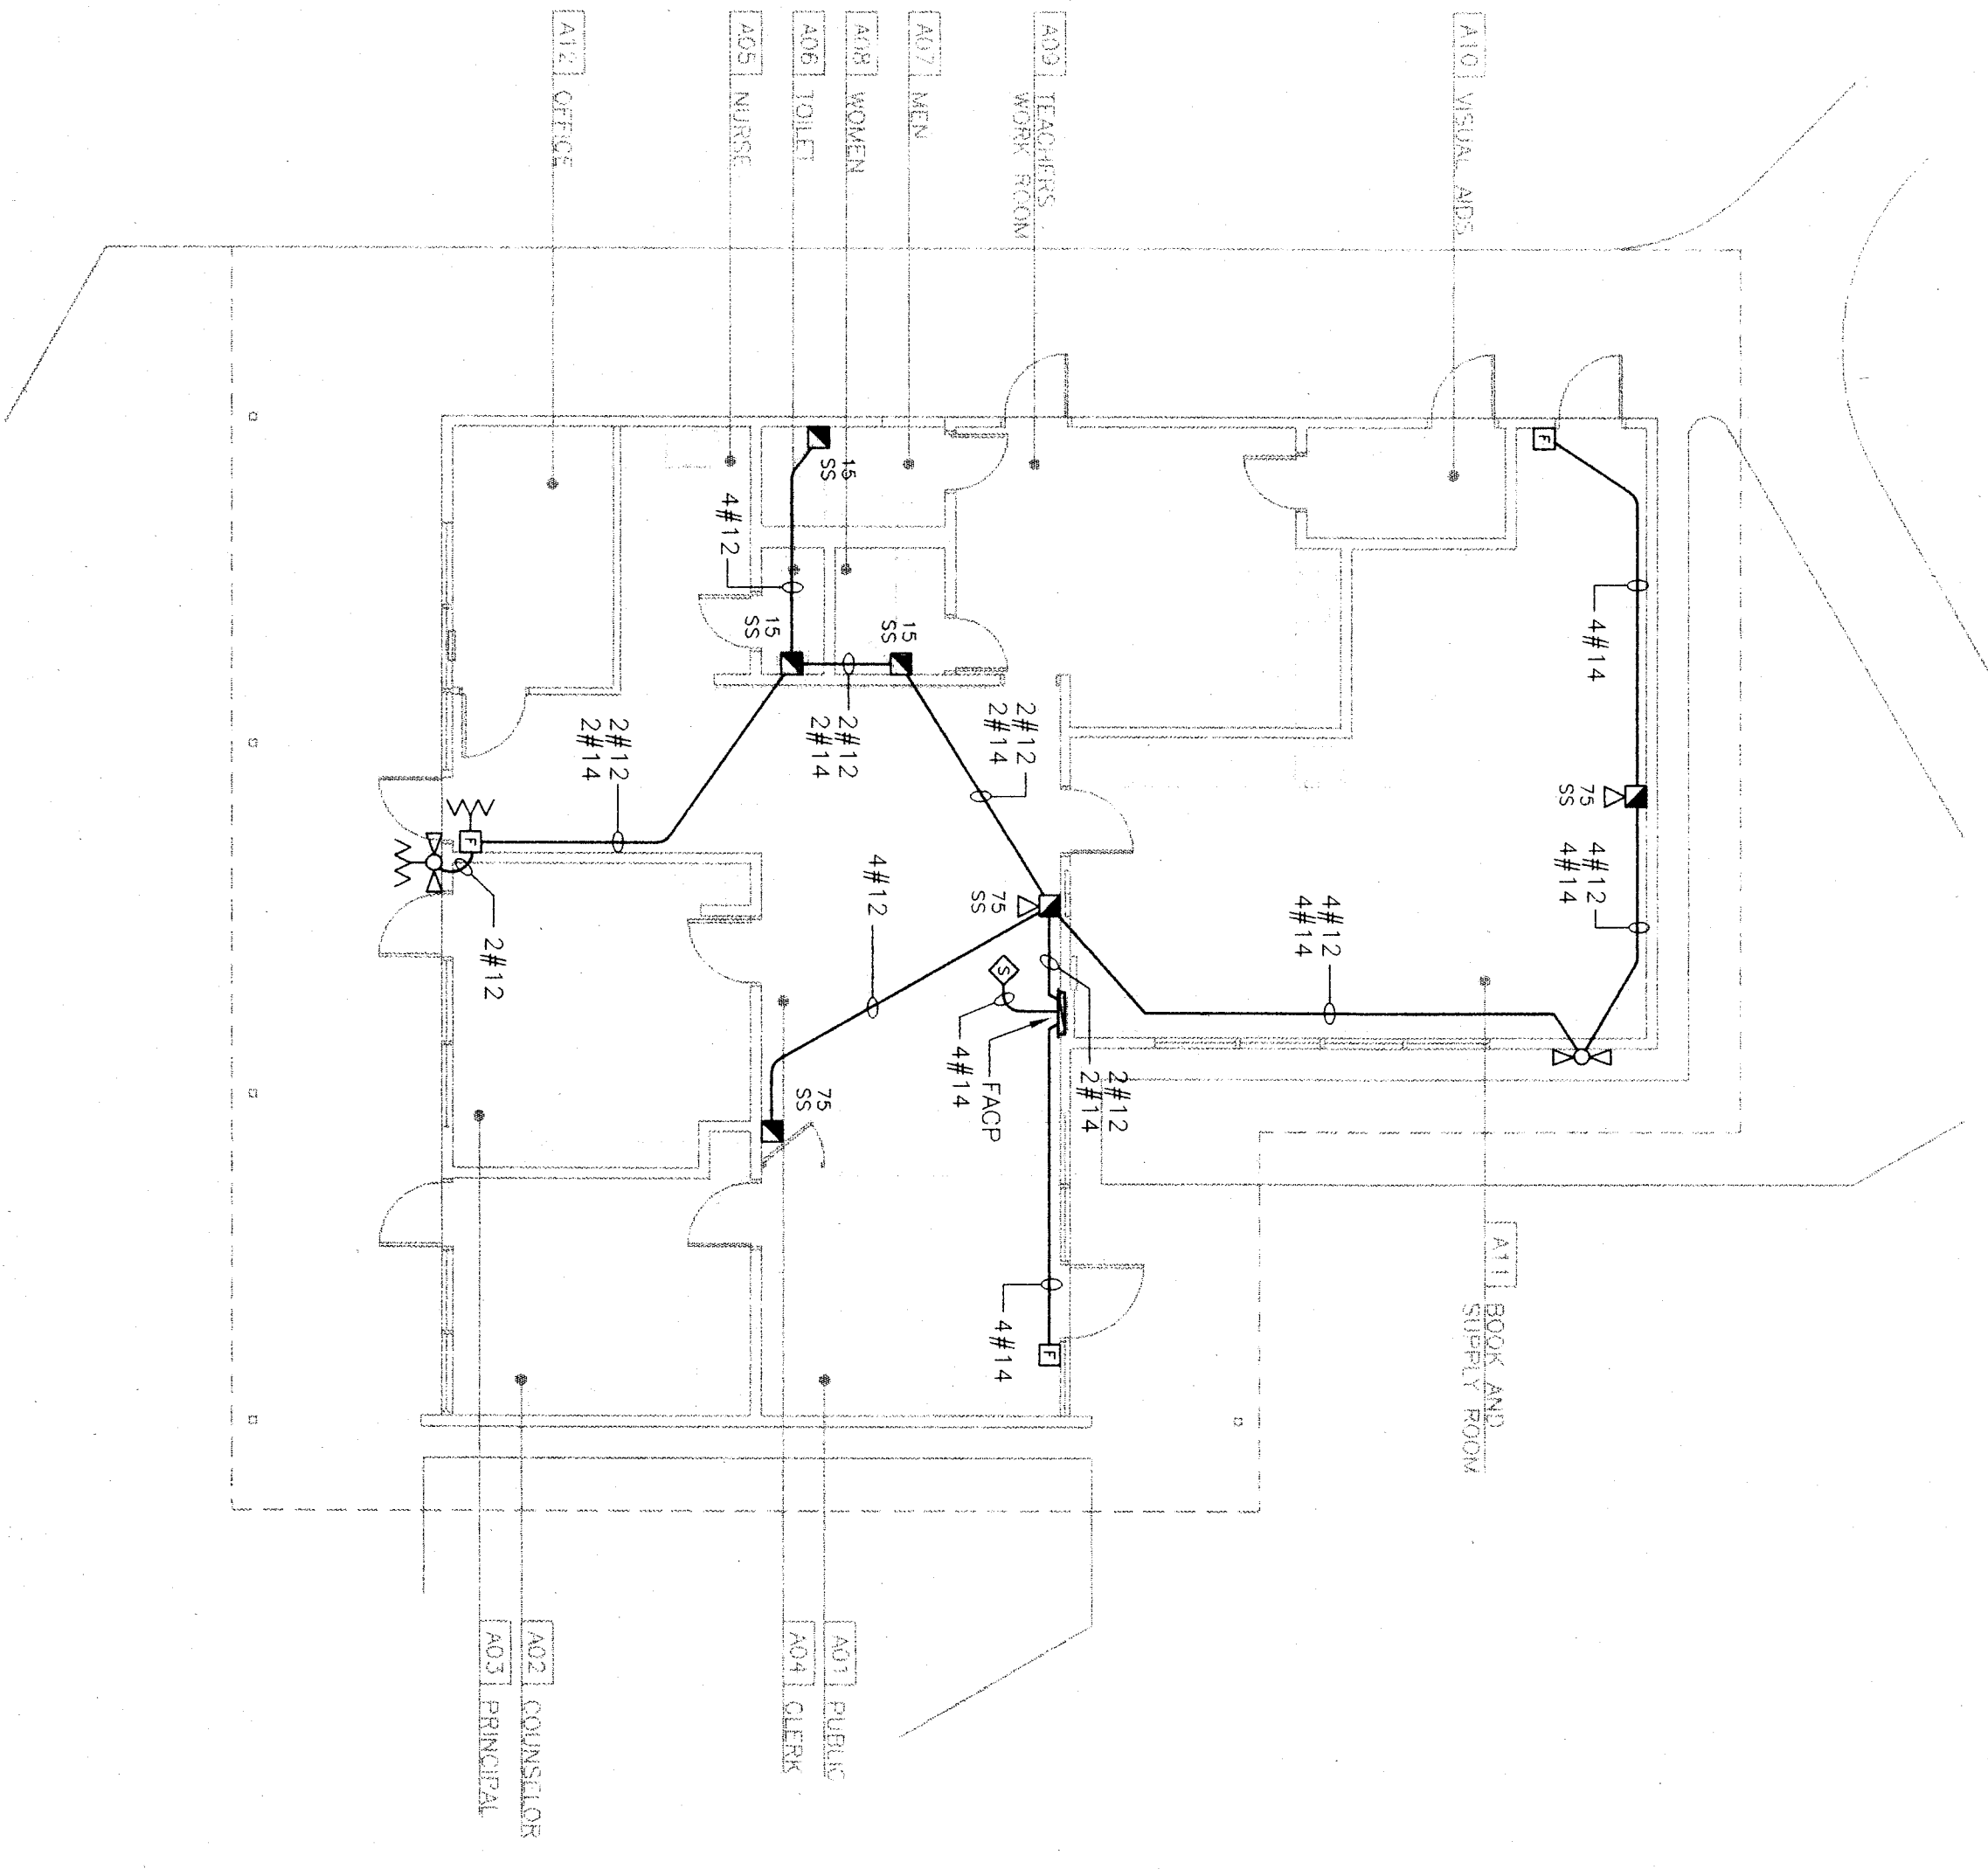


BUILDING "A" FIRE ALARM PLAN


- REFERENCE NOTES:**
- 1 INTERCEPT AND EXTEND EXISTING LIGHTING CIRCUIT AS REQUIRED.
 - 2 REPLACE EXISTING LIGHT FIXTURE W/NEW AS REQUIRED.
 - 3 REMOVE ALL EXISTING LIGHT FIXTURES FOR THIS AREA. SEE LIGHTING PLAN FOR NEW LOCATIONS.
 - 4 DISCONNECT AND REMOVE ALL EXISTING ELECTRICAL WIRING NOT BEING REUSE IN THIS AREA.

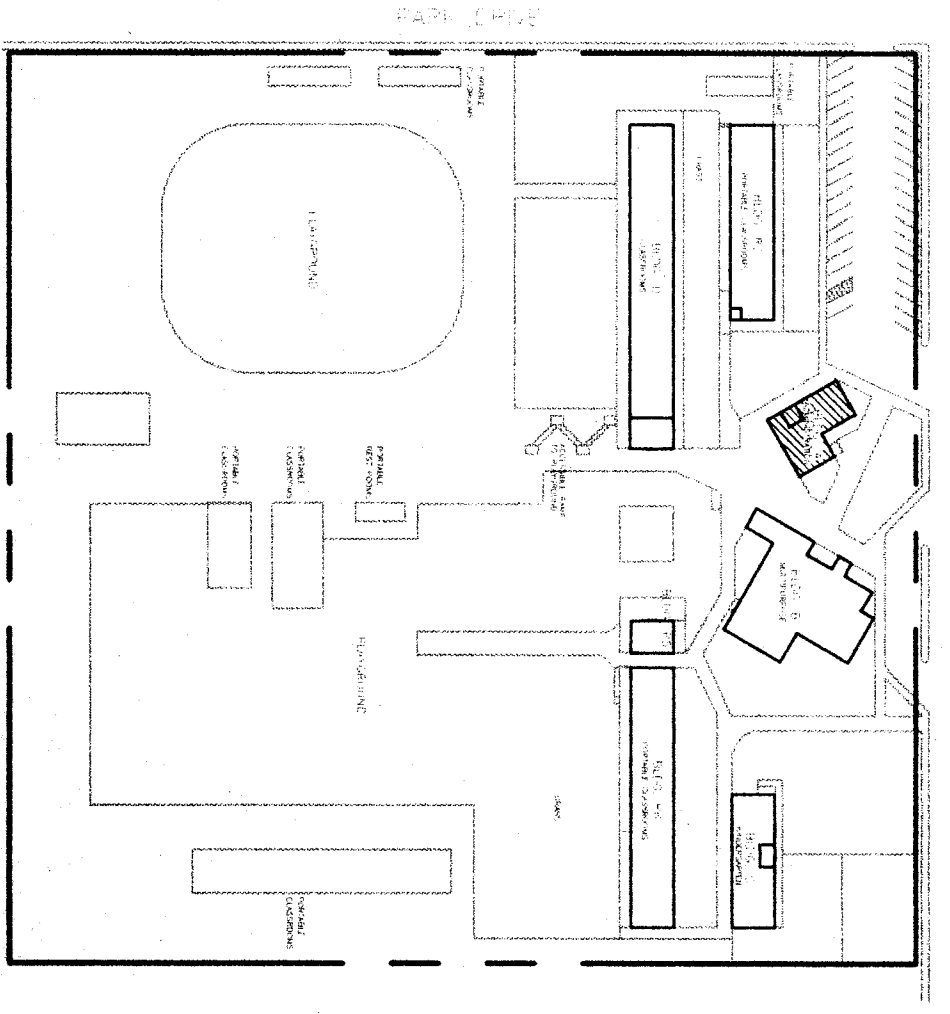

BUILDING "A" ELECTRICAL FLOOR PLAN

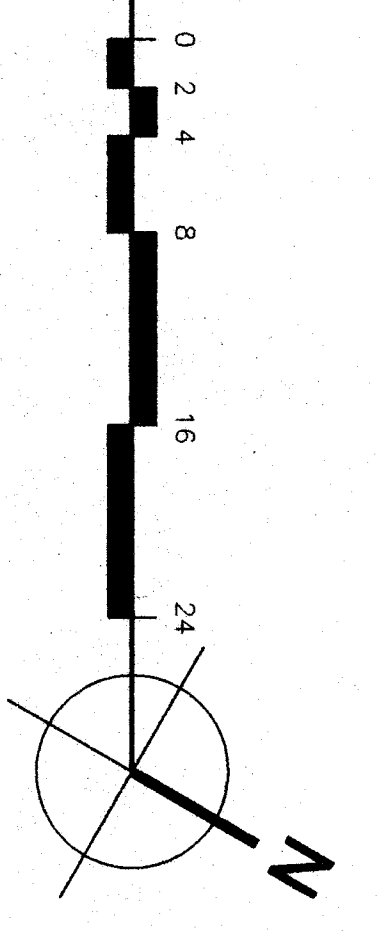

KEY PLAN

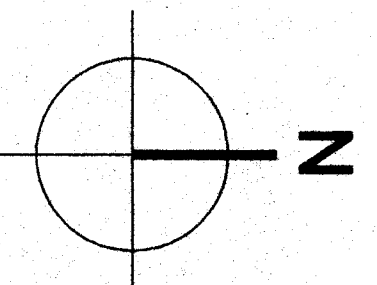

INTERSTATE ENGINEERS
 440 W. Edmond Ave., Suite 100
 Fresno, California 93711
 (209) 432-4907 / (209) 432-4914 fax
 James W. Gordon, Electrical Engineer
 EE #6101

bfgc architects planners inc.
 5500 ming avenue, suite 450, bakersfield, ca 93309-4631
 805 836-4300
 fax 805 836-4311

son luis obispo
 1211 bond street, suite 113
 son luis obispo, california 93301
 805 546-0433

son jose
 160 west south ave. st. suite 525
 son jose, california 95113
 408 924-0841

Principal architects:
 David L. Corral, AIA, C-4564, dean a. thompson, AIA, C-9190
 Ronald G. Grier, AIA, C-3132, Bruce M. Boggs, AIA, C-21334
 William F. Rowland, AIA, C-8702, Richard L. Mellon, AIA, C-8079

**HORT SCHOOL
 MODERNIZATION
 BAKERSFIELD CITY
 SCHOOL DISTRICT**

2301 PARK DRIVE
 BAKERSFIELD, CA. 93306

**BUILDING "A"
 ELECTRICAL
 FLOOR PLANS**

Job no. 97-276
 date MAY 12, 98
 drawn by C.A.
 chkd by J.W.G.
 copyright 1997

2.01