



REMOVE ALL DASHED FIXTURES
THIS AREA PREPARE PIPING TO
ACCEPT NEW FIXTURES AS SHOWN.
CAP ALL UNUSED PIPING BEHIND SURFACES.


PLUMBING DEMOLITION PLAN (BUILDING C)
SCALE: 1/8" = 1'-0"

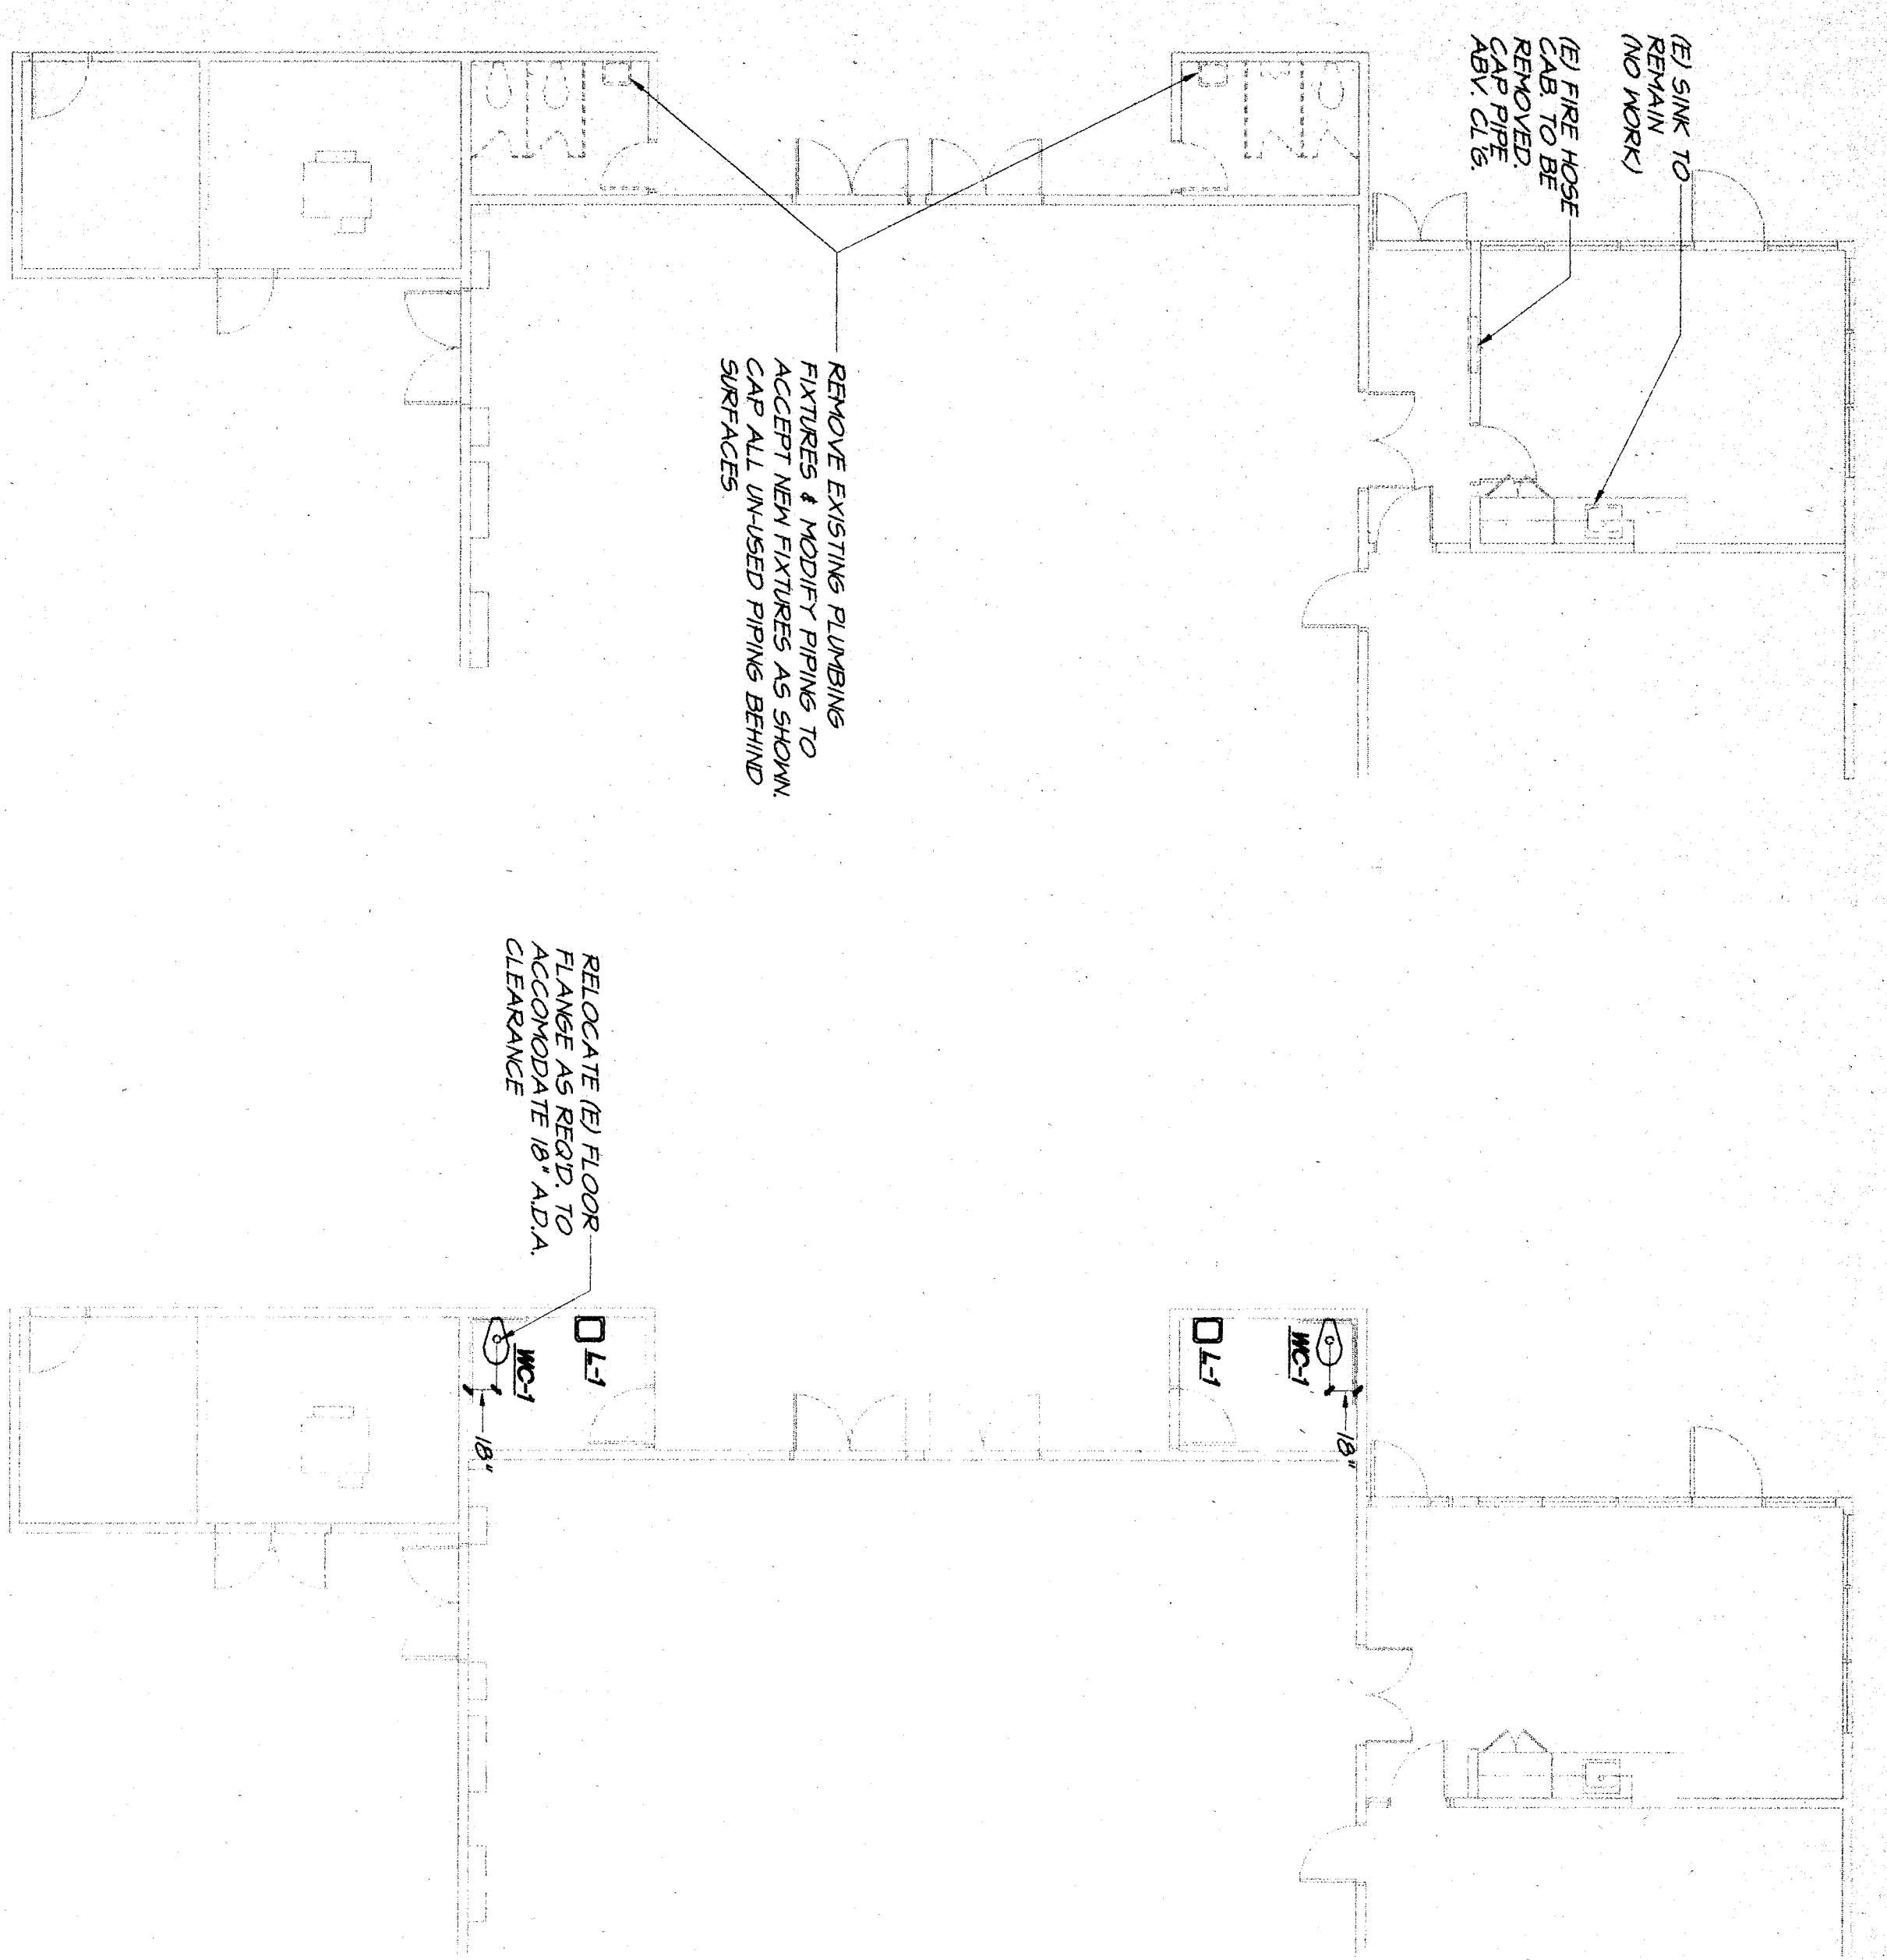

PLUMBING F.P. (BLD.G. B)
SCALE: 1/8" = 1'-0"

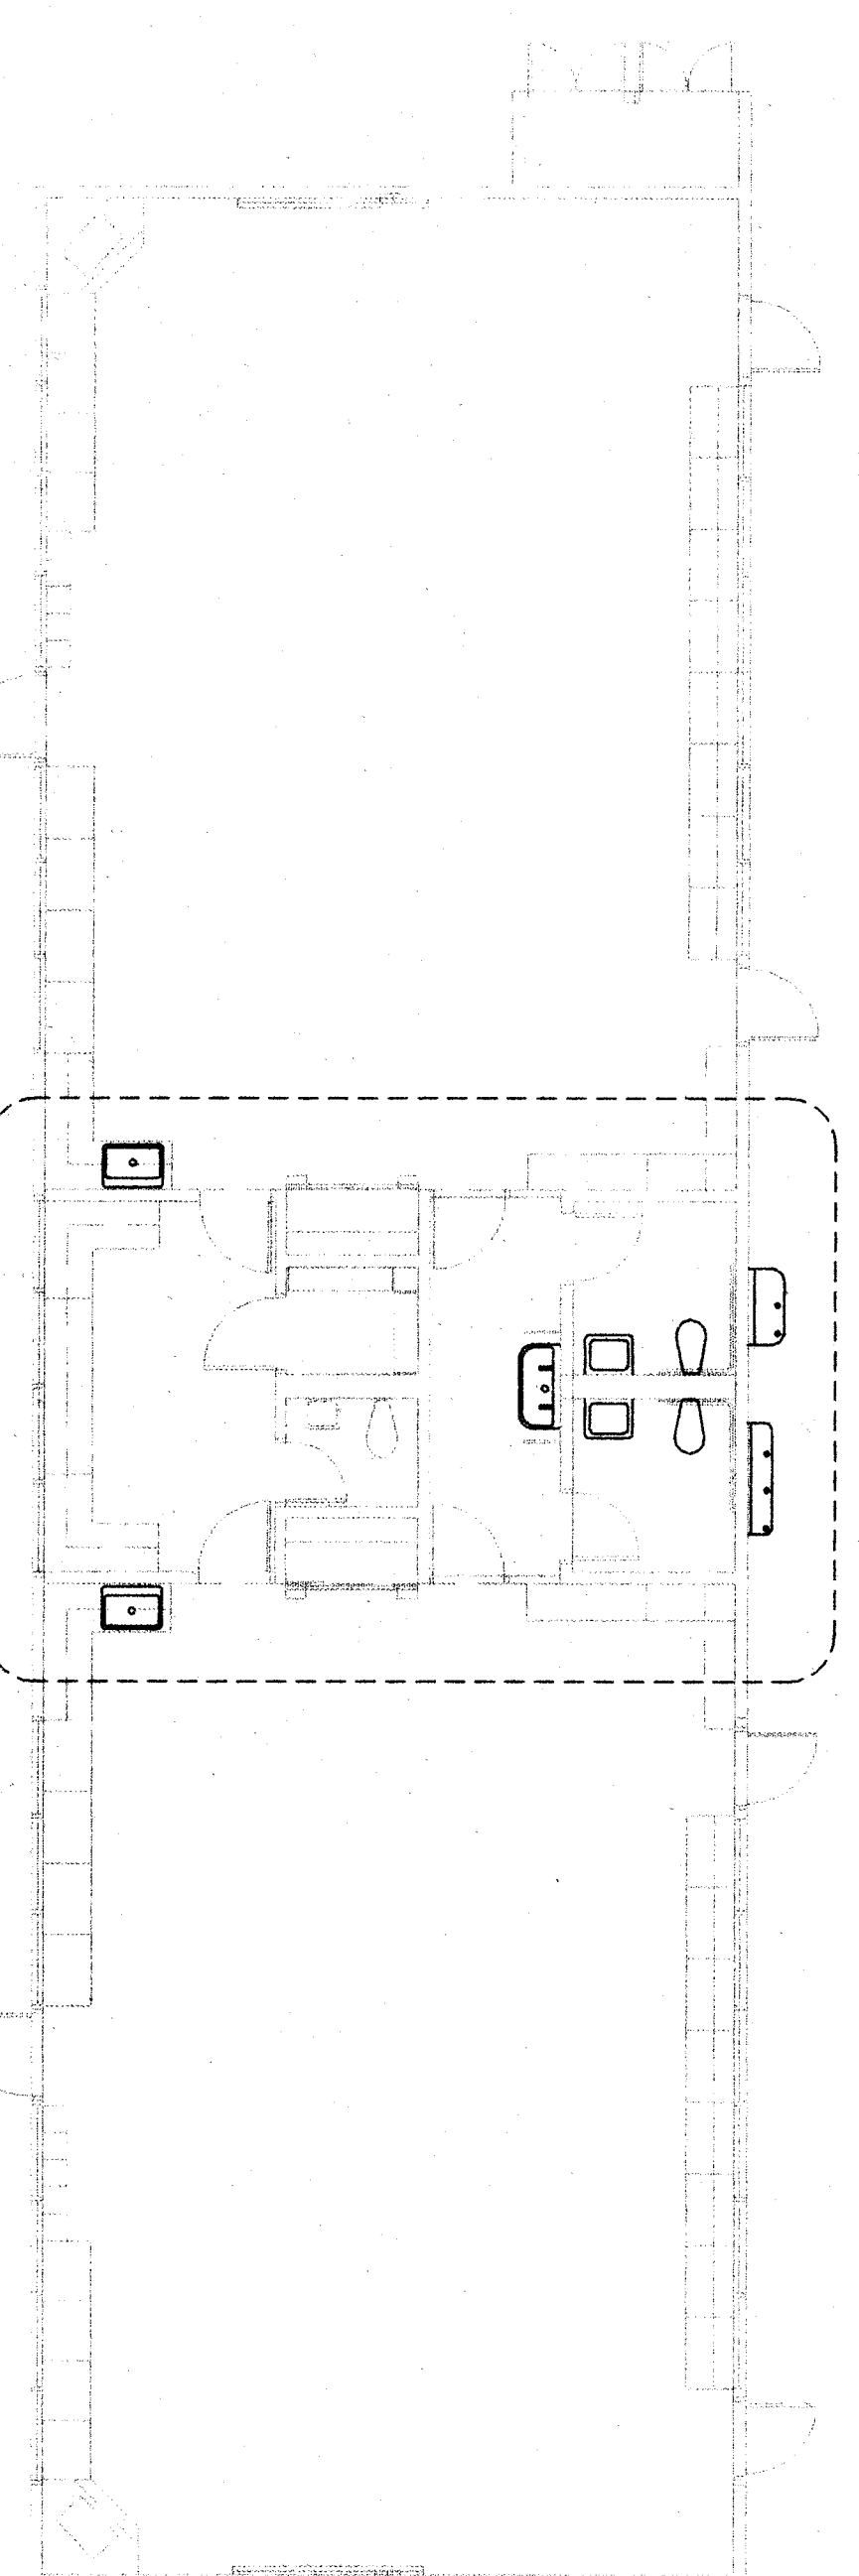


PLUMBING FLOOR PLAN (BUILDING C)
SCALE: 1/8" = 1'-0"

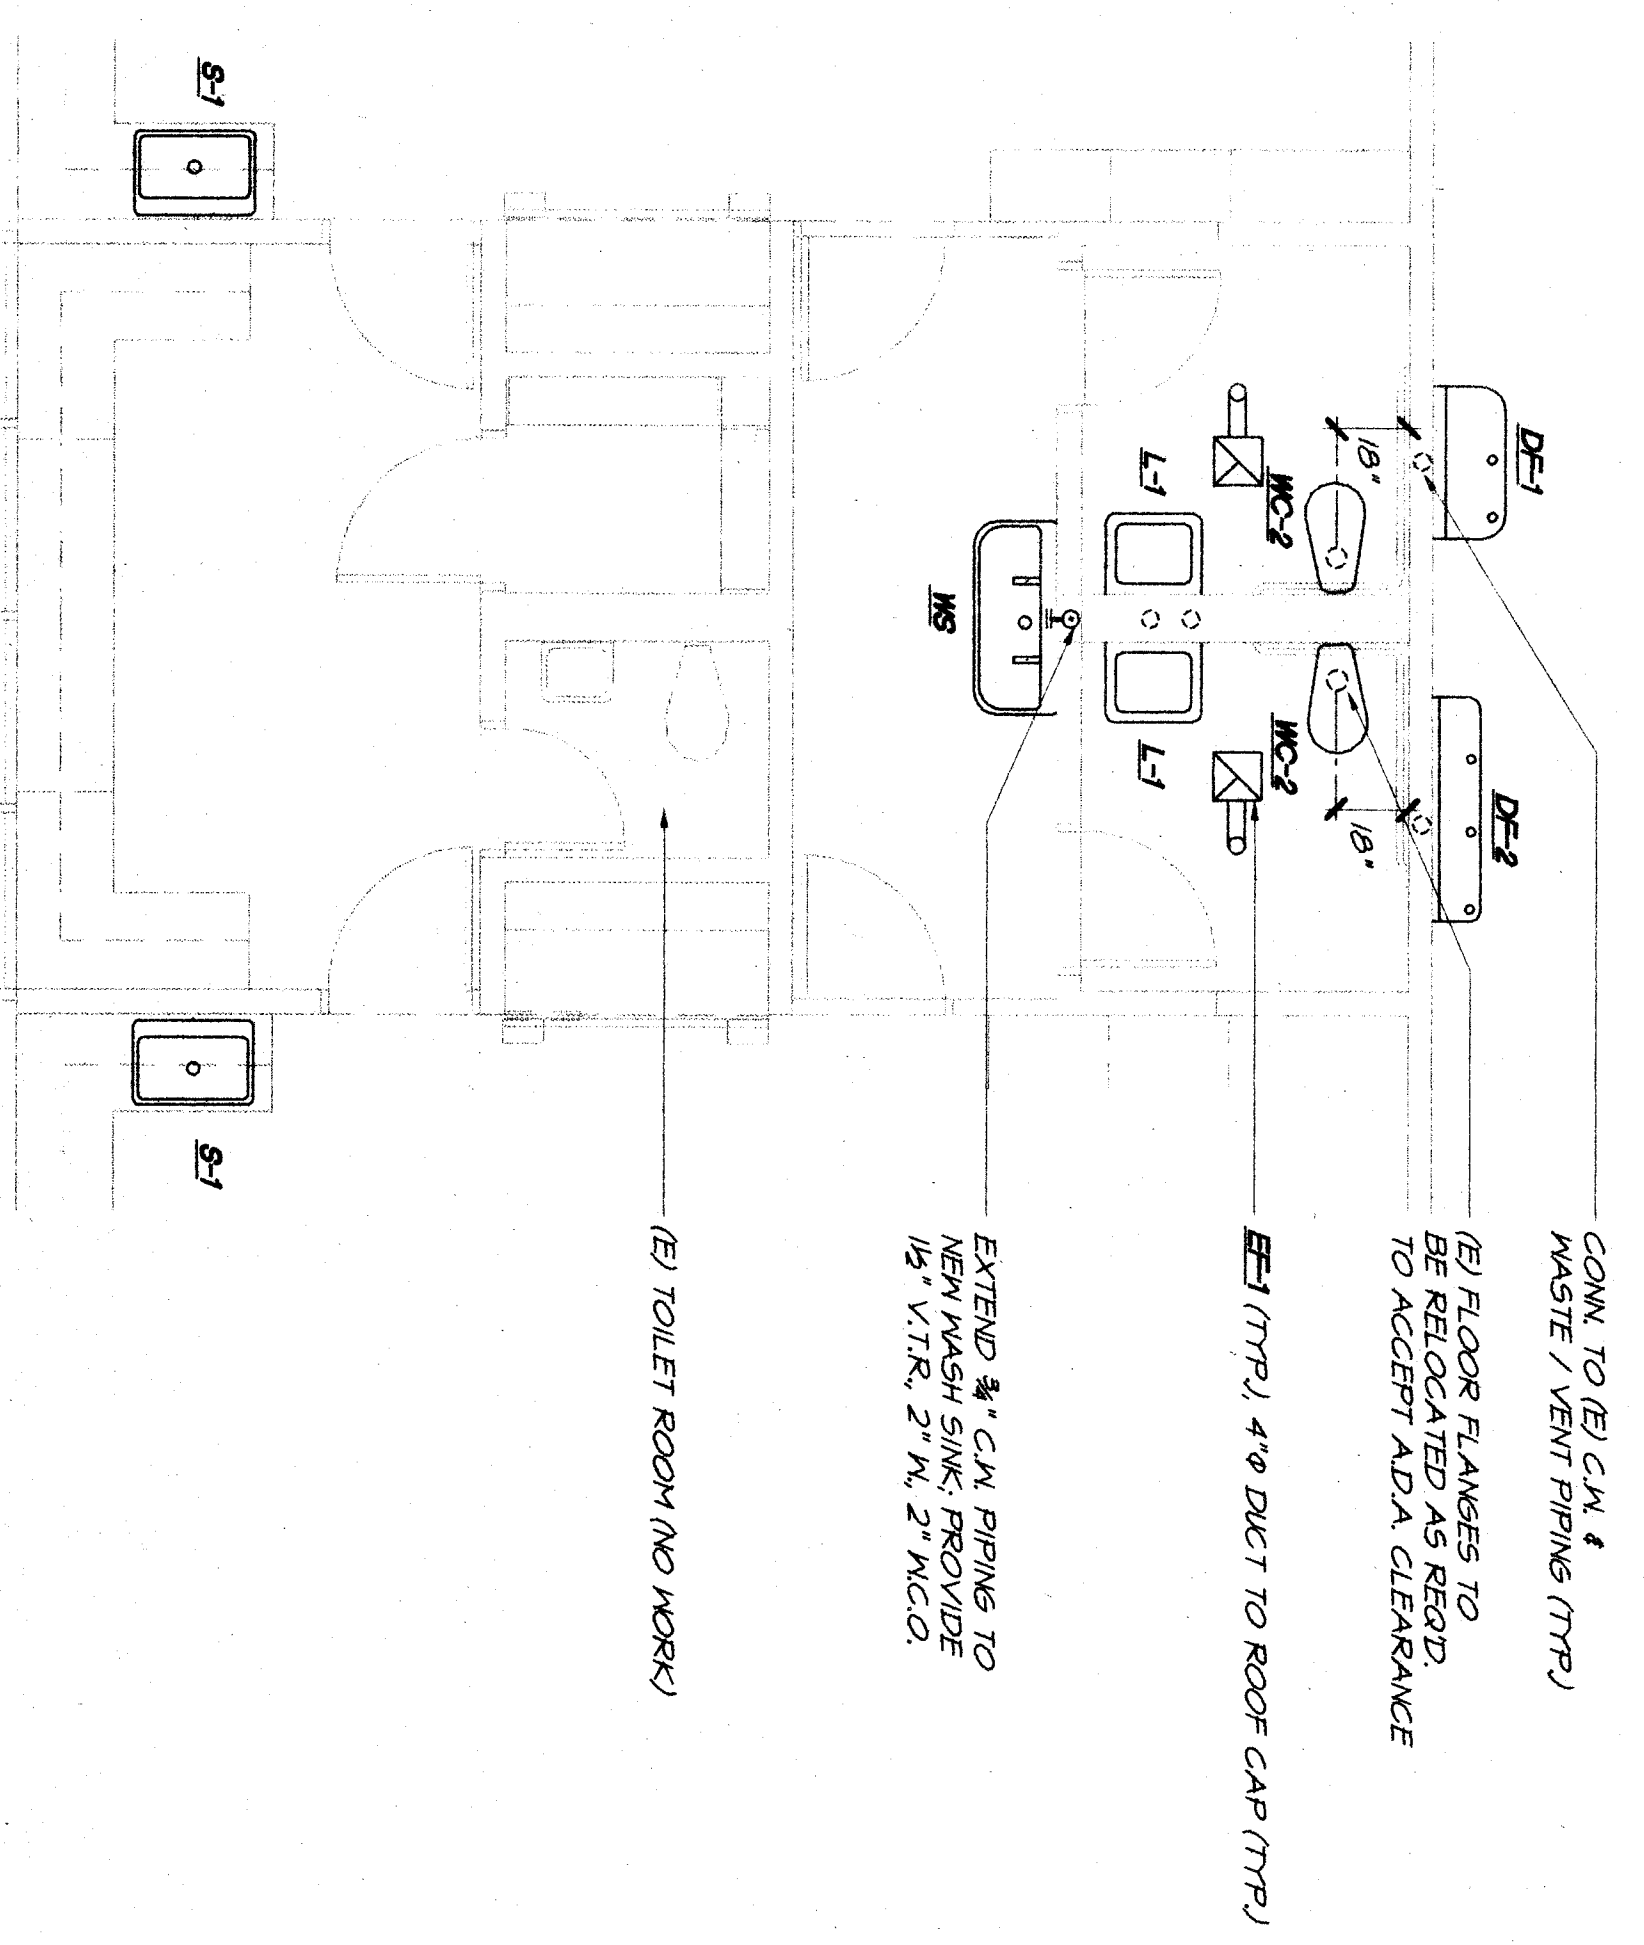

PARTIAL PLUMBING F.P. (BLD'G C)
SCALE: 1/4" = 1'-0"

DEMOLITION PLUMBING F.P. (BLD'G. B)
SCALE: 1/8" = 1'-0"

MDC
MECHANICAL ENGINEERING SERVICES
428 Thacker Avenue, Bakersfield, CA 93301
Tel: (805) 335-5333 Fax: (805) 335-5339

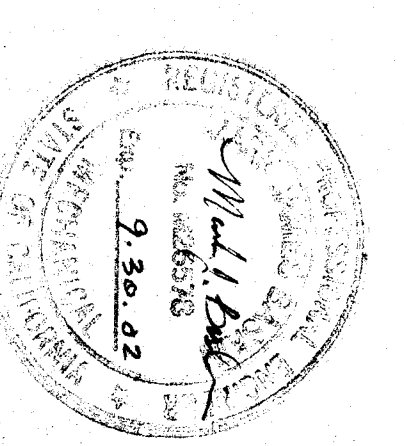

bfgc architects planners inc.
bakerfield
5800 mg avenue, suite 450, bakerfield ca 93309-4511
805 836-4300 FAX 805 836-4311

SAM LUIS OBISPO
3811 broad street, suite 113
san luis obispo, california 93401
805 345-0433

SAM JOSE
160 west south allen st, suite 205
san jose, california 95113
408 924-0841

principal architects
ronald c. montoni, ronald c. fischer
frank a. grezda, alan c. shibe
bruce a. robbins, alan c. shibe
milton p. sanders, alan c. shibe
whittier p. sanders, alan c. shibe
11000 p. sanders, alan c. shibe

HORT SCHOLL
MODERNIZATION
BAKERSFIELD CITY
SCHOLL DISTRICT
2301 PARK DRIVE
BAKERSFIELD, CA 93306

PLUMBING
FLOOR PLANS
BUILDINGS B & C
SCALE: AS NOTED

Job No. 97-276
date JUNE 17, 98
drawn by N.L.
chk'd by R.B.
copyright 1998

P
2.01
OF 4