




PLUMBING DEMOLITION/ PLUMBING FLOOR PLAN - BUILDING R6
SCALE 1/8" = 1'-0"

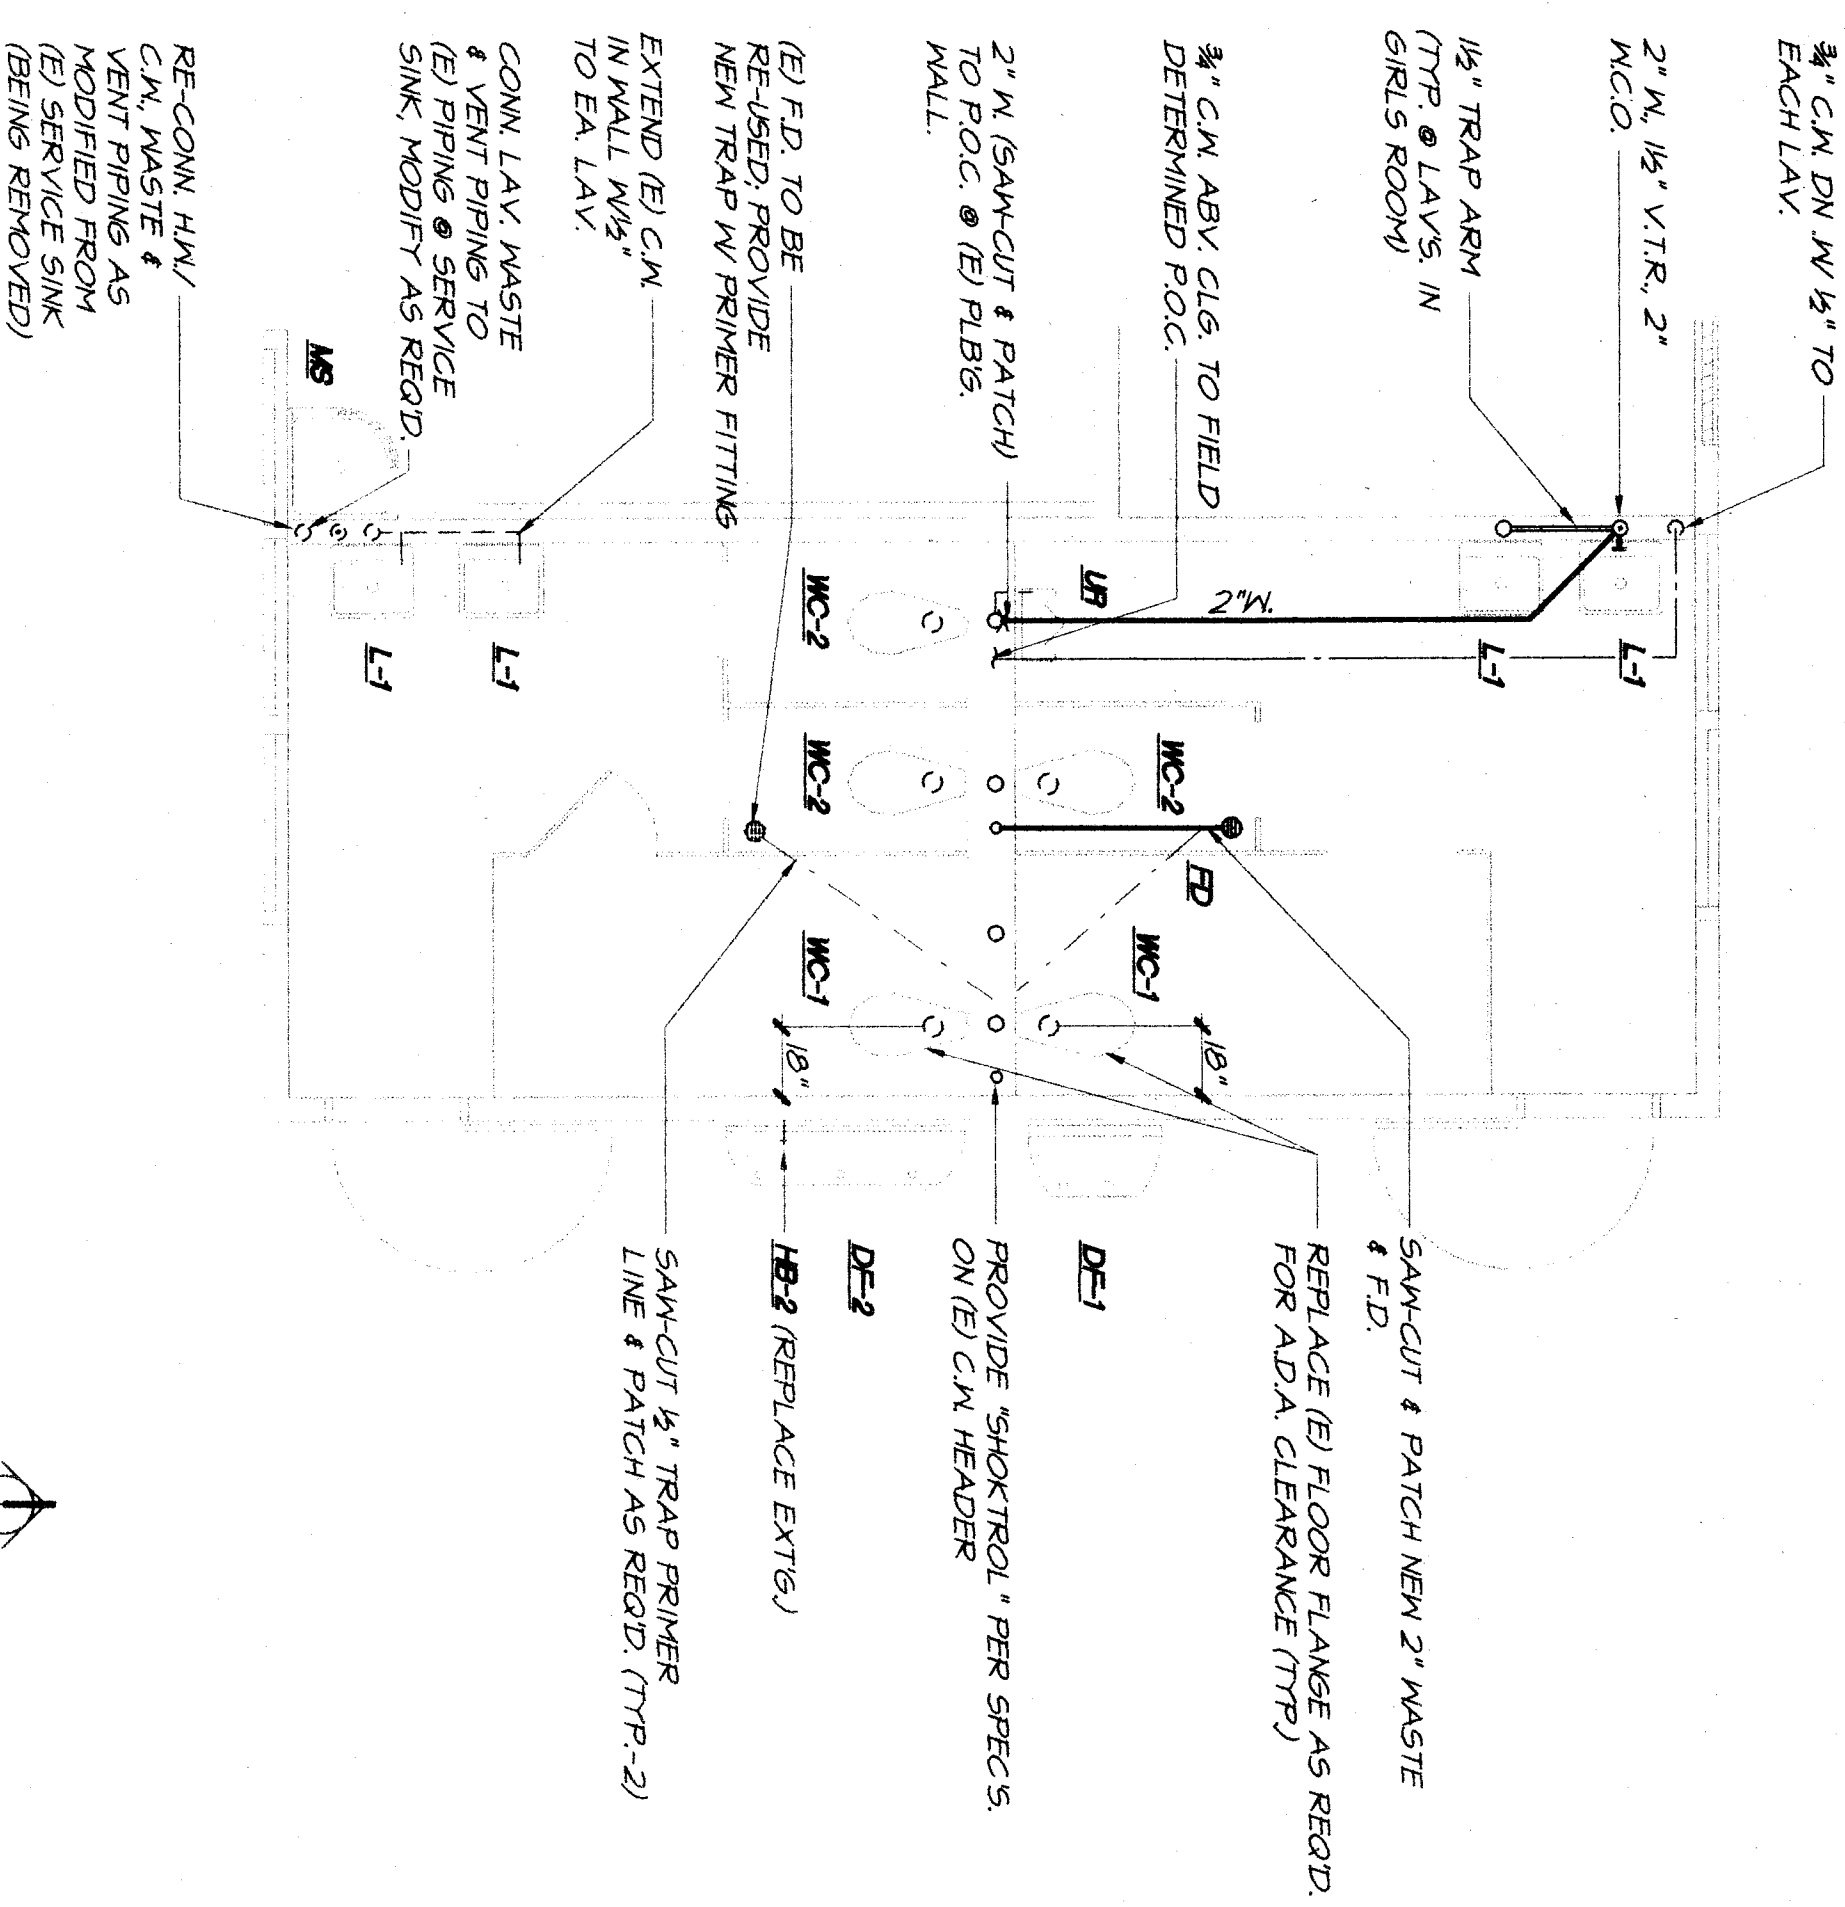


PARTIAL PLUMBING FLOOR PLAN
SCALE 1/4" = 1'-0"

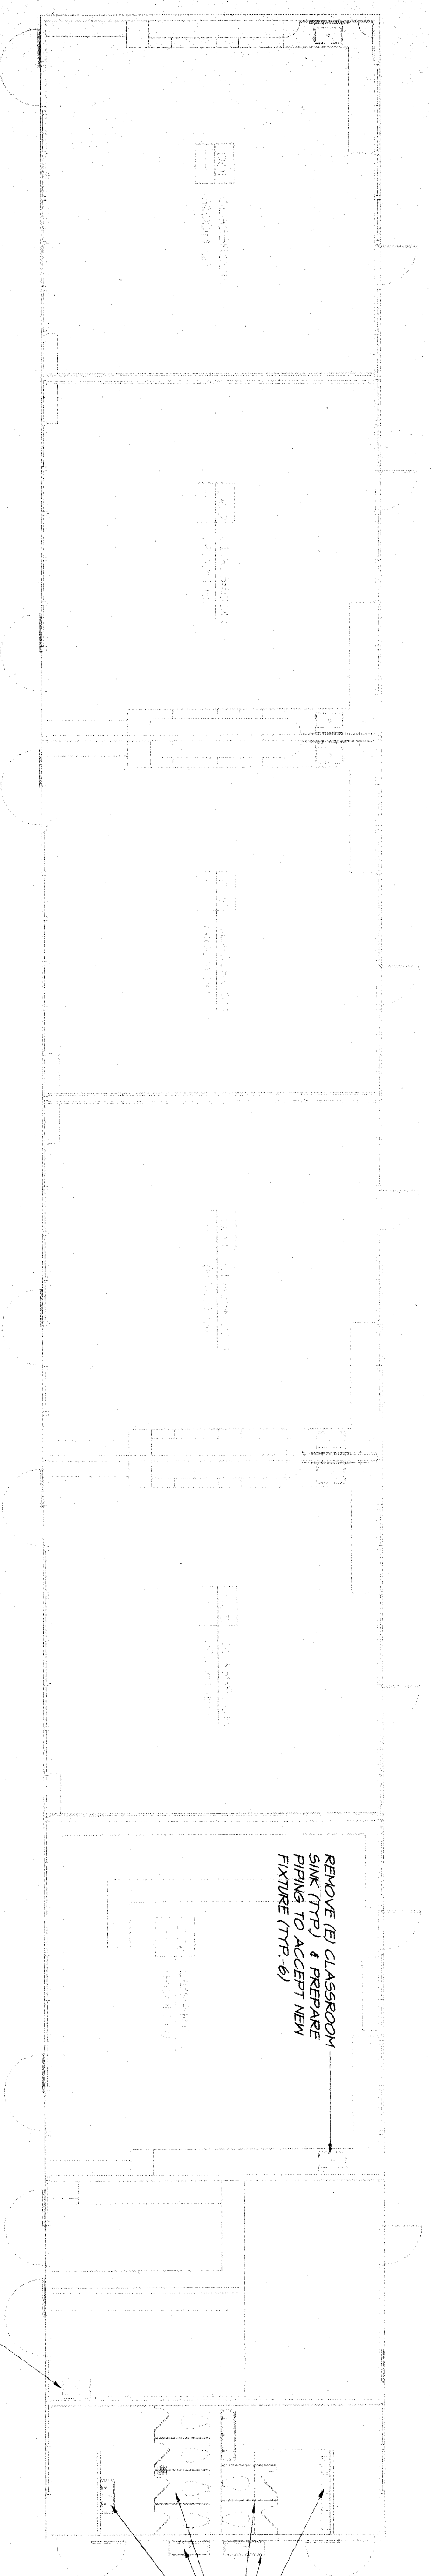

PLUMBING DEMOLITION FLOOR PLAN - BUILDING D
SCALE 1/8" = 1'-0"

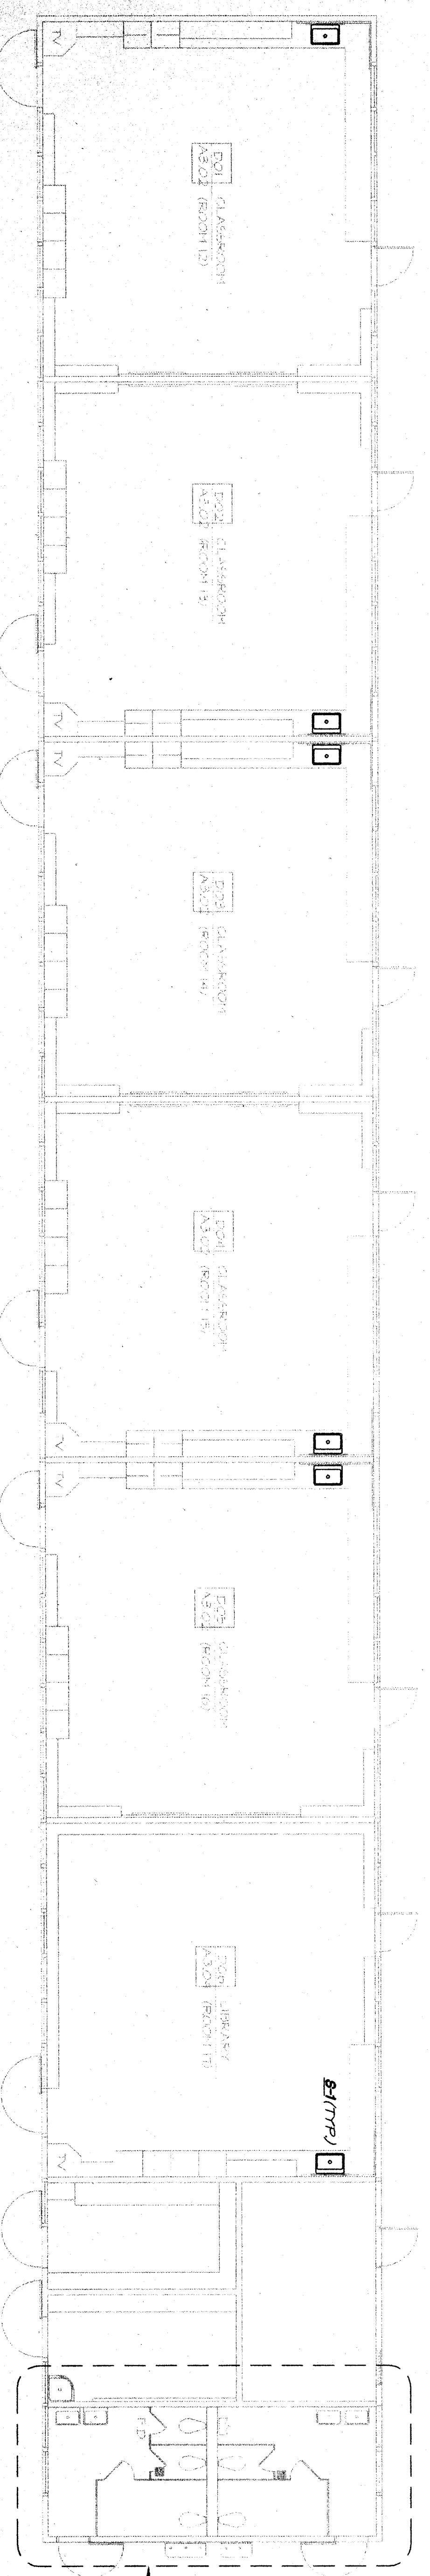

PLUMBING FLOOR PLAN - BUILDING D
SCALE 1/8" = 1'-0"

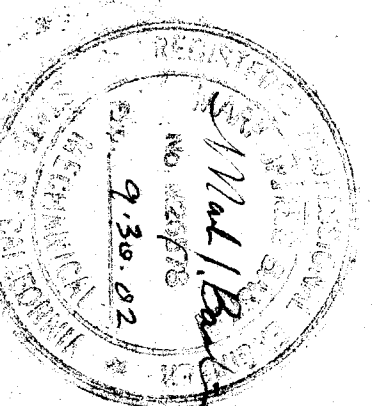

MDC MECHANICAL DESIGN CONSULTANTS
428 7TH STREET, BAKERSFIELD, CA 93301
TEL: 805.338.5555 FAX: 805.338.5555

Job No.	97-276
Date	JUNE 17, 98
Drawn by	N.L.
Checked by	R.B.
Copy #/4	1998

**HORT SCHOOL
MODERNIZATION
BAKERSFIELD CITY
SCHOOL DISTRICT**

2301 PARK DRIVE
BAKERSFIELD, CA 93306

**PLUMBING
FLOOR PLANS
BUILDING "R6" & "D"**
SCALE AS NOTED

bfgc architects planners inc.
Baker's Field
5007 King of the Hill
BOS 836-4300
FAX 805 836-4311

SON LIS ODISPO
3211 Broad Street, Suite 115
San Luis Obispo, California 93401
805 546-0433
SON JOSE
160 West Santa Ana St, Suite 200
San Jose, California 95131
408 924-0941

Principal architect: [Signature]

Stamp: State of California, No. 9736, Mechanical Engineering, S. M. B.

REVISIONS

NO.	DATE	DESCRIPTION
1	10/11/98	ISSUED FOR PERMITS
2	11/11/98	REVISED PER PERMITS

DATE: 11/11/98
BY: [Signature]