



PARTIAL PLUMBING FLOOR PLAN
SCALE 1/4" = 1'-0"

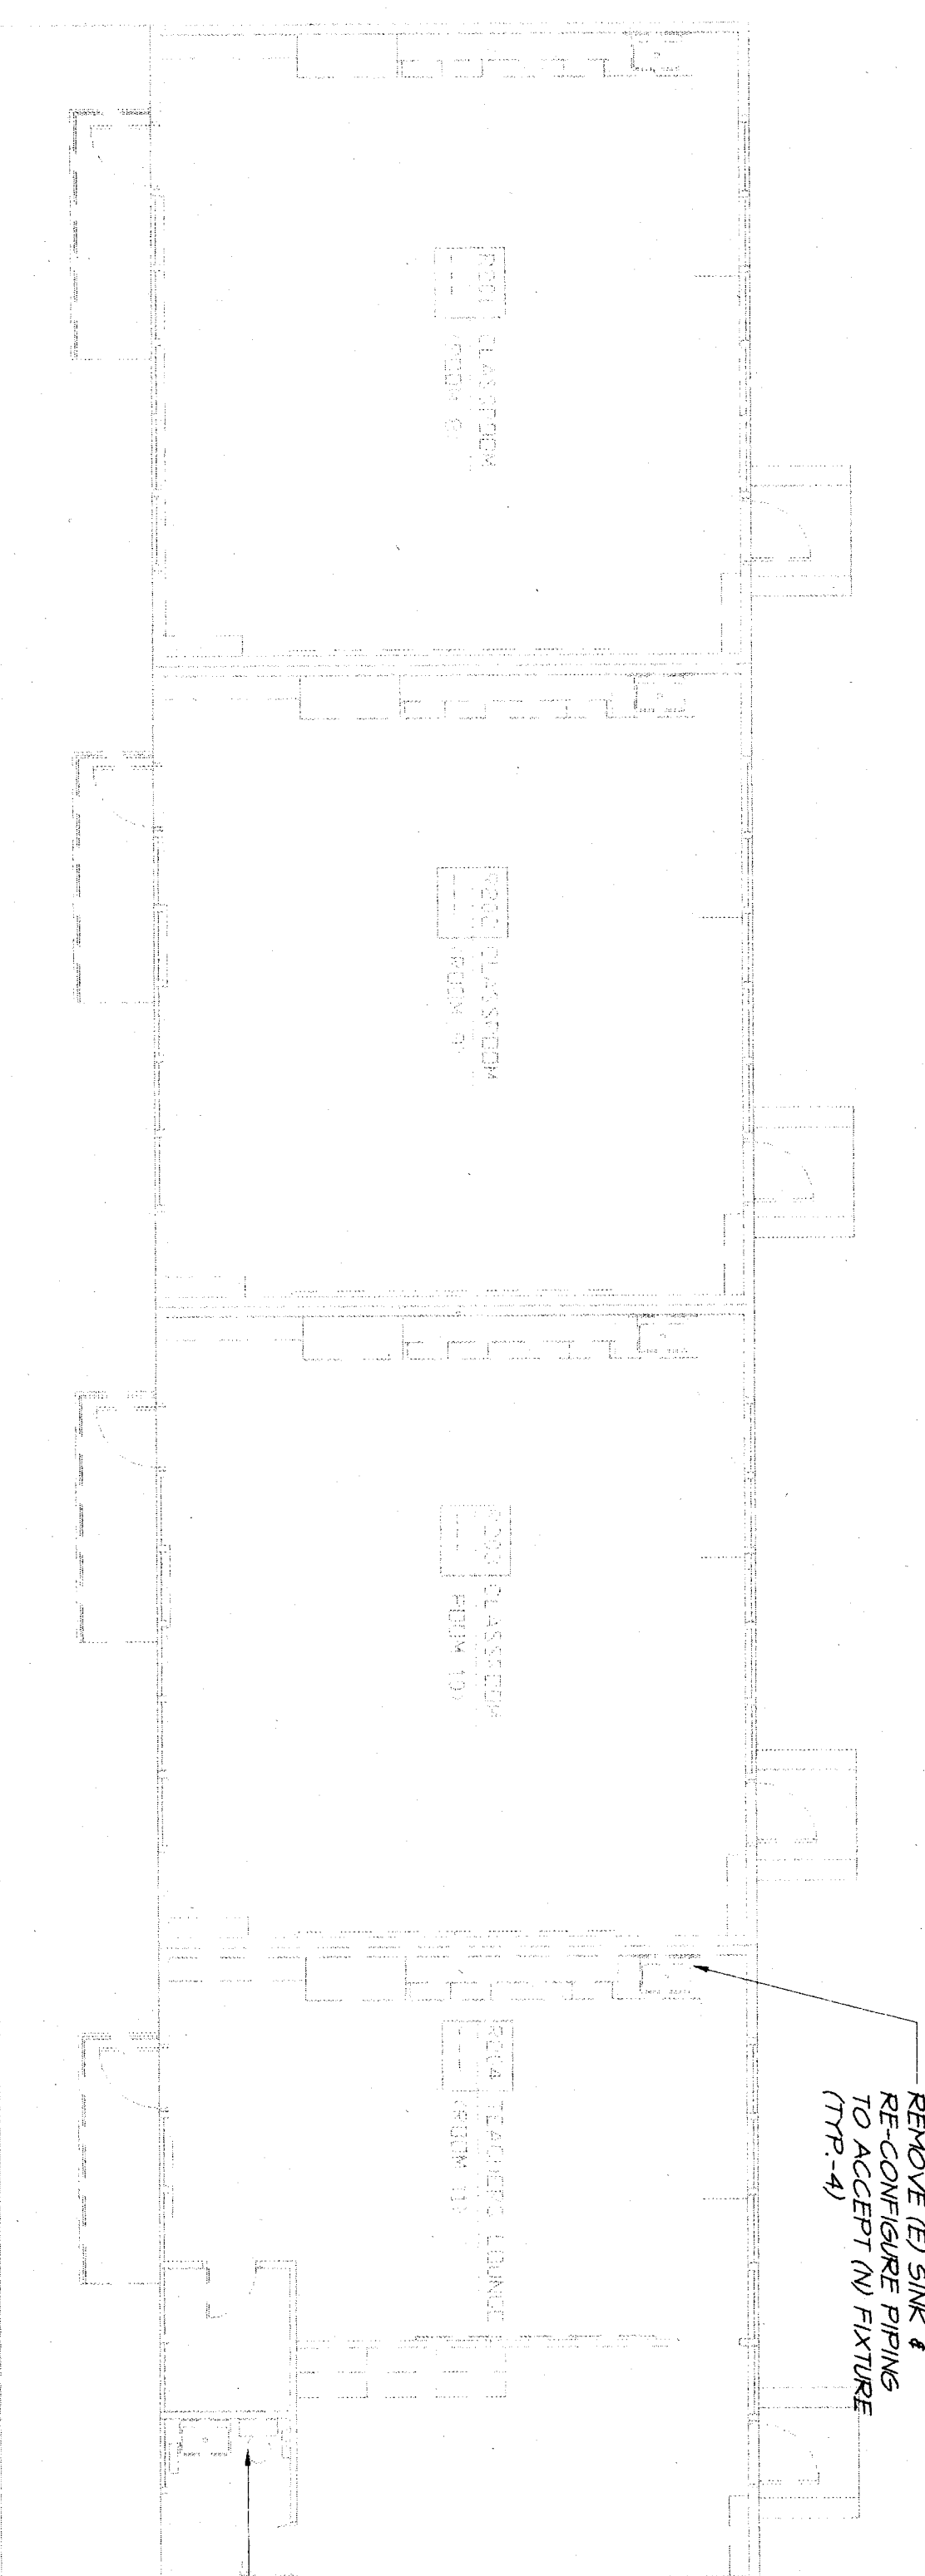

DEMOLITION FLOOR PLAN BLDG. R-2
SCALE 1/8" = 1'-0"

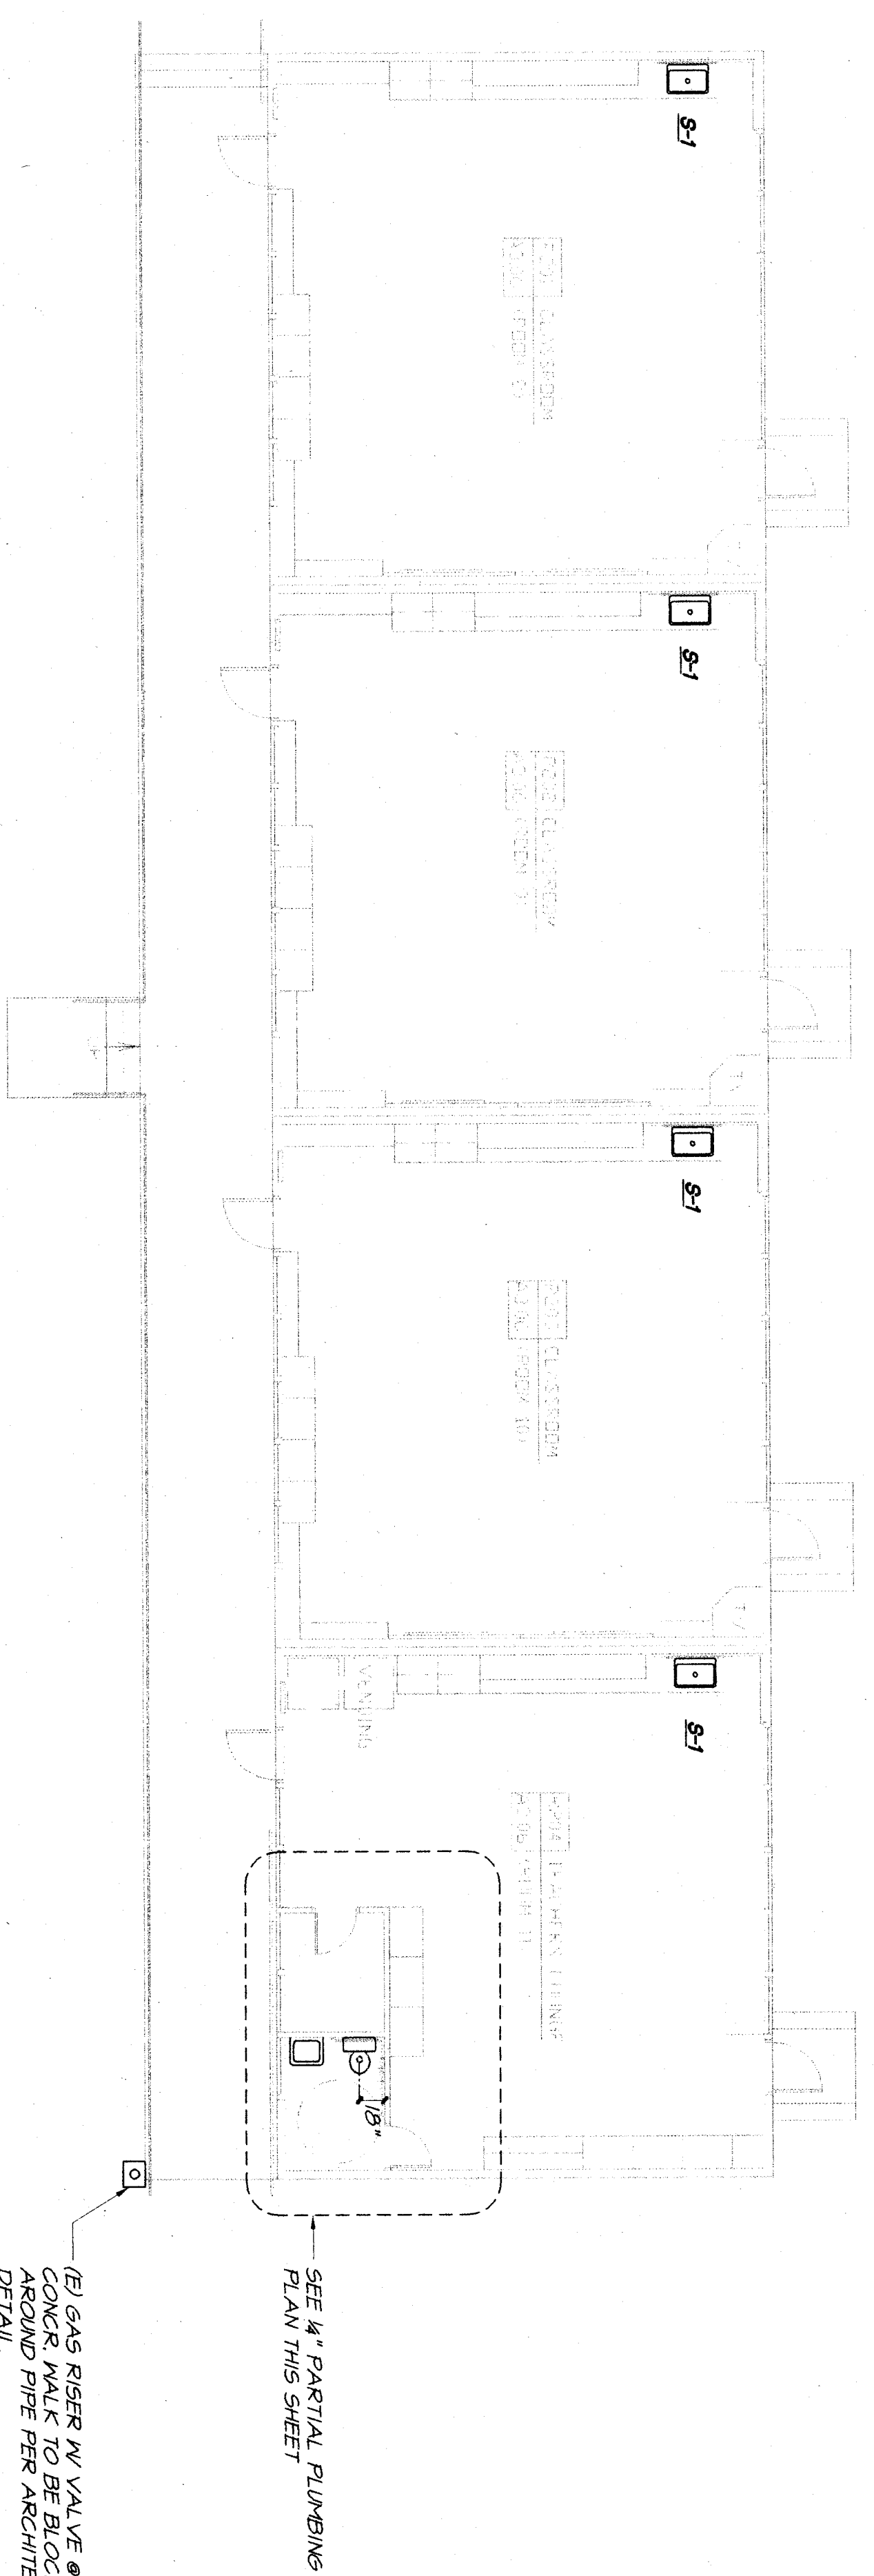

FLOOR PLAN BLDG. R-2
SCALE 1/8" = 1'-0"

REGISTERED PROFESSIONAL ENGINEER
 MECHANICAL ENGINEERING
 OCT 10, 1998
 191118
 M.D. S. L. T.

b7gc architects designers inc
 baker-sfield
 5500 mgg ave. suite 450, bakersfield ca 93309-4431
 805 836-4300 fax 805 836-4311
 SAN LUIS OBISPO
 3211 broad street suite 113
 san luis obispo, california 93401
 805 376-9333
 SAN JOSE
 160 west santa clara st. suite 503
 san jose, california 95113
 408 924-1841

HORT SCHOLL
 MODERNIZATION
 BAKERSFIELD CITY
 SCHOLL DISTRICT
 2301 PARK DRIVE
 BAKERSFIELD, CA 93306
 PLUMBING
 FLOOR PLAN
 BUILDING R2
 1/8" = 1'-0"

Job no. 97-276
 date JUNE 17, 98
 drawn by N.L.
 checked by R.L.
 copyright 1998
P
 2.03
 OF 4



MDC
 MECHANICAL ENGINEERING SERVICES
 423 Truman Avenue
 Bakersfield, CA 93301
 Tel # (805) 326-510 Fax # (805) 326-0099