



UNIT 6 FLOOR PLAN - LIGHTING LAYOUT
SCALE 1/8" = 1'-0"

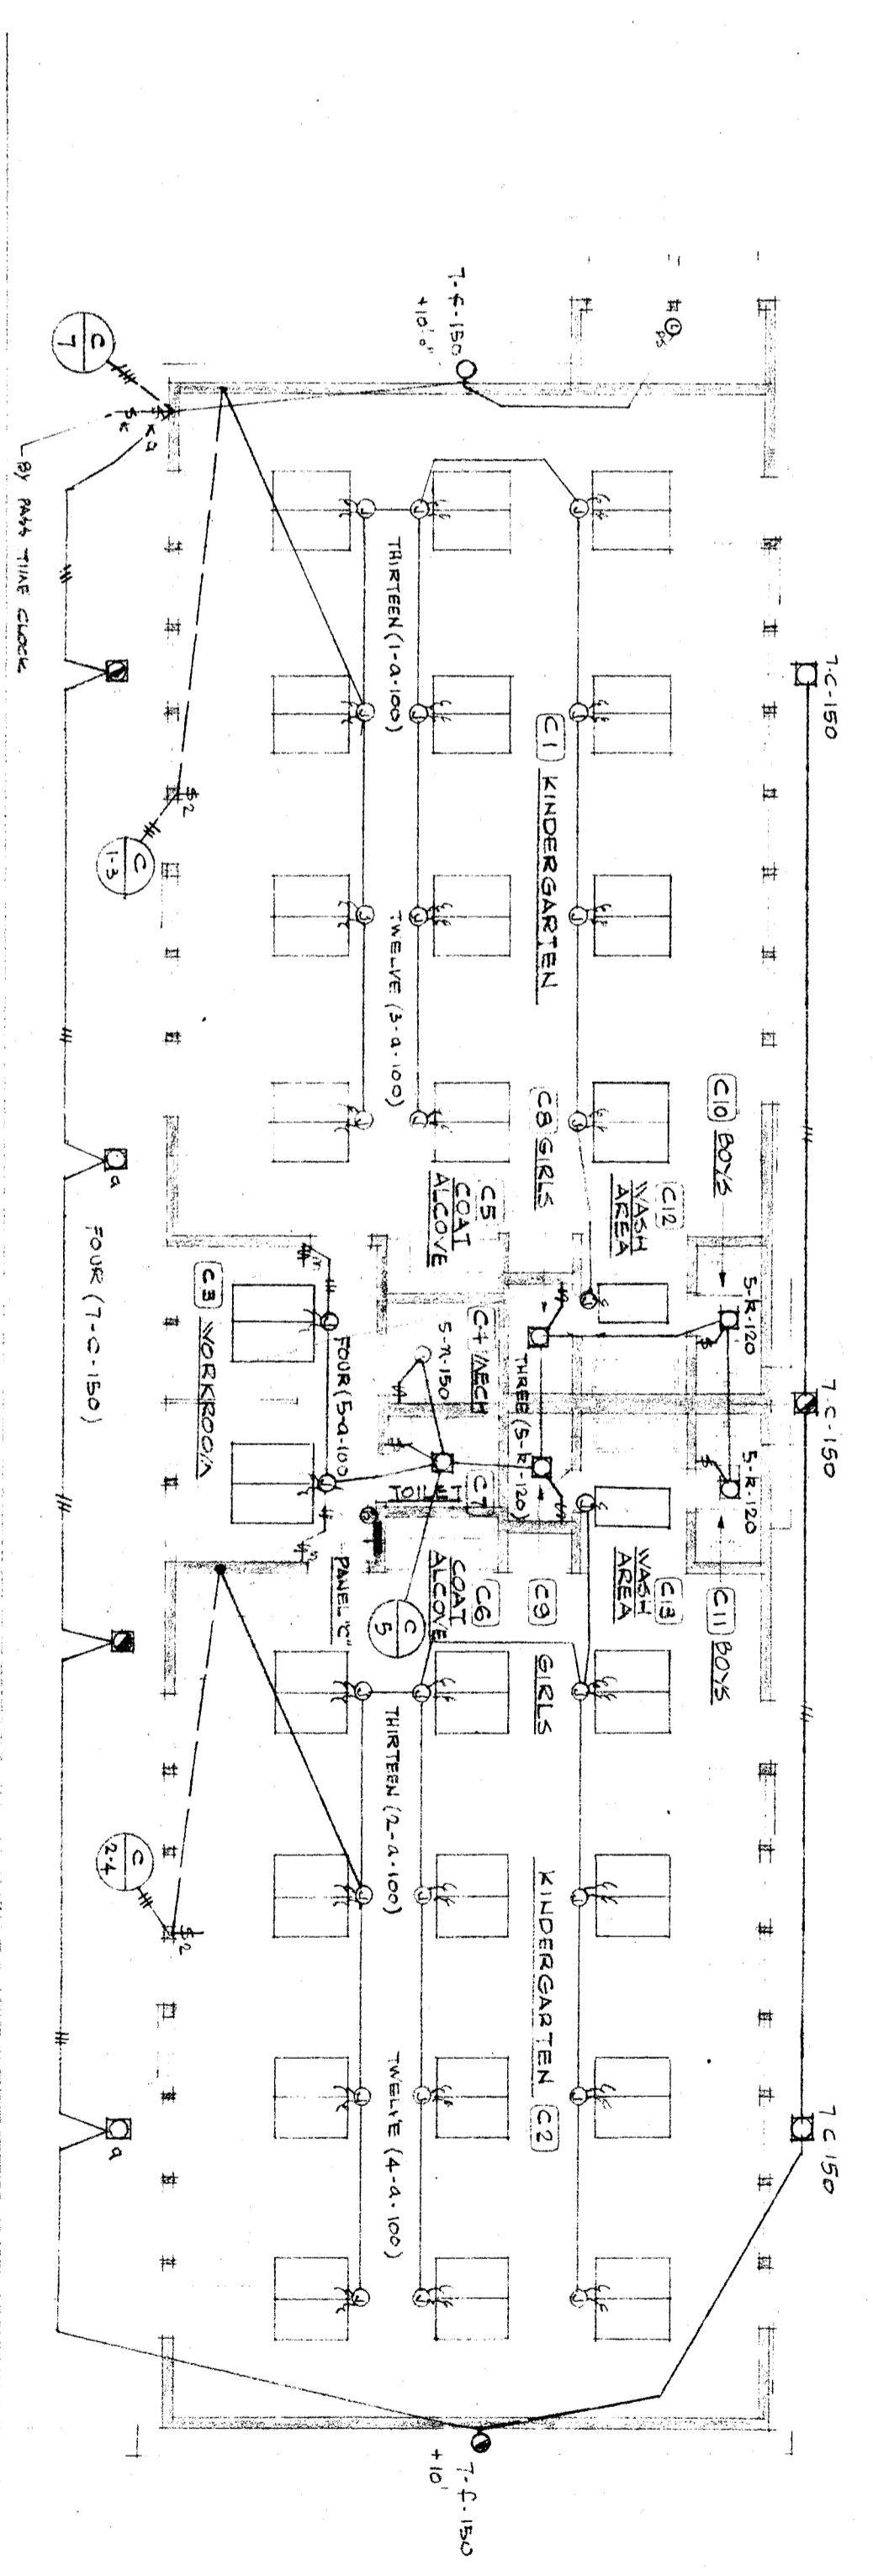


UNIT C FLOOR PLAN - LIGHTING LAYOUT
SCALE 1/8" = 1'-0"

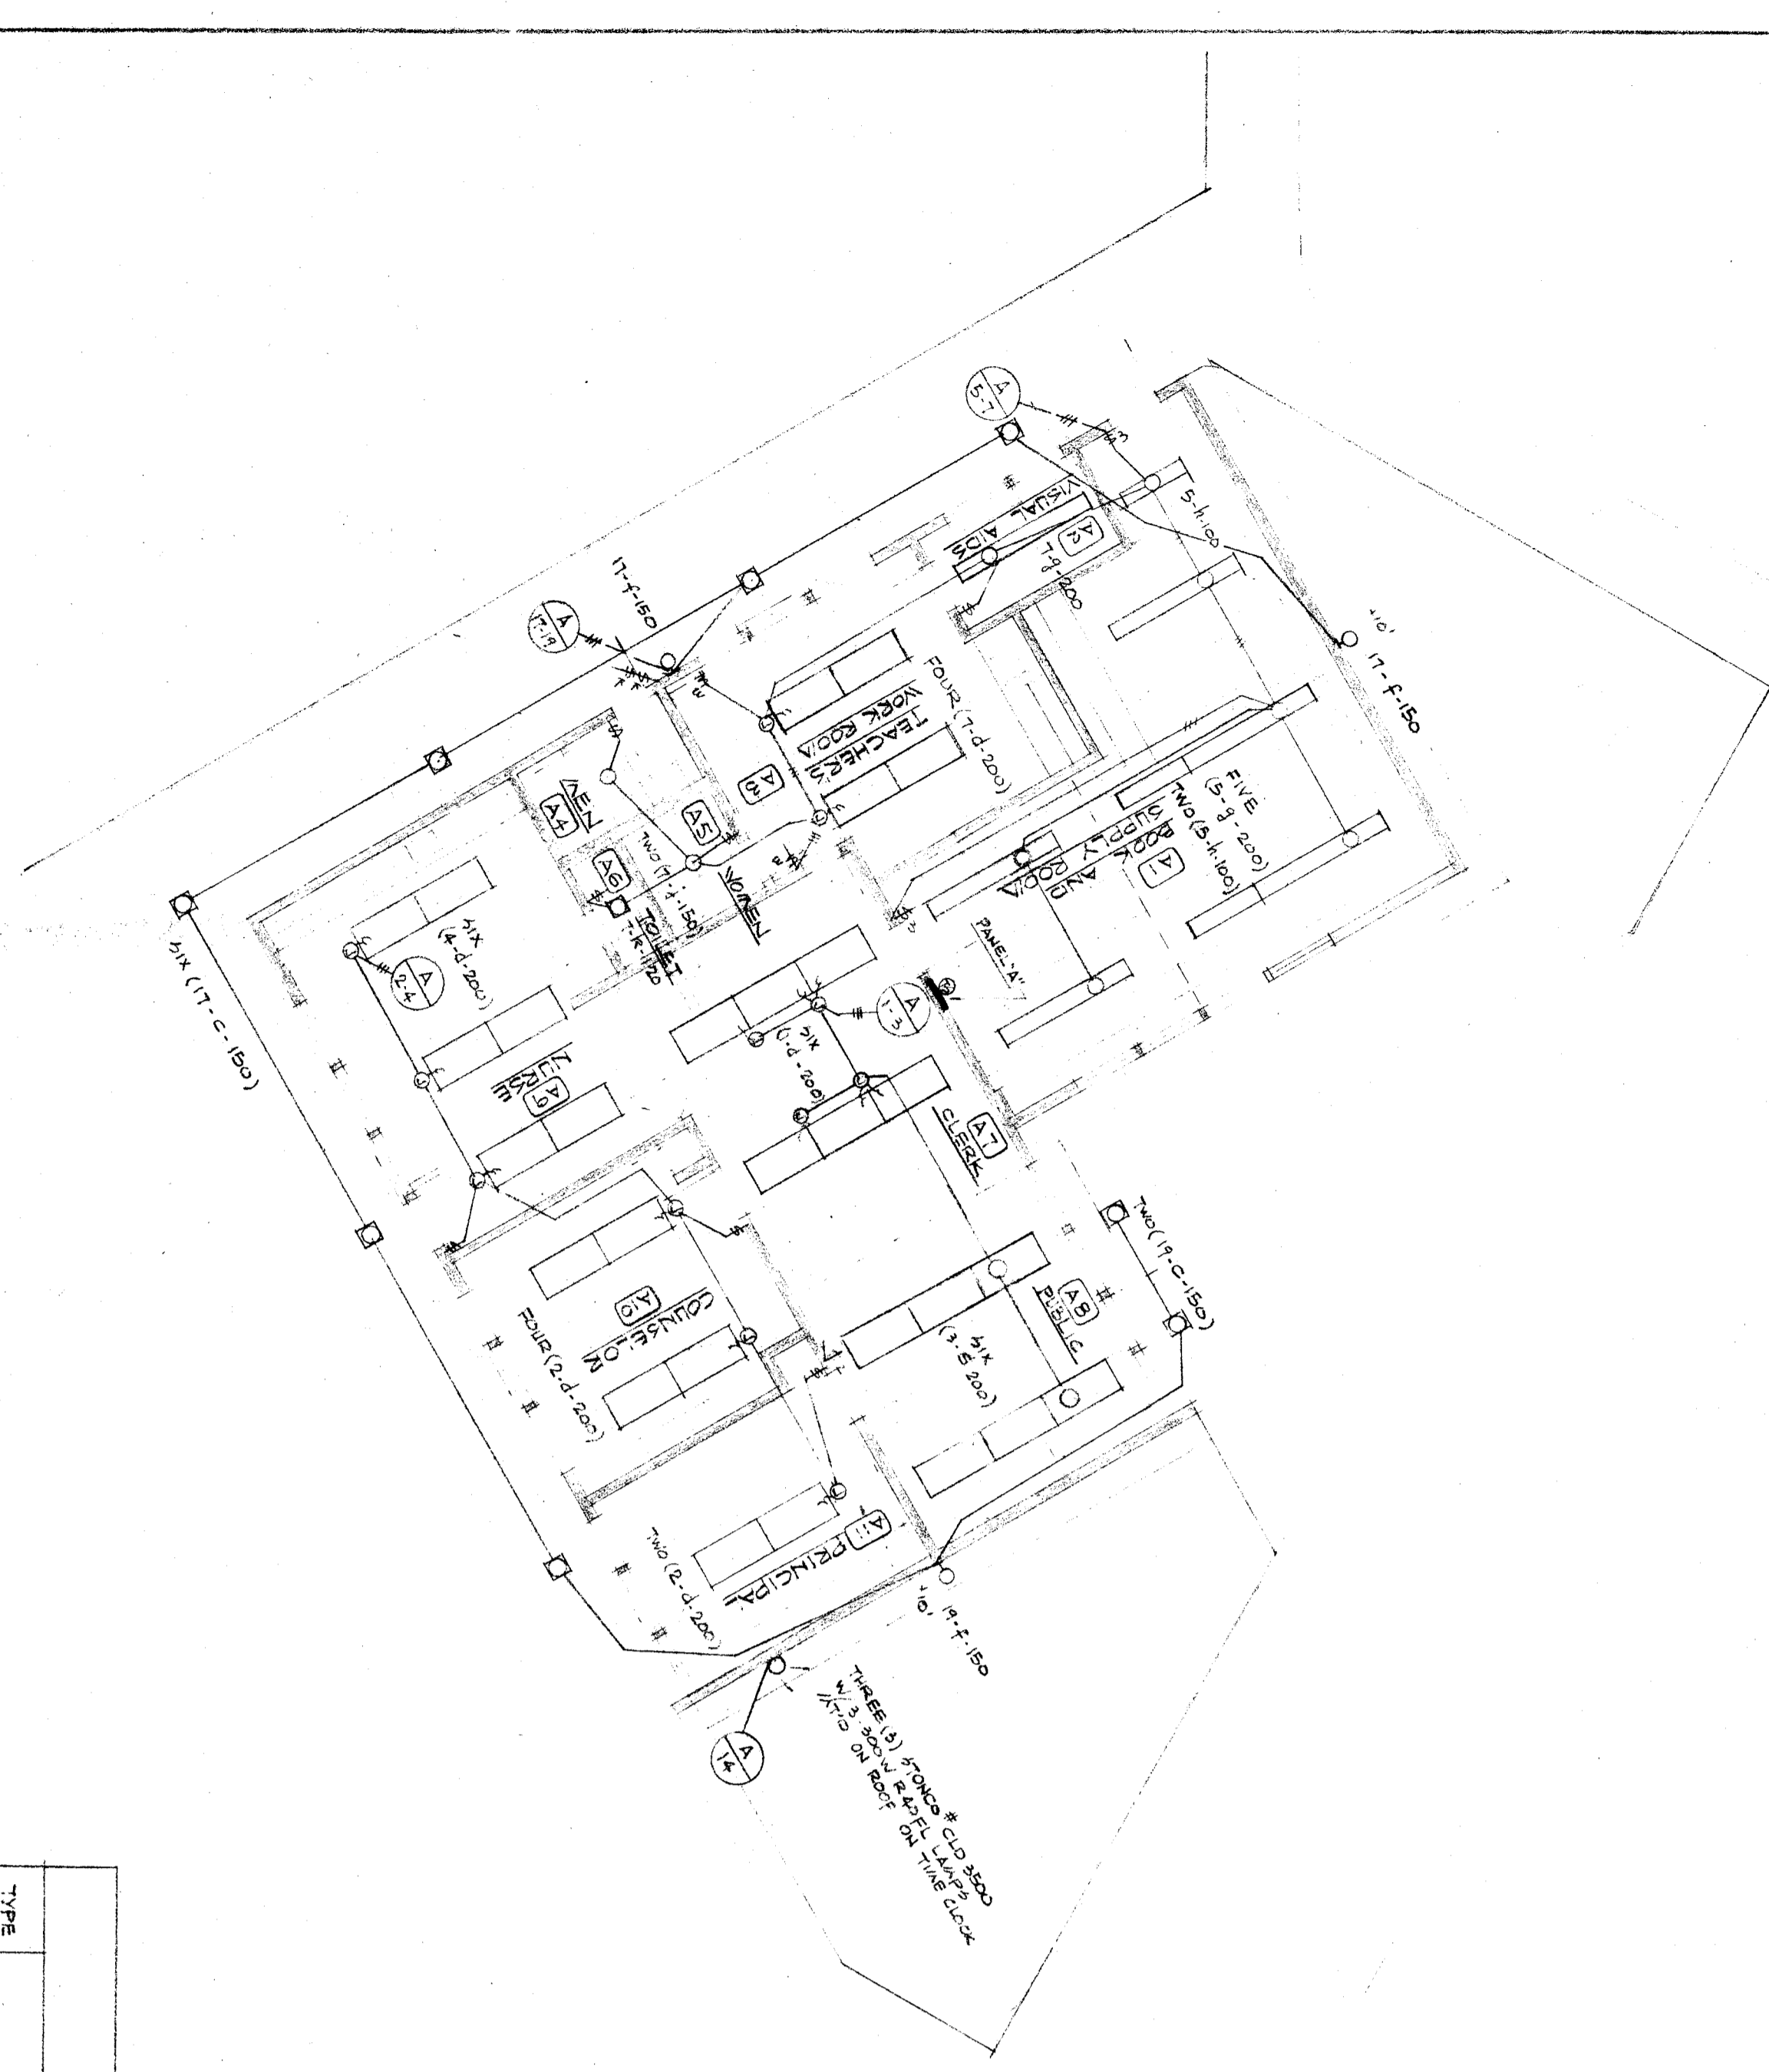

UNIT A FLOOR PLAN - LIGHTING LAYOUT
SCALE 1/8" = 1'-0"

TYPE	DESCRIPTION	LAMP	HT'G
A	DAY-BRITE CAT #114421-041 4x4-40W	2-40W	RECESS.
B	SUN-BEAM CAT #1041102-0825	1-125W	
P	4WE DETAIL ON RIGHT		
C	MARCO CAT #116-080-WP-C	1-50W	RECESS.
D	DAY-BRITE CAT #114421-041 4x4-40W	4-40W	RECESS.
E	SUN-BEAM CAT #1041102-0825	1-125W	
F	HOLOPHANE CAT #415	1-50W	DKT.
G	GLORIE CAT #415	4-40W	RECESS.
H	GLORIE CAT #415	4-40W	RECESS.
I	GLORIE CAT #415	4-40W	RECESS.
J	GLORIE CAT #415	4-40W	RECESS.
K	GLORIE CAT #415	4-40W	RECESS.
L	GLORIE CAT #415	4-40W	RECESS.
M	GLORIE CAT #415	4-40W	RECESS.
N	GLORIE CAT #415	4-40W	RECESS.
O	GLORIE CAT #415	4-40W	RECESS.
P	GLORIE CAT #415	4-40W	RECESS.
Q	GLORIE CAT #415	4-40W	RECESS.
R	GLORIE CAT #415	4-40W	RECESS.
S	GLORIE CAT #415	4-40W	RECESS.

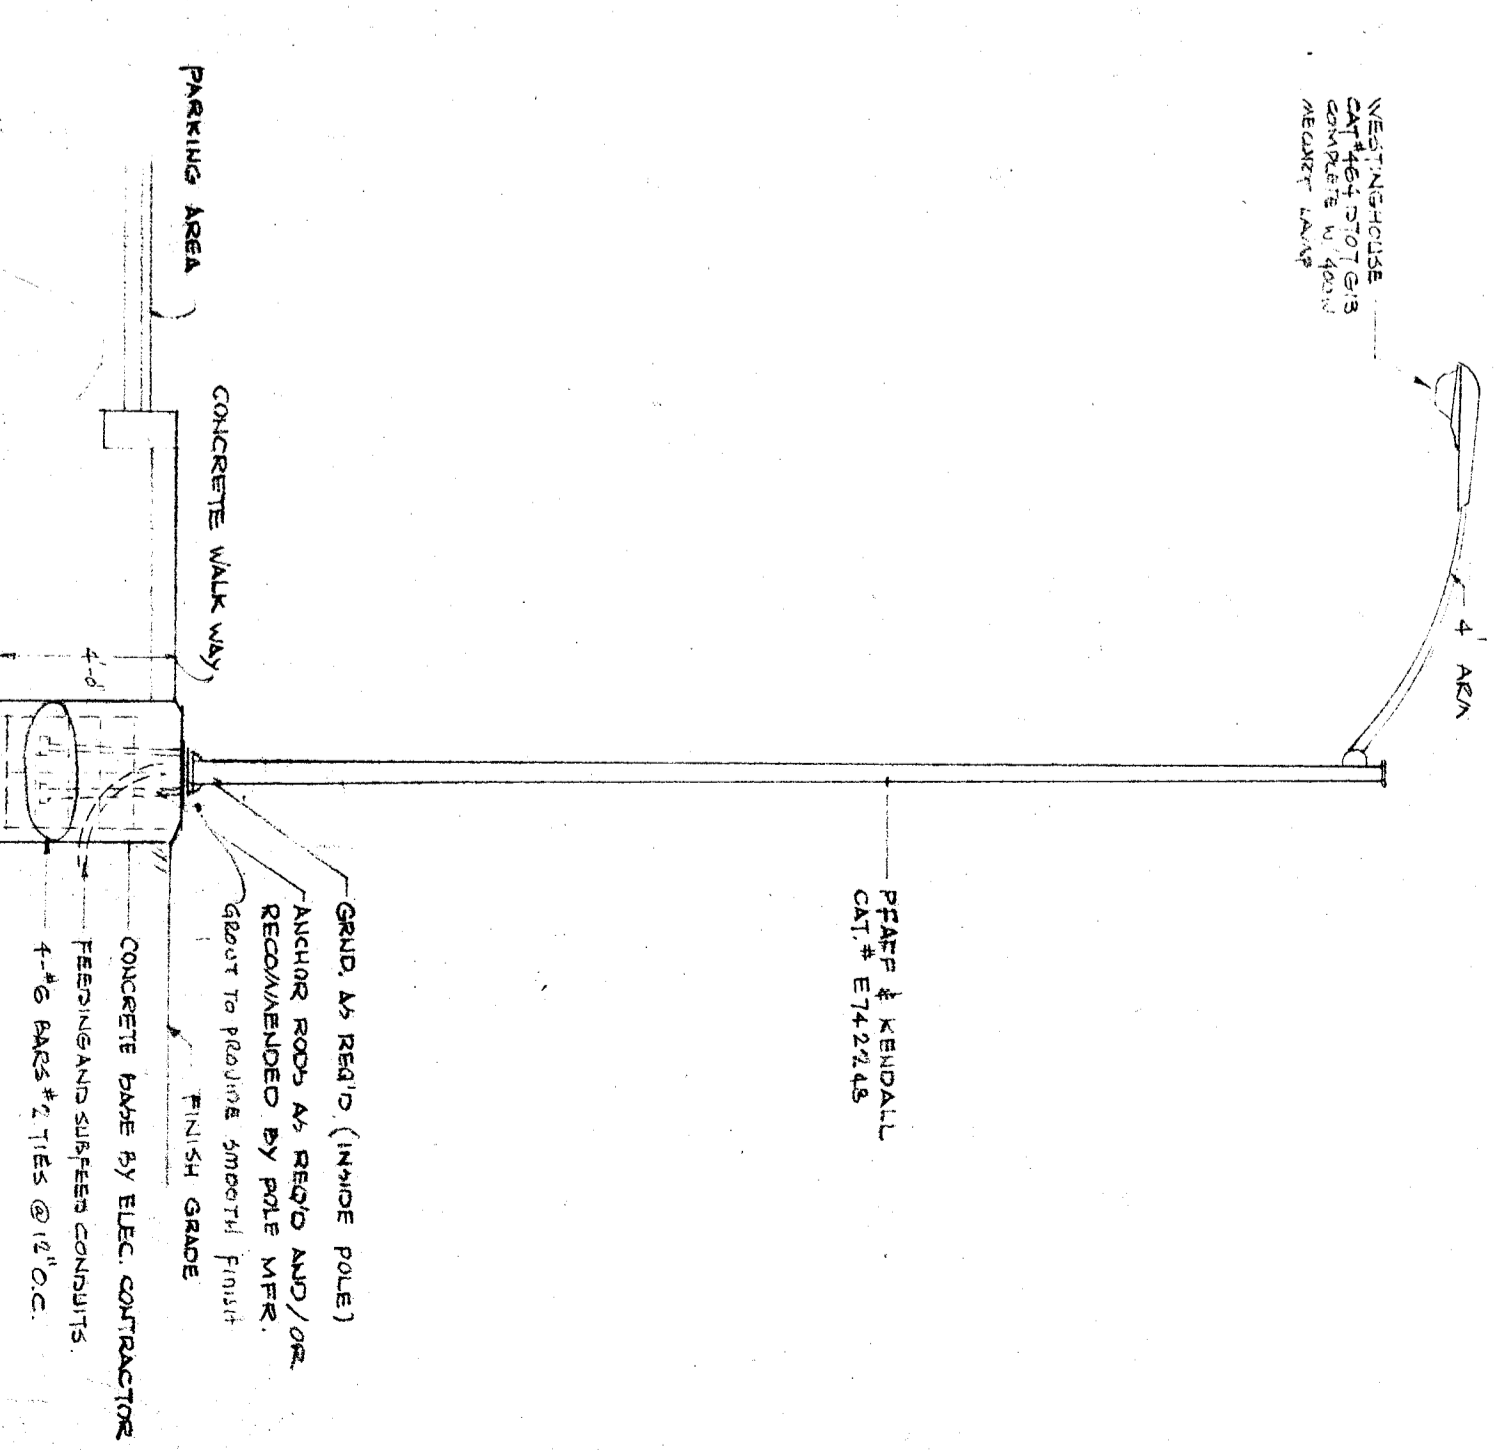

DETAIL FIXTURE TYPE "P"
NO SCALE

STATE OF CALIF.
STATE FIRE MARSHALL
GLENN B. YANCE
BY: [Signature]

JOB No 6318 FLOOR PLANS - LIGHTING LAYOUT

SIX CLASSROOM, TWO KINDERGARTEN AND ADMINISTRATION BUILDINGS HORT SCHOOL BAKERSFIELD CITY SCHOOL DISTRICT BAKERSFIELD, KERN COUNTY, CALIFORNIA

APPROVED BY BOARD OF EDUCATION BAKERSFIELD CITY SCHOOL DISTRICT DATE: JUL 21 1964

STATE OF CALIFORNIA - ELECTRICAL ENGINEER SERVICE DATE REVISIONS

24839 APPROVED JUL 15 1964

EDWARD LOWE ELECTRICAL ENGINEER 2025 CHESTER ST. PRESNO CALIFORNIA AM 8 7853

DATE: 5-18-64 DRAWN: HL CHECKED: [Signature]

CALVIN W. GOSS ALLAN R. CHOY GOSS AND CHOY ARCH CTS AIA 920 CHESTER D. CALIFORNIA, 323-5443