
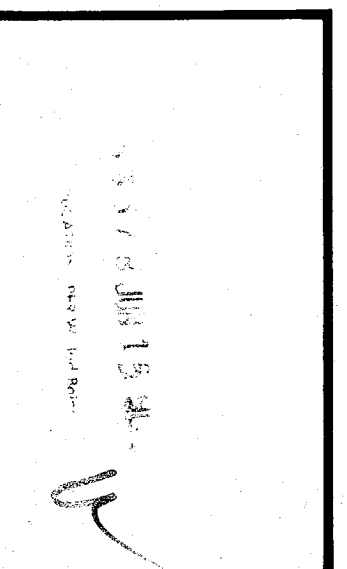


ROBERT F. STUHR ARCHITECT INC.
 3121 CALIFORNIA AVE.
 BAKERSFIELD, CA 93304
 (805) 327-1692

ENG: ROBERT F. STUHR AIA C-1610
 WILLIAM J. MELBY AIA C-16935
 DANNY E. ORDIZ AIA C-14728

TITLE 24 & 1988 UBC

4/7/14

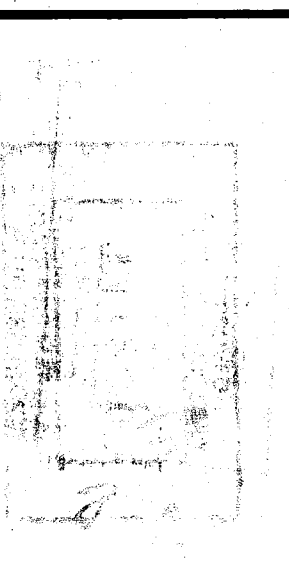


UNIT C & D PLUMBING & MECHANICAL PLAN
 VISTA EAST CONTINUATION HIGH SCHOOL 30 YEAR MODERNIZATION
 815 EUREKA STREET
 KERN HIGH SCHOOL DISTRICT
 KERN COUNTY, CALIFORNIA

BRUCE B. MOORE & ASSOCIATE
 CONSULTING MECHANICAL ENGINEER
 3109 CALIFORNIA AVE. ROOM 318 93304
 BAKERSFIELD, CALIFORNIA
 CALIFORNIA NO. ME 4180
 SEP 6/2009


CHECK AND VERIFY ALL DIMENSIONS BEFORE REPORTING DISCREPANCIES TO THE ARCHITECT. ALL CONSTRUCTION SHALL CONFORM TO UBC.

MARK	DATE	REVISIONS
△		
△		
△		

JOB NO. 707
 DRAWN: [Signature]
 CHECKED: [Signature]
 DATE: 4-14-10
 OF 4 SHEETS

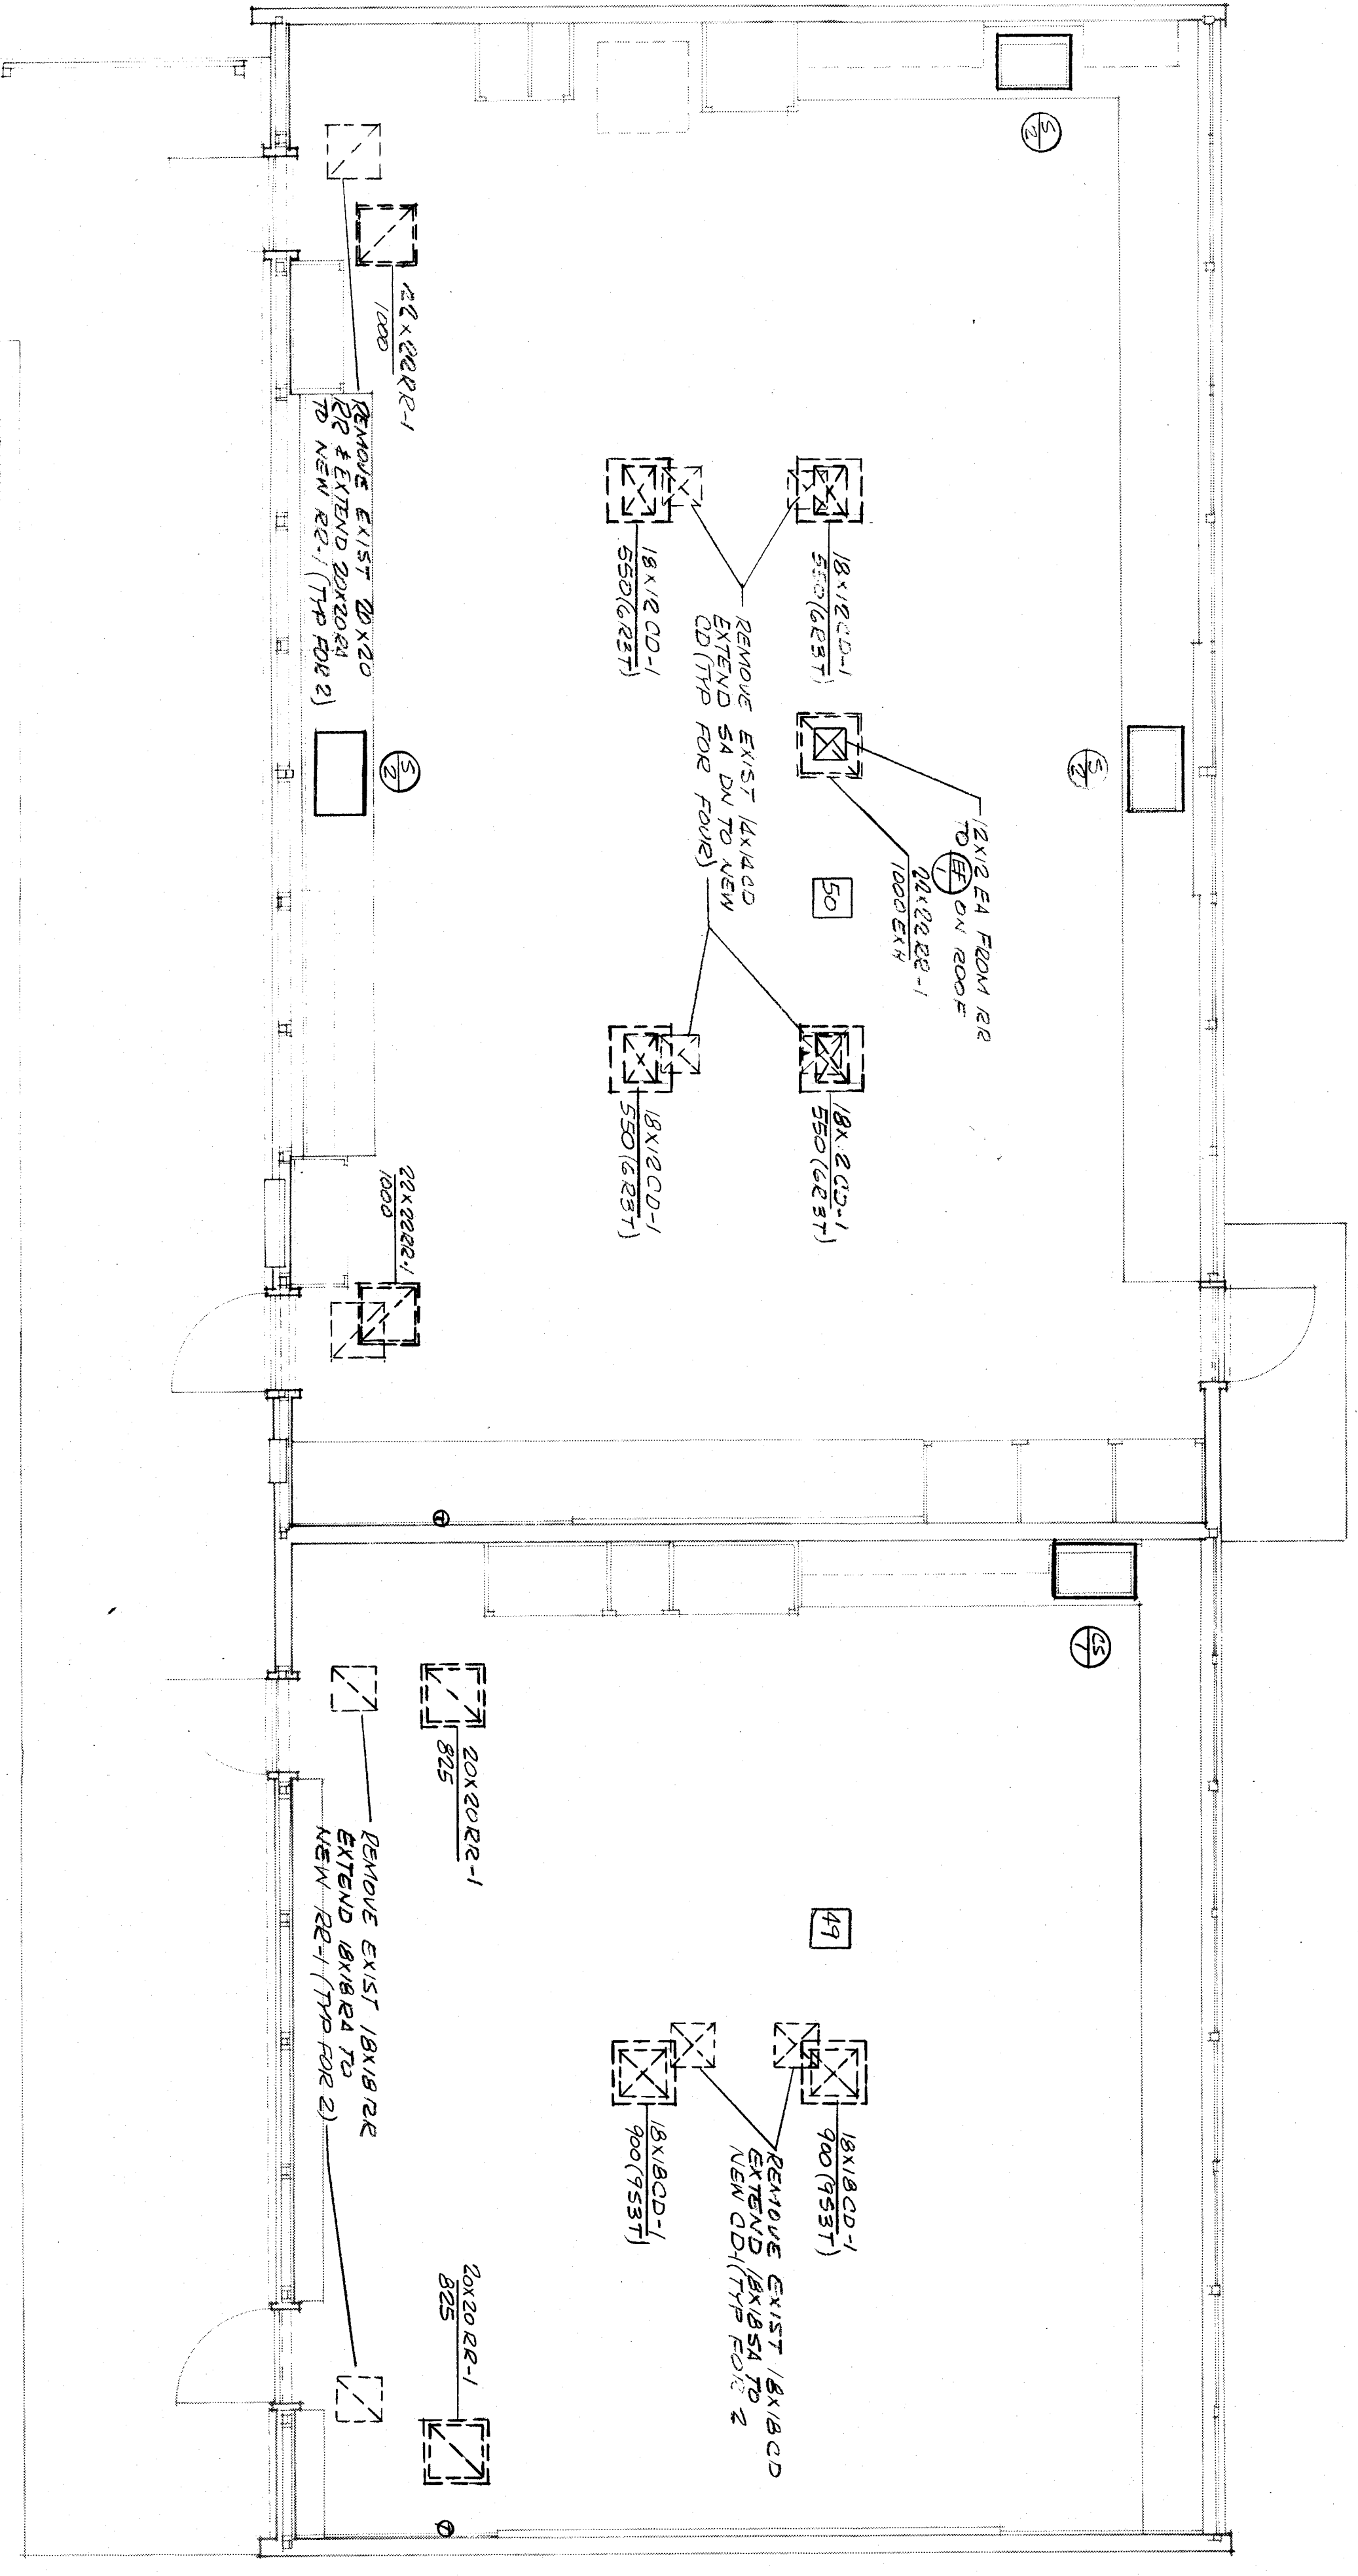

UNIT D PLUMBING & MECHANICAL PLAN 1/4"=1'

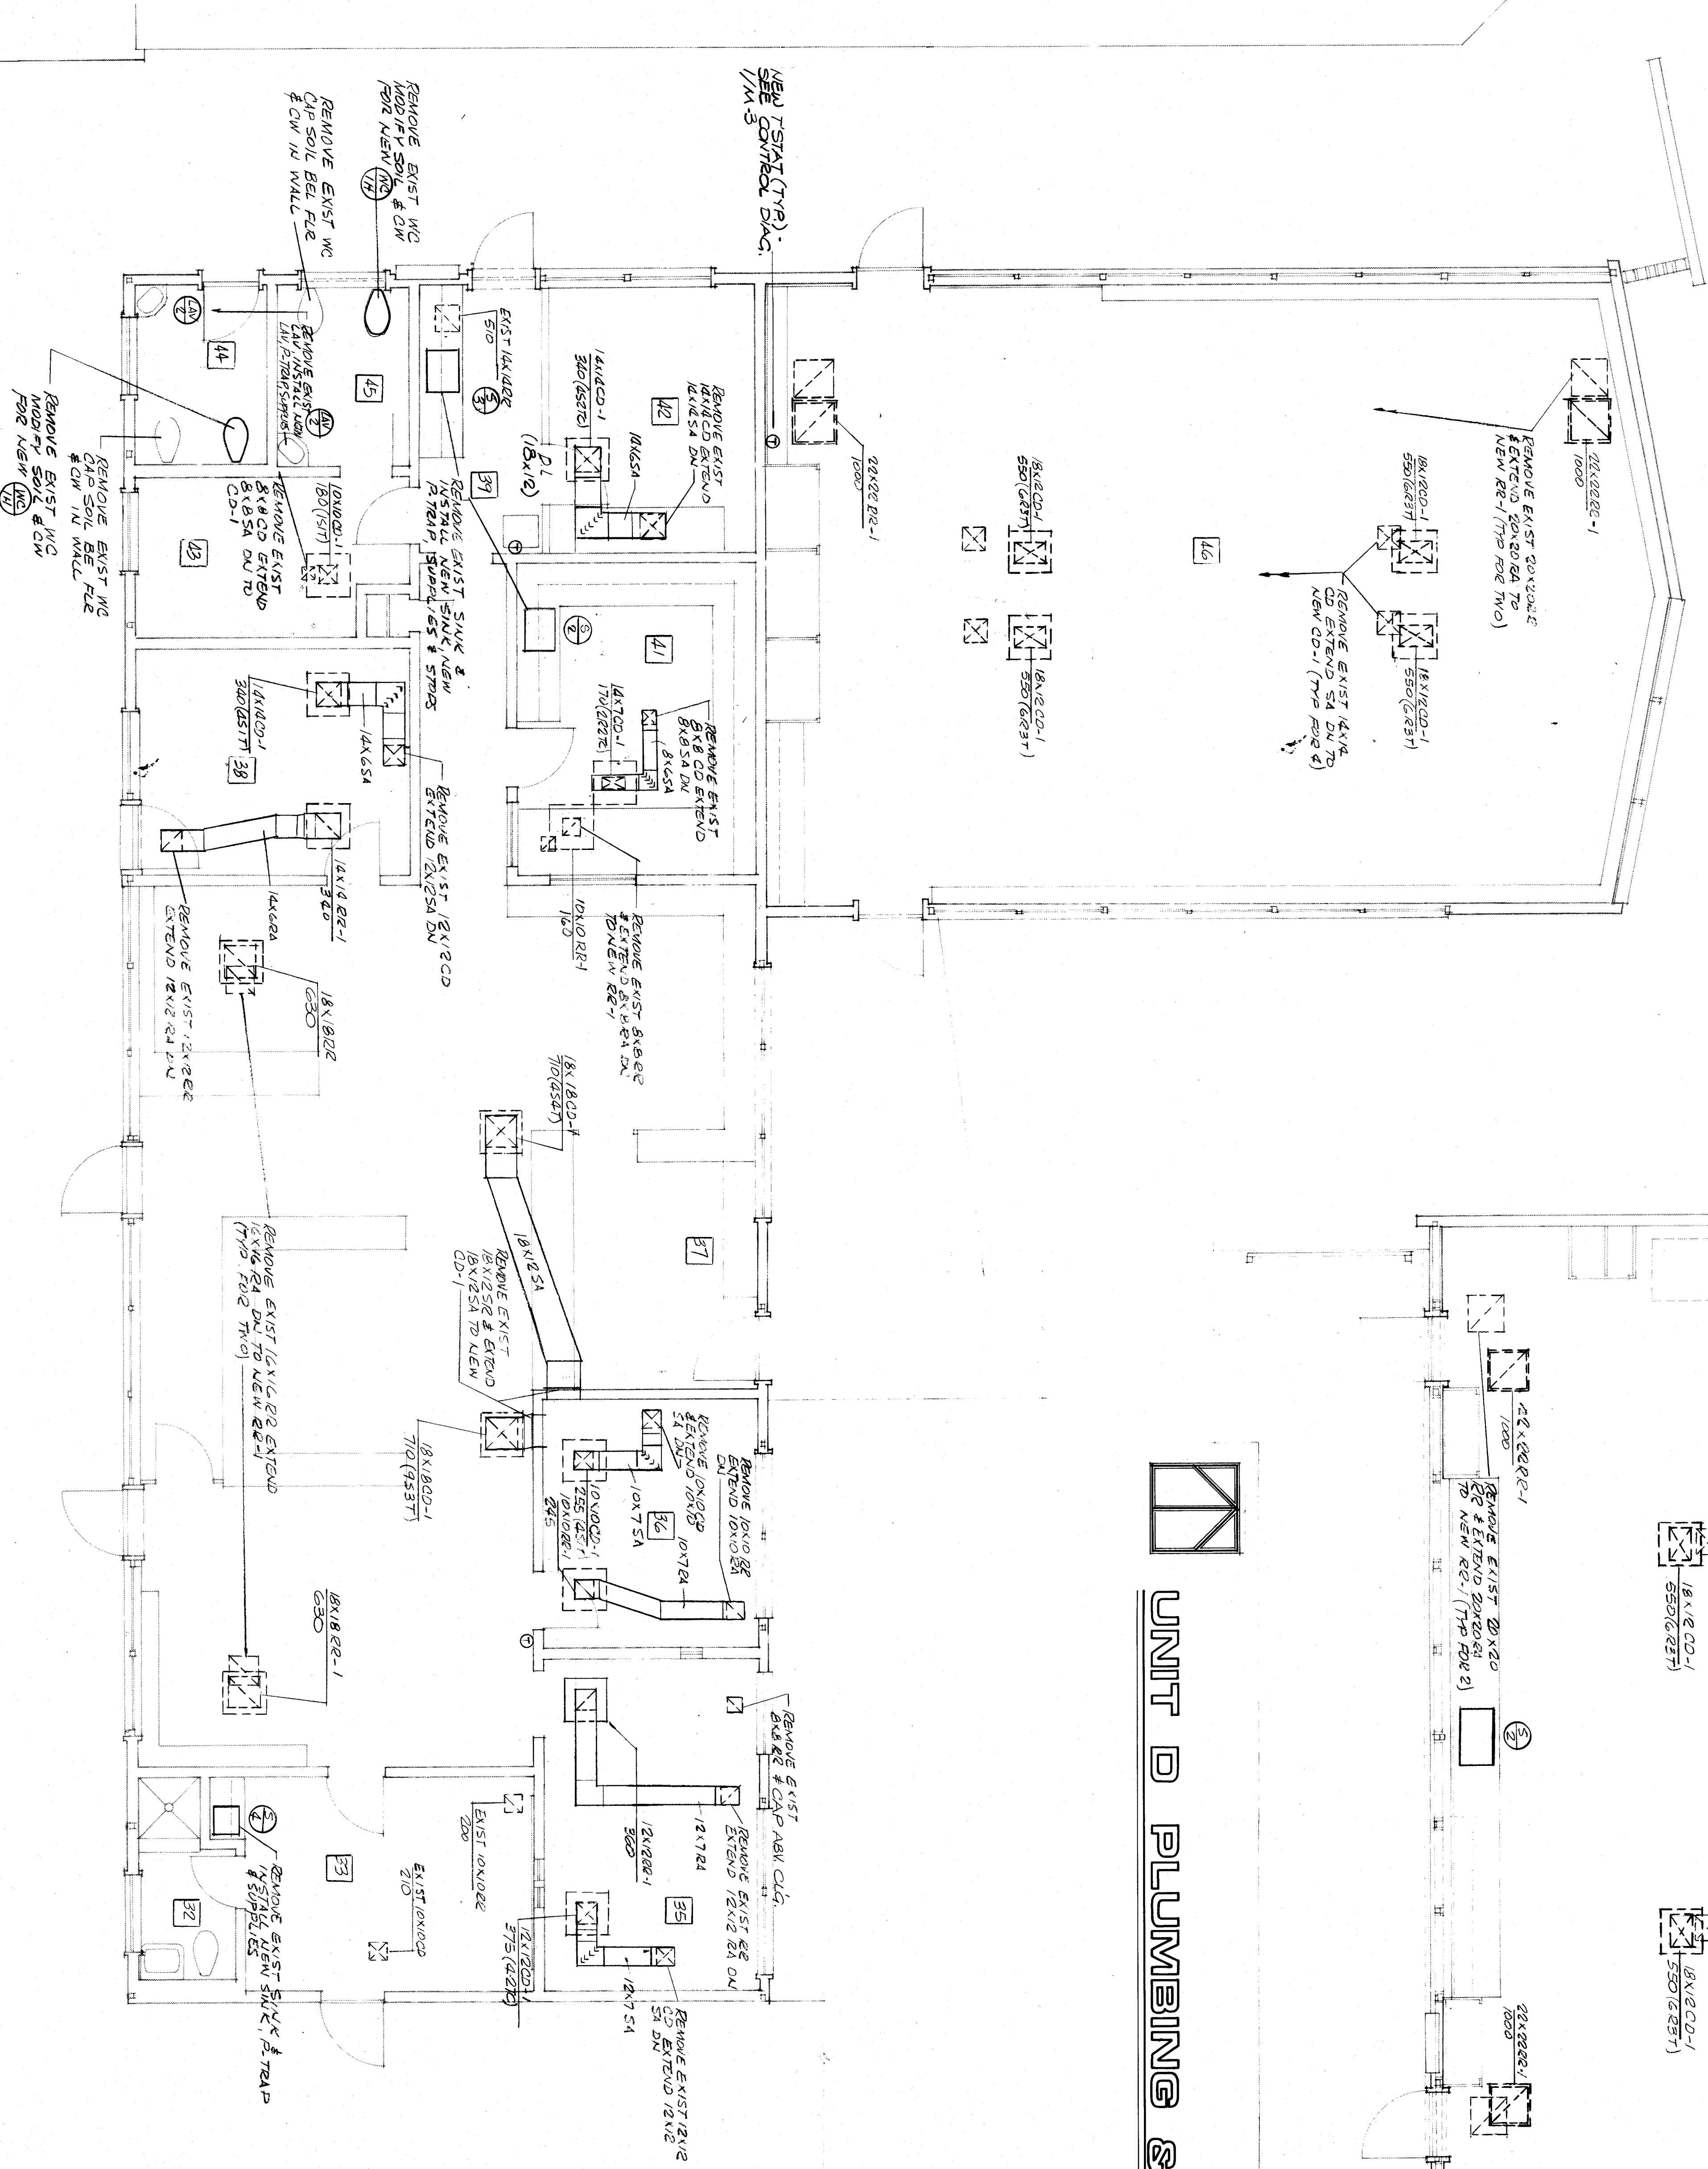

UNIT C PLUMBING & MECHANICAL 1/4"=1'

KERN STREET 1988