



ROBERT F. STUHR ARCHITECT INC.

3121 CALIFORNIA AVE. BAKERSFIELD CA. 93304 (805) 327-1632

EXP- ROBERT F. STUHR AIA C-1610 WILLIAM J. MELBY AIA C-16335 DANNY E. ORDIZ AIA C-14728

TITLE: 2A & 1988 I.P.C.

DATE: 1/15/88

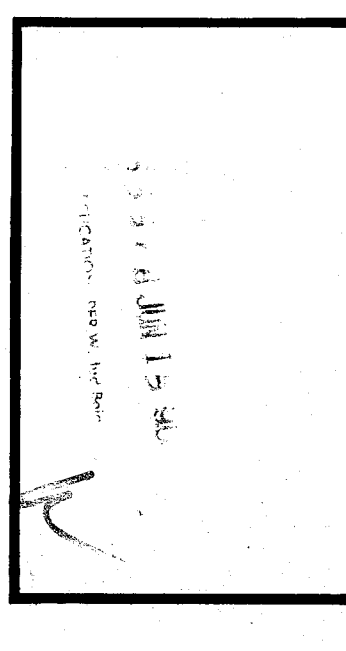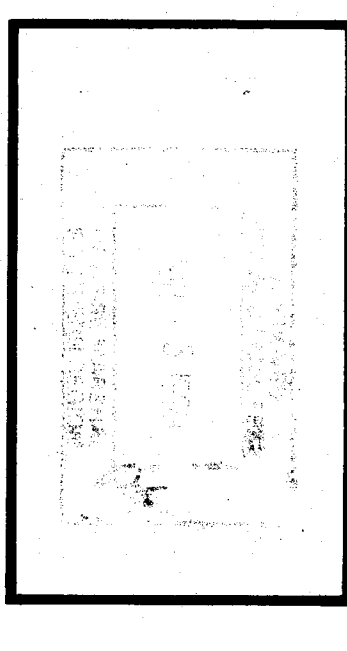

UNIT F & G PLUMBING & MECHANICAL PLAN
VISTA EAST CONTINUATION HIGH SCHOOL 30 YEAR MODERNIZATION
815 EUREKA STREET
KERN HIGH SCHOOL DISTRICT
KERN COUNTY, CALIFORNIA


CARRIE B. TROBERT & ASSOCIATE ARCHITECTS
3109 CALIFORNIA AVENUE, SUITE 200
BAKERSFIELD, CALIFORNIA 93304
CALIFORNIA NO. R. 43480
EXP. 05/01/91

CHECK AND VERIFY ALL DIMENSIONS BEFORE PROCEEDING WITH THE WORK. REPORT DISCREPANCIES TO THE ARCHITECT IMMEDIATELY. ALL SHALL CONFORM TO IBC.

MARK	DATE	REVISIONS
△		
△		
△		
△		


JOB NO. 707
DRAWN: [Signature]
CHECKED: [Signature]
DATE: 6-24-90

OF 4 SHEETS

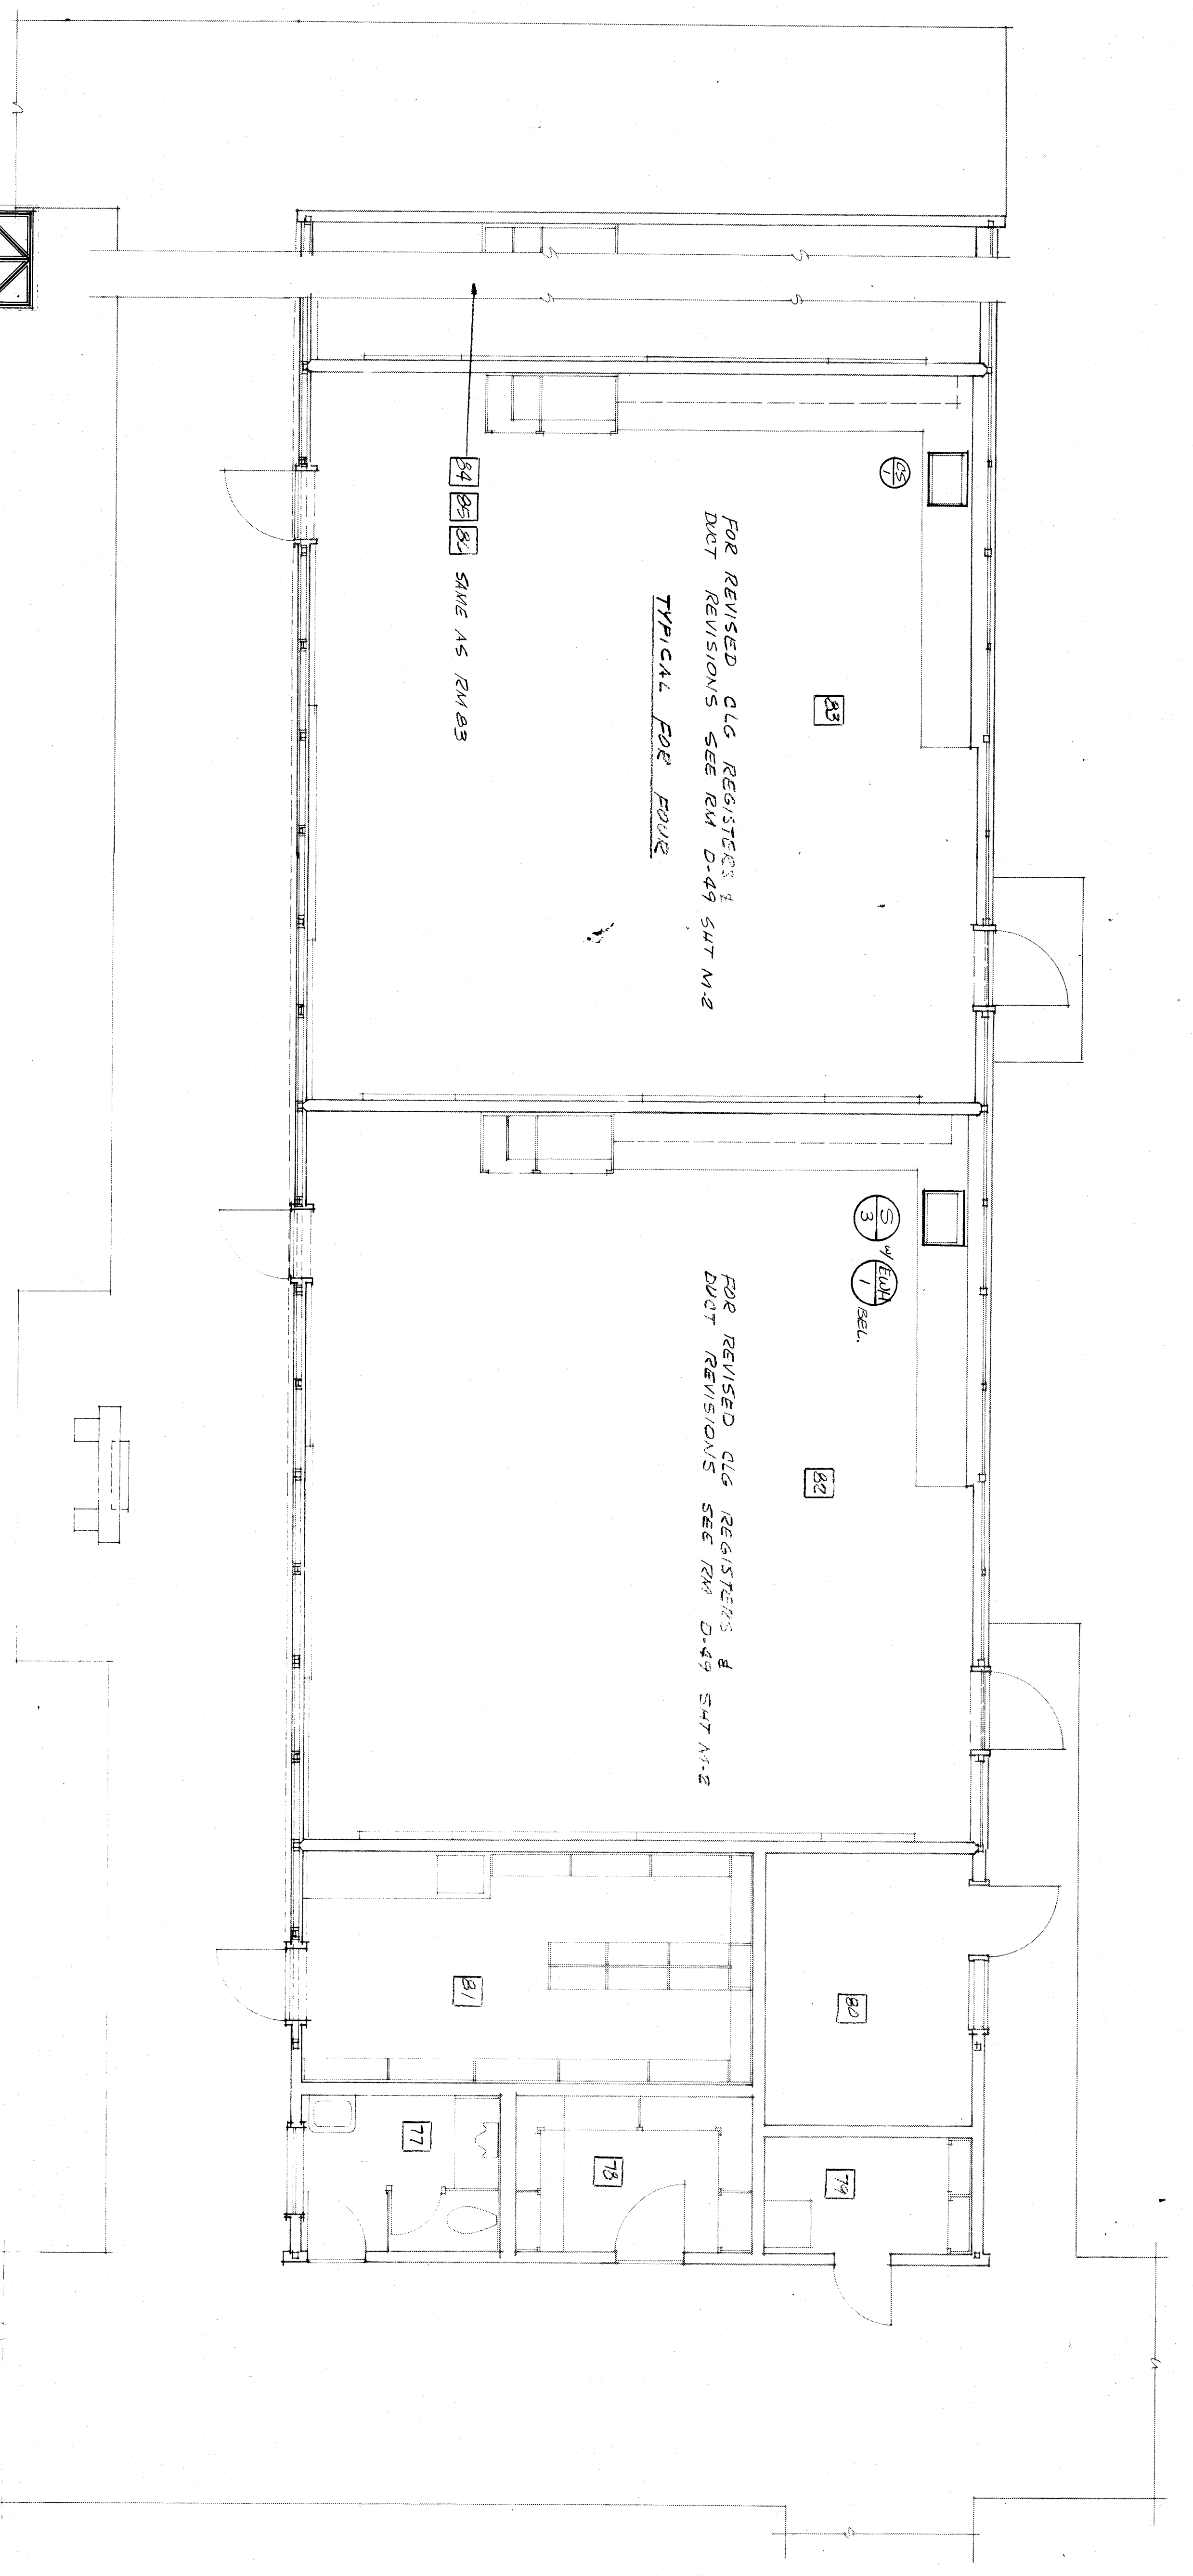

UNIT G PLUMBING & MECHANICAL PLAN

1/4" = 1'-0"

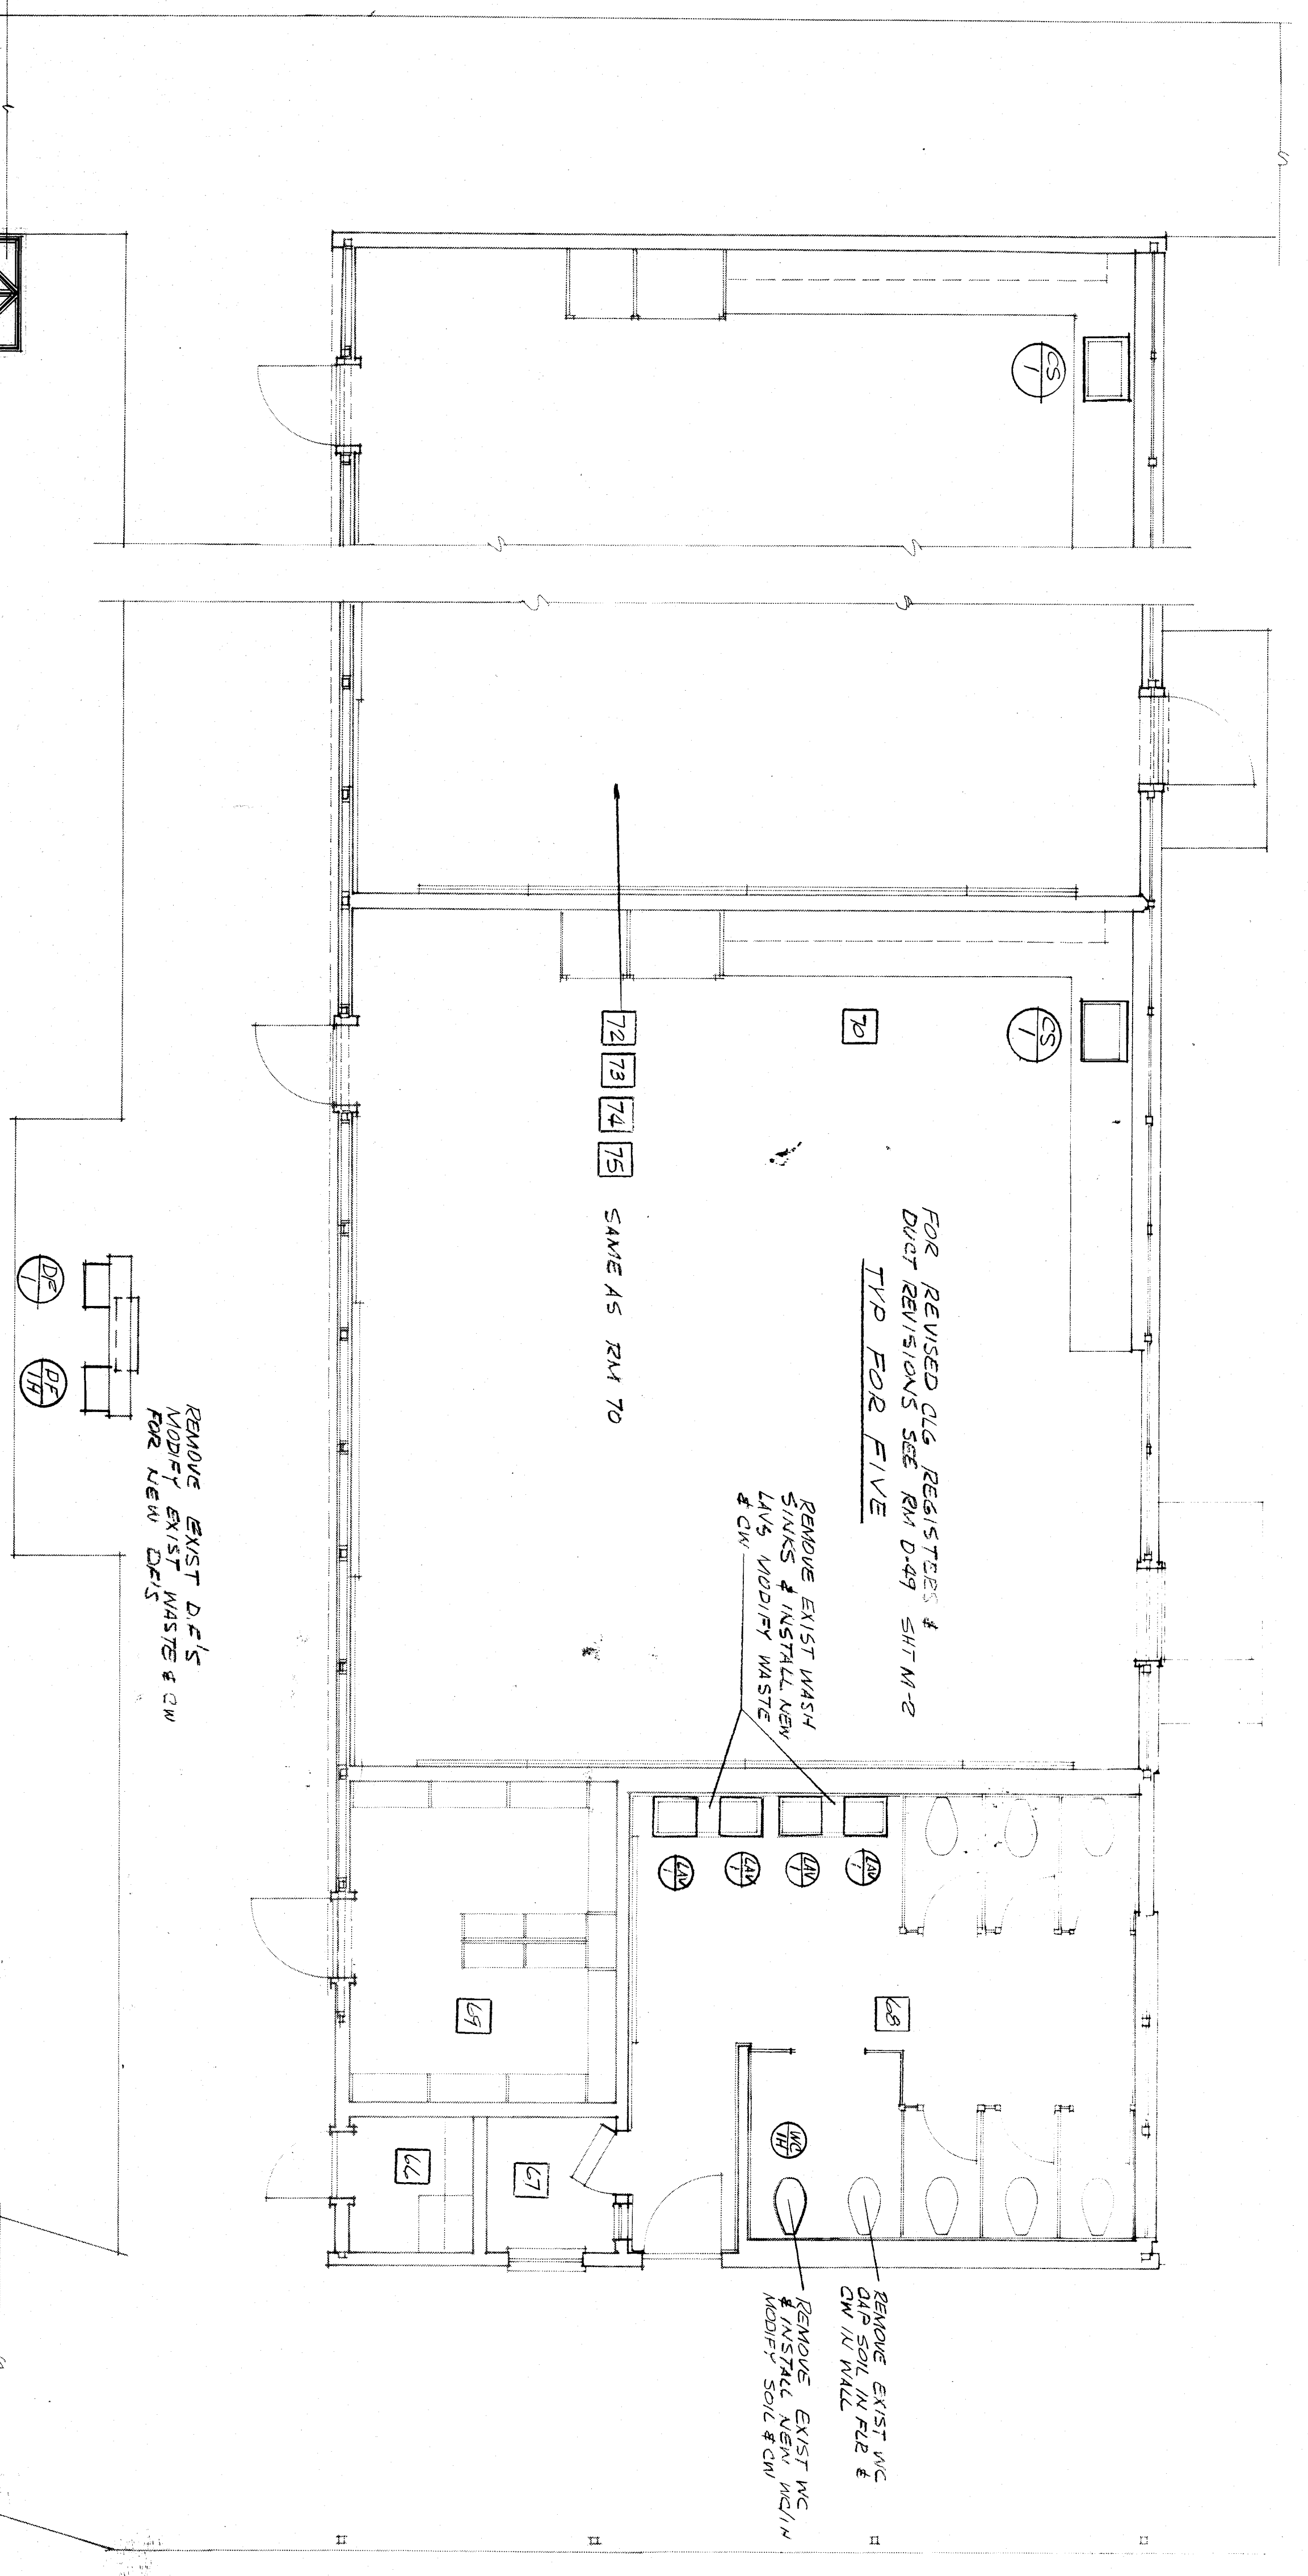

UNIT F PLUMBING & MECHANICAL PLAN

1/4" = 1'-0"